

NOTE:


1. SEE SHEET M-001 FOR LEGEND AND ABBREVIATIONS.

KEYED NOTES:

- ① 12x12 EA UP
- ② 8x6 EA UP
- ③ 14x10 SA UP
- ④ 10x6 EA UP



ARCHITECTURE ENGINEERING PLANNING
 SWRT
 144 Fore Street/P.O. Box 618
 Portland, Maine 04104
 tel. (207) 772-3846
 fax. (207) 772-1070

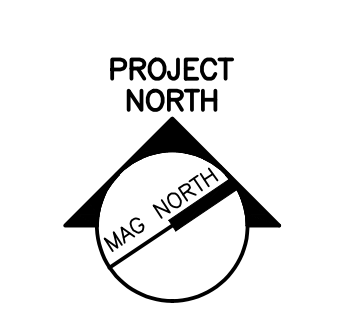

PROJECT TITLE:
**MAINE TURNPIKE AUTHORITY
 ADMINISTRATION BUILDING**
 PORTLAND, MAINE

CURRENT ISSUE STATUS:
**ISSUED FOR BIDDING/CONSTRUCTION
 7-9-07**


REV	DESCRIPTION	DATE
0	BIDDING/CONSTRUCTION	7-9-07

GRAPHIC SCALE:

SCALE: 1/8"=1'-0"
 PROJECT MANAGER: SLB
 JC/DRAWN BY: TCM/BGG
 A/E OF RECORD: RWW
 CAD FILE: MH102-06016
 PROJECT NO: 06016
 DATE: 7-9-07

SHEET TITLE:
**SECOND FLOOR
 HVAC DUCTWORK
 PLAN**

SHEET No.
MH102

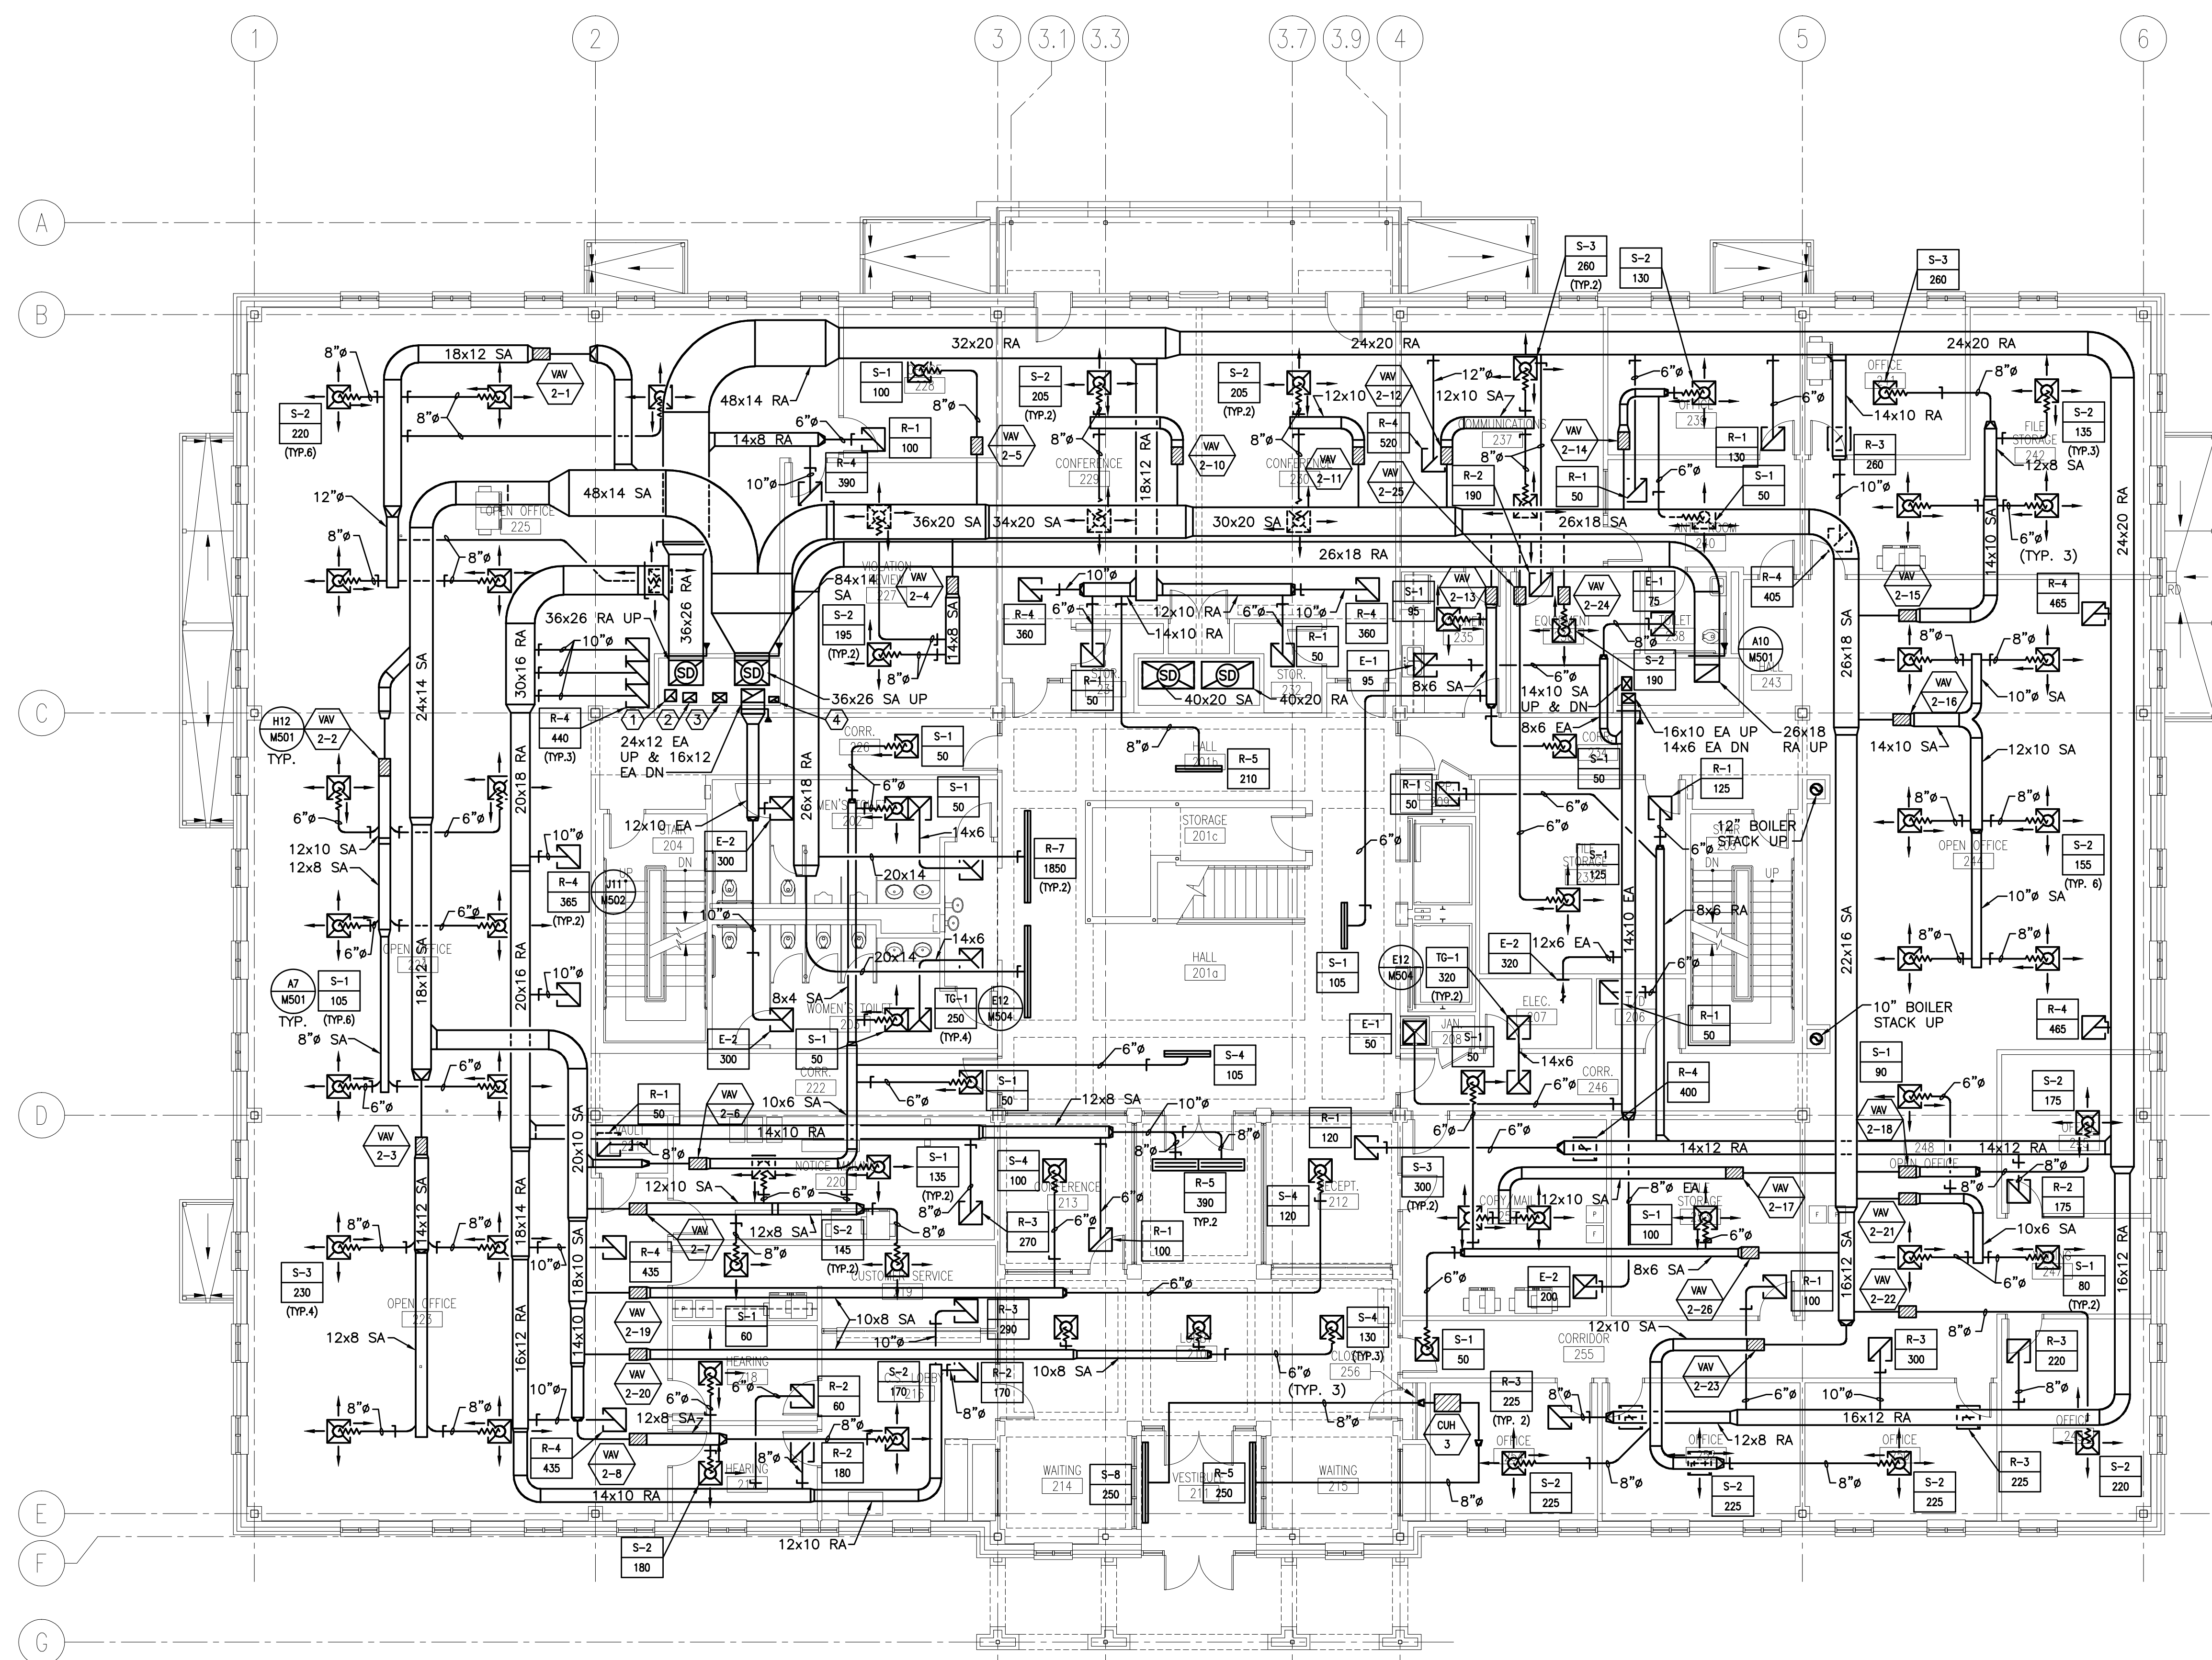

A1 SECOND FLOOR PLAN

1/8" = 1'-0"