


NOTE:

- SEE SHEET M-001 FOR LEGEND AND ABBREVIATIONS.
- ALL PIPING RUNOUTS TO BE 3/4" UNLESS NOTED OTHERWISE.

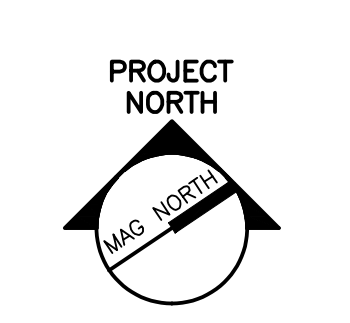

PROJECT TITLE:
**MAINE TURNPIKE AUTHORITY
 ADMINISTRATION BUILDING**
 PORTLAND, MAINE

CURRENT ISSUE STATUS:
**ISSUED FOR BIDDING/CONSTRUCTION
 7-9-07**

REV	DESCRIPTION	DATE
0	BIDDING/CONSTRUCTION	7-9-07


GRAPHIC SCALE:
 0" 1"

SCALE: 1/8" = 1'-0"

PROJECT MANAGER: SLB
 JC/DRAWN BY: TCM/BGG
 A/E OF RECORD: RMW
 CAD FILE: MP102-06016
 PROJECT NO: 06016
 DATE: 7-9-07

SHEET TITLE:
**SECOND FLOOR
 HVAC PIPING
 PLAN**

SHEET No.
MP102

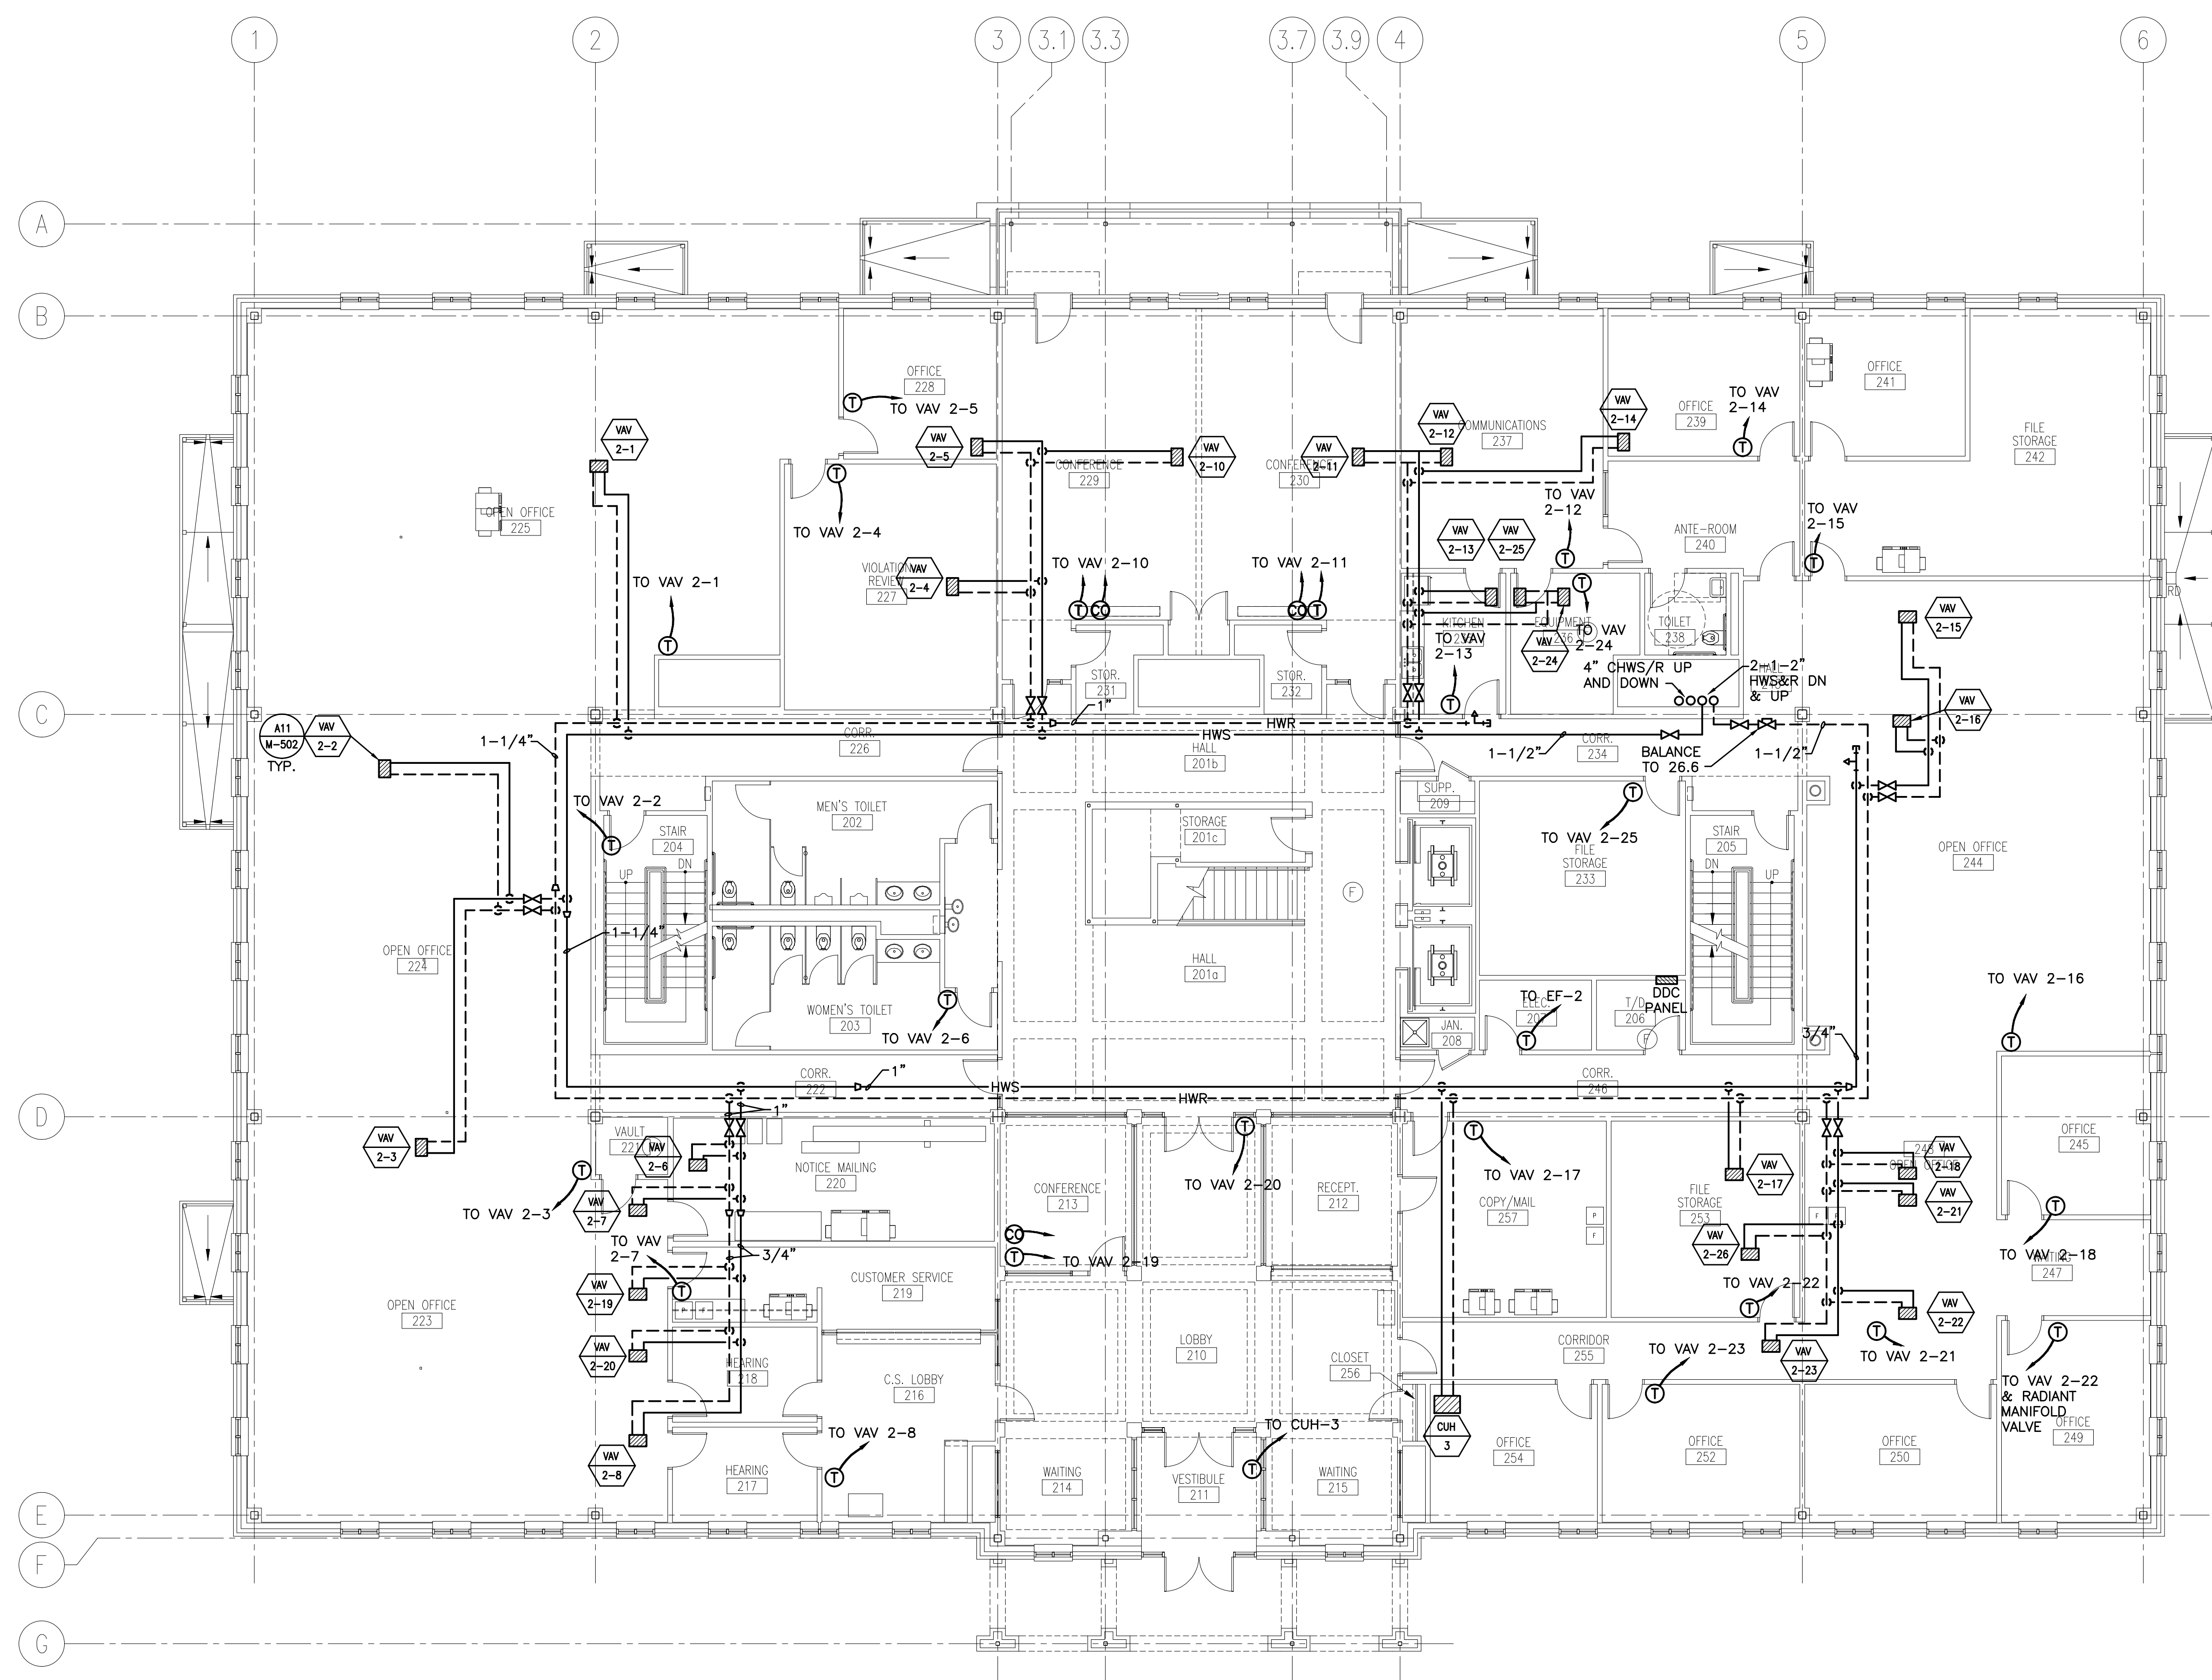

A1 SECOND FLOOR PLAN

1/8" = 1'-0"