

NOTE:

1. SEE SHEET M-001 FOR LEGEND AND ABBREVIATIONS.


2. ALL PIPING RUNOUT TO BE 3/4" UNLESS NOTED OTHERWISE.

KEYED NOTES:

① P-5



ARCHITECTURE ENGINEERING PLANNING
SART
144 Fore Street/P.O. Box 618
Portland, Maine 04104
tel. (207) 772-3846
fax. (207) 772-1070

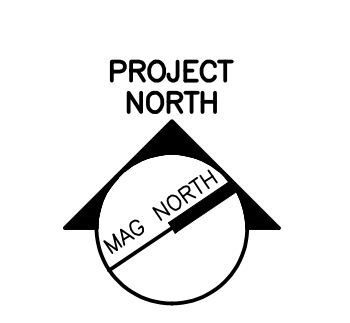

PROJECT TITLE:
**MAINE TURNPIKE AUTHORITY
ADMINISTRATION BUILDING**
PORTLAND, MAINE

CURRENT ISSUE STATUS:
ISSUED FOR BIDDING/CONSTRUCTION
7-9-07

REV	DESCRIPTION	DATE
0	BIDDING/CONSTRUCTION	7-9-07


GRAPHIC SCALE:
0" 1"

SCALE: 1/8"=1'-0"

PROJECT MANAGER: SLB
JC/DRAWN BY: TCM/BGG
A/E OF RECORD: RMW
CAD FILE: MP103-06016
PROJECT NO: 06016
DATE: 7-9-07

SHEET TITLE:
**THIRD FLOOR
HVAC PIPING
PLAN**

SHEET No.
MP103

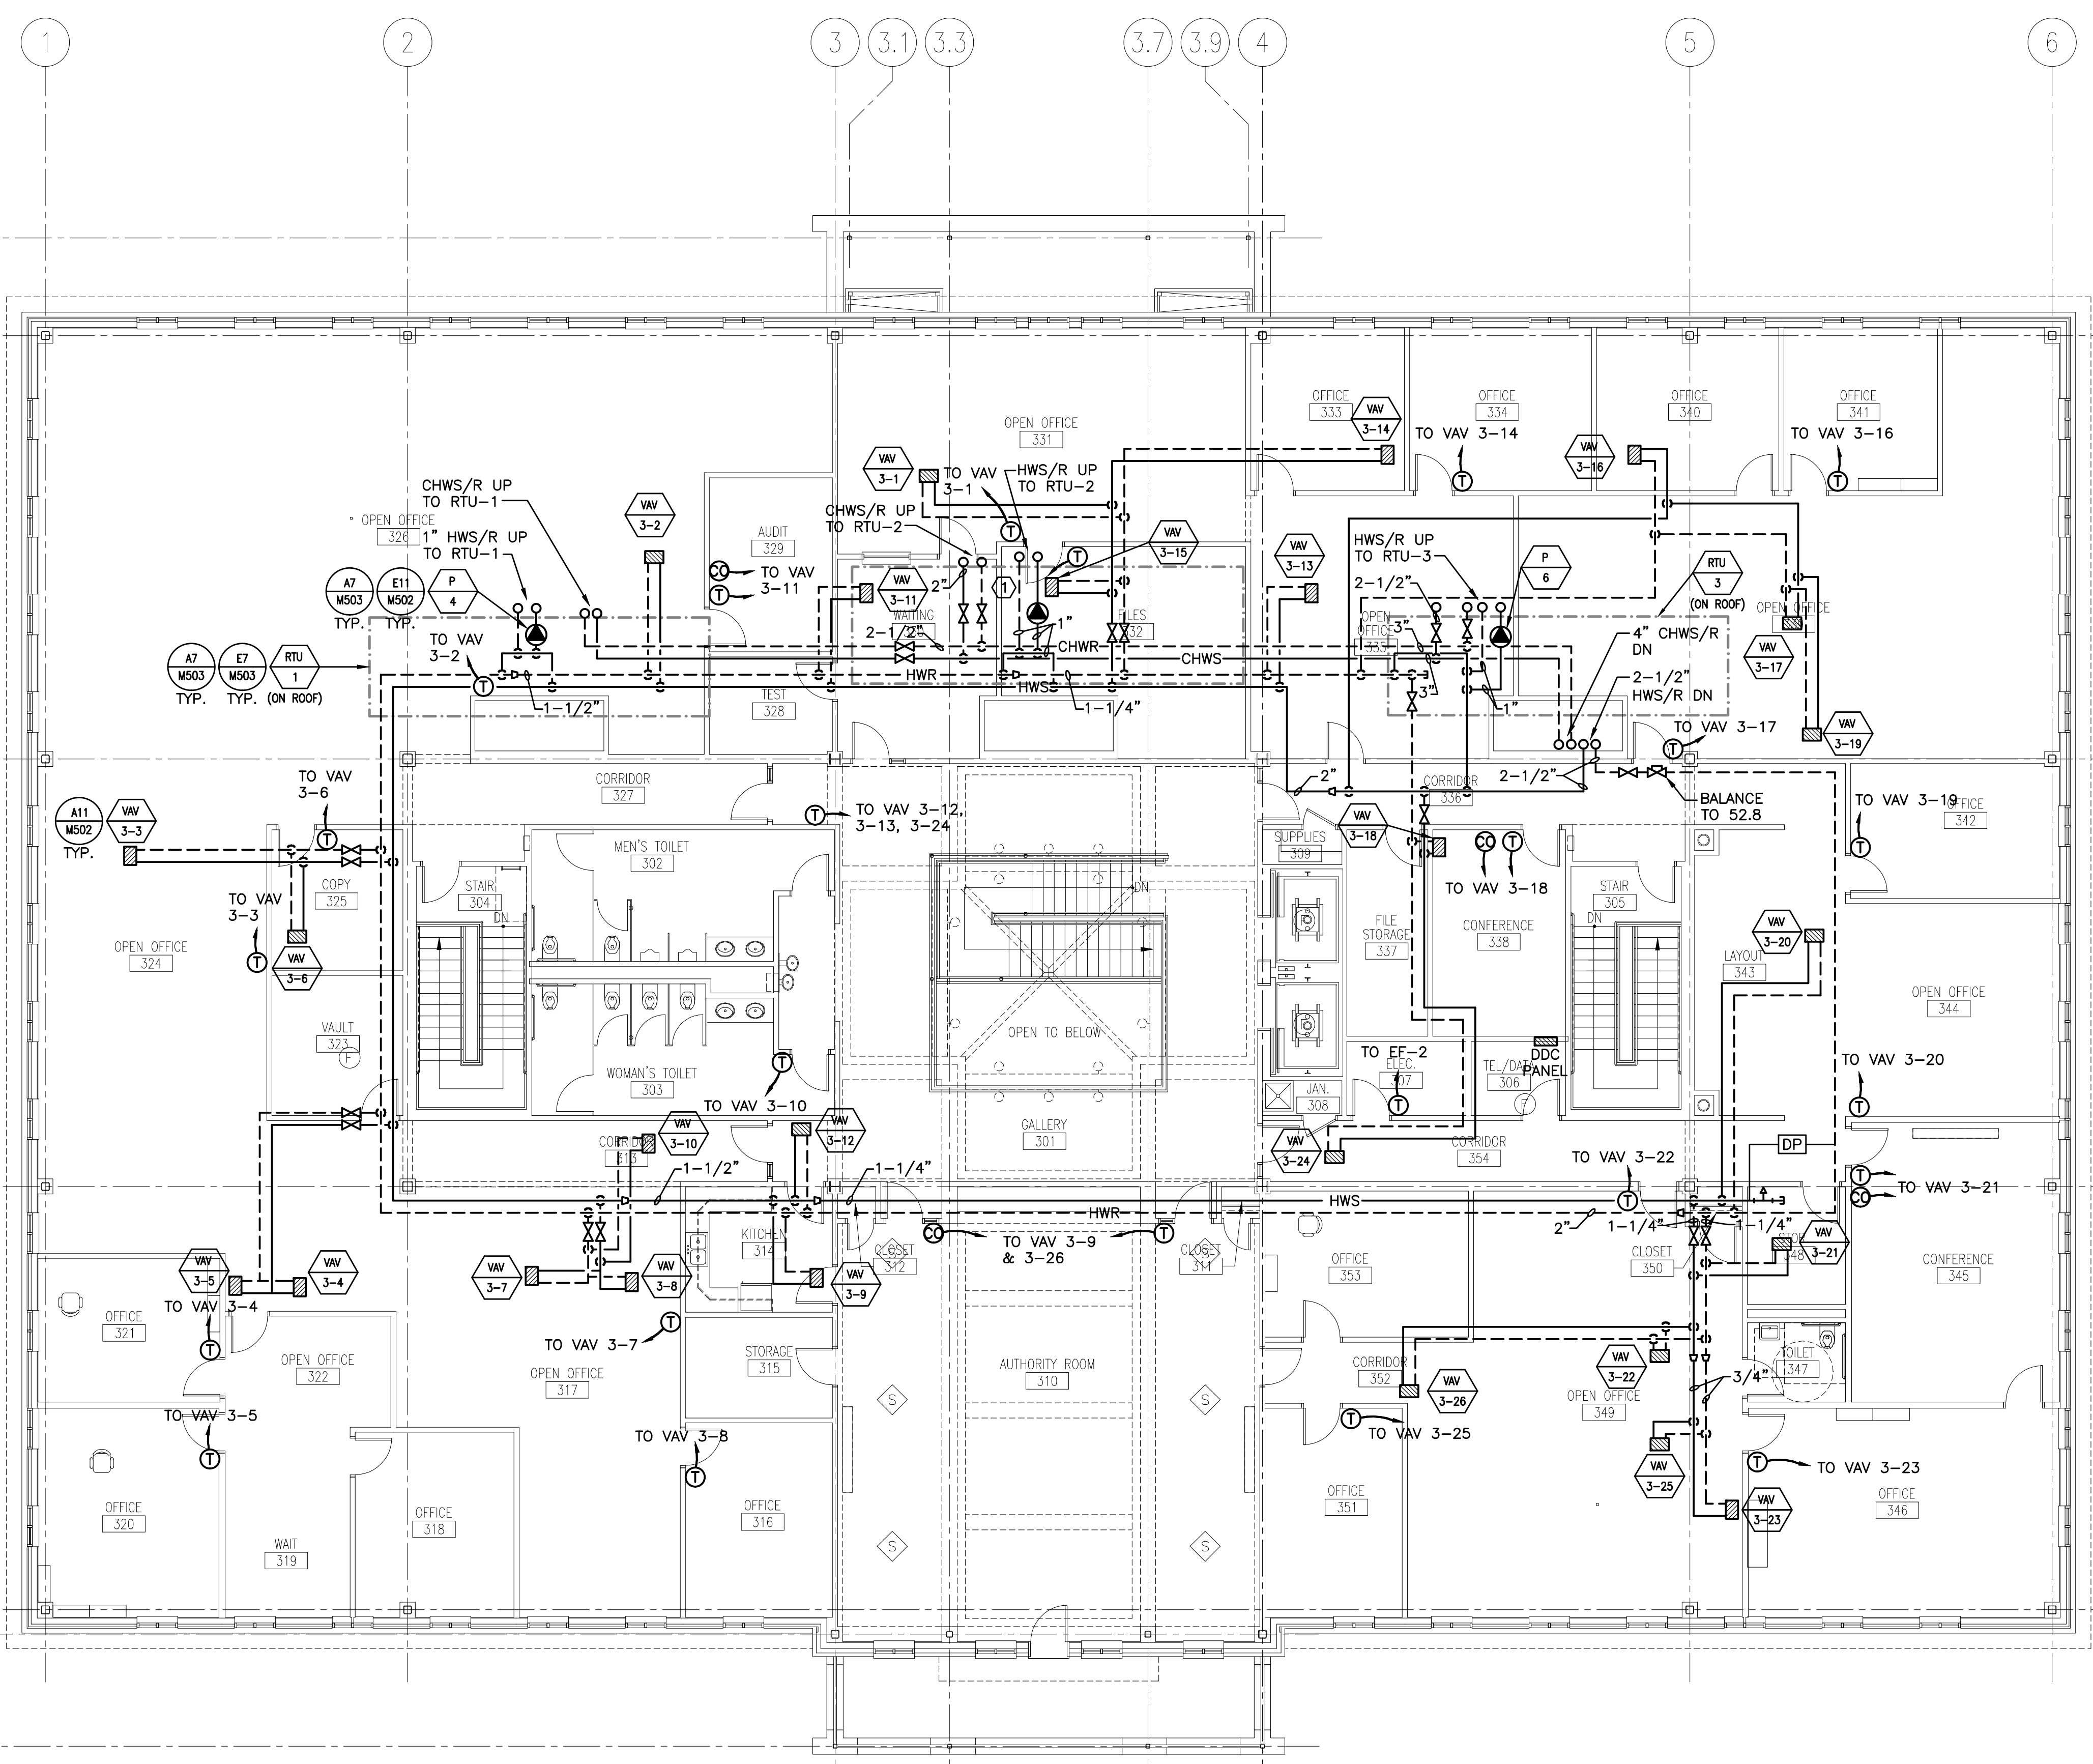

A1 THIRD FLOOR PLAN

1/8" = 1'-0"