



5 Milk Street
 Portland, Maine 04101
 207 774 4811
 www.wintonscott.com



RANSOM
 Consulting, Inc.

Civil Engineering:
 RANSOM CONSULTING, INC.
 400 Commercial Street,
 Suite 404
 Portland, ME 04101
 T. 207.772.2891

Electrical Engineering:
 SWIFT CURRENT ENGINEERING
 Royal River Center, Unit 4B
 10 Forest Falls Drive
 Yarmouth, ME 04096
 T. 207.847.9280

City of
 Portland
 Public Services
 Department:

Water
 Resources
 Division

Facility at
 109 District Rd,
 Portland


PERMIT SET

OCTOBER 20, 2015


UTILITY PLAN

Scale: As Noted

C-1

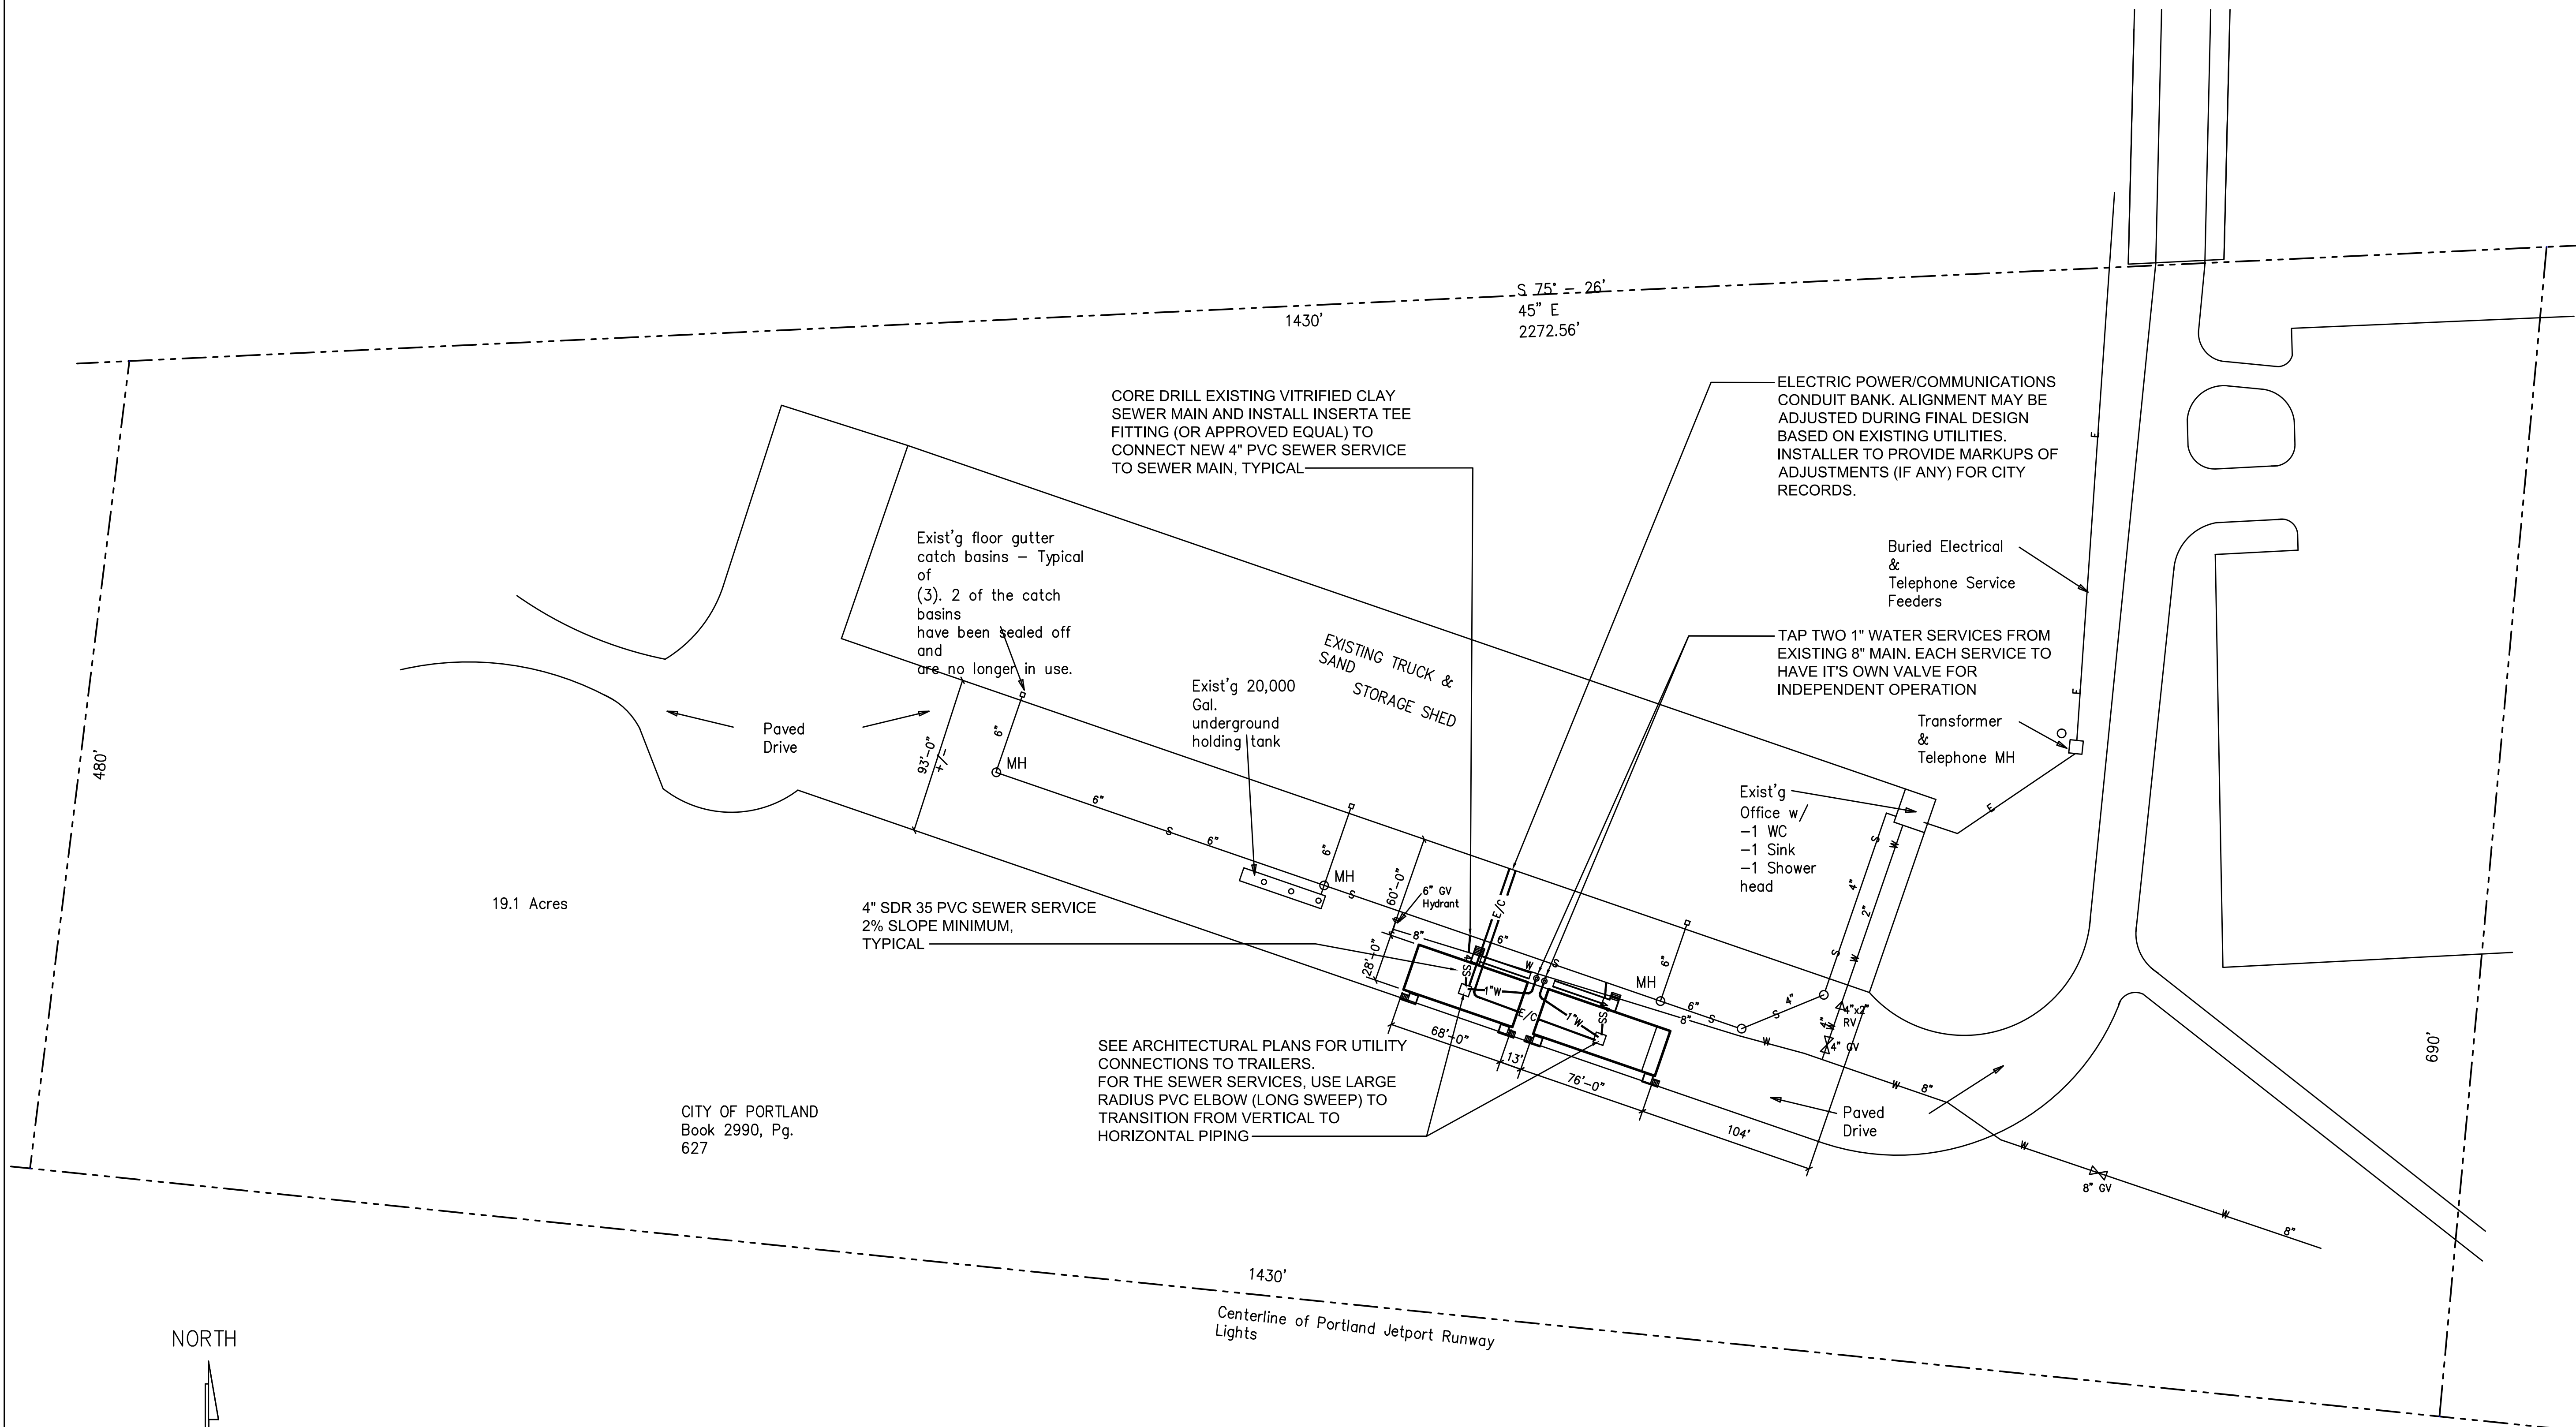

CITY OF PORTLAND
 Book 2990, Pg.
 627

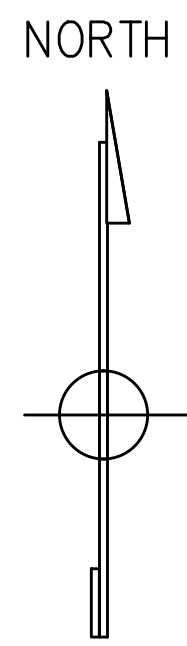

ISSUED FOR
 PERMITTING ONLY

PROPOSED SITE
 PLAN

