

EQUIPMENT SCHEDULE


- PL-1 AMERICAN STANDARD MURRO UNIVERSAL DESIGN WALL-HUNG LAVATORY WITH EVERCLEAN (INCLUDE SHROUD)
- PL-2 CHICAGO FAUCETS MODEL# 895-317RGD1ABCP
- PL-3 AMERICAN STANDARD RIGHT WIDTH FloWise ELONGATED RIGHT HEIGHT FLUSHOMETER TOILET
- PL-4 AMERICAN STANDARD MADERA FloWise 16-1/2" HEIGHT ELONGATED FLUSHOMETER TOILET
- PL-5 AMERICAN STANDARD WASHBROOK FloWise UNIVERSAL URINAL
- PL-6 FREEDOM SHOWERS MODEL# APFQ3637BF3P
ACCESSORIES:
FOLDING SHOWER SEAT
HORIZONTAL & VERTICAL GRAB BARS
SHOWER ROD & CURTAIN
CAULKLESS DRAIN
PRESSURE BALANCE VALVE WITH HAND-HELD SHOWER AND SLIDE BAR
- PL-7 ELKAY SCRUB SINK MODEL# EWSF390263 (SINK ONLY)
- PL-8 ELKAY TWO STATION WALL MOUNT WATER COOLER MODEL# EZTL8C
- PL-9 ELKAY GOOSENECK FAUCET MODEL# LK500GN08T4
- WA-1 BOBRICK B-5806, 42" S.S. GRAB BAR
- WA-2 BOBRICK B-5806, 36" S.S. GRAB BAR
- WA-3 BOBRICK TILT MIRROR WITH S.S. FRAME (18" x 30") B-293 1830
- WA-4 SCRANTON PRODUCTS HINY HIDERS TOILET PARTITIONS FLOOR MOUNTED, OVERHEAD BRACED COLOR: STAINLESS PATTERN: HAMMERED
- L-1 SCRANTON PRODUCTS TUFFTEC LOCKERS, 18 x 18 x 72 COLOR: TBD HORIZONTAL VENTS SLOPED TOPS 4" BASE
- L-2 SCRANTON PRODUCTS TUFFTEC BENCH COLOR: TBD (3) STEEL PEDESTALS
- A-1 SLIMLINE WALL MOUNTED AIR CONDITIONER
- F.E. WALL MOUNTED FIRE EXTINGUISHER

Ecomaine - Renovation of Office/Break Area
64 Blueberry Road, Portland, ME 04102

SHEET
A103

JOB # 12122
DATE 05/06/13
SCALE 1/4" = 1'-0"

TITLE
EQUIPMENT PLAN

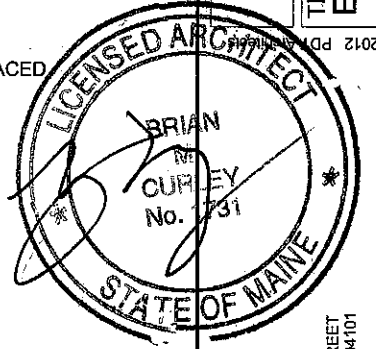


ARCHITECTURE
INTERIOR DESIGN
PLANNING

49 DARTMOUTH STREET
PORTLAND, MAINE 04101
www.pdlarchts.com



ELECTRICAL LEGEND

- DUPLEX OUTLET
- QUAD OUTLET
- GFCI OUTLET
- TEL/DATA OUTLET

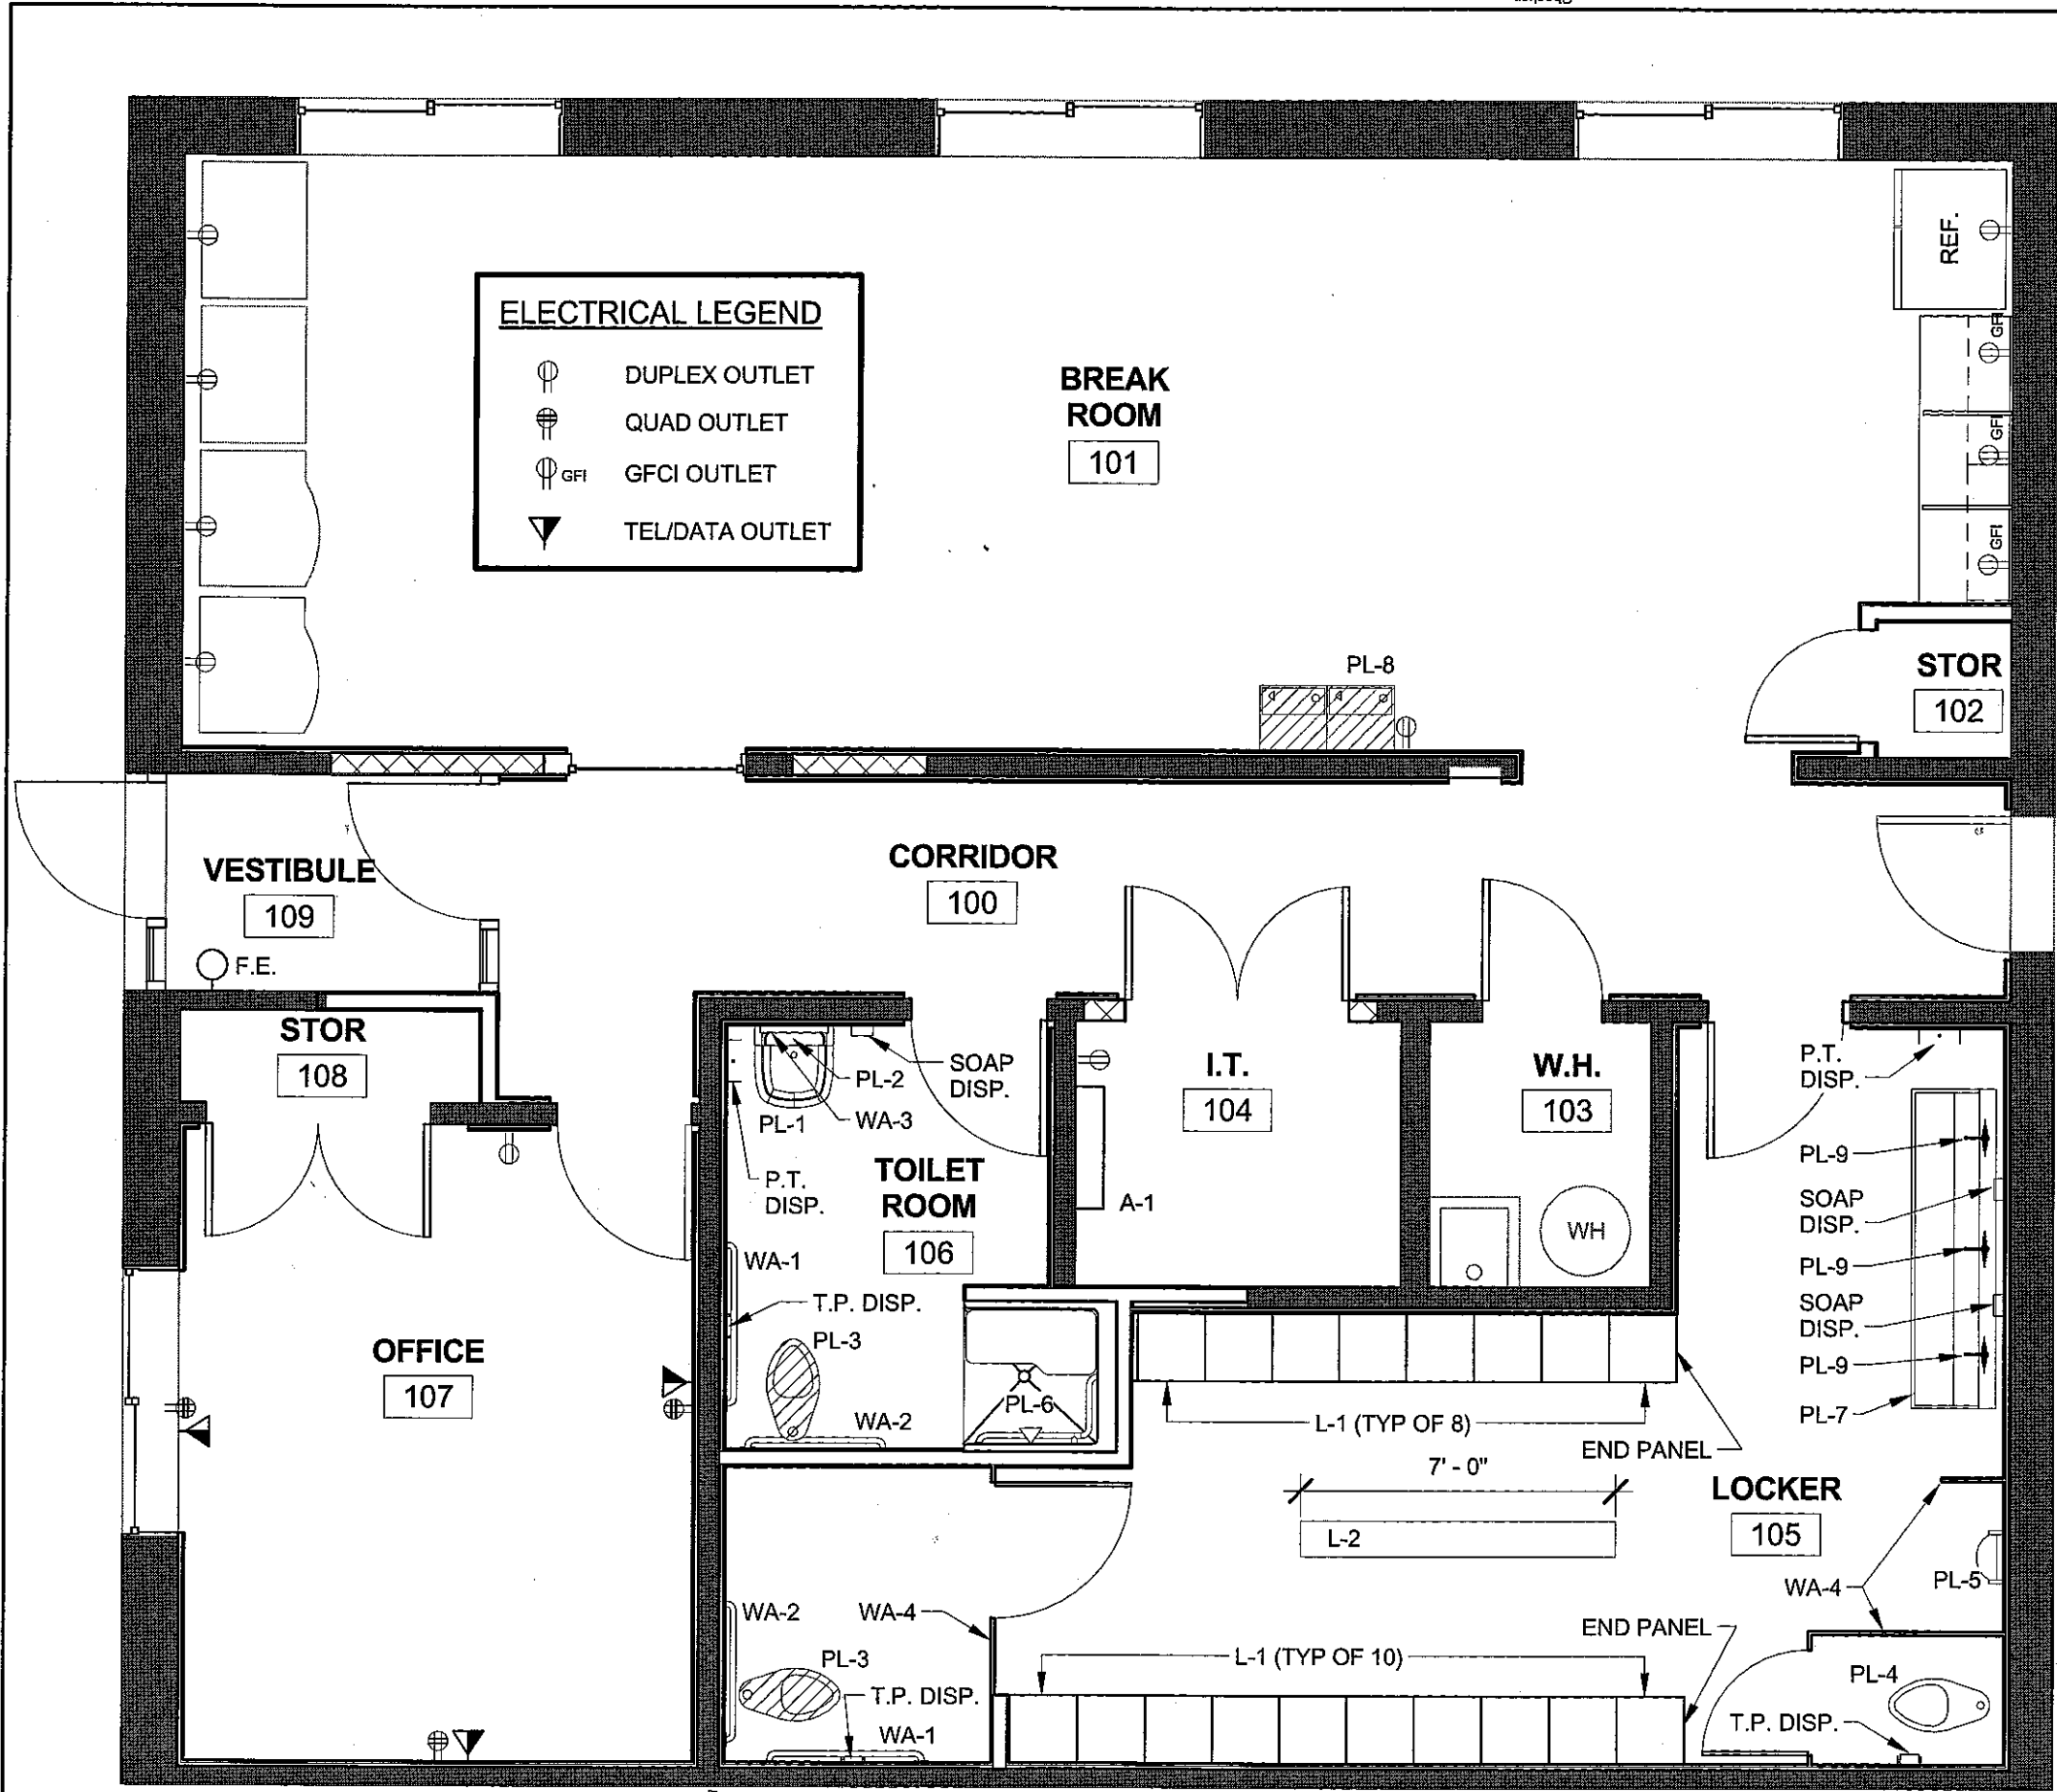

1 EQUIPMENT PLAN
1/4" = 1'-0"