


COPYRIGHT 2016 © DIRIGO ARCHITECTURAL ENGINEERING LLC. ALL RIGHTS RESERVED. NO REPRODUCTION WITHOUT PRIOR WRITTEN PERMISSION

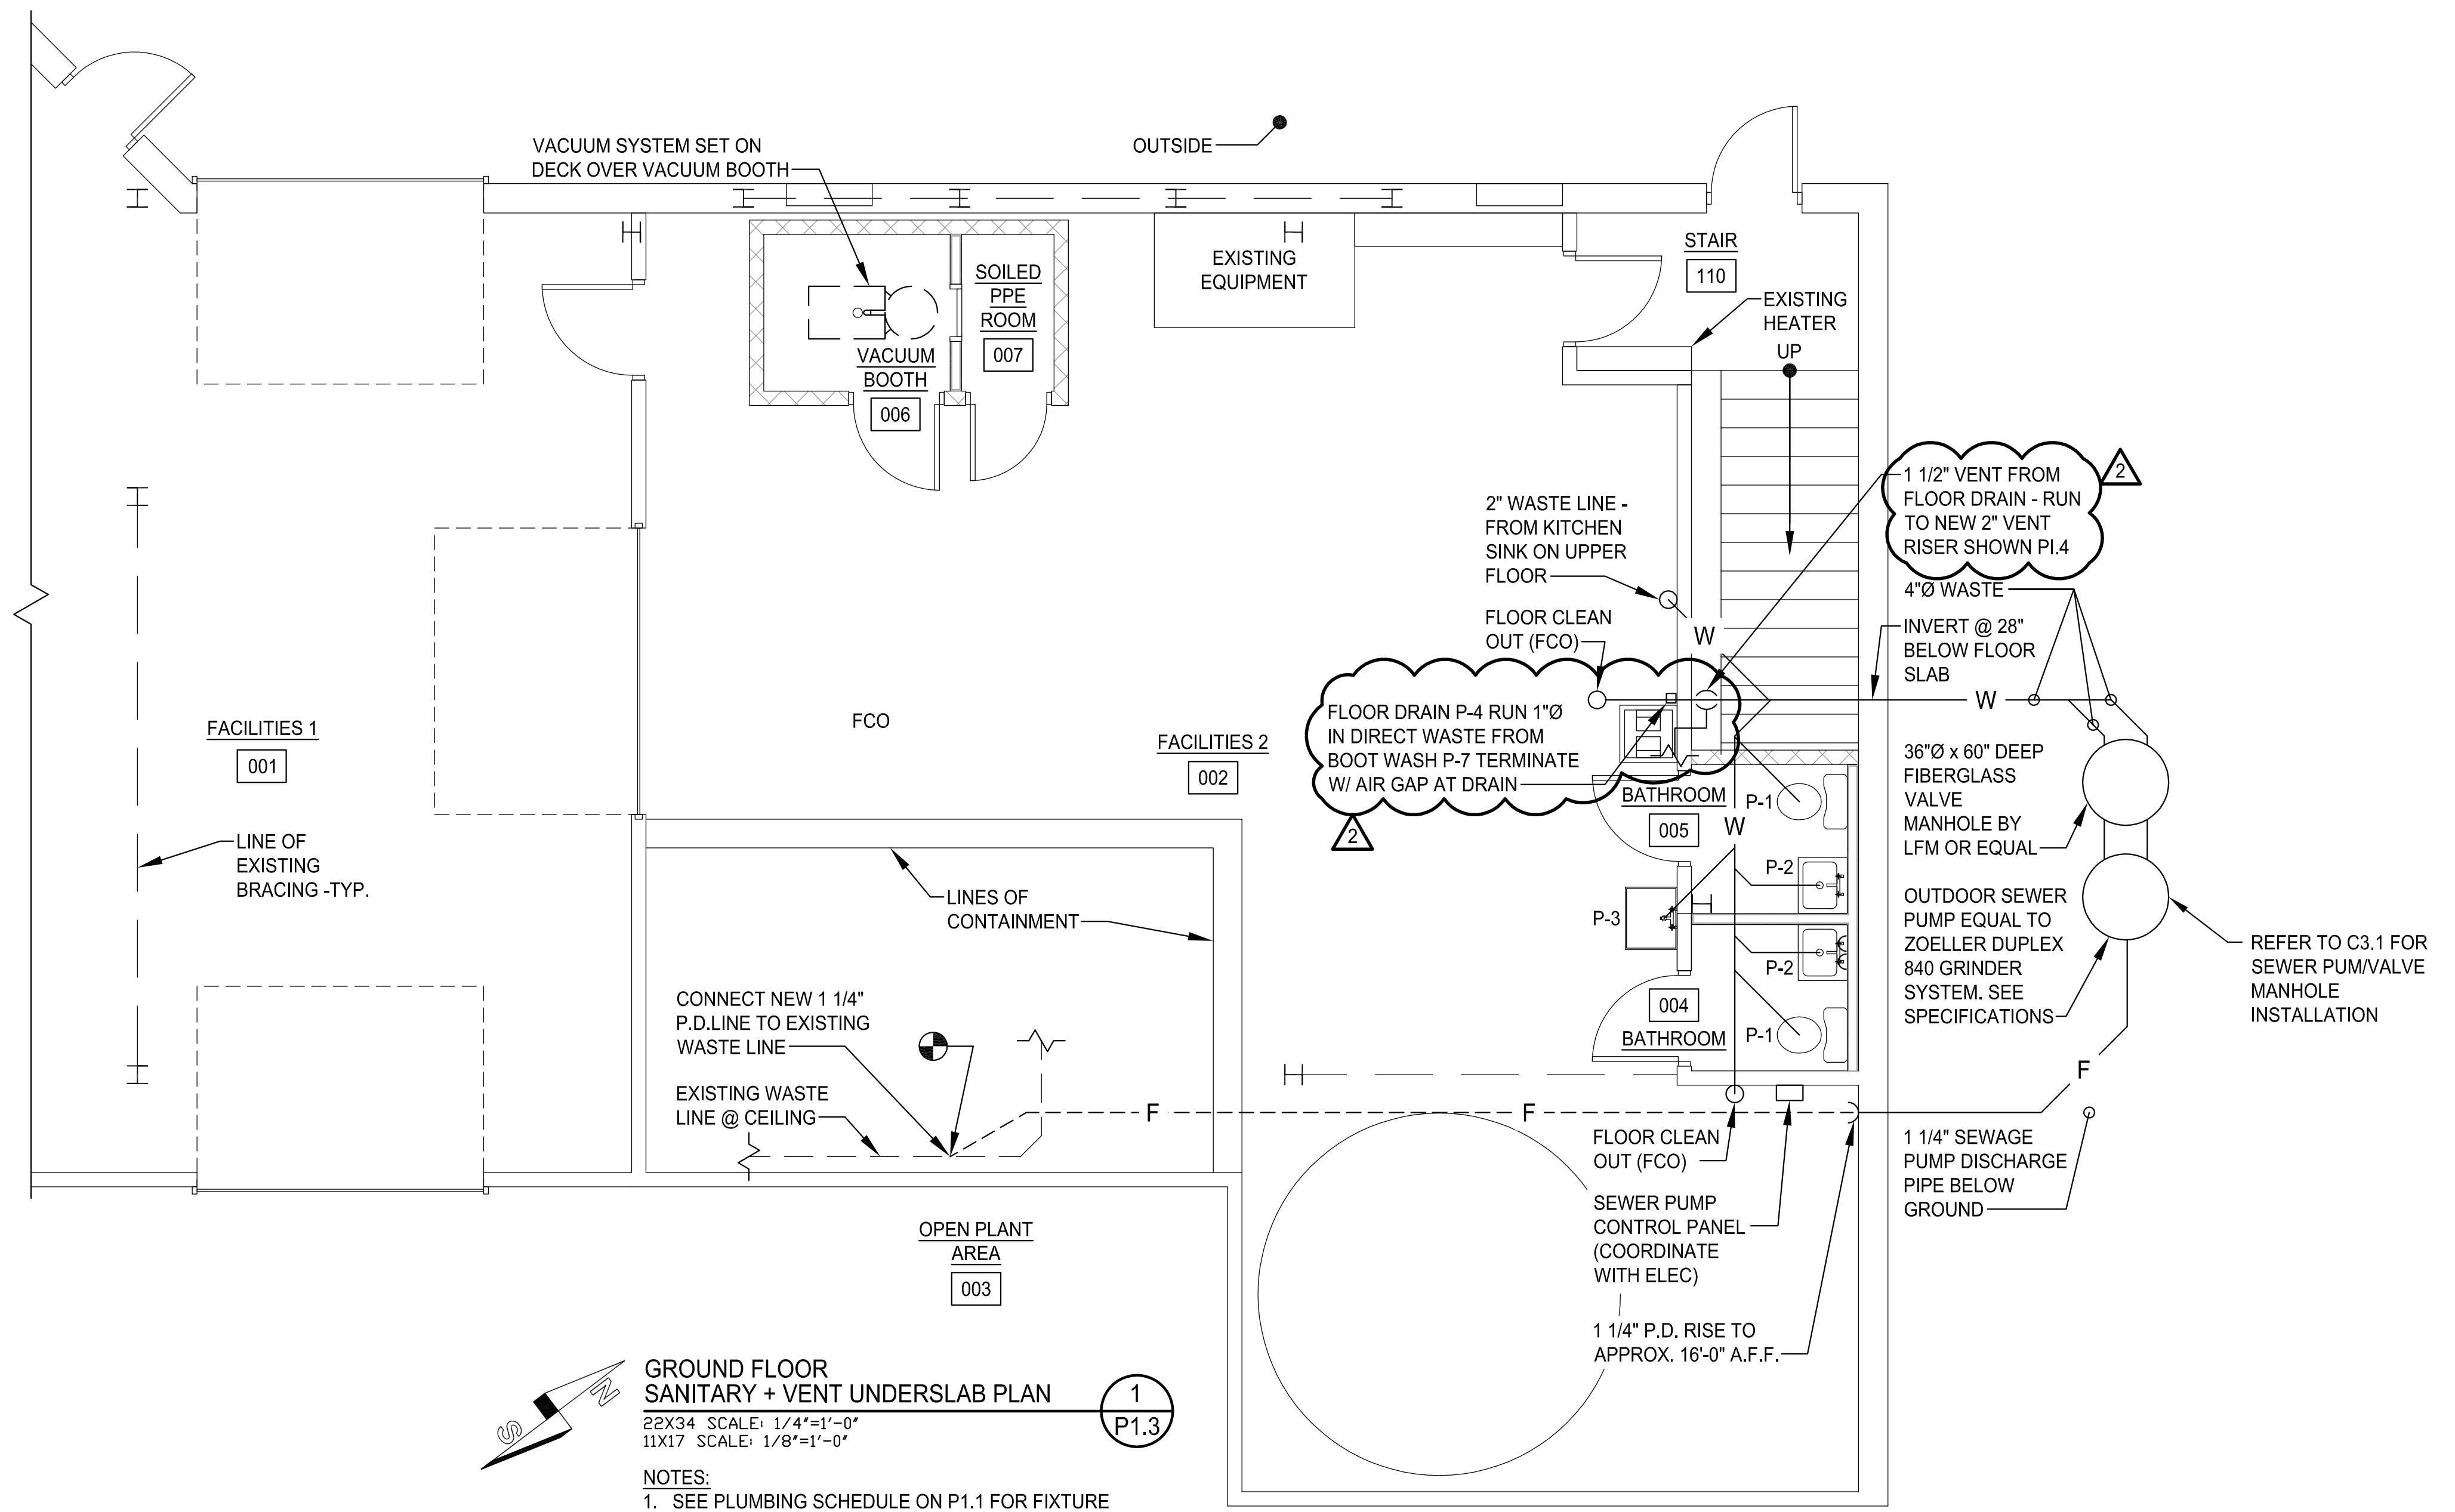

**GROUND FLOOR  
SANITARY + VENT UNDERSLAB PLAN** 1  
22X34 SCALE: 1/4"=1'-0"  
11X17 SCALE: 1/8"=1'-0" P1.3

**NOTES:**

- SEE PLUMBING SCHEDULE ON P1.1 FOR FIXTURE SPECIFICATIONS
- SLOPE WASTE PIPE AT 1/4" PER FOOT MIN.
- ALL EXISTING MAINS AND BRANCHES PROPOSED FOR CONNECTIONS BE VERIFIED IN THE FIELD BEFORE START OF WORK IN THE ASSOCIATED WORK SCOPE.

Optimized Design, Inc. P.C.  
Mechanical / HVAC

ecomaine  
**LOCKER ROOM RENOVATION**  
PORTLAND  
MAINE

SIGNED COPY OF DRAWING  
ON FILE AT DIRIGO A/E  
OFFICE

6/1/2016

**GROUND FL. SANITARY + VENT UNDERSLAB PLAN**

REV.	DATE	DESCRIPTION
1	1/18/16	ISSUED FOR CONSTRUCTION
2	6/1/16	ISSUED FOR SI #1
3		

DRAWN BY: CGB  
CHECKED BY: RHB

PH: (207) 225 - 3040  
1071 Auburn Road  
Suite G  
Turner, ME 04282

**DIRIGO ARCHITECTURAL**  
ENGINEERING • CONSTRUCTION MANAGEMENT  
EM: tperkins@dirigoae.com W: www.dirigoae.com

DATE: 6/1/16  
PROJECT NO. 15-015  
SHEET NO.  
**P1.3**