



COPYRIGHT 2016 © DIRIGO ARCHITECTURAL ENGINEERING LLC. ALL RIGHTS RESERVED. NO REPRODUCTION WITHOUT PRIOR WRITTEN PERMISSION

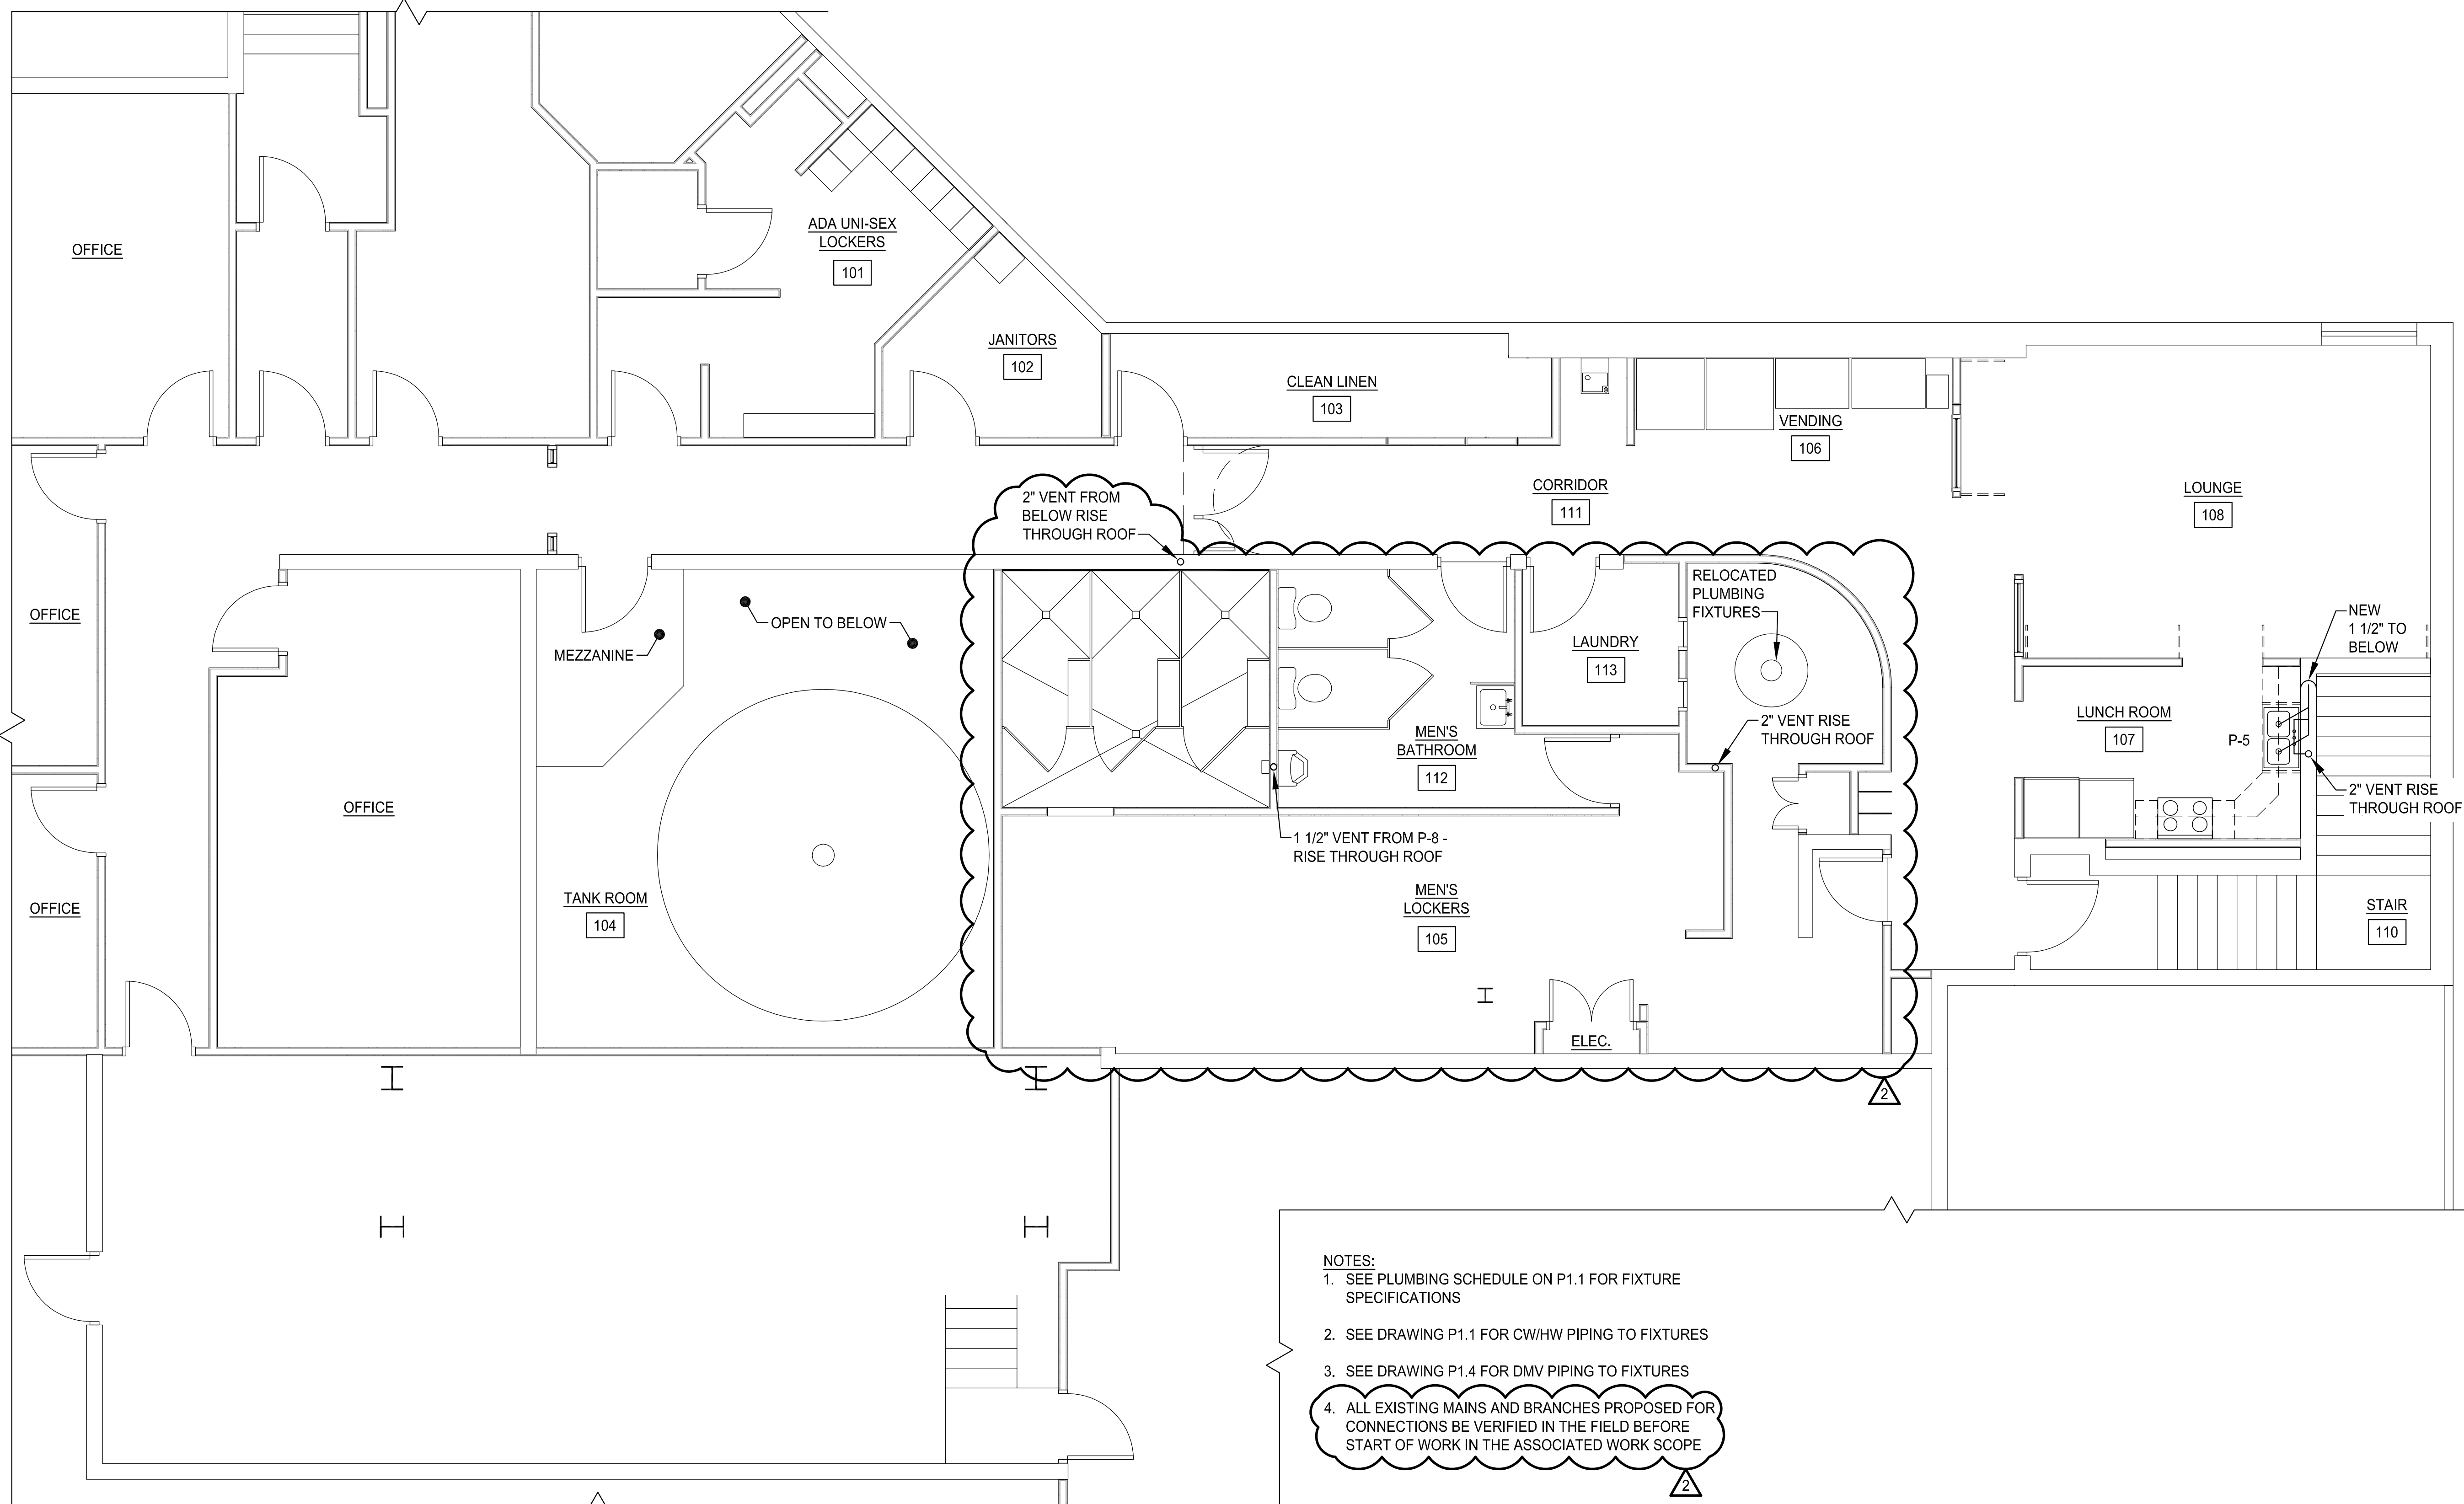

- NOTES:**
- SEE PLUMBING SCHEDULE ON P1.1 FOR FIXTURE SPECIFICATIONS
  - SEE DRAWING P1.1 FOR CW/HW PIPING TO FIXTURES
  - SEE DRAWING P1.4 FOR DMV PIPING TO FIXTURES
  - ALL EXISTING MAINS AND BRANCHES PROPOSED FOR CONNECTIONS BE VERIFIED IN THE FIELD BEFORE START OF WORK IN THE ASSOCIATED WORK SCOPE

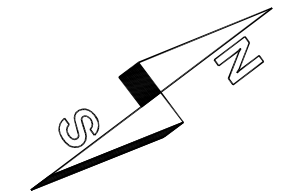

LEVEL 2 FLOOR SANITARY + VENT PLAN 1  
 22X34 SCALE: 1/4"=1'-0"  
 11X17 SCALE: 1/8"=1'-0" P1.5

Optimized Design, Inc. P.C.  
 Mechanical / HVAC

ecomaine  
**LOCKER ROOM RENOVATION**  
 PORTLAND  
 MAINE

SIGNED COPY OF DRAWING  
 ON FILE AT DIRIGO A/E  
 OFFICE

6/1/2016

**LEVEL 2 FL. SANITARY + VENT PLAN**

REV.	DATE	DESCRIPTION
1	1/18/16	ISSUED FOR CONSTRUCTION
2	6/1/16	ISSUED FOR SI #1
3		

DRAWN BY: CGB      CHECKED BY: RHB

PH: (207) 225 - 3040  
 1071 Auburn Road  
 Suite G  
 Turner, ME 04282

**DIRIGO**  
**ARCHITECTURAL**  
 ENGINEERING • CONSTRUCTION MANAGEMENT  
 EM: tperkins@dirigoae.com W: www.dirigoae.com

DATE: 6/1/16  
 PROJECT NO. 15-015

SHEET NO.  
**P1.5**