 
 
 
 





NOTES:

- SEE MECHANICAL, ELECTRICAL AND PLUMBING DRAWINGS FOR CEILING MOUNTED EQUIPMENT.


LEGEND:

-  ACOUSTICAL CEILING GRID AND 2X2 TILE WITH ARCHITECTURAL REVEAL
-  MOISTURE RESISTANT GYPSUM
-  RECESSED LIGHTING
-  DIFFUSERS
-  1X LIGHTING
-  2X2 LIGHTING

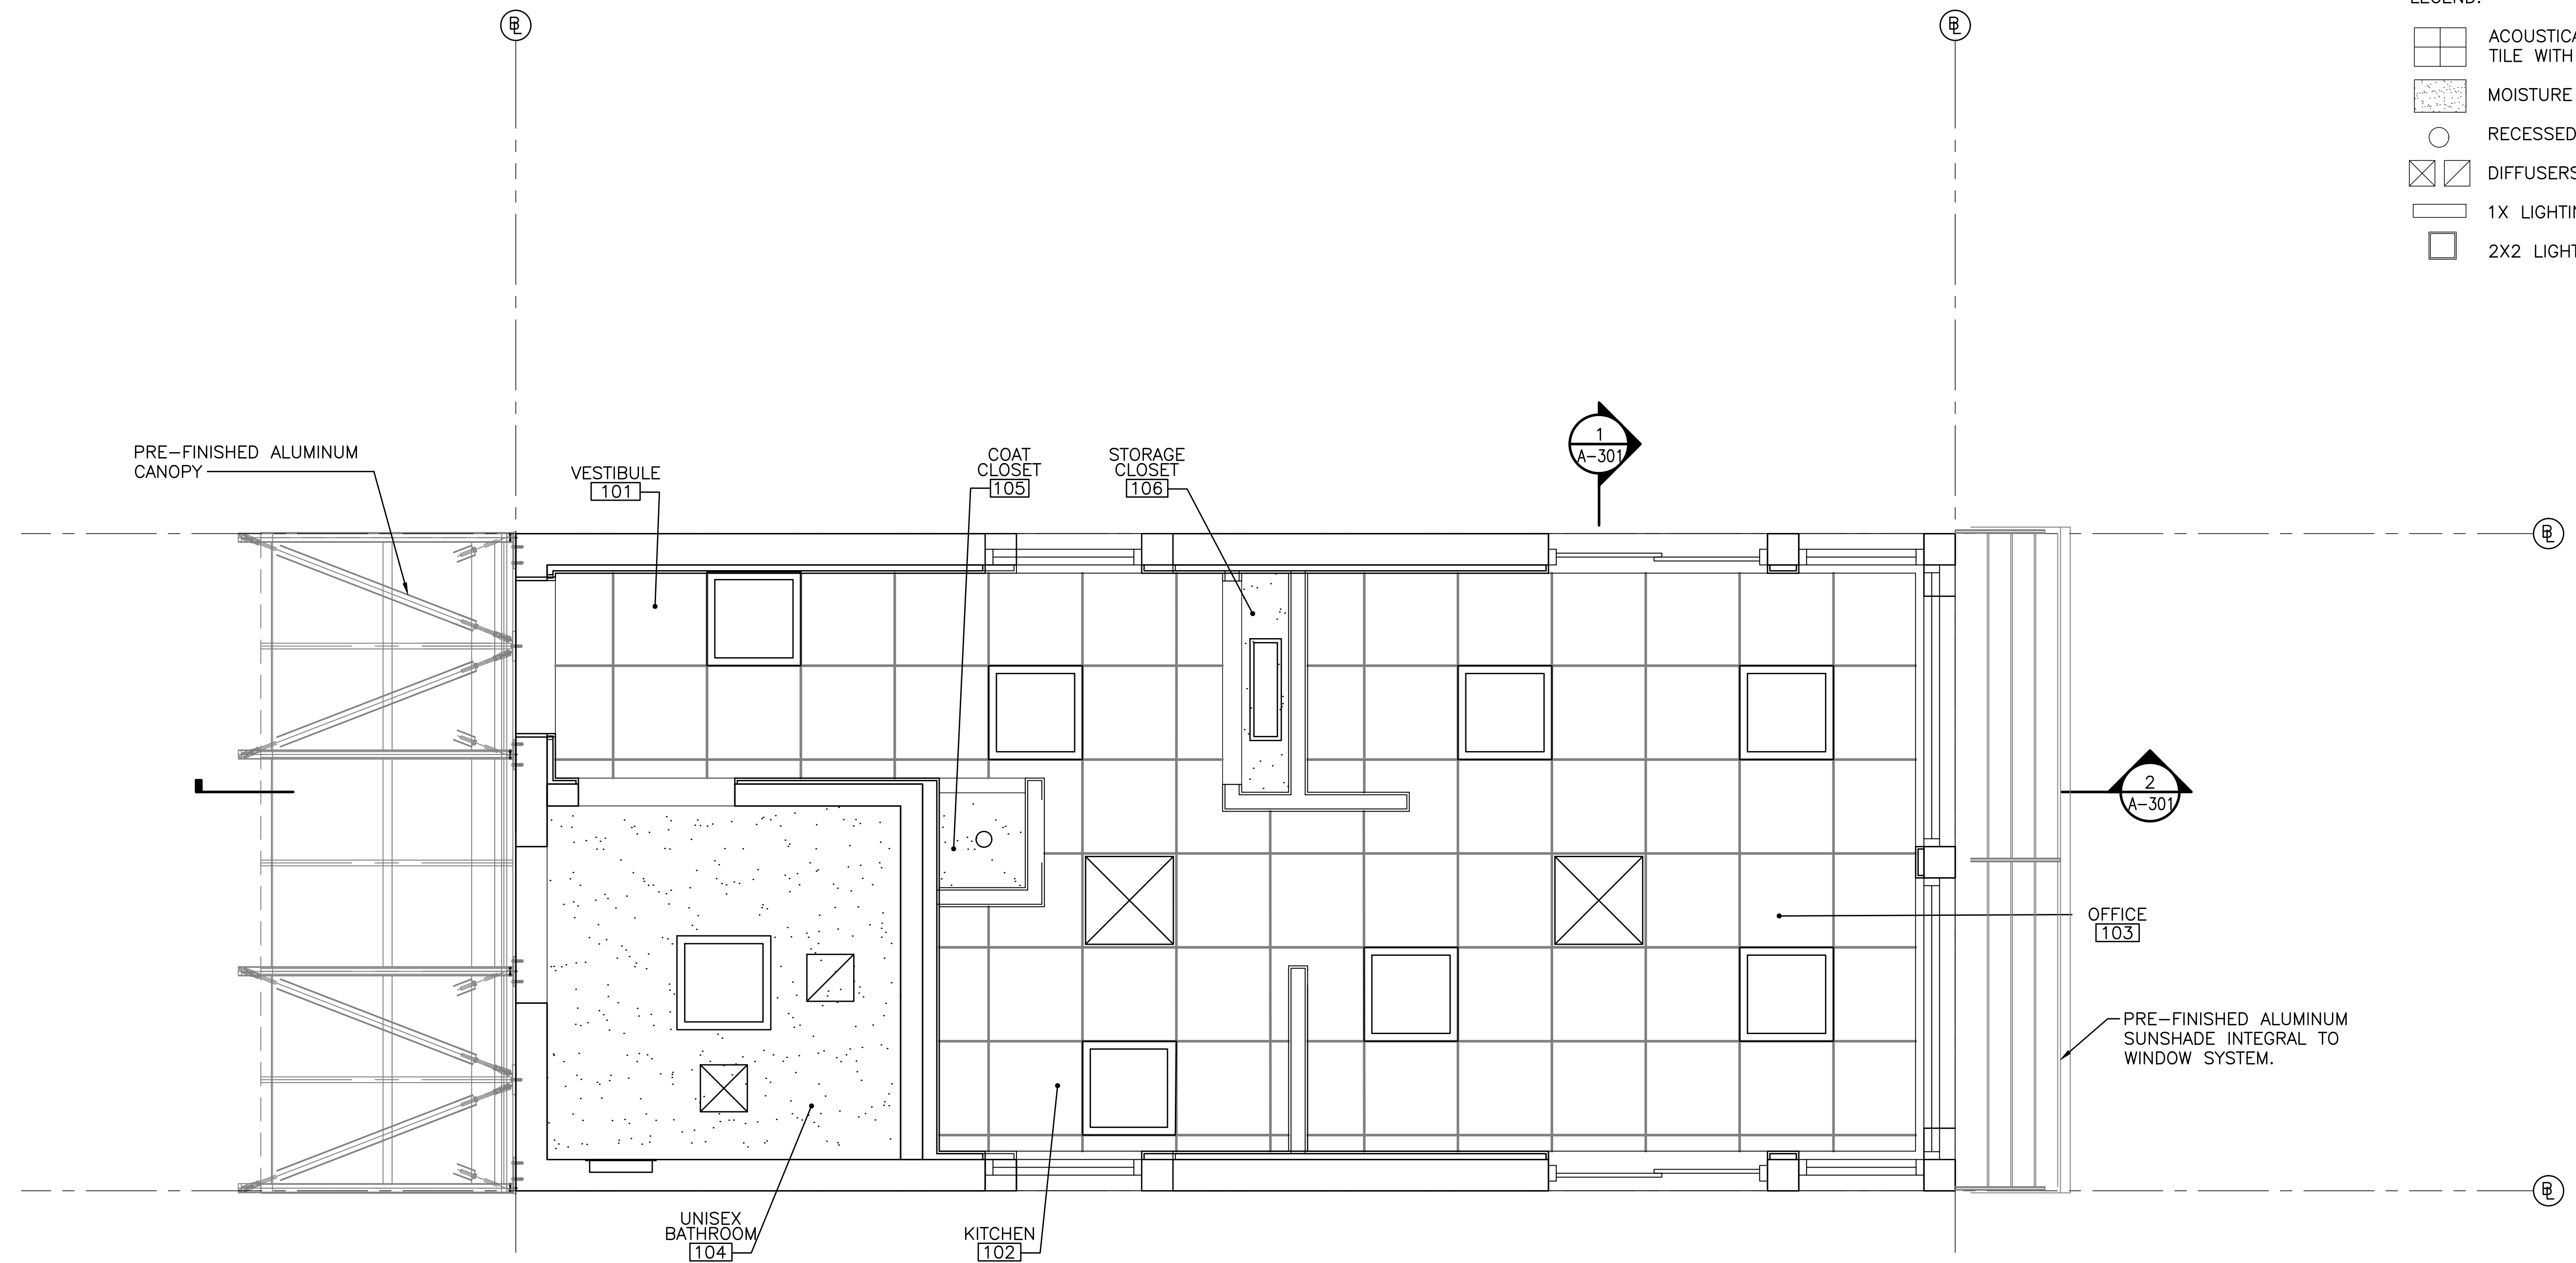

1
A-102 REFLECTED CEILING PLAN
SCALE: 1/2" = 1'-0"

**ISSUED FOR BID
NOT FOR CONSTRUCTION**
JANUARY 5, 2017

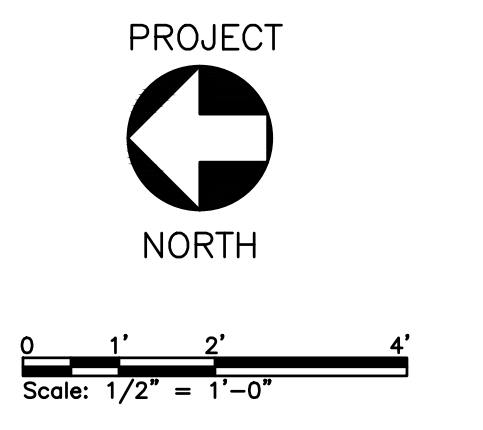

REV	DESCRIPTION	DWN	APP	DATE
C	RE-ISSUED FOR BID	BLB	CBC	01/05/17
B	RE-ISSUED FOR BID	BLB	CBC	10/28/16
A	ISSUED FOR BID	BLB	CBC	9/02/16

ecomaine 64 BLUEBERRY ROAD, PORTLAND, ME	
SCALE HOUSE WITH INSULATED BLOCK CONSTRUCTION	
REFLECTED CEILING PLAN	
PROJECT NO. 162.002.002	DRAWING NO. A-102
SHEET 12 OF 40	

PLEASE NOTE: THIS DOCUMENT MAY NOT ACCURATELY REPRESENT THE FINAL DOCUMENT. ONLY AN ENGINEER, ARCHITECT OR SURVEYOR SIGNED, SEALED AND DATED PAPER COPY, PROVIDED BY THIS OFFICE, MAY BE UTILIZED FOR BIDDING OR CONSTRUCTION PURPOSES.

Colby Company
engineering
47A York Street
Portland, Maine 04101
207.553.7753
colbycoengineering.com

SIZE: ANSI D
DATE: 09/02/2016
DES BY: BLB
DWN BY: BLB
CKD BY: DMD