

NOTES:



1. SEE SHEET E-001 FOR LEGEND, ABBREVIATIONS, AND GENERAL NOTES.
2. SEE SHEET E-601 FOR LIGHTING FIXTURE SCHEDULE AND PANEL SCHEDULE.

KEYED NOTES:

- ① SURFACE MOUNTED FIXTURE.
- ② RECONNECT SALVAGED SUPPLY CONDUCTORS FROM DESIGNATED PANEL LP9 CIRCUIT. REPLACE LAMPS; SEE SHEET E-601 FOR EXISTING FIXTURE PRODUCT DATA. NOTE: FIXTURE LOCATION NOT SHOWN TO SCALE; SEE SHEET C-101 FOR EXACT FIXTURE LOCATION.
- ③ SWITCH CONTROLS INTERIOR LIGHTING FIXTURES IN VESTIBULE, KITCHEN, AND OFFICE.

CIRCUIT SCHEDULE:


- ① LP9-1
- ② LP9-2
- ③ LP9-27,29

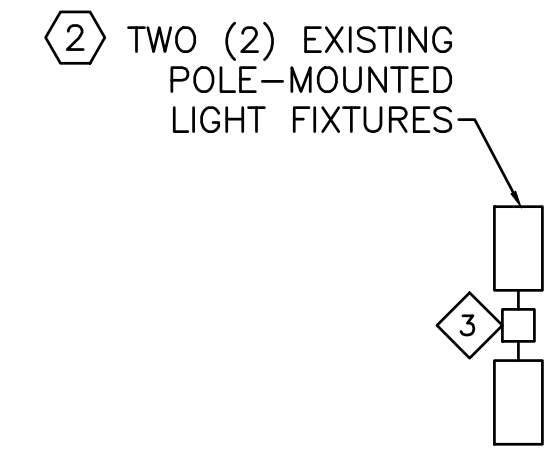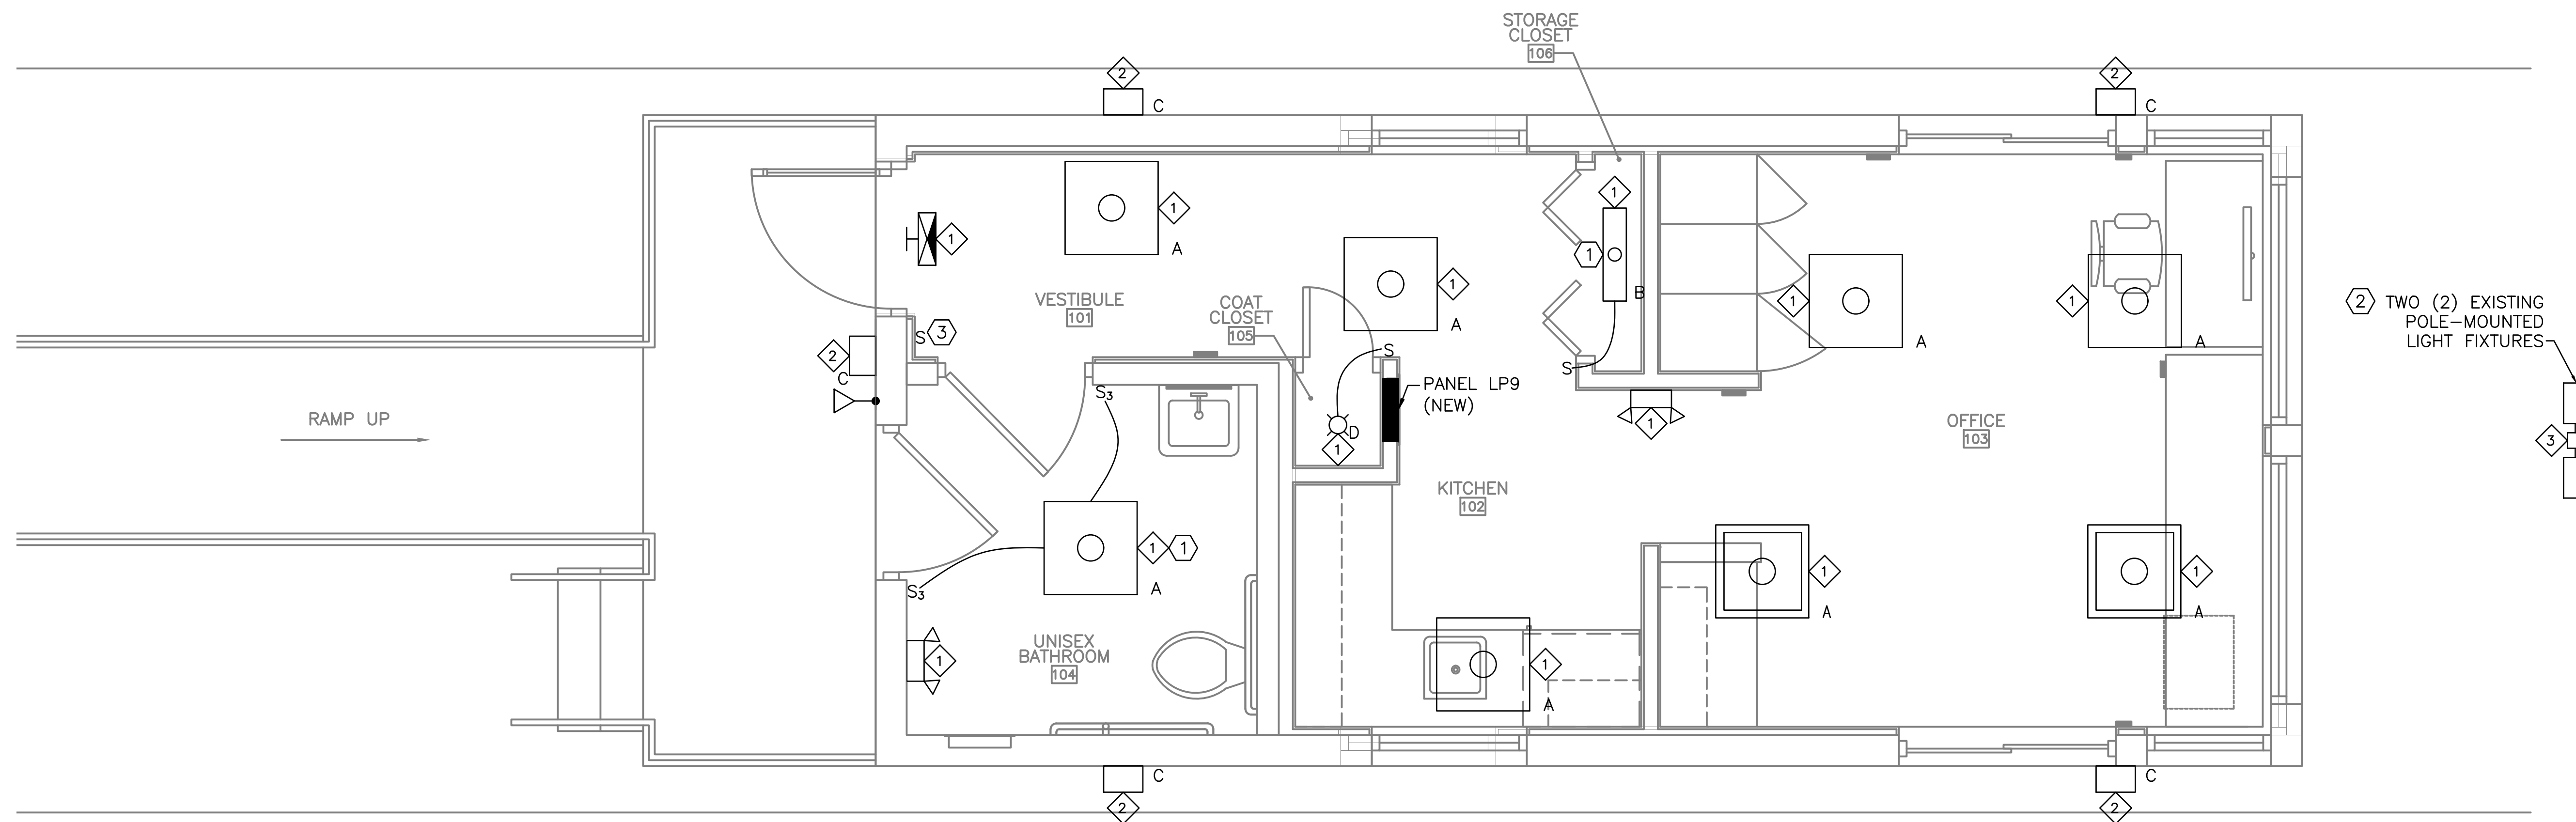


LIGHTING FLOOR PLAN

SCALE: 1/2" = 1'-0"


PROJECT

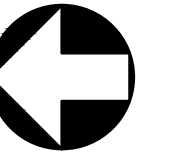

NORTH

 

ISSUED FOR BID
NOT FOR CONSTRUCTION
 JANUARY 5, 2017

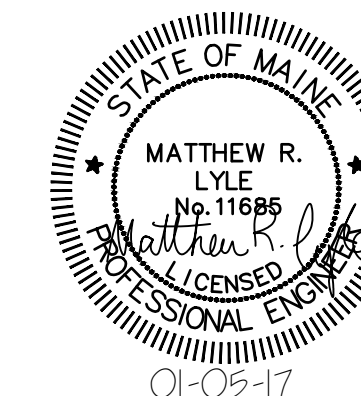

PLEASE NOTE: THIS DOCUMENT MAY NOT ACCURATELY REPRESENT THE FINAL DOCUMENT. ONLY AN ENGINEER, ARCHITECT OR SURVEYOR SIGNED, SEALED AND DATED PAPER COPY, PROVIDED BY THIS OFFICE, MAY BE UTILIZED FOR BIDDING OR CONSTRUCTION PURPOSES.

REV	DESCRIPTION	DWN	APP	DATE
C	RE-ISSUED FOR BID	MRL	CBC	01/05/17
B	RE-ISSUED FOR BID	MRL	CBC	10/28/16
A	ISSUED FOR BID	MRL	CBC	9/02/16

SIZE:	ANSI D
DATE:	09/02/2016
DES BY:	MRL
DWN BY:	MRL
CKD BY:	CBC

ecomaine 64 BLUEBERRY ROAD, PORTLAND, ME	
SCALE HOUSE WITH INSULATED BLOCK CONSTRUCTION	
LIGHTING FLOOR PLAN	
PROJECT NO.	162.002.002
DRAWING NO.	E-102
SHEET	39 OF 40