



ecomaine

64 BLUEBERRY ROAD
PORTLAND, MAINE 04102

JANUARY 5, 2017 - ISSUED FOR BID

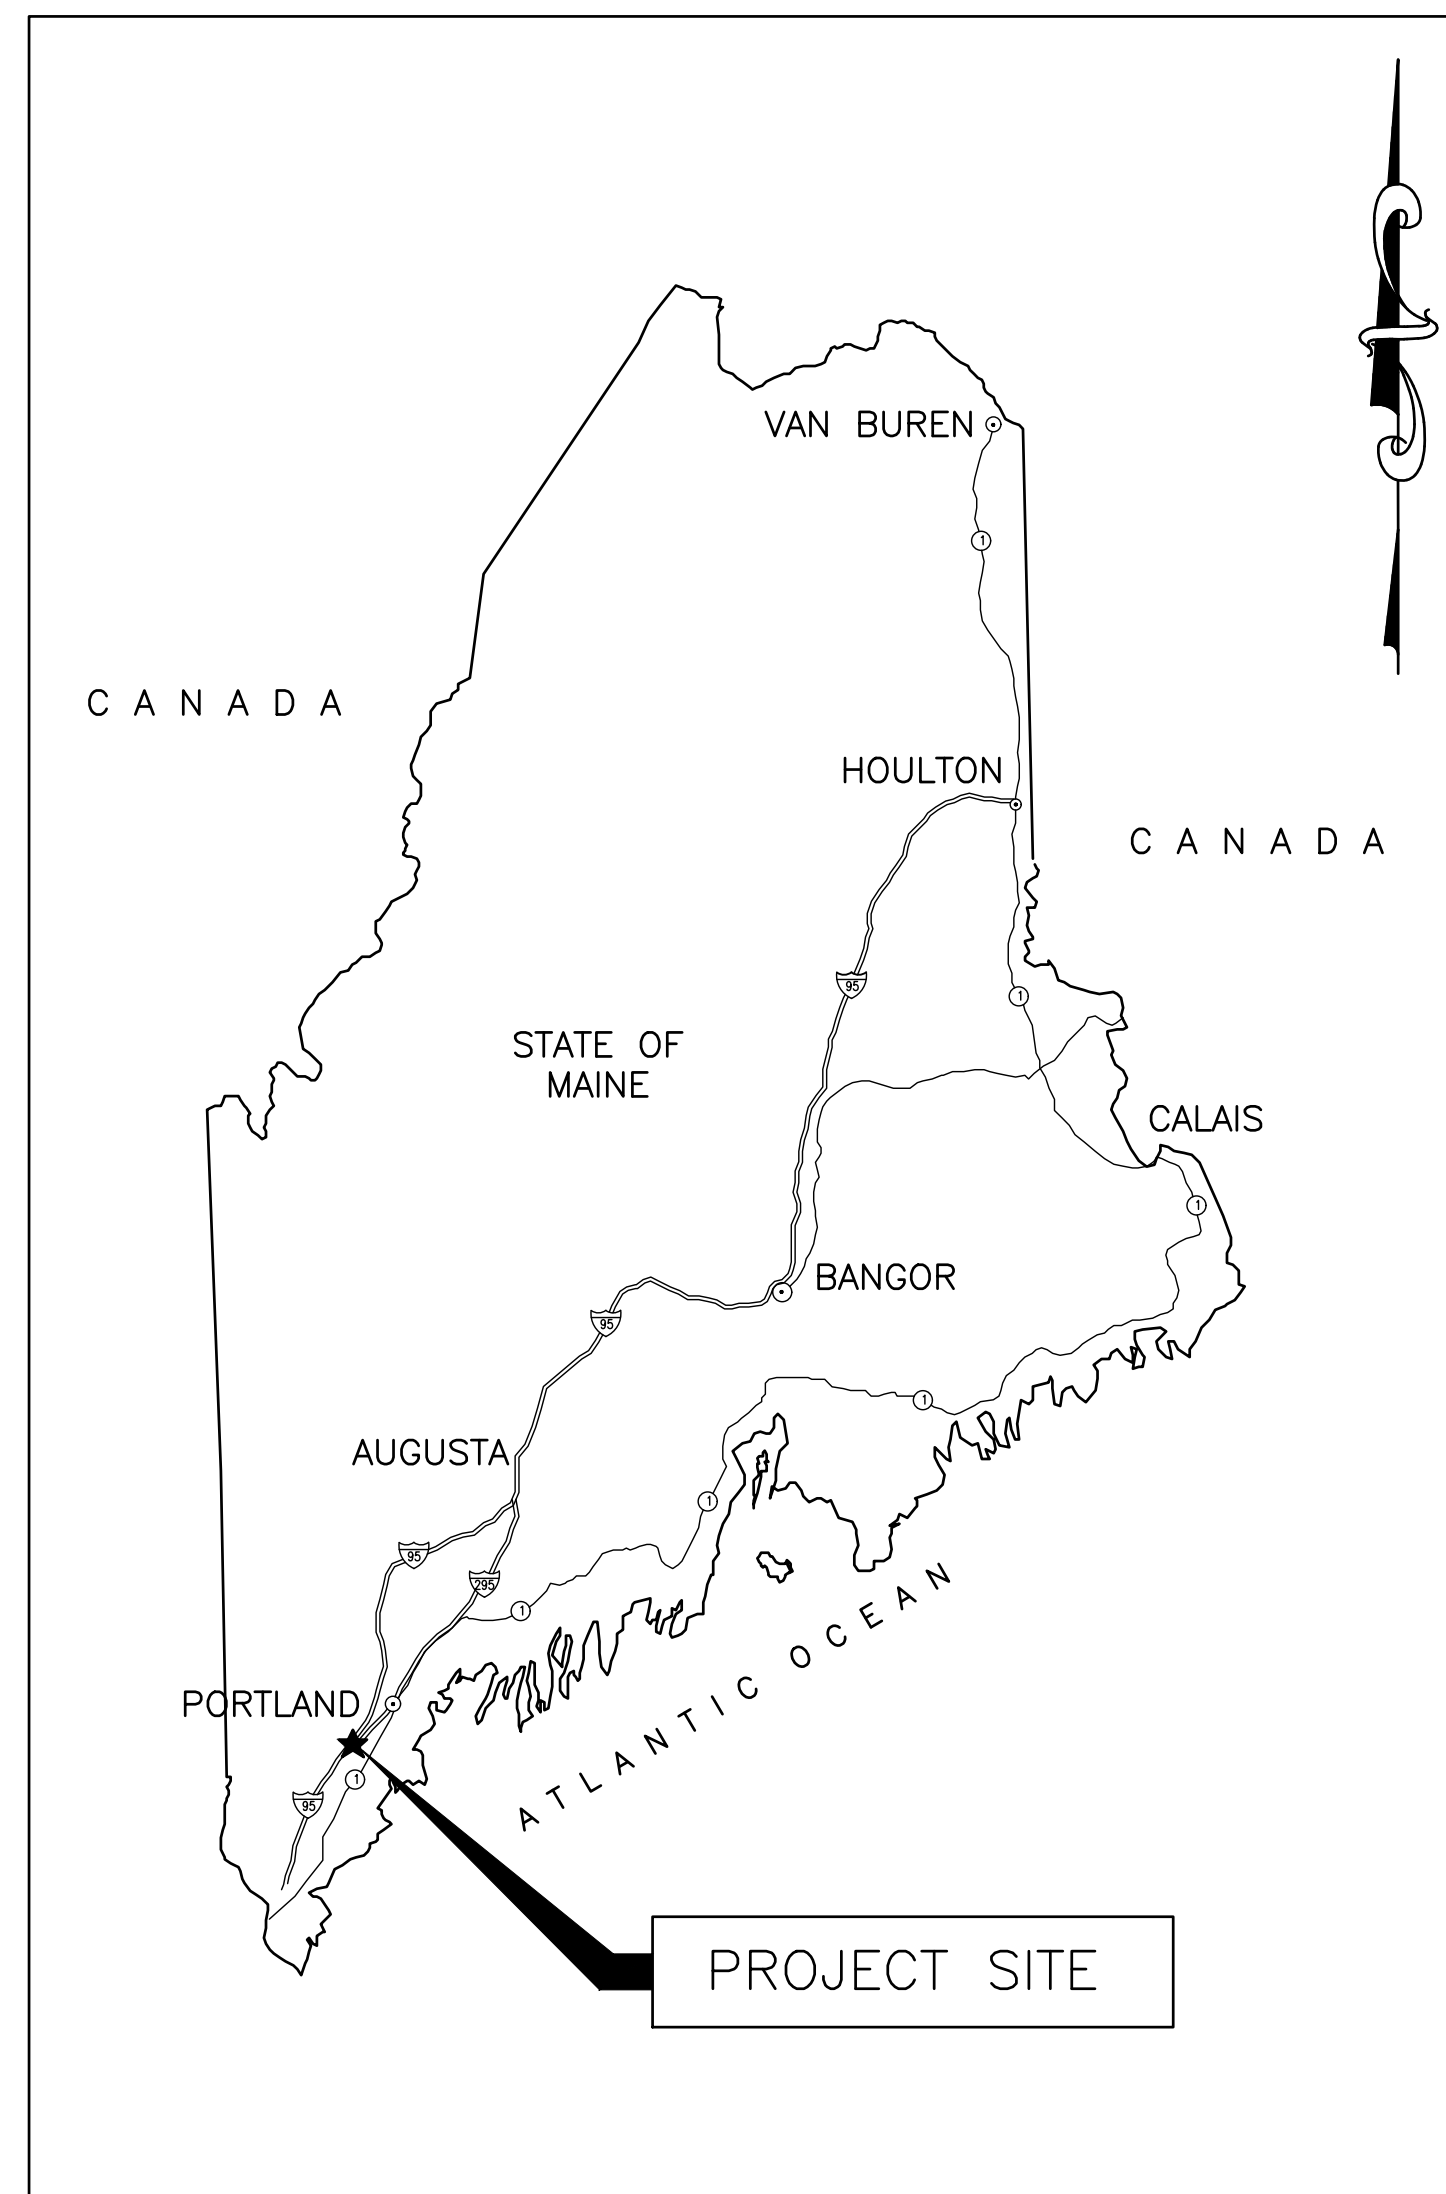


VICINITY MAP
SCALE: NTS

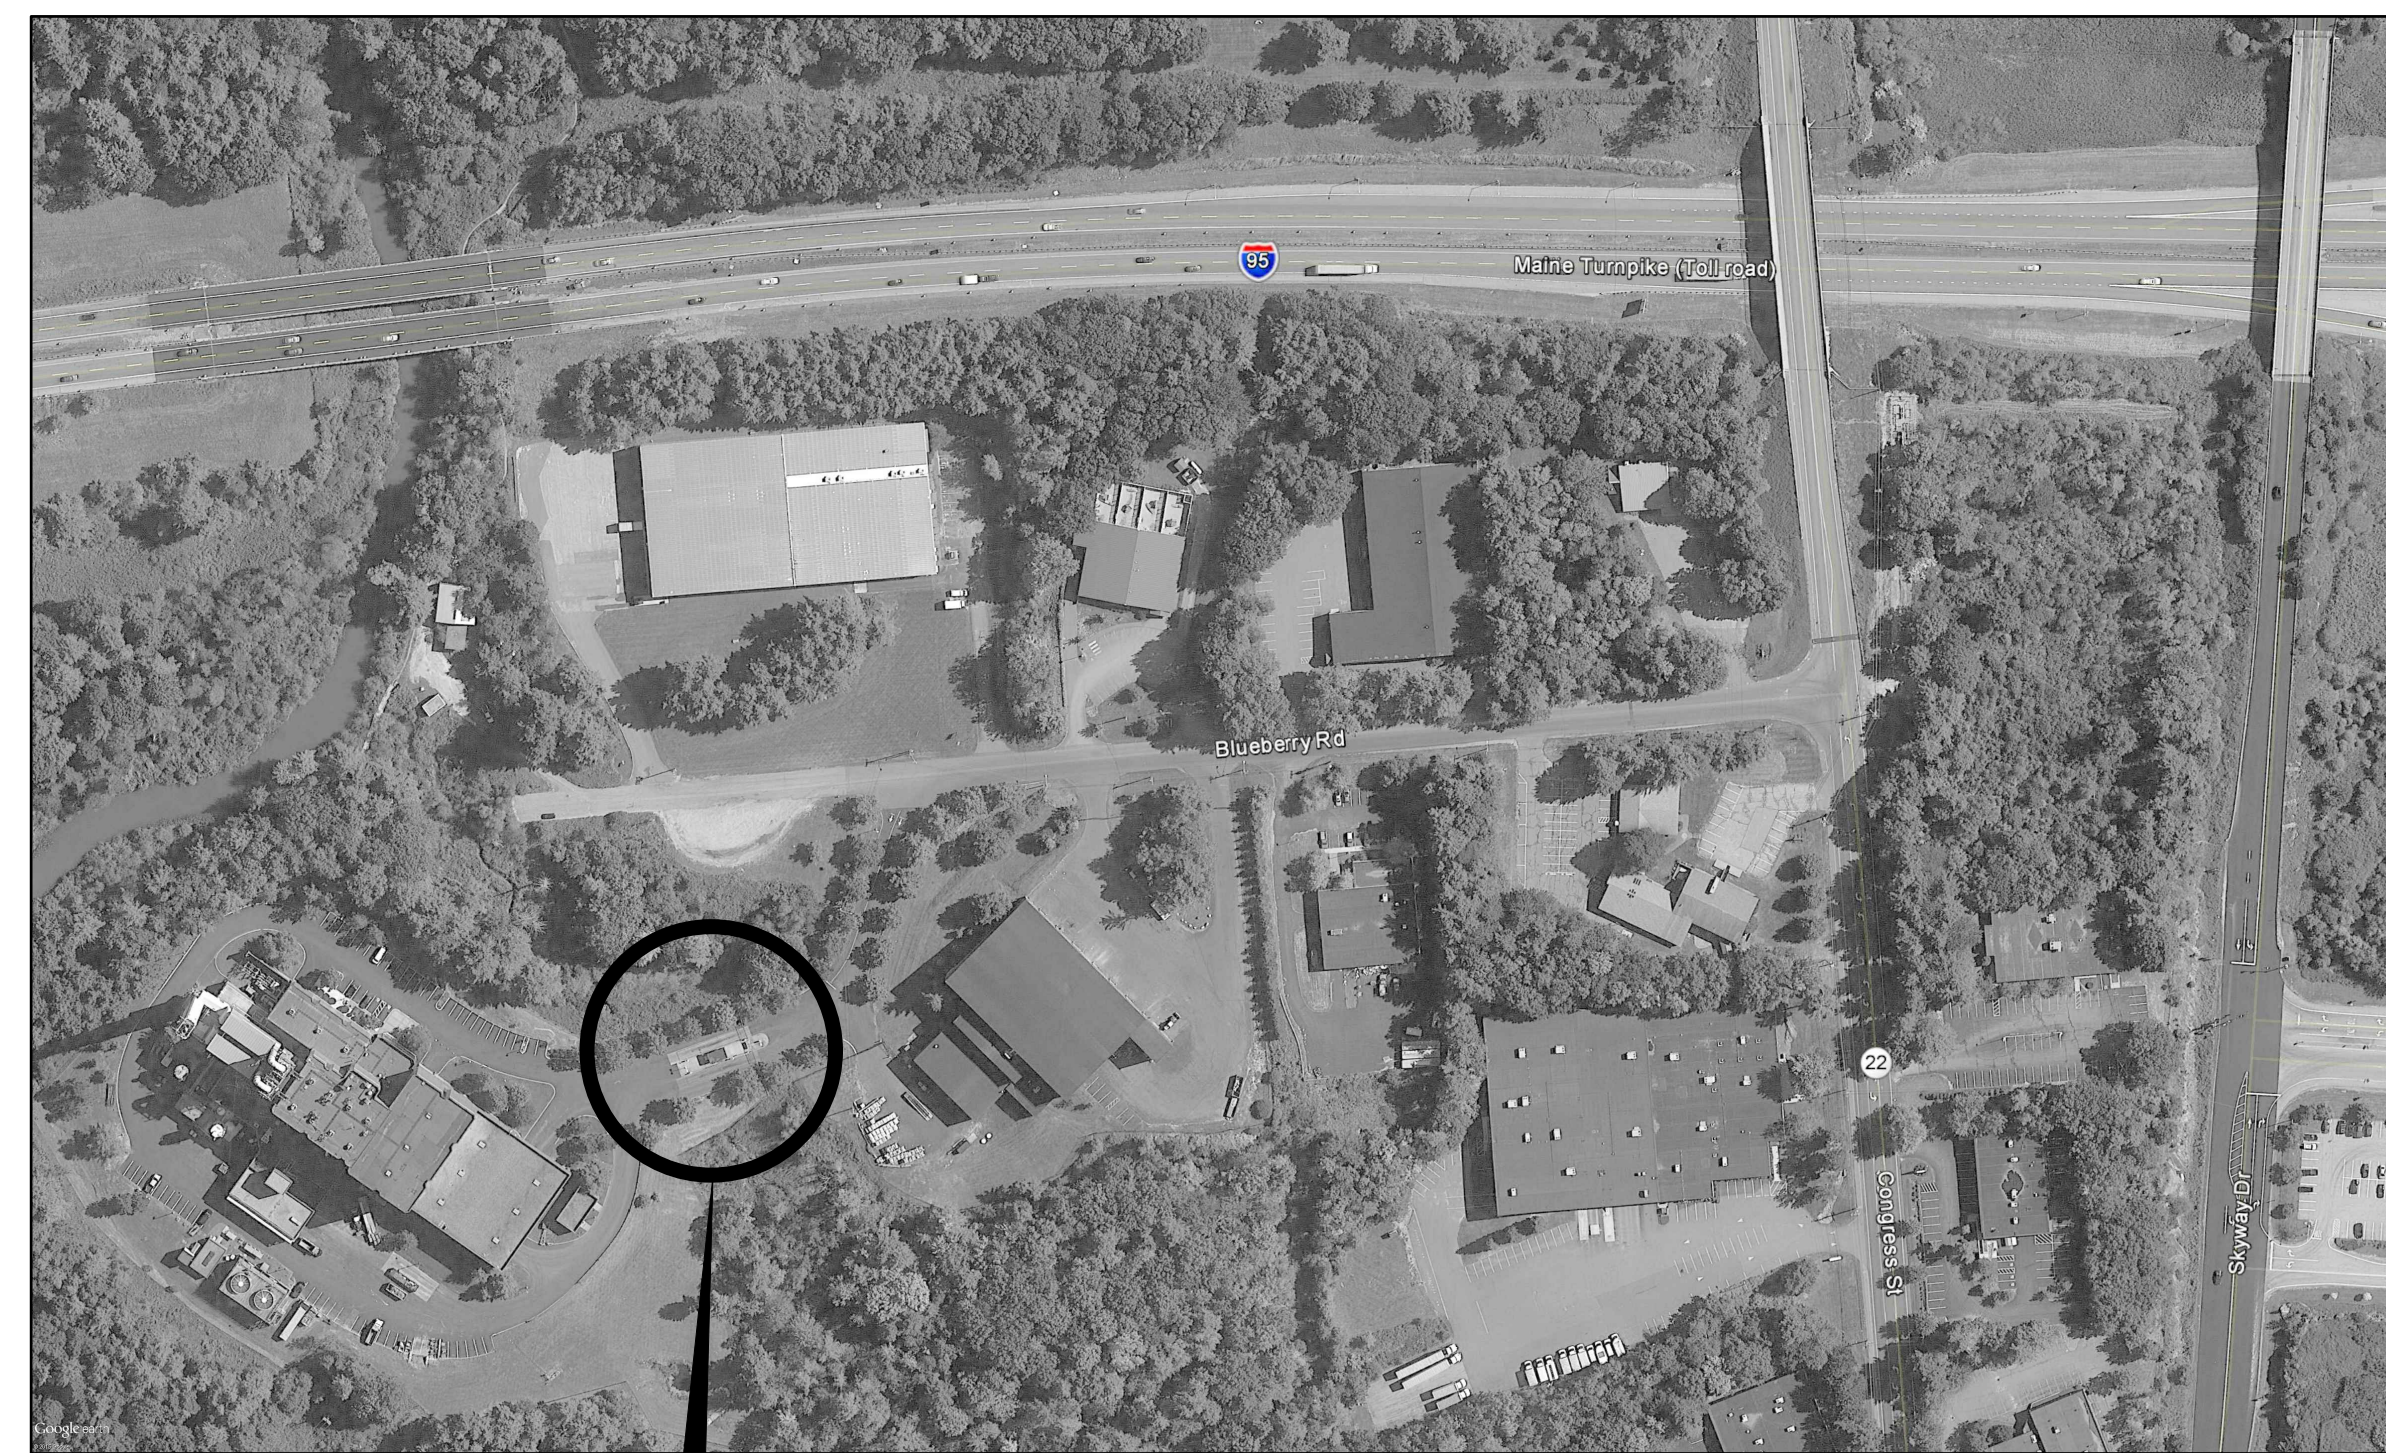

SCALE HOUSE SITE

LOCATION MAP
SCALE: NTS

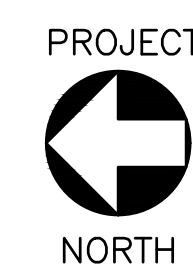

ecomaine SHEET INDEX		
DRAWING	TITLE	SHEET NUMBER
G-001	COVER SHEET	1
C-001	SITE GENERAL NOTES, LEGEND, AND ABBREVIATIONS	2
C-101	EXISTING CONDITIONS PLAN	3
CD-101	SITE DEMOLITION PLAN	4
C-102	SITE LAYOUT PLAN	5
C-501	EROSION AND SEDIMENTATION CONTROL NOTES AND DETAILS	6
C-502	SITE DETAILS	7
A-001	GENERAL NOTES AND SPECIFICATIONS	8
AD-101	DEMOLITION FLOOR PLAN, REFLECTED CEILING PLAN AND ROOF PLAN	9
AD-201	DEMOLITION EXTERIOR ELEVATIONS	10
A-101	FLOOR PLAN	11
A-102	REFLECTED CEILING PLAN	12
A-103	ROOF PLAN	13
A-201	EXTERIOR ELEVATIONS	14
A-301	BUILDING SECTIONS	15
A-302	WALL SECTIONS	16
A-401	INTERIOR ELEVATIONS	17
A-601	SCHEDULES AND DETAILS	18
S-001	STRUCTURAL GENERAL NOTES	19
S-101	SCALE HOUSE FOUNDATION PLAN	20
S-102	SCALE HOUSE CMU PLAN	21
S-103	FRAMING PLANS	22
S-201	SCALE HOUSE CMU ELEVATIONS	23
S-501	STRUCTURAL DETAILS	24
S-502	STRUCTURAL DETAILS	25
M-001	MECHANICAL LEGEND, ABBREVIATIONS, GENERAL NOTES, AND SPECS	26
M-002	MECHANICAL SPECIFICATIONS	27
M-101	MECHANICAL FIRST FLOOR PLAN	28
M-102	MECHANICAL ROOF PLAN	29
M-501	MECHANICAL DETAILS	30
M-601	MECHANICAL SCHEDULES	31
P-001	PLUMBING LEGEND, ABBREVIATIONS, GENERAL NOTES AND SCHEDULES	32
PD-101	PLUMBING DEMOLITION PLAN	33
P-101	PLUMBING FLOOR PLANS	34
P-501	PLUMBING DETAILS AND SCHEDULES	35
E-001	ELECTRICAL LEGEND, ABBREVIATIONS, AND GENERAL NOTES	36
ED-101	ELECTRICAL DEMOLITION PLAN	37
E-101	ELECTRICAL FLOOR PLAN	38
E-102	LIGHTING FLOOR PLAN	39
E-601	PANEL & LIGHTING SCHEDULES AND ELECTRICAL DETAILS	40

ISSUED FOR BID
NOT FOR CONSTRUCTION
JANUARY 5, 2017

PLEASE NOTE: THIS DOCUMENT MAY NOT ACCURATELY REPRESENT THE FINAL DOCUMENT. ONLY AN ENGINEER, ARCHITECT OR SURVEYOR SIGNED, SEALED AND DATED PAPER COPY, PROVIDED BY THIS OFFICE, MAY BE UTILIZED FOR BIDDING OR CONSTRUCTION PURPOSES.

				ecomaine	
				64 BLUEBERRY ROAD, PORTLAND, ME	
				SCALE HOUSE WITH INSULATED BLOCK CONSTRUCTION	
				COVER SHEET	
C	RE-ISSUED FOR BID	BLB	CBC	01/05/17	
B	RE-ISSUED FOR BID	BLB	CBC	10/28/16	
A	ISSUED FOR BID	BLB	CBC	9/02/16	
REV	DESCRIPTION	DWN	APP	DATE	
		SIZE: ANSI D		PROJECT NO.	DRAWING NO.
		DATE: 09/02/2016		162.002.002	
		DES BY: BLB		SHEET	G-001
		DWN BY: BLB		1 OF 40	
		CKD BY: DMD			



47A York Street
Portland, Maine 04101
207.533.7753
colbycoengineering.com