


NOTES:

1. SEE SHEET P-001 FOR LEGEND, ABBREVIATIONS AND GENERAL NOTES.
2. COORDINATE DEMOLITION OF PLUMBING EQUIPMENT AND ASSOCIATED COMPONENTS WITH OTHER TRADES.
3. SEE CIVIL DRAWINGS FOR NEW STORM WATER PIPING, EXISTING DOMESTIC WATER PIPING, AND EXISTING SANITARY PIPING.

DEMOLITION KEYED NOTES:


- 1 CUT AND CAP 3" SANITARY AND 1" WATER MAIN 6" ABOVE SLAB.
- 2 3"X3" RAIN LEADER AND SIDEWALL DOWNSPOUT TO BE REMOVED.

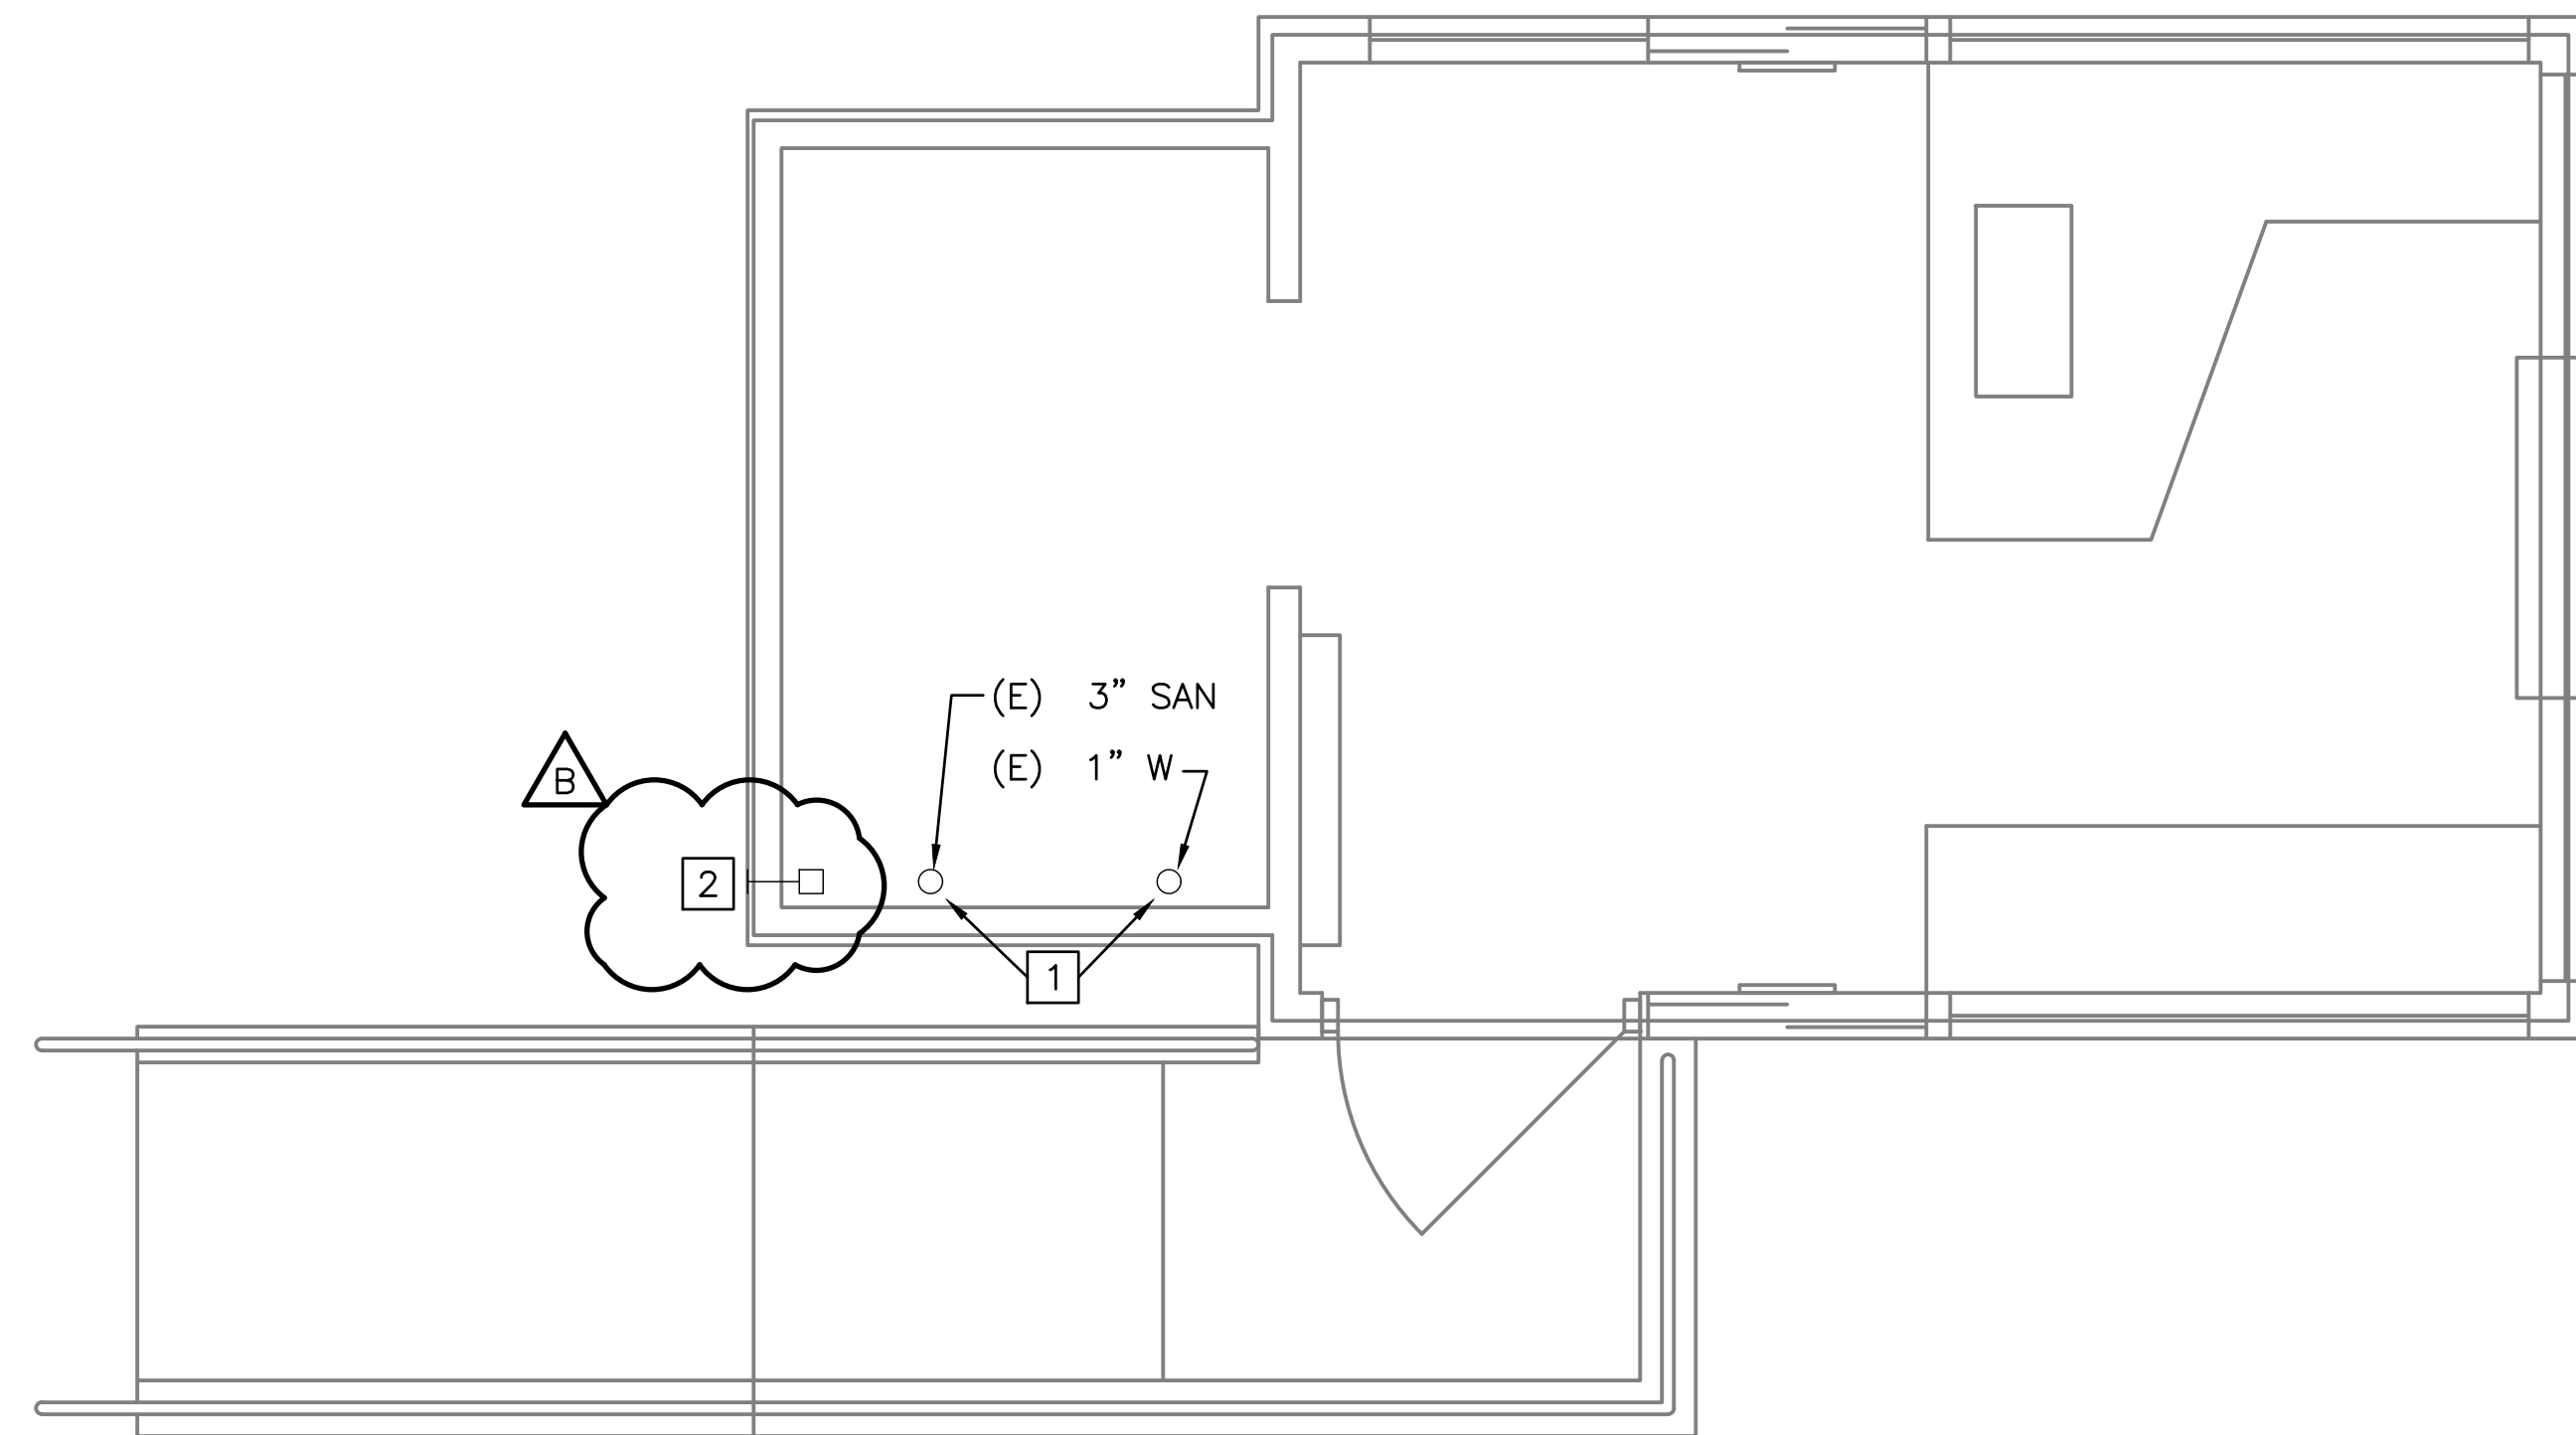


DEMOLITION – SANITARY & DOMESTIC WATER FLOOR PLAN

SCALE: 1/2" = 1'-0"


PROJECT

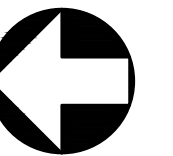

NORTH

 

ISSUED FOR BID
NOT FOR CONSTRUCTION
 JANUARY 5, 2017

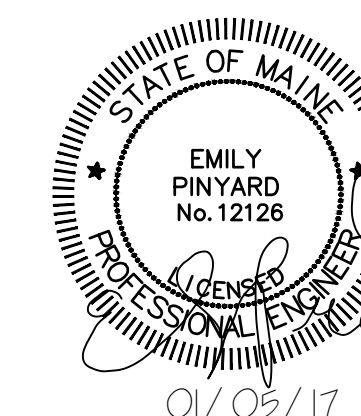

				ecomaine 64 BLUEBERRY ROAD, PORTLAND, ME	
				SCALE HOUSE WITH INSULATED BLOCK CONSTRUCTION	
				PLUMBING DEMOLITION PLAN	
REV	DESCRIPTION	DWN	APP	DATE	
C	RE-ISSUED FOR BID	MBD	ERP	01/05/17	
B	RE-ISSUED FOR BID	MBD	ERP	10/28/16	
A	ISSUED FOR BID	MBD	ERP	9/02/16	
PLEASE NOTE: THIS DOCUMENT MAY NOT ACCURATELY REPRESENT THE FINAL DOCUMENT. ONLY AN ENGINEER, ARCHITECT OR SURVEYOR SIGNED, SEALED AND DATED PAPER COPY, PROVIDED BY THIS OFFICE, MAY BE UTILIZED FOR BIDDING OR CONSTRUCTION PURPOSES.		SIZE:	ANSI D		PROJECT NO.
		DATE:	09/02/2016		162.002.002
		DES BY:	MIF		SHEET
		DWN BY:	MBD		33 OF 40
		CKD BY:	ERP		
 47A York Street Portland, Maine 04101 207.533.7753 colbycoengineering.com		PD-101			