

10

9

8

7

6

5








4


3

2

1


General Notes
 WARNING: This document contains sensitive security information and intellectual property that is the work, product and property of Securadyne Systems, LLC. and intended for use only as part of a working relationship with our customer. If the confidentiality of this document and the information it contains cannot be assured, please discontinue use and notify Securadyne Systems, LLC. immediately.

- LEGEND**
-  PULL STATION
 -  HORN WITH STROBE, CEILING
 -  STROBE, CEILING
 -  SMOKE DETECTOR
 -  FIRE ALARM PANEL
 -  FIRE ALARM SYSTEM ANNUNCIATOR
 -  CITY BOX

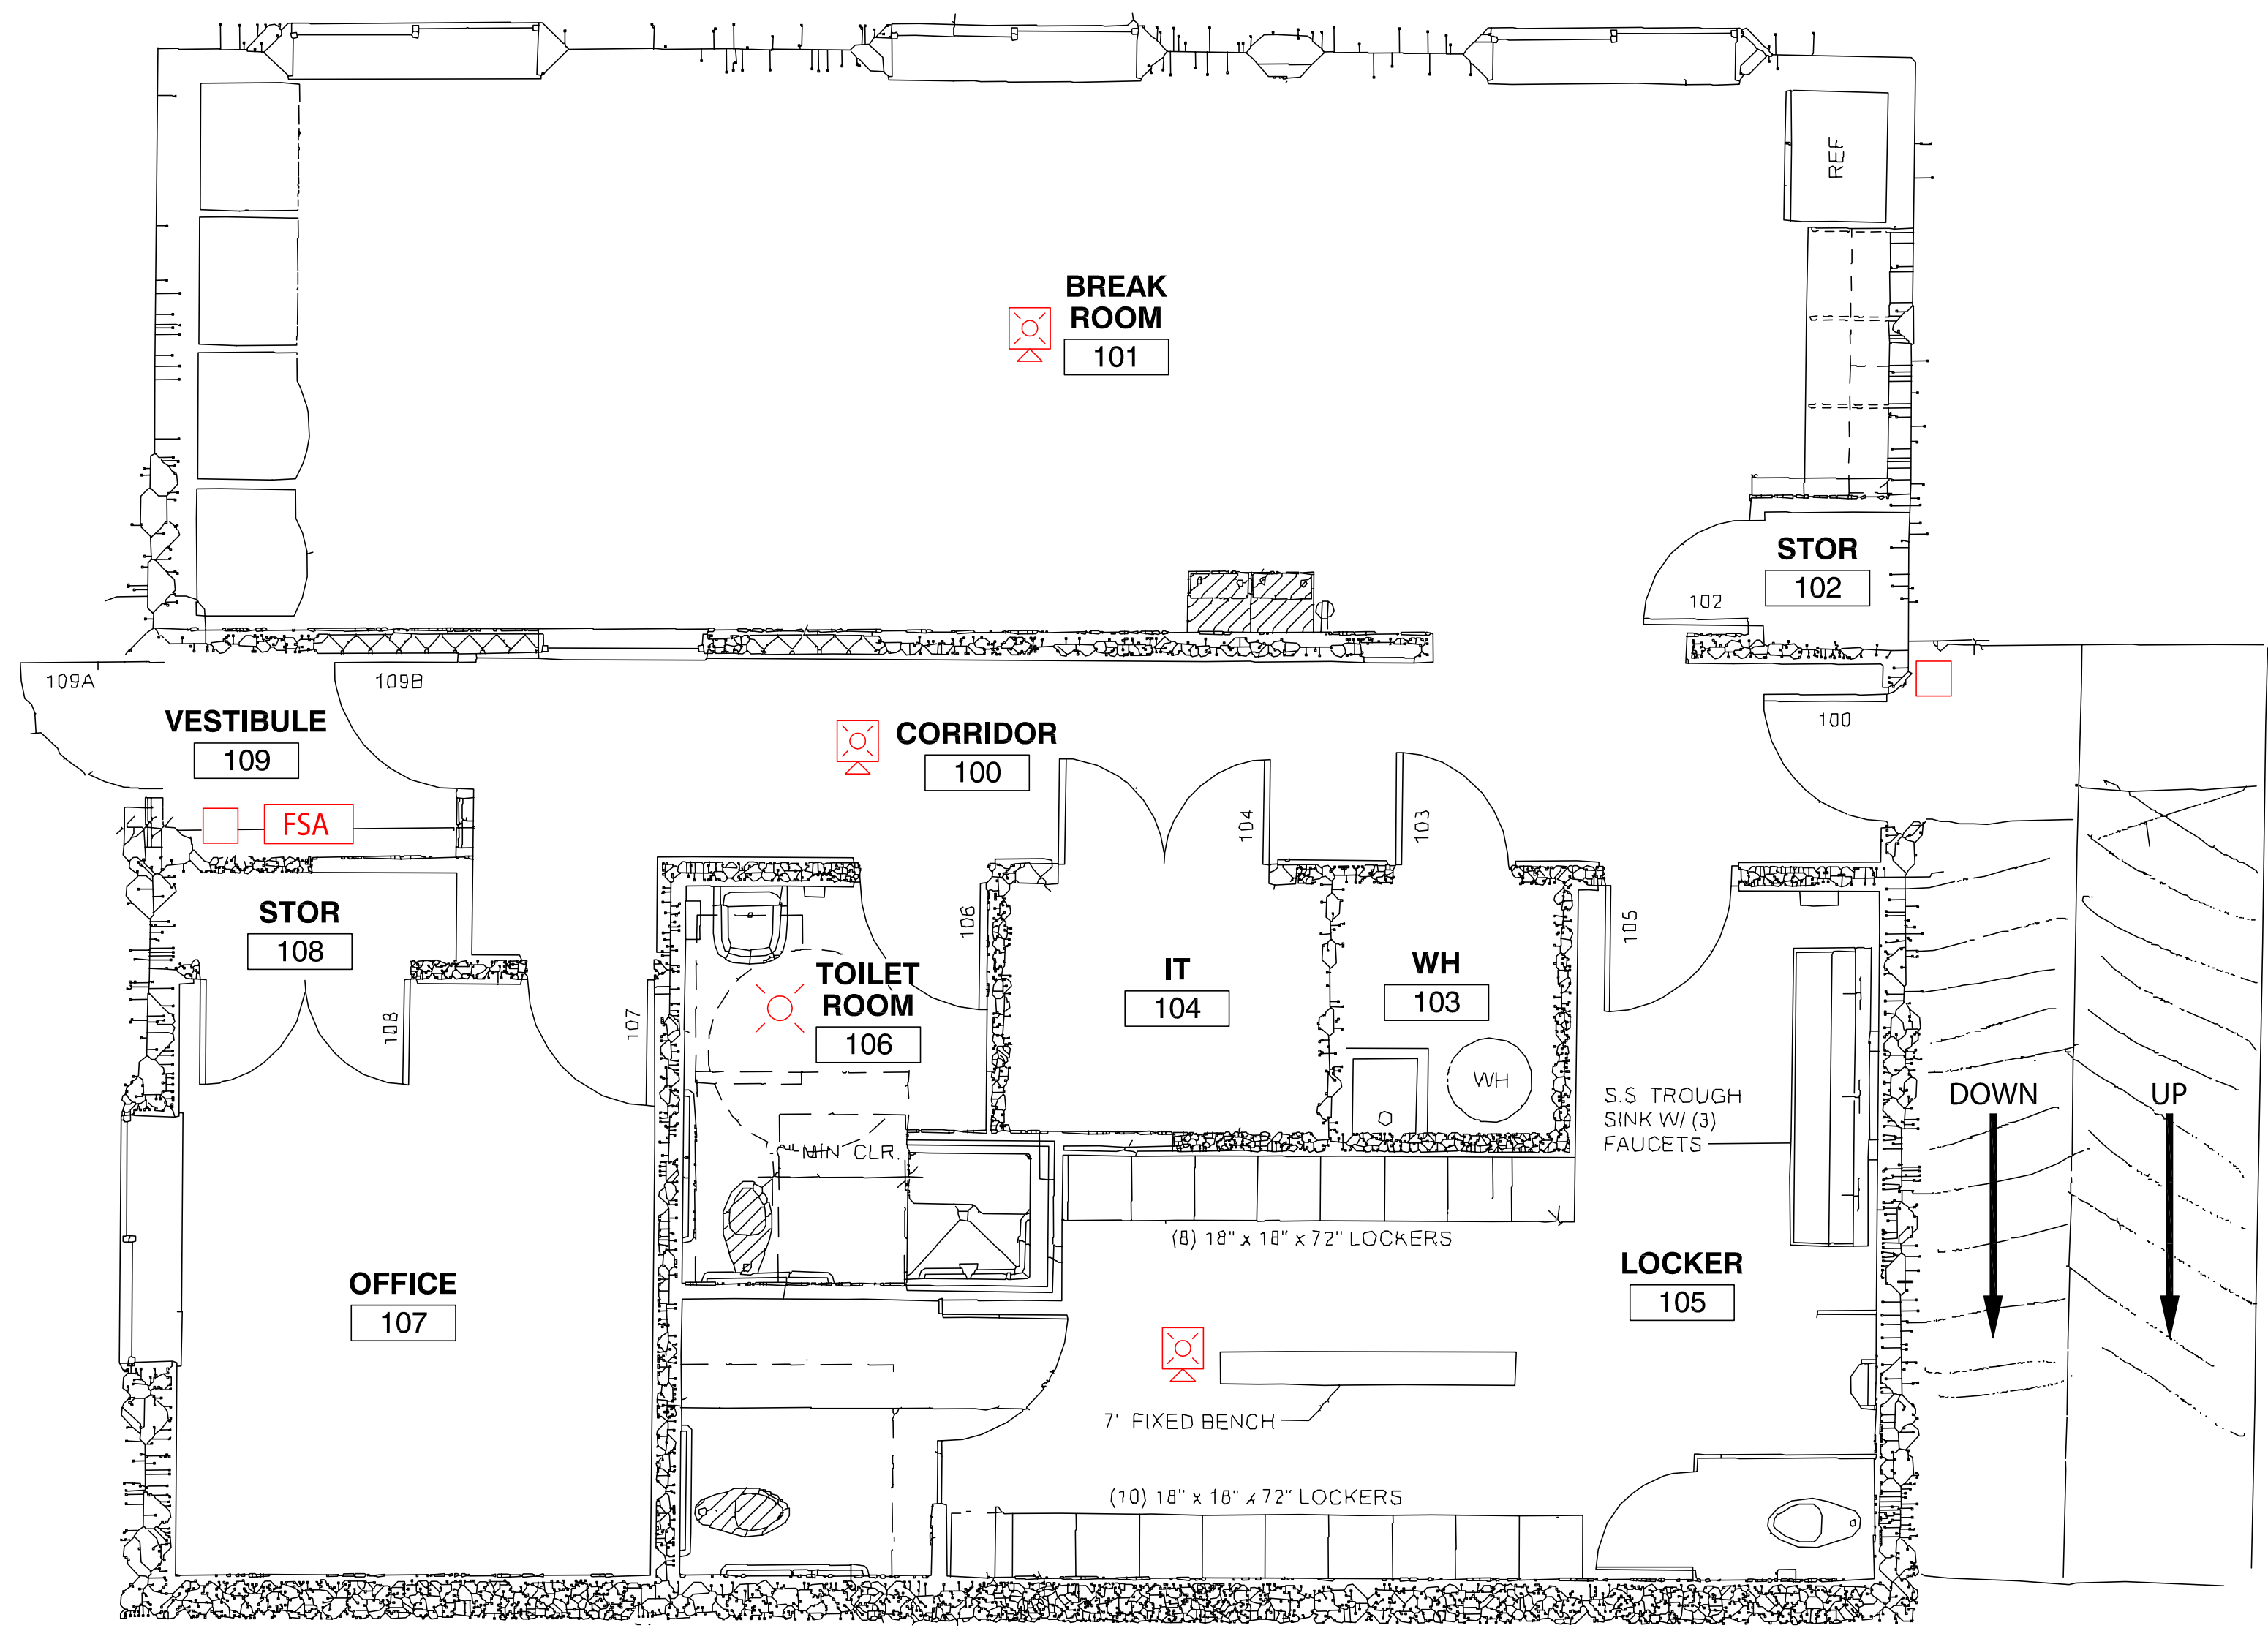

PROPOSAL
 NOT TO BE USED
 FOR CONSTRUCTION

© 2013 Securadyne Systems. All rights reserved. This drawing may not be reproduced, displayed, modified or distributed without the express prior written permission of the copyright holder.

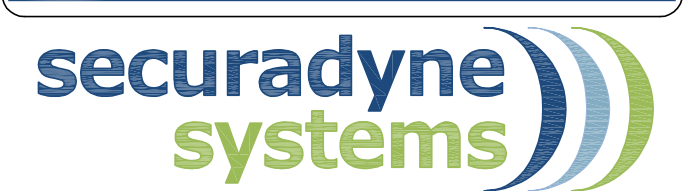

NE Reg Wilmington, MA Office
 600 Research Drive
 Wilmington, MA 01887
 Toll Free: 800-544-2616
 Fax: 978-688-9119
 In State: 978-688-4444

NE Reg Portland, ME Office
 4 Thomas Drive, Suite 5
 Westbrook, ME 04092
 Toll Free: 888-826-6567
 Fax: 207-828-0044
 In State: 207-828-0022

Client Name and Address

ecomaine

**64 BLUEBERRY ROAD
 PORTLAND, MAINE**

Drawing Title



**FIRE PROTECTION
 SYSTEM DESIGN
 PROPOSAL-
 OFFICE/BREAK AREA**

	Name	Date
Drawn By	RAB	06/17/13
Scale	NONE	

Securadyne Proposal No.

Securadyne Drawing No.

ECOMAINE-OFFICE

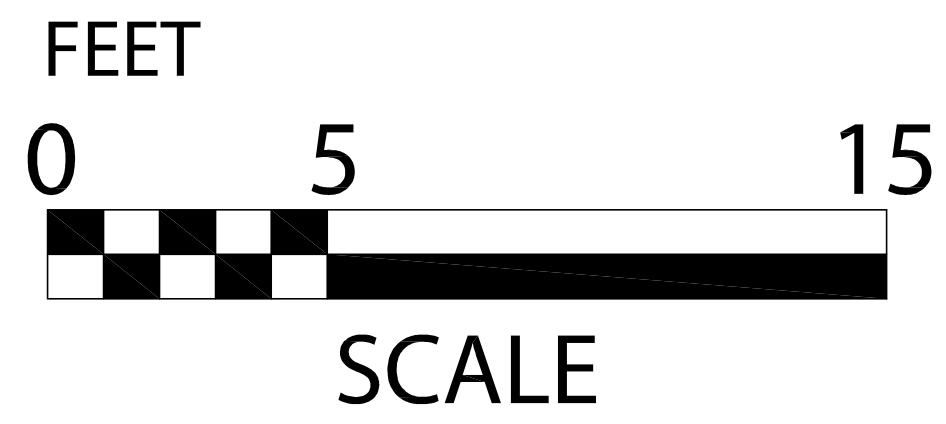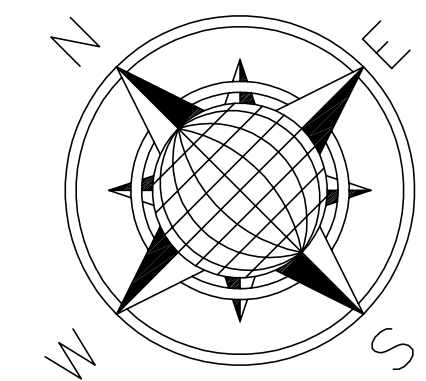

10

9

8

7

6

5

4

3

2

1 SHEET 1 OF 1