

10

9

8

7

6

5

4

3

2

1

F

E

D

C

B

A

F


E

D

C

B




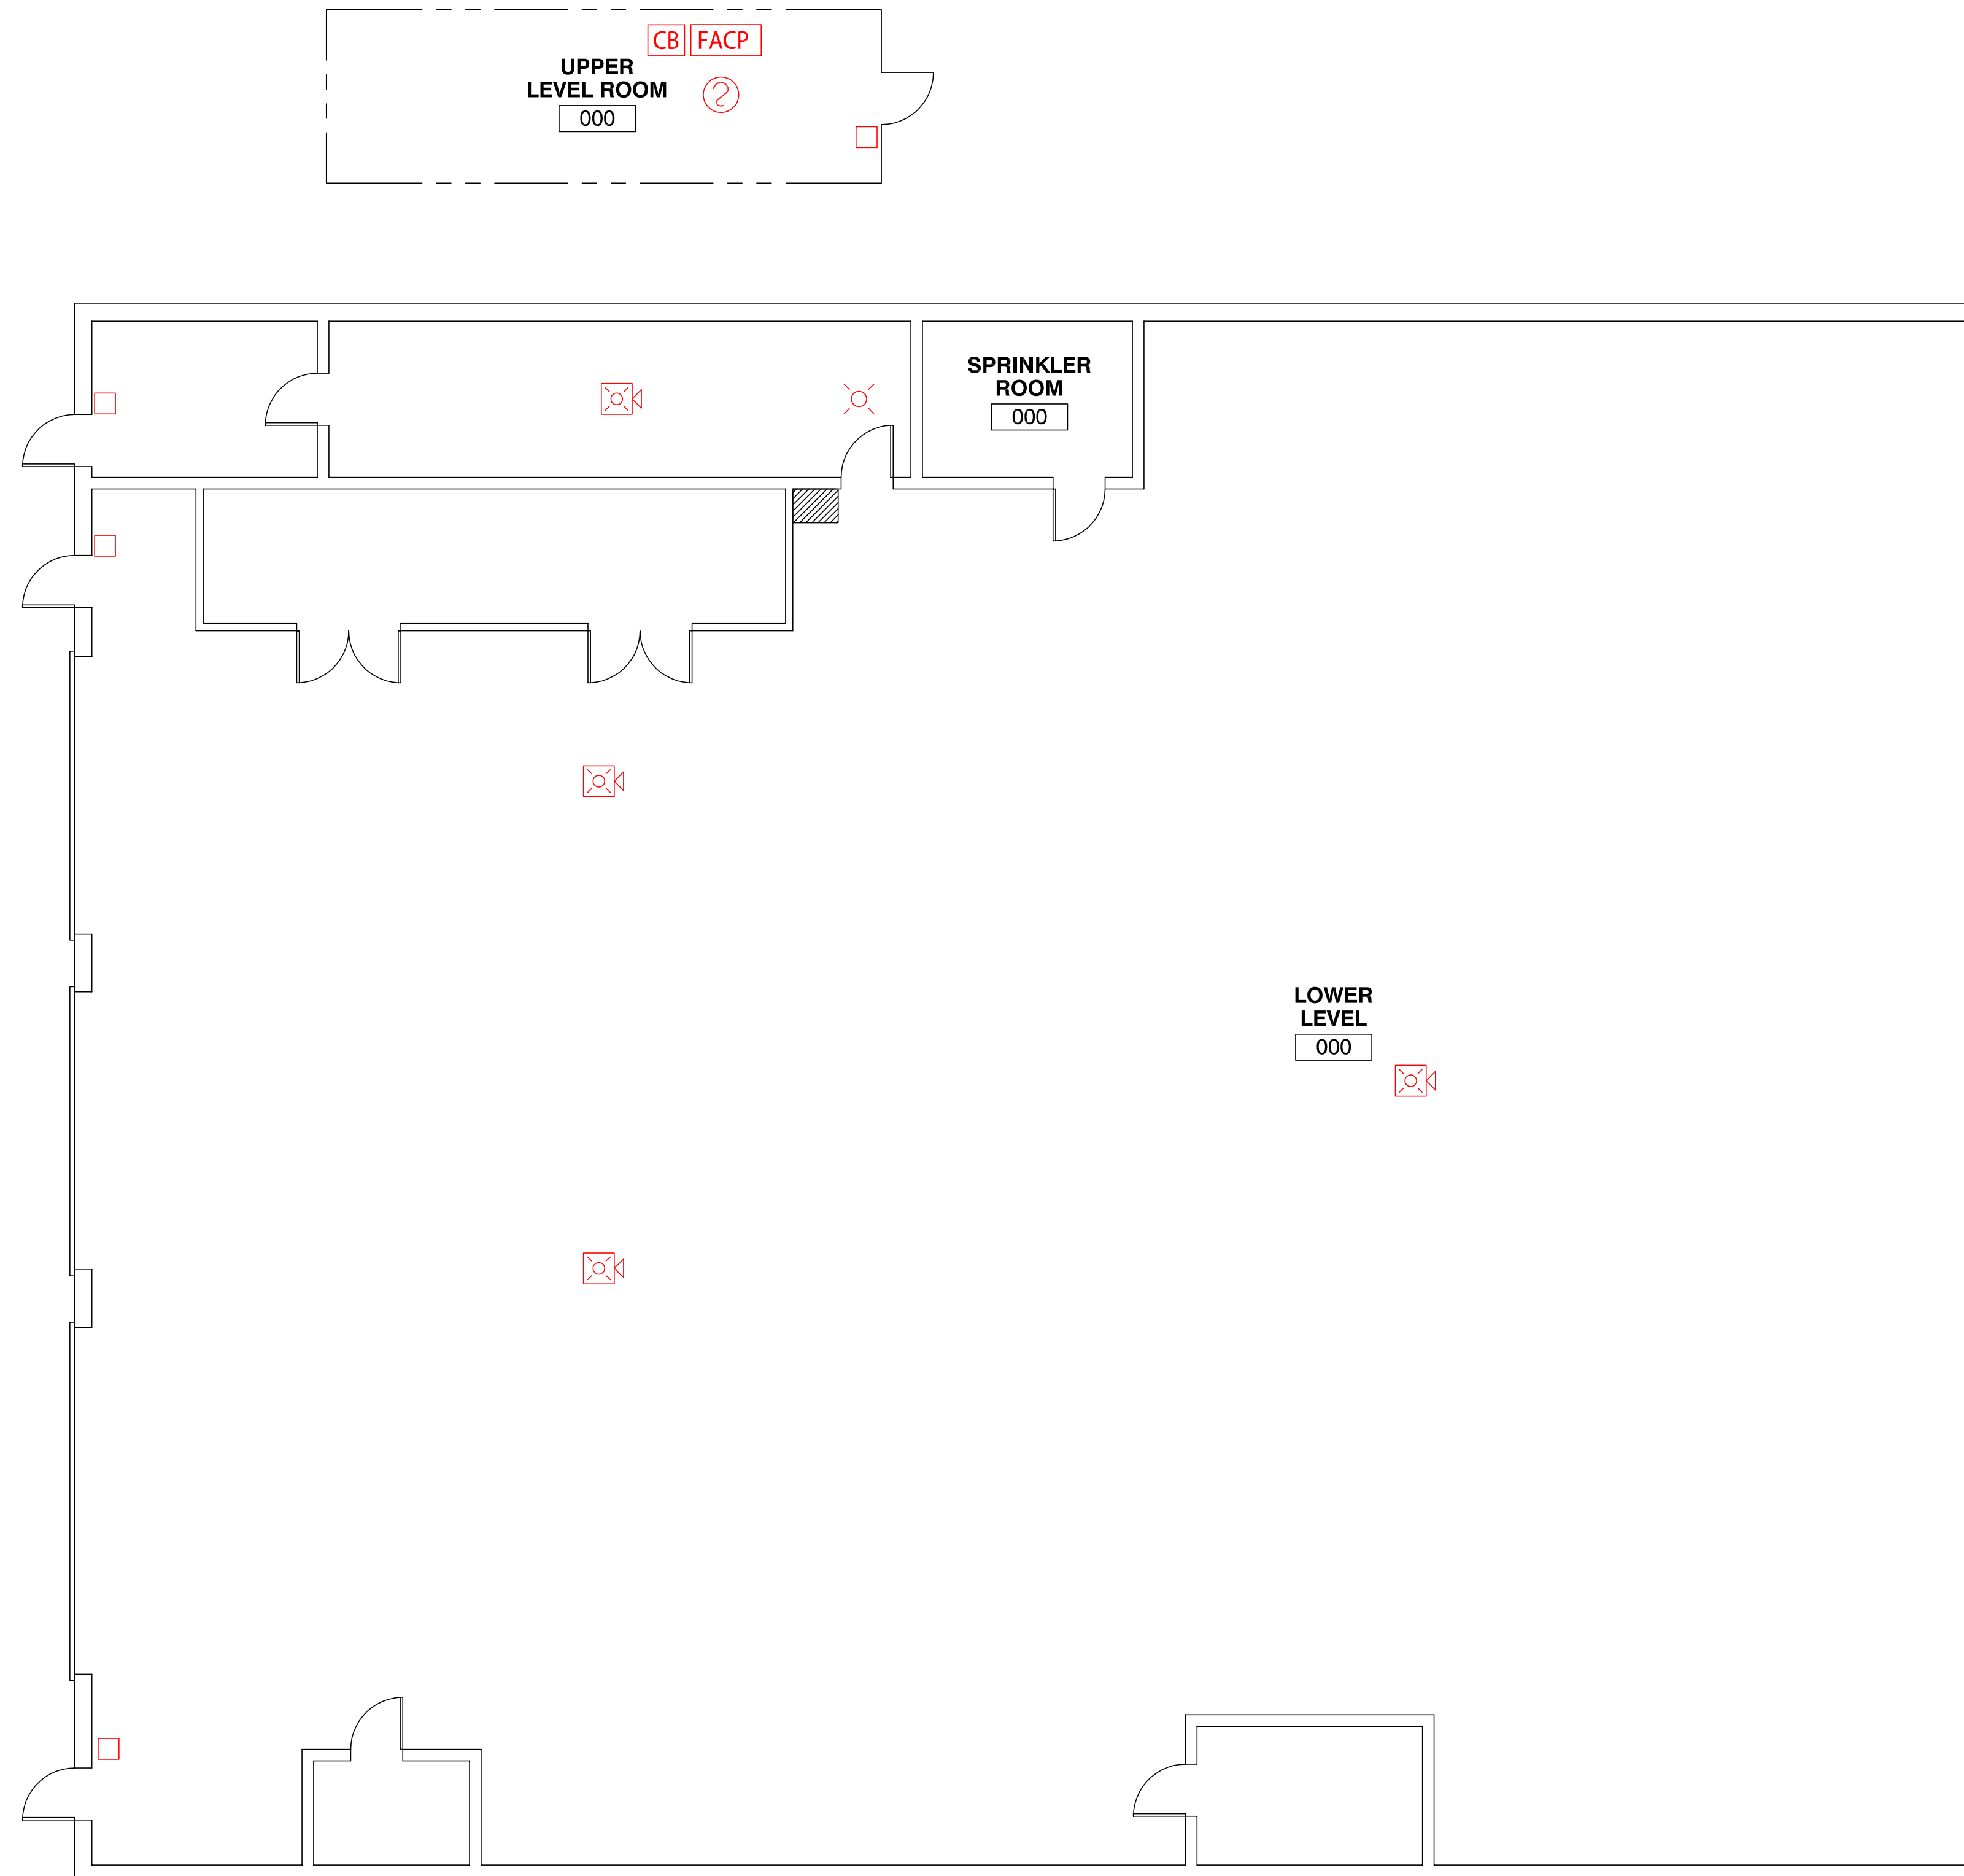



A

 

General Notes


WARNING: This document contains sensitive security information and intellectual property that is the work, product and property of Securadyne Systems, LLC. and intended for use only as part of a working relationship with our customer. If the confidentiality of this document and the information it contains cannot be assured, please discontinue use and notify Securadyne Systems, LLC. immediately.

LEGEND

-  PULL STATION
-  HORN WITH STROBE, CEILING
-  STROBE, CEILING
-  SMOKE DETECTOR
-  FIRE ALARM PANEL
-  FIRE ALARM SYSTEM ANNUNCIATOR
-  CITY BOX

PROPOSAL
NOT TO BE USED
FOR CONSTRUCTION

© 2013 Securadyne Systems. All rights reserved.
This drawing may not be reproduced, displayed,
modified or distributed without the express prior
written permission of the copyright holder.

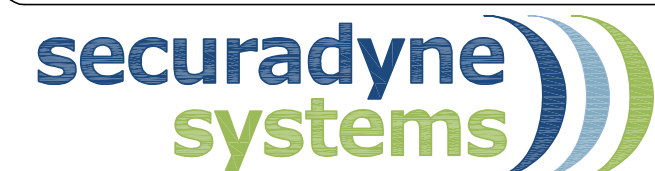

NE Reg Wilmington, MA Office
600 Research Drive
Wilmington, MA 01887
Toll Free: 800-254-2616
Fax: 978-688-9119
In State: 978-688-4444

NE Reg Portland, ME Office
4 Thomas Drive, Suite 5
Westbrook, ME 04092
Toll Free: 888-836-8567
Fax: 207-828-0044
In State: 207-828-0022

Client Name and Address

ecomaine
64 BLUEBERRY ROAD
PORTLAND, MAINE



Drawing Title

**FIRE PROTECTION
SYSTEM DESIGN
PROPOSAL-
WAREHOUSE 2**

	Name	Date
Drawn By	RAB	06/17/13
Scale	NONE	

Securadyne Proposal No.

Securadyne Drawing No.
ECOMAINE-WH2

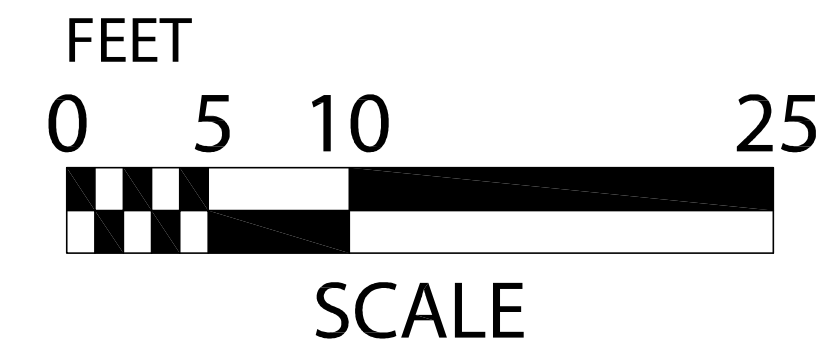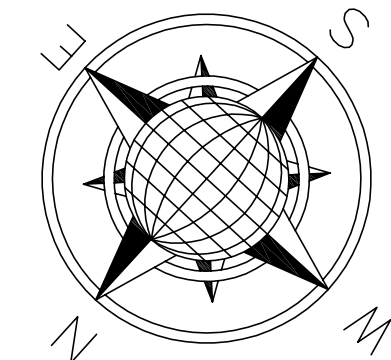

10

9

8

7

6

5

4

3

2

1 SHEET 1 OF 1