

LOAD DESCRIPTION	AMP	POLE	DWG. CRKT. NO.	POLE	WATTS	WATT LOADS			WATTS	L.C. NO.	DWG. CRKT. NO.	POLE	AMP	LOAD DESCRIPTION
						PH A	PH B	PH C						
TUB 1 OF 1 - REMARKS:														
TRANSFORMER	200	3	1	1	101868	91265	---	---	67050	2	2	3	225	HVAC-1
	-	-	-	3	---	90657	---	---		4	-	-	-	
	-	-	-	5	---	---	---	86996		6	-	-	-	
ELEVATOR (FUTURE)	70	3	7	7	0	0	---	---	0	8	-	3	100	SPACE
	-	-	-	9	---	0	---	---		10	-	-	-	
	-	-	-	11	---	---	---	0		12	-	-	-	
SPACE	200	3	-	13	0	0	---	---	0	14	14	3	100	SPACE
	-	-	-	15	---	0	---	---		16	-	-	-	
	-	-	-	17	---	---	---	0		18	-	-	-	
SPACE	200	3	19	19	0	0	---	---		20	-	-	-	
	-	-	-	21	---	5000	---	10000		22	22	2	30	WATER HEATER
	-	-	-	23	---	---	---	5000		24	-	-	-	
TOTAL AMPS:335.5					91265	95657	91996	TOTAL WATTS:278918						
REMARKS:														



Architects + Engineers
HARRIMAN ASSOCIATES

One Ashura Business Park
Ashura, Maine 04210
207.784.5100 tel
207.783.3017 fax
www.harriman.com
Building communities
since 1870
© 2006

Project Title
**WOODARD & CURRAN
OFFICE ADDITION**

PORTLAND, MAINE

HA Project No. **05178**

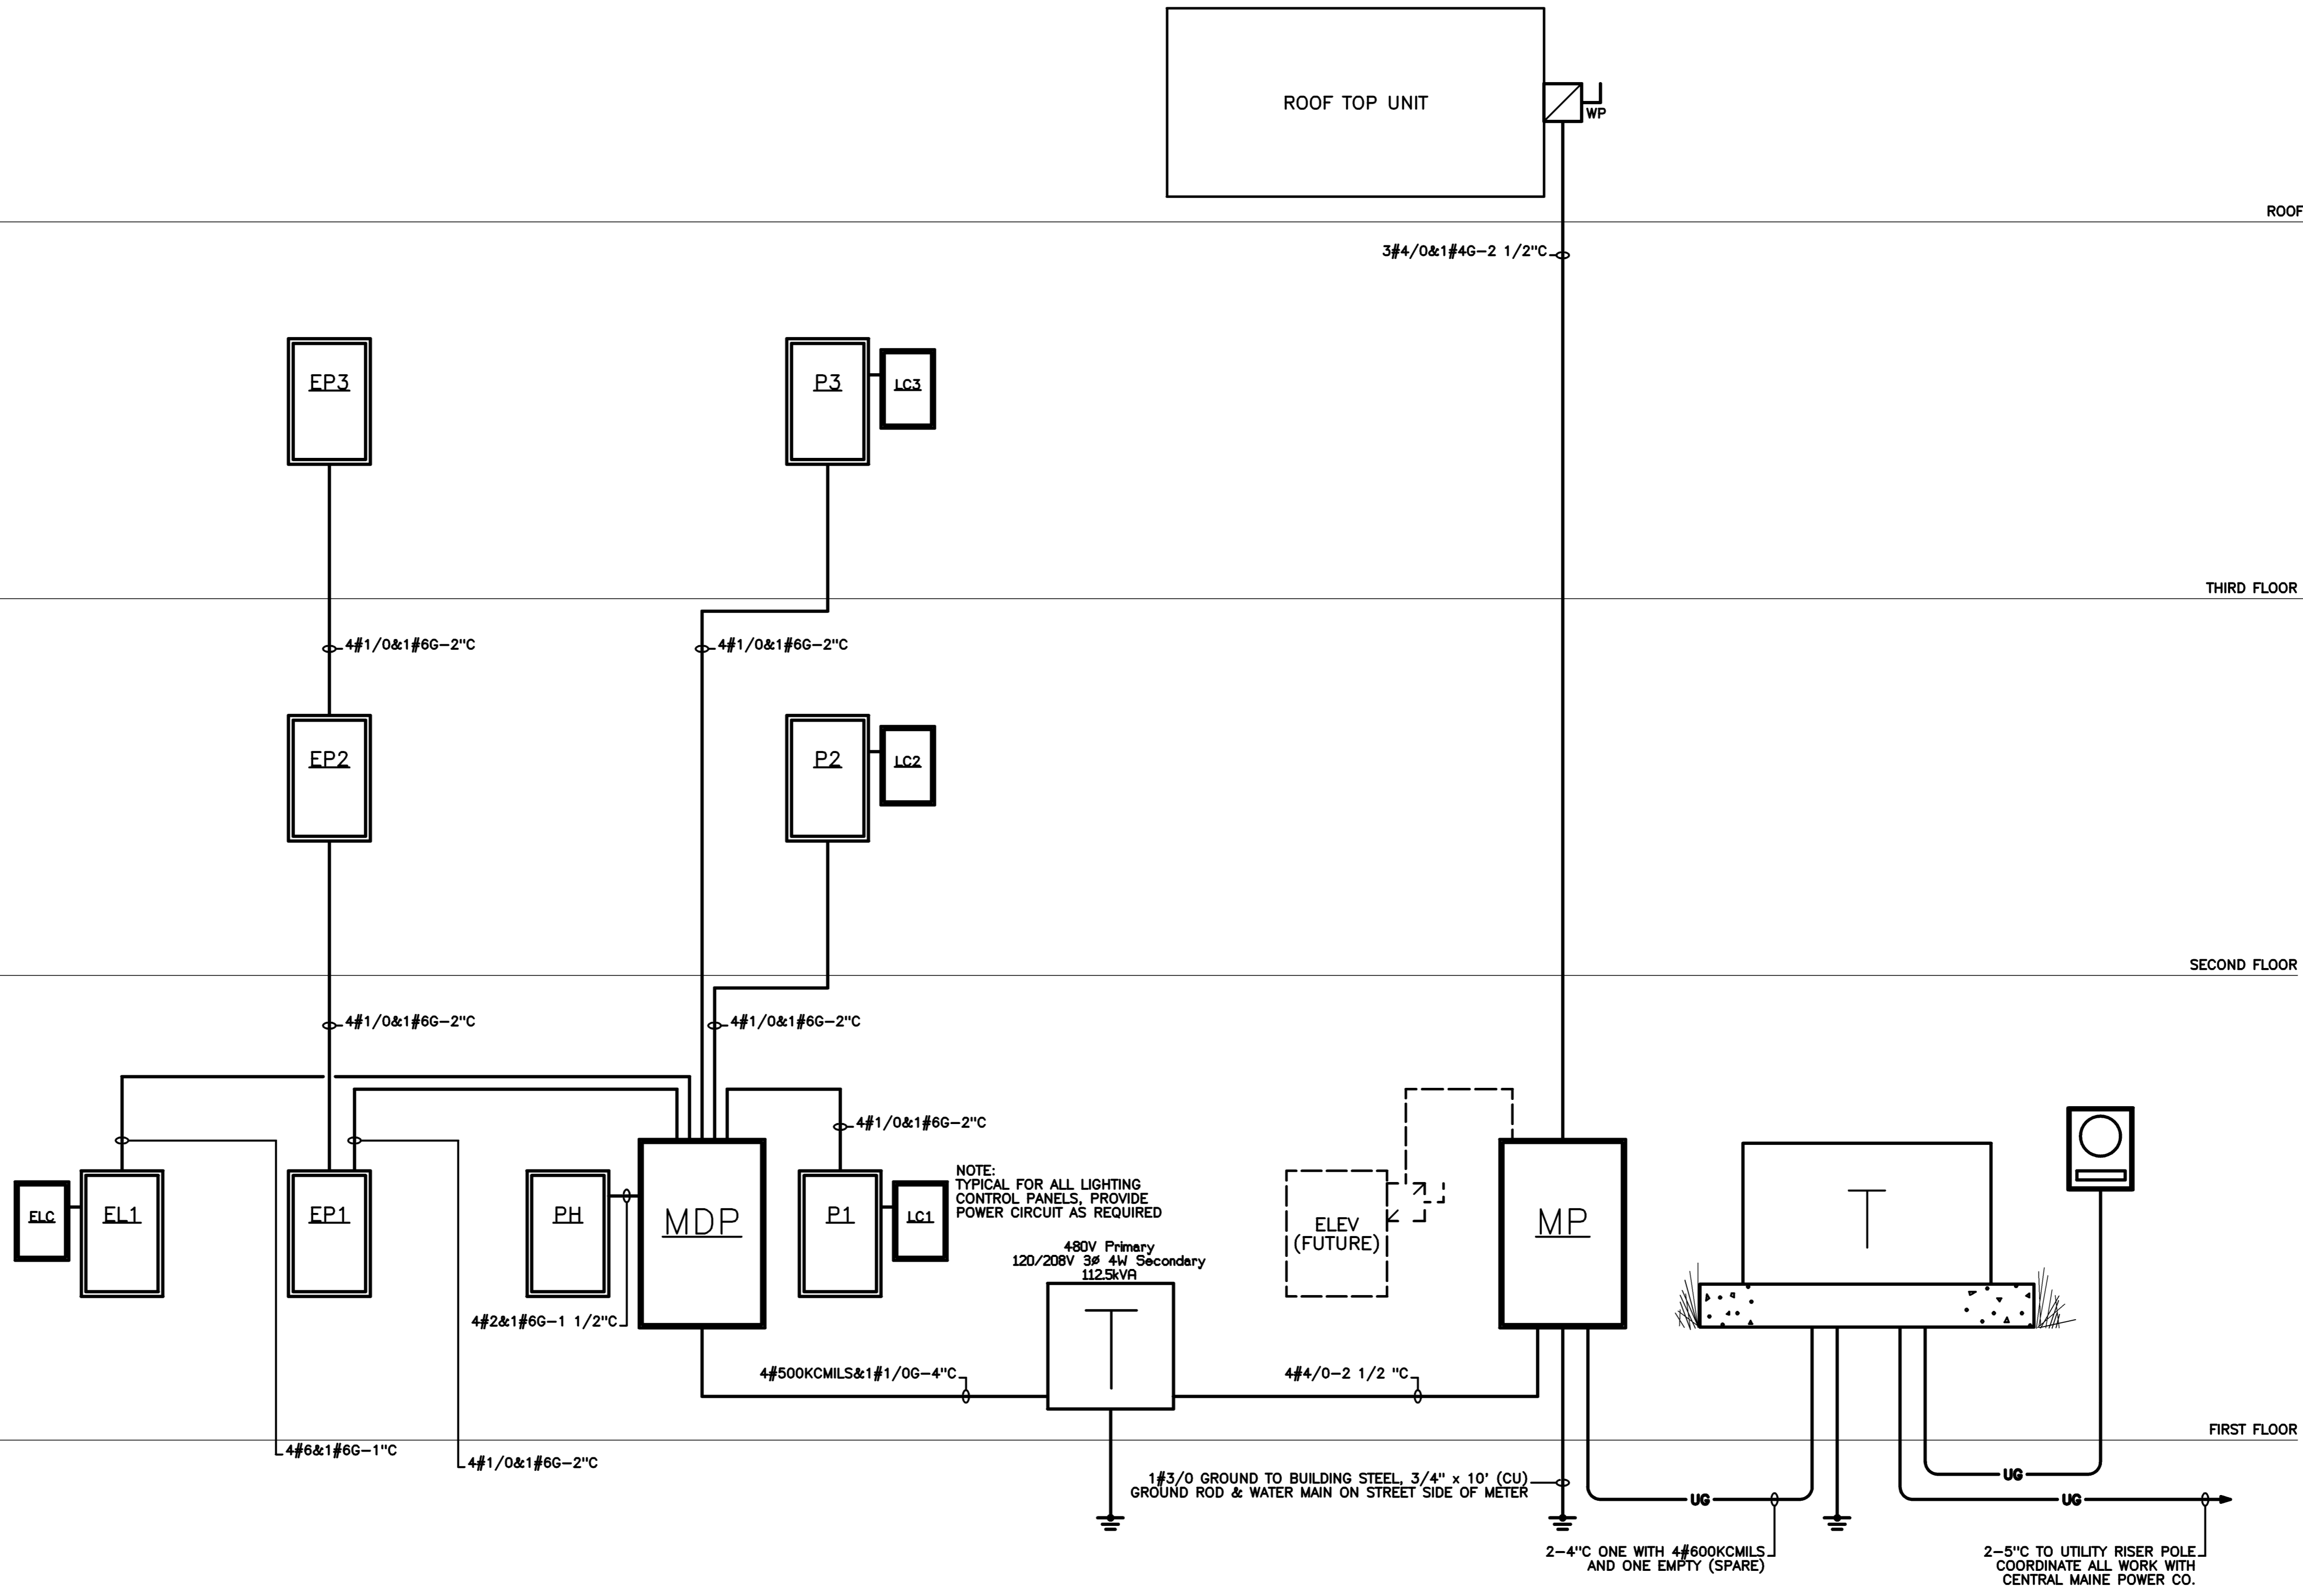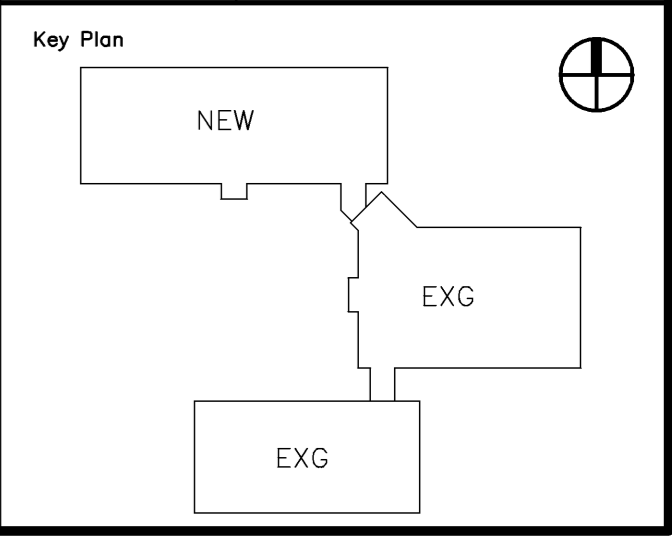

Issue Dates		
-	05-15-06	ISSUED FOR CONSTRUCTION
-	03-14-06	FINAL REVIEW
-	02-03-06	DD REVIEW
Mark	Date	Description

Drawing Status	
Drawing Title	POWER RISER DIAGRAM
PA / PE:	JWT
Drawn By:	JWT
Drawing Number	E30.1