


WORKSTATION DETAIL

1/2" = 1'-0" 0 1' 2' 3' REF: NA


A4

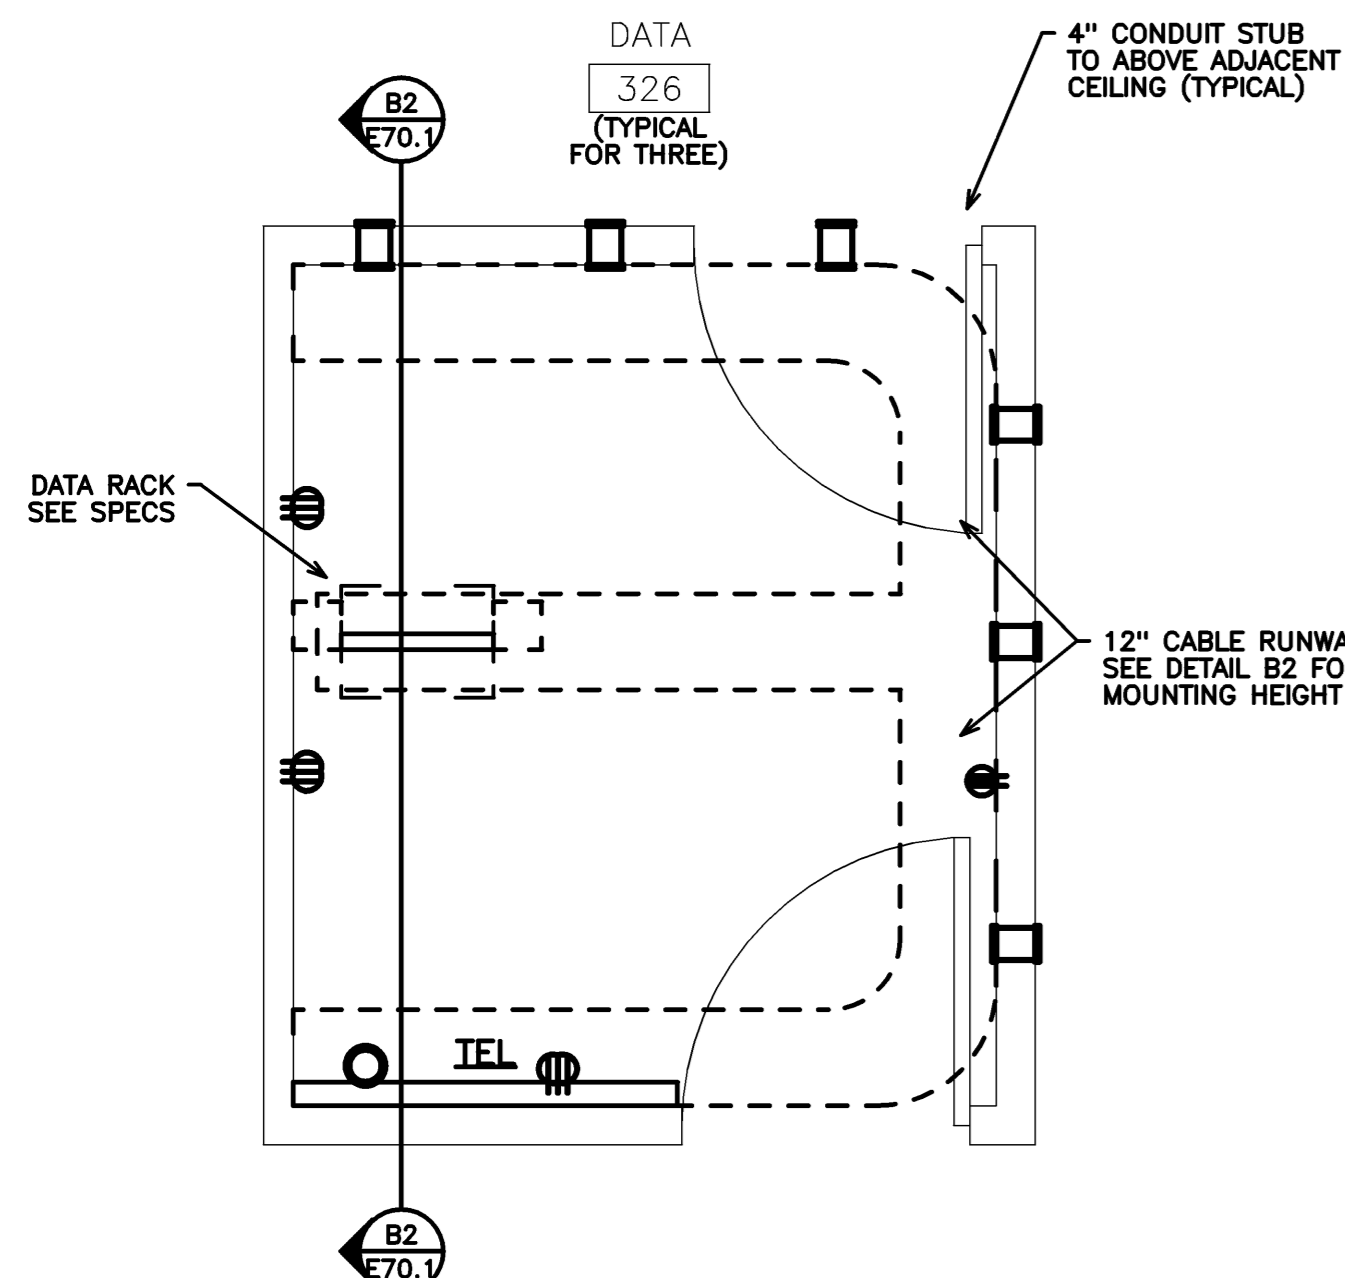

DATA ROOM ENLARGED PLAN

1/2" = 1'-0" 0 1' 2' 3' REF: NA


B4

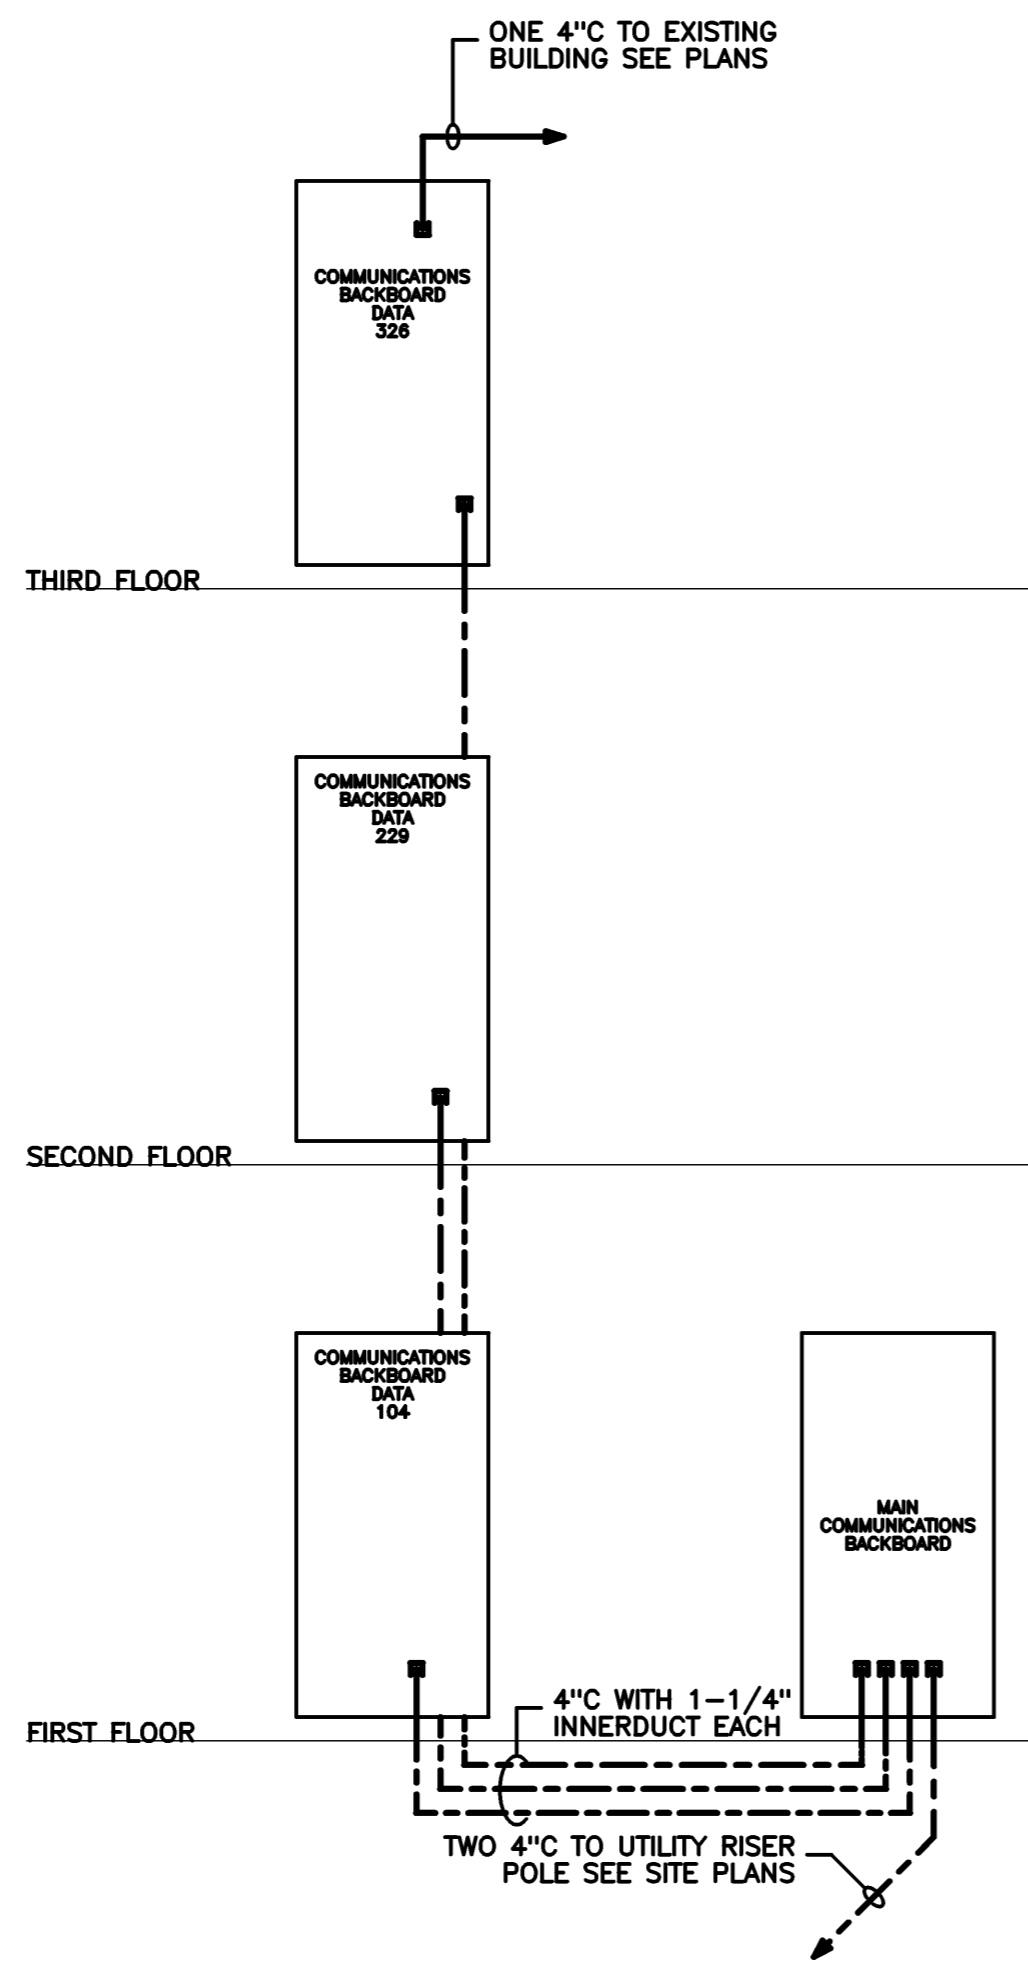

TELEPHONE / DATA RISER

NO SCALE REF: NA


B3

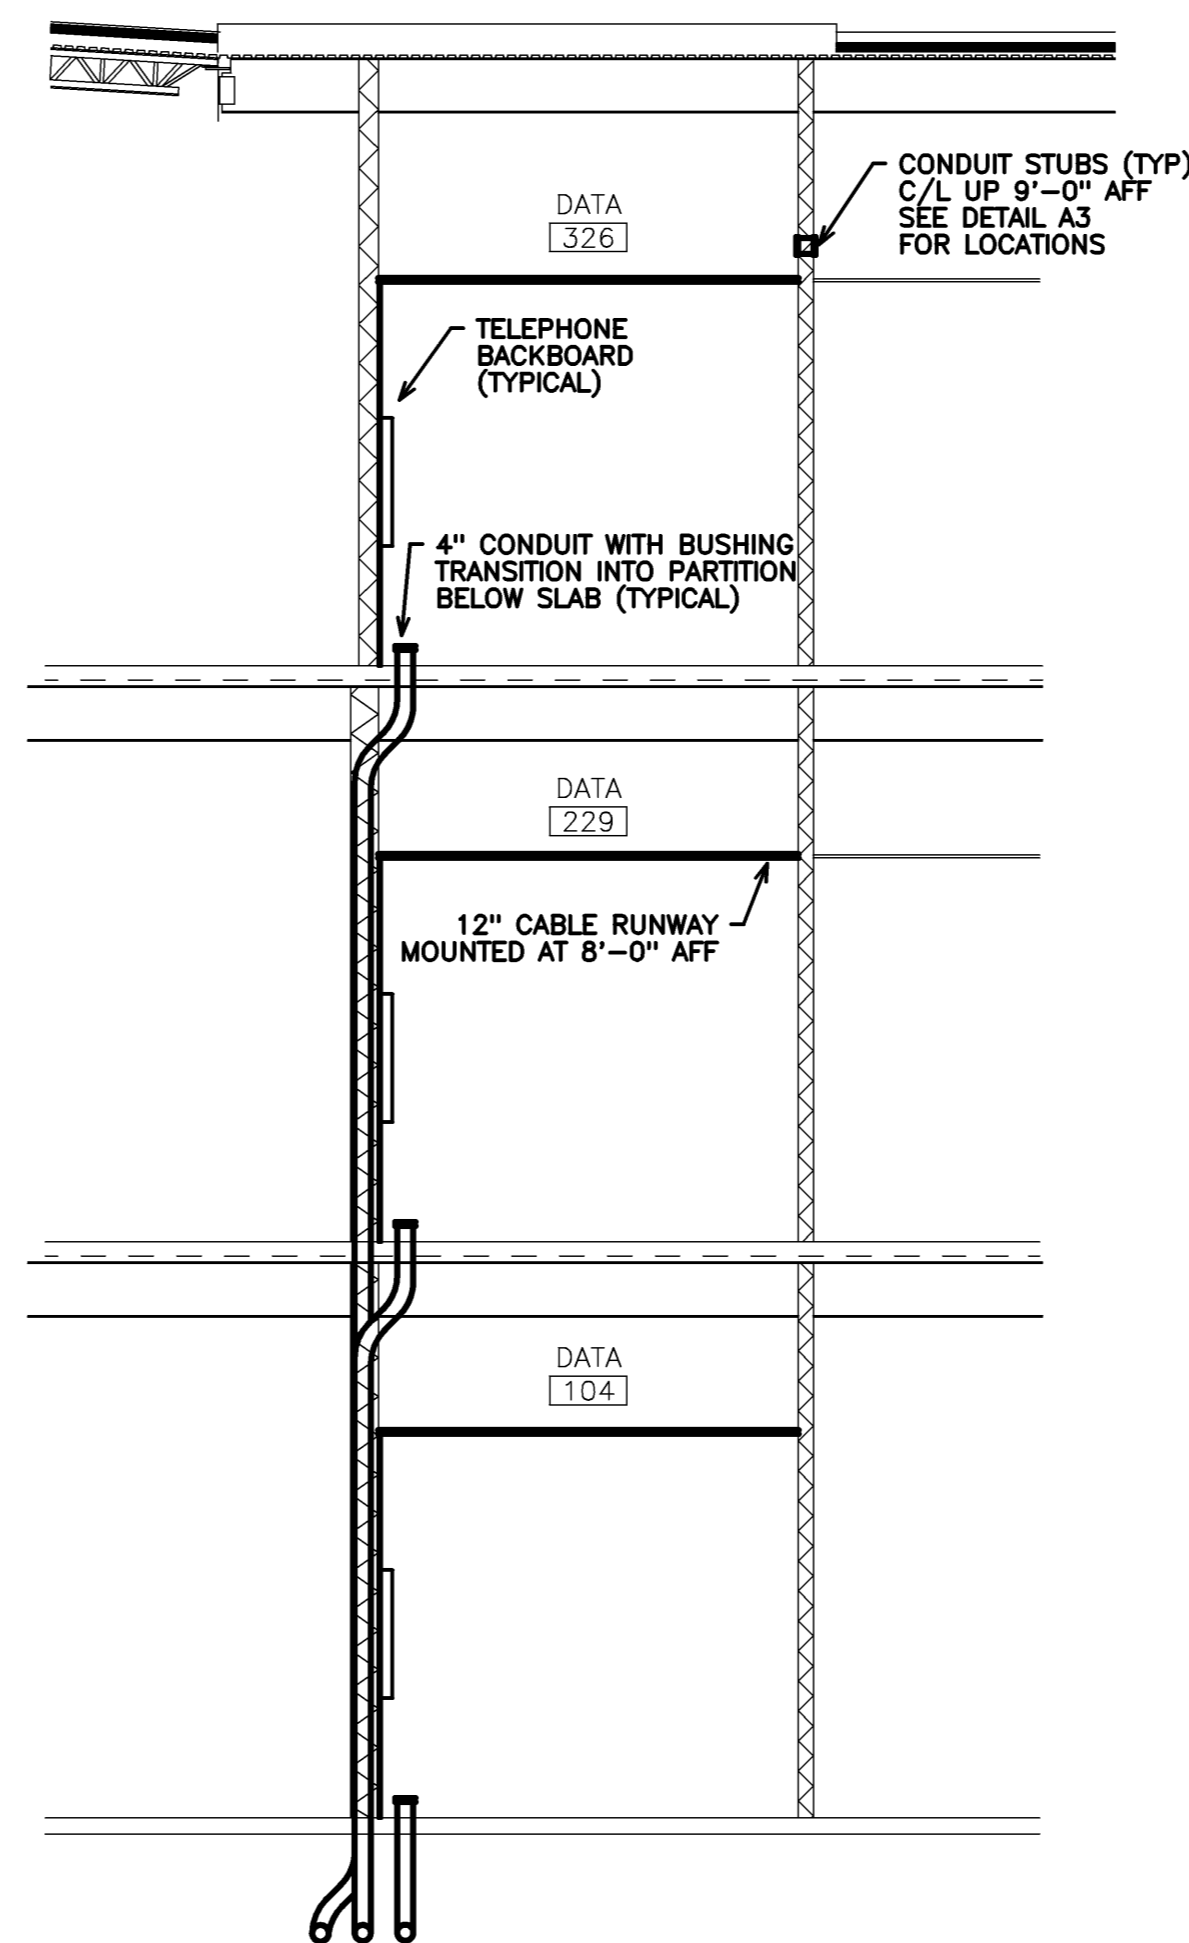

DATA ROOM ELEVATIONS

NO SCALE REF: NA


B2

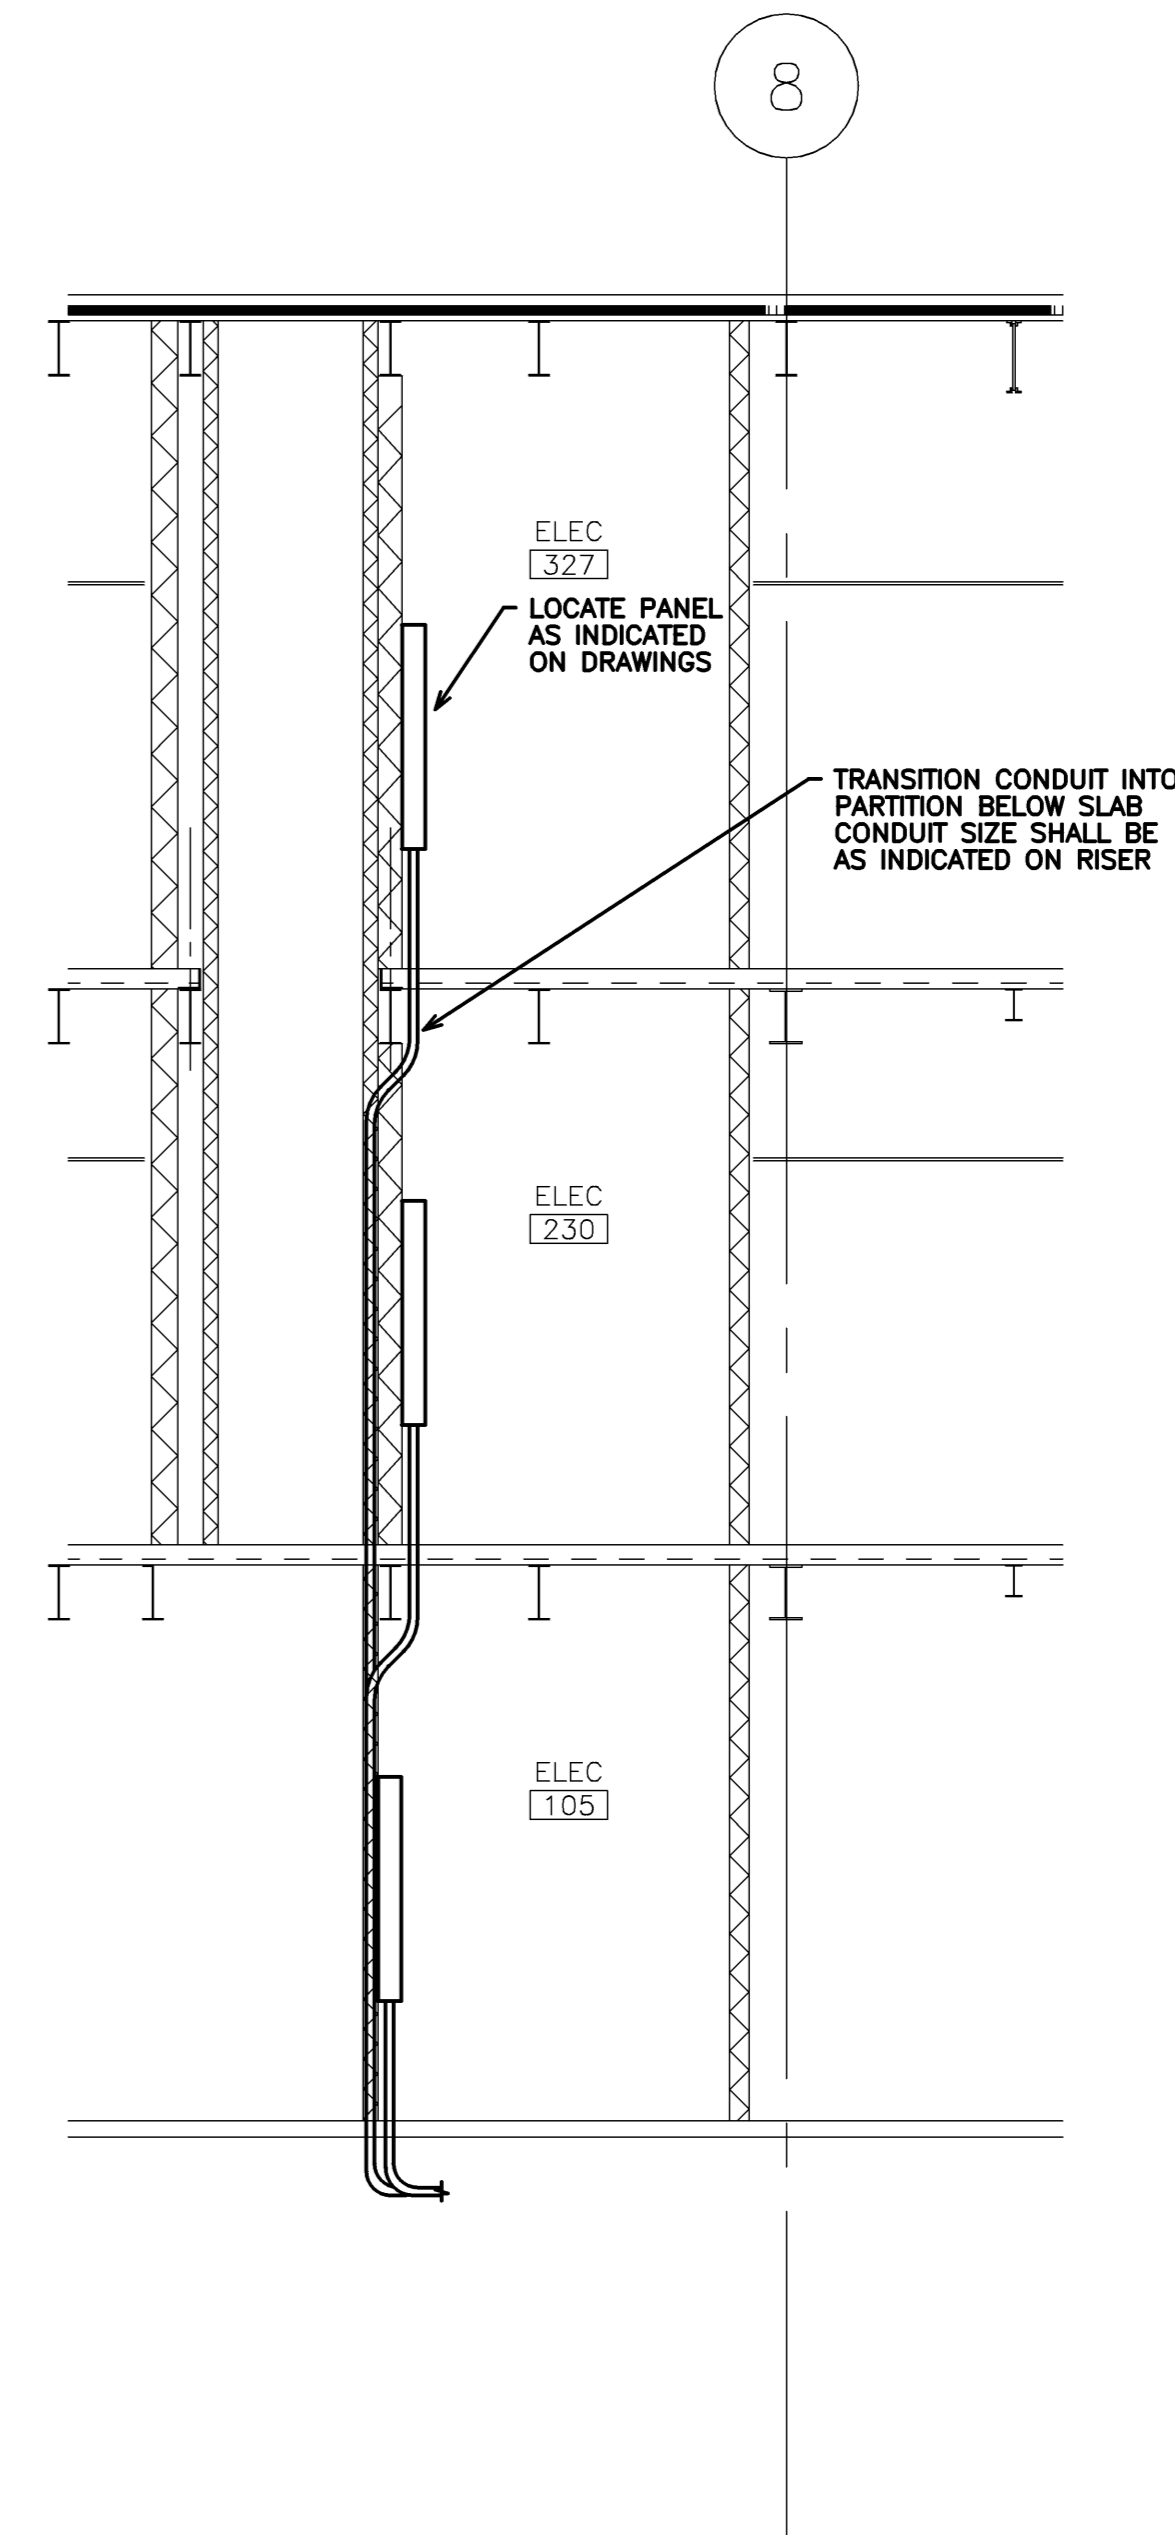

ELEC ROOM ELEVATIONS

NO SCALE REF: NA

B1

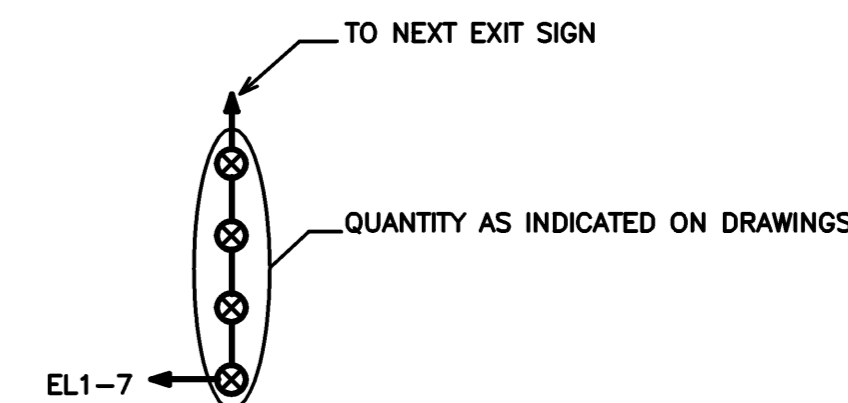

NOTE: WIRE ALL EXIT SIGNS TO EL1-7

EXIT SIGN WIRING

NO SCALE REF: NA

C1

NOT USED

1/8" = 1'-0" 0 4' 8' 12' REF: NA

C4

NOT USED

 

1/8" = 1'-0" 0 4' 8' 12' REF: NA

C3

NOT USED

1/8" = 1'-0" 0 4' 8' 12' REF: NA

C2

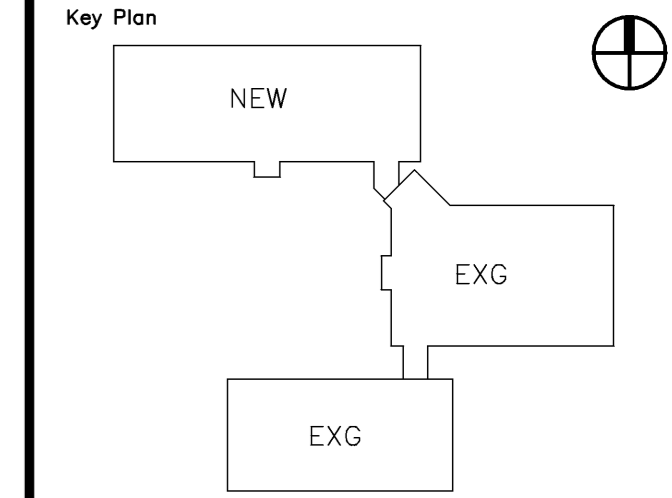

Mark	Date	Description
-	05-15-06	ISSUED FOR CONSTRUCTION
-	03-14-06	FINAL REVIEW

Issue Dates

Drawing Status

Drawing Title
DETAILS

PA / PE: **JWT** Drawn By: **JWT**

Drawing Number

E70.1