






Reviewed for Code Compliance
Inspection Division
Approved with Conditions

Date: 06/18/13

NOTES:

- 1) REUSE EXISTING CIRCUITING FOR NEW LAYOUT
- 2) FINAL PANEL SCHEDULES WILL BE DONE AT COMPLETION

- A - 2X2 LED INDIRECT
- B - LED DOWNLIGHT
- B1 - LED WALL WASH
- B2 - DIMMABLE LED DOWNLIGHT

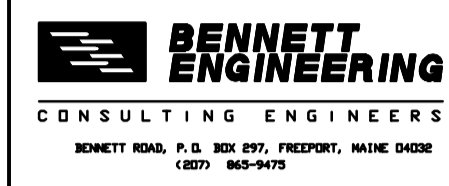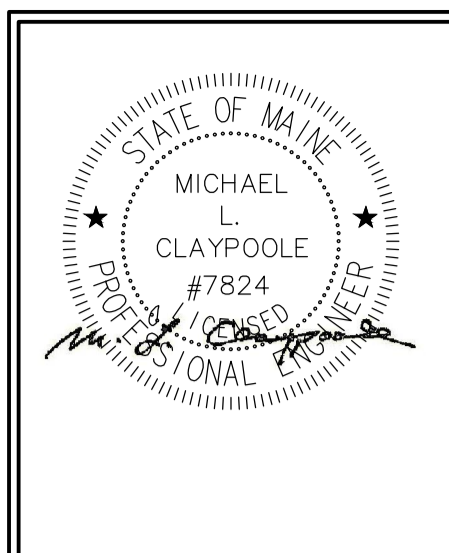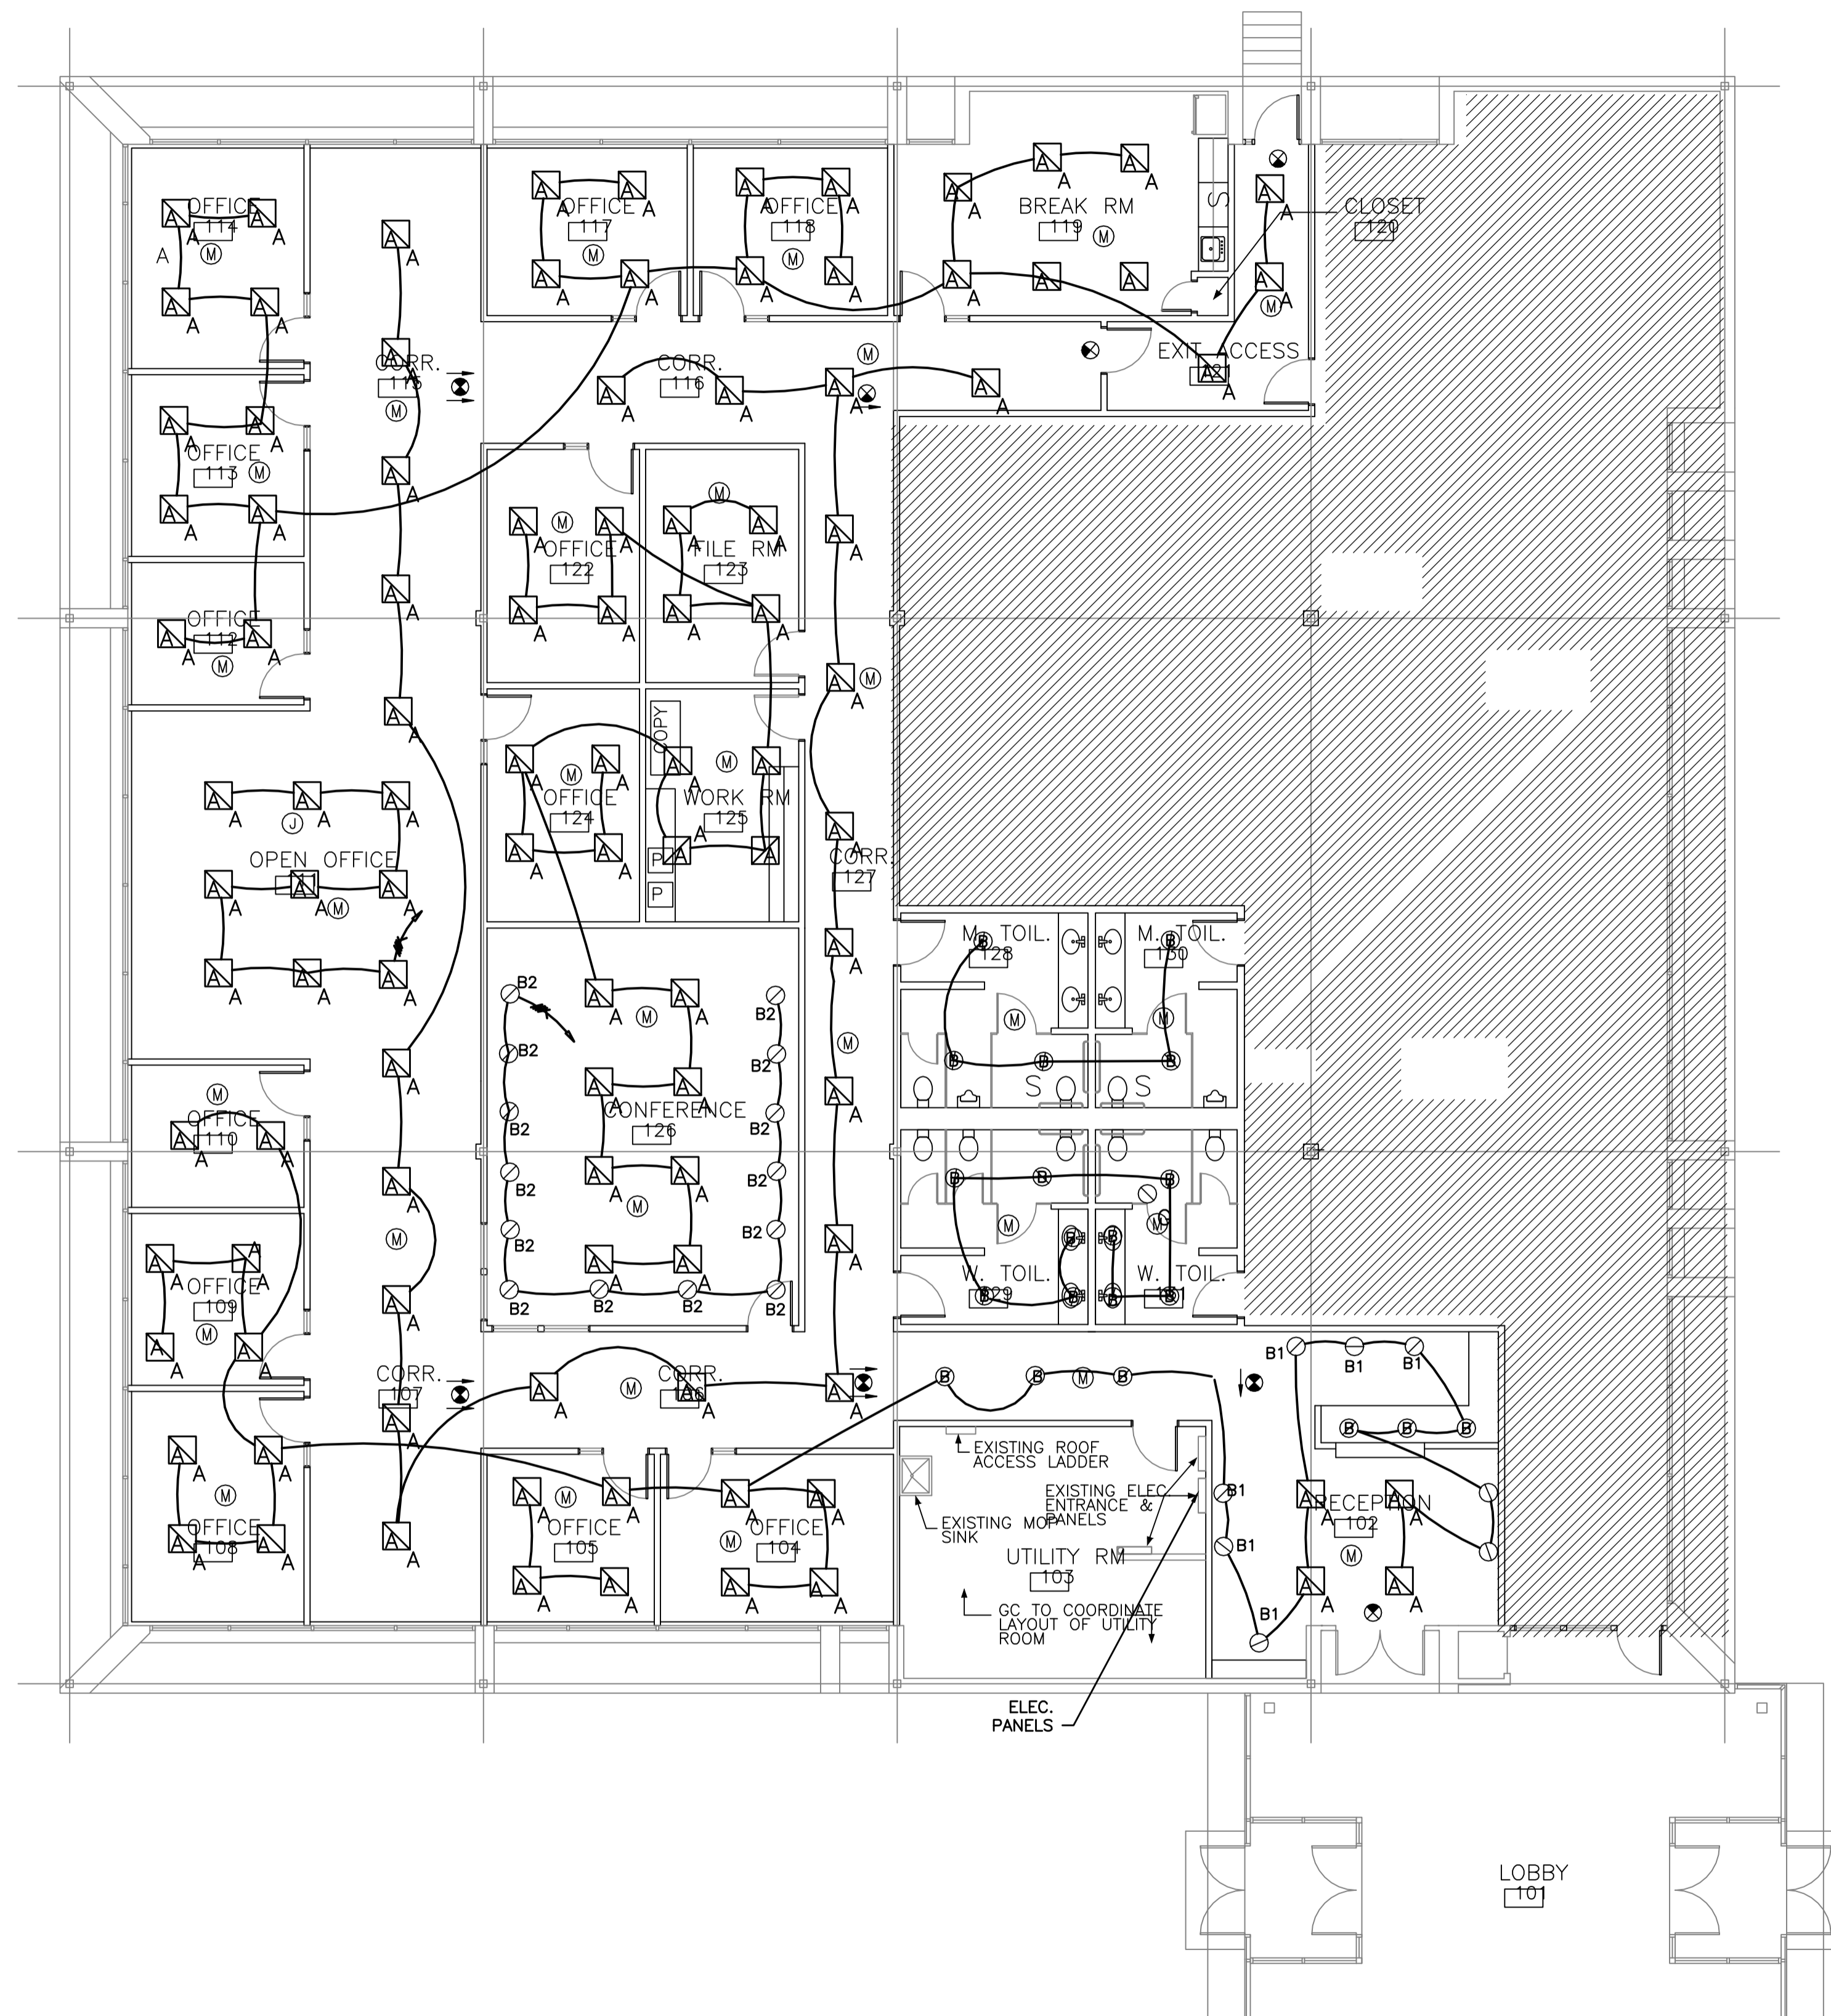

BH Milliken
ELECTRICAL CONTRACTORS
175 ANDERSON STREET
PORTLAND, MAINE 04101
PHONE 879-1877
FAX: 774-1492

CROSS INS.
CONGRESS STREET
PORTLAND, MAINE

| | |
|-------------|---------|
| TITLE | |
| LIGHTING | |
| SCALE: | SCALE |
| DATE: | 3-29-13 |
| SHEET | |
| E300 | |

FLOOR PLAN
1/8" = 1'-0"