

Project Title
**CROSS
 INSURANCE
 RENOVATIONS**
 2331 CONGRESS STREET
 Portland, Maine

GENERAL NOTES


03-24-13	PROGRESS DRAWING
----------	------------------

Mark	Date	Description
------	------	-------------

Issue Dates

Drawing Title
**MECHANICAL
 DUCTWORK PLAN**

Drawing Number
M-1

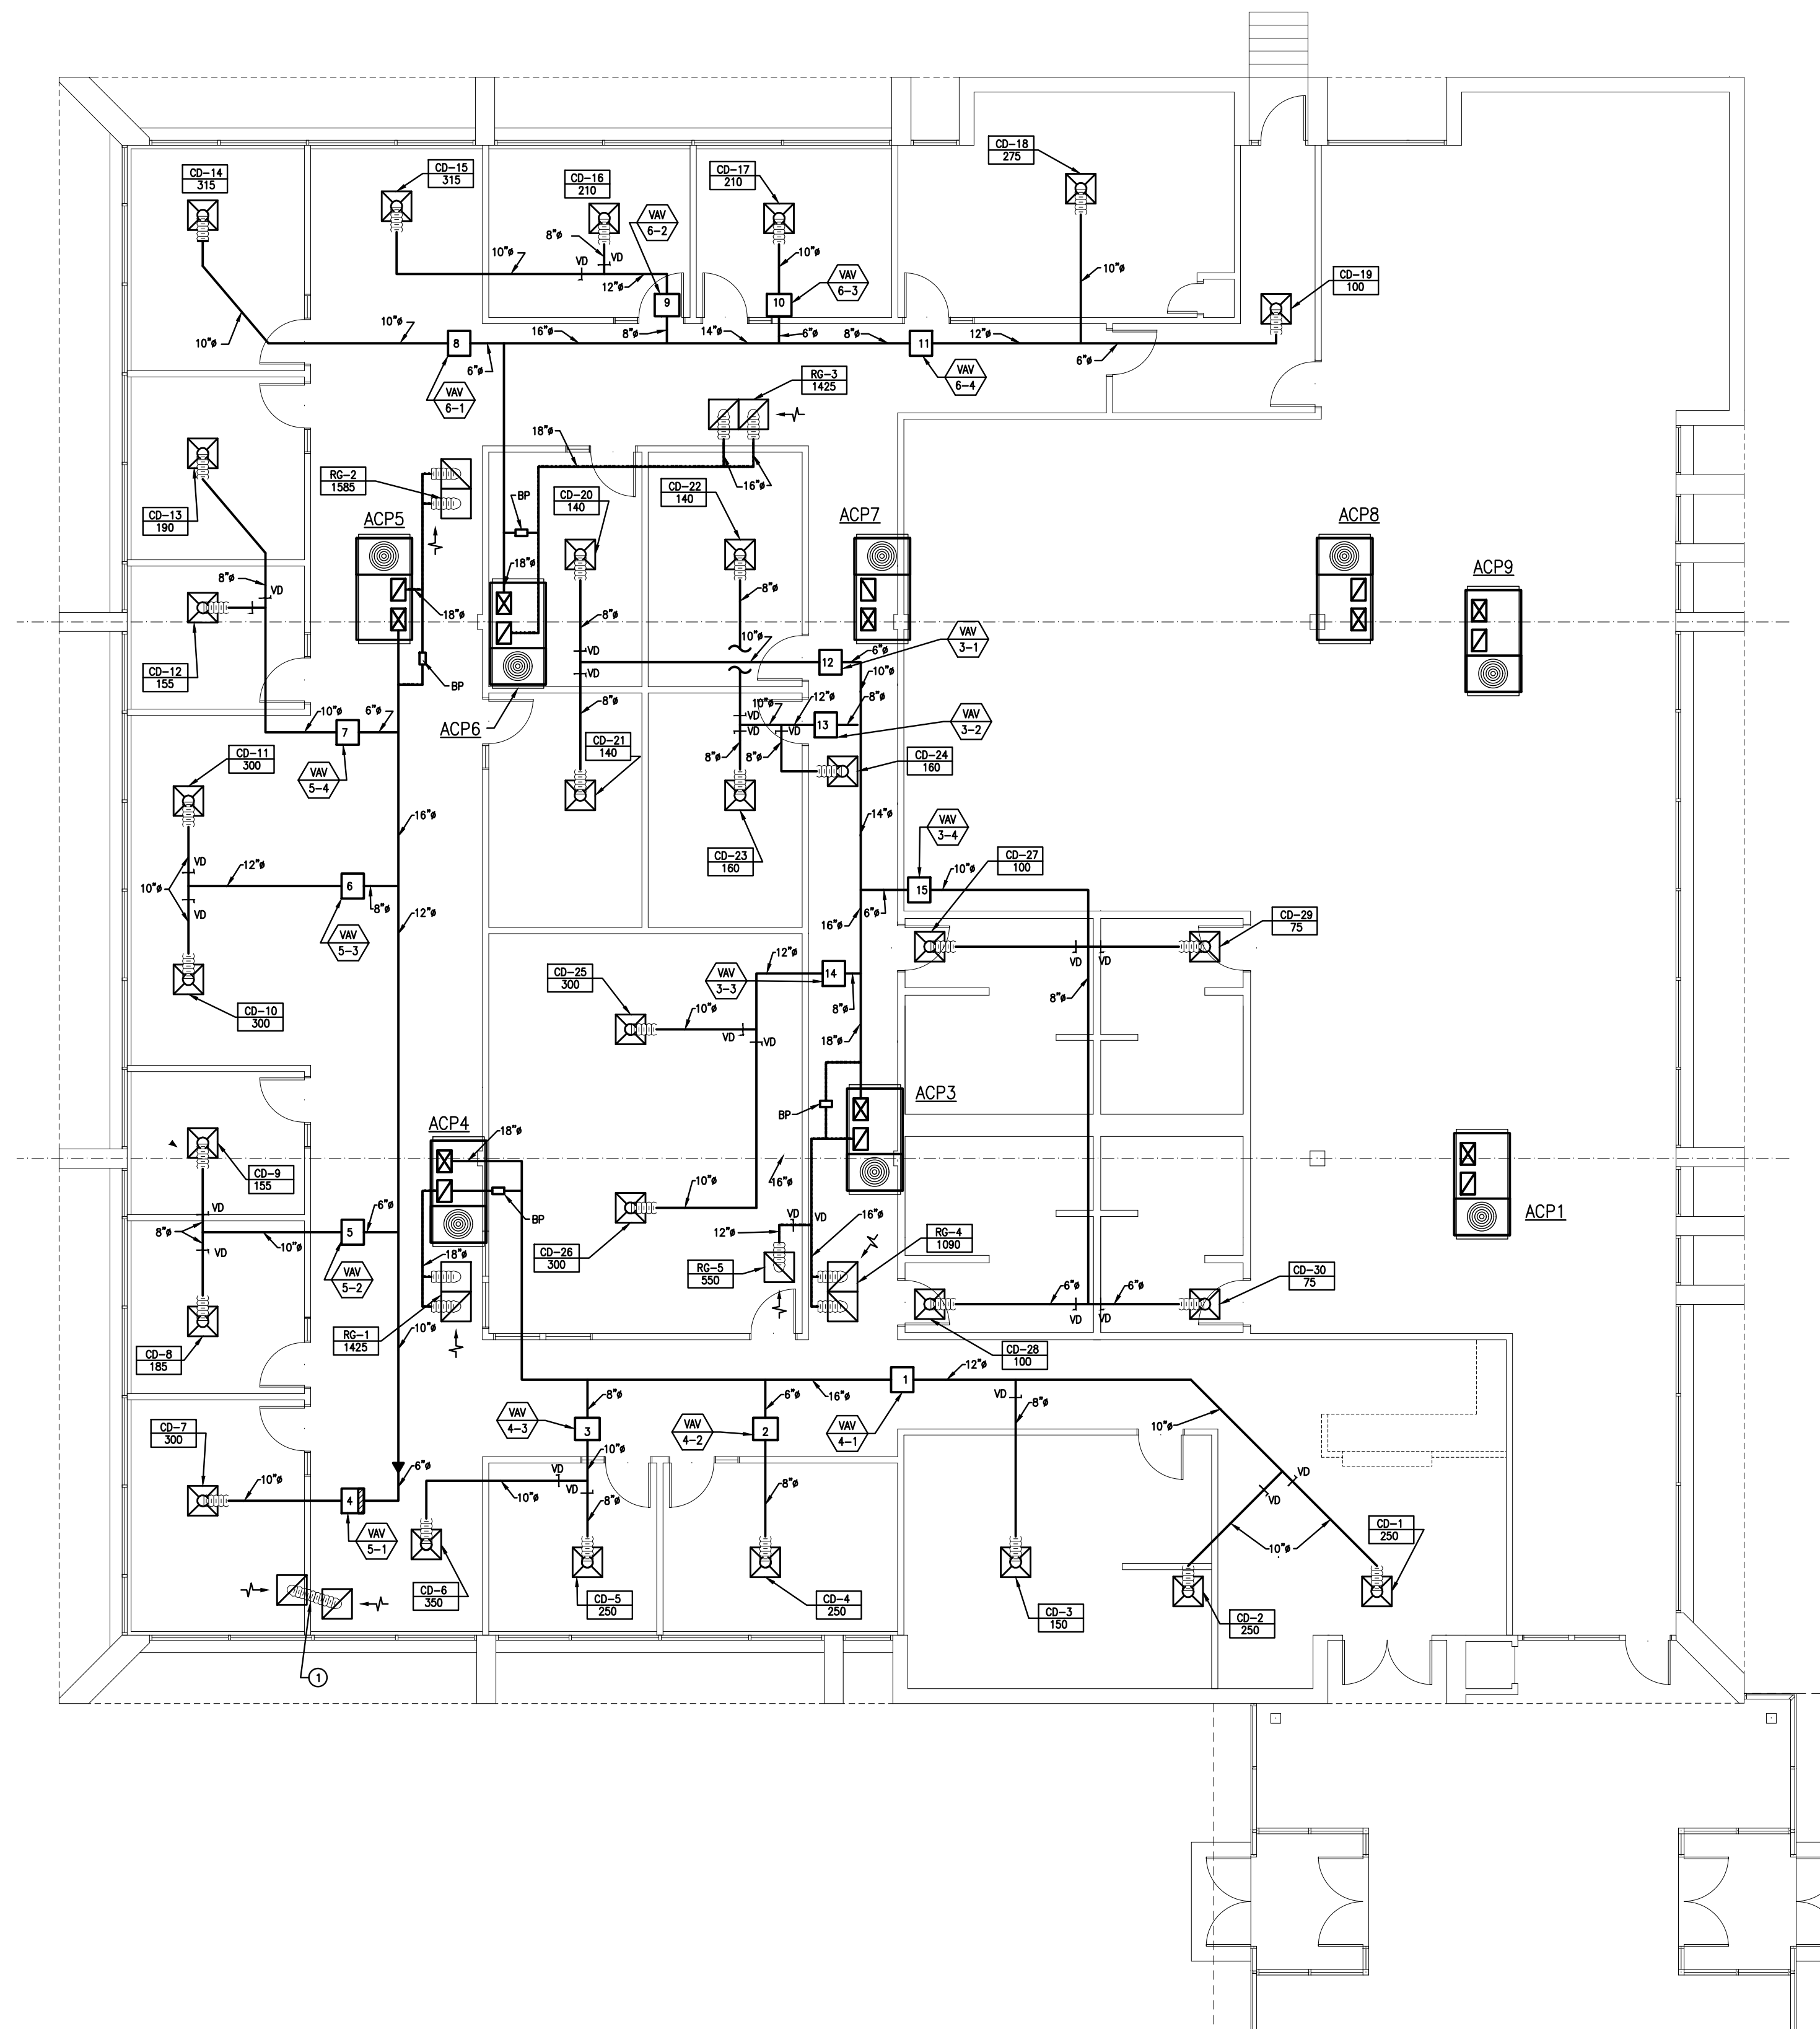

KEYED NOTES
 ① PROVIDE TRANSFER GRILLES ALL ROOMS BUT #126,11, AND REST ROOM

① **MECHANICAL DUCTWORK PLAN**
 SCALE: 1/8" = 1'-0"

MECHANICAL SERVICES, INC.
 400 PRESUMPCOT STREET
 PORTLAND, MAINE 04103
 WWW.MECHANICALSERVICES.COM

HVAC SERVICE INSTALLATION PREVENTATIVE MAINTENANCE
 OIL & GAS BURNERS CONTROLS 24 HOUR SERVICES
 40 GABRIEL DRIVE, AUGUSTA, ME. 04330 (207) 626-0822
 PORTLAND, ME. 774-1531 BANGOR 947-6250 EASTON 488-6112