

Project Title
**CROSS
INSURANCE
RENOVATIONS**

2331 CONGRESS STREET
Portland, Maine

GENERAL NOTES


03-24-13	PROGRESS DRAWING
----------	------------------

Mark	Date	Description
------	------	-------------

Issue Dates

Drawing Title
**MECHANICAL
DUCTWORK PLAN**

Drawing Number
M-2

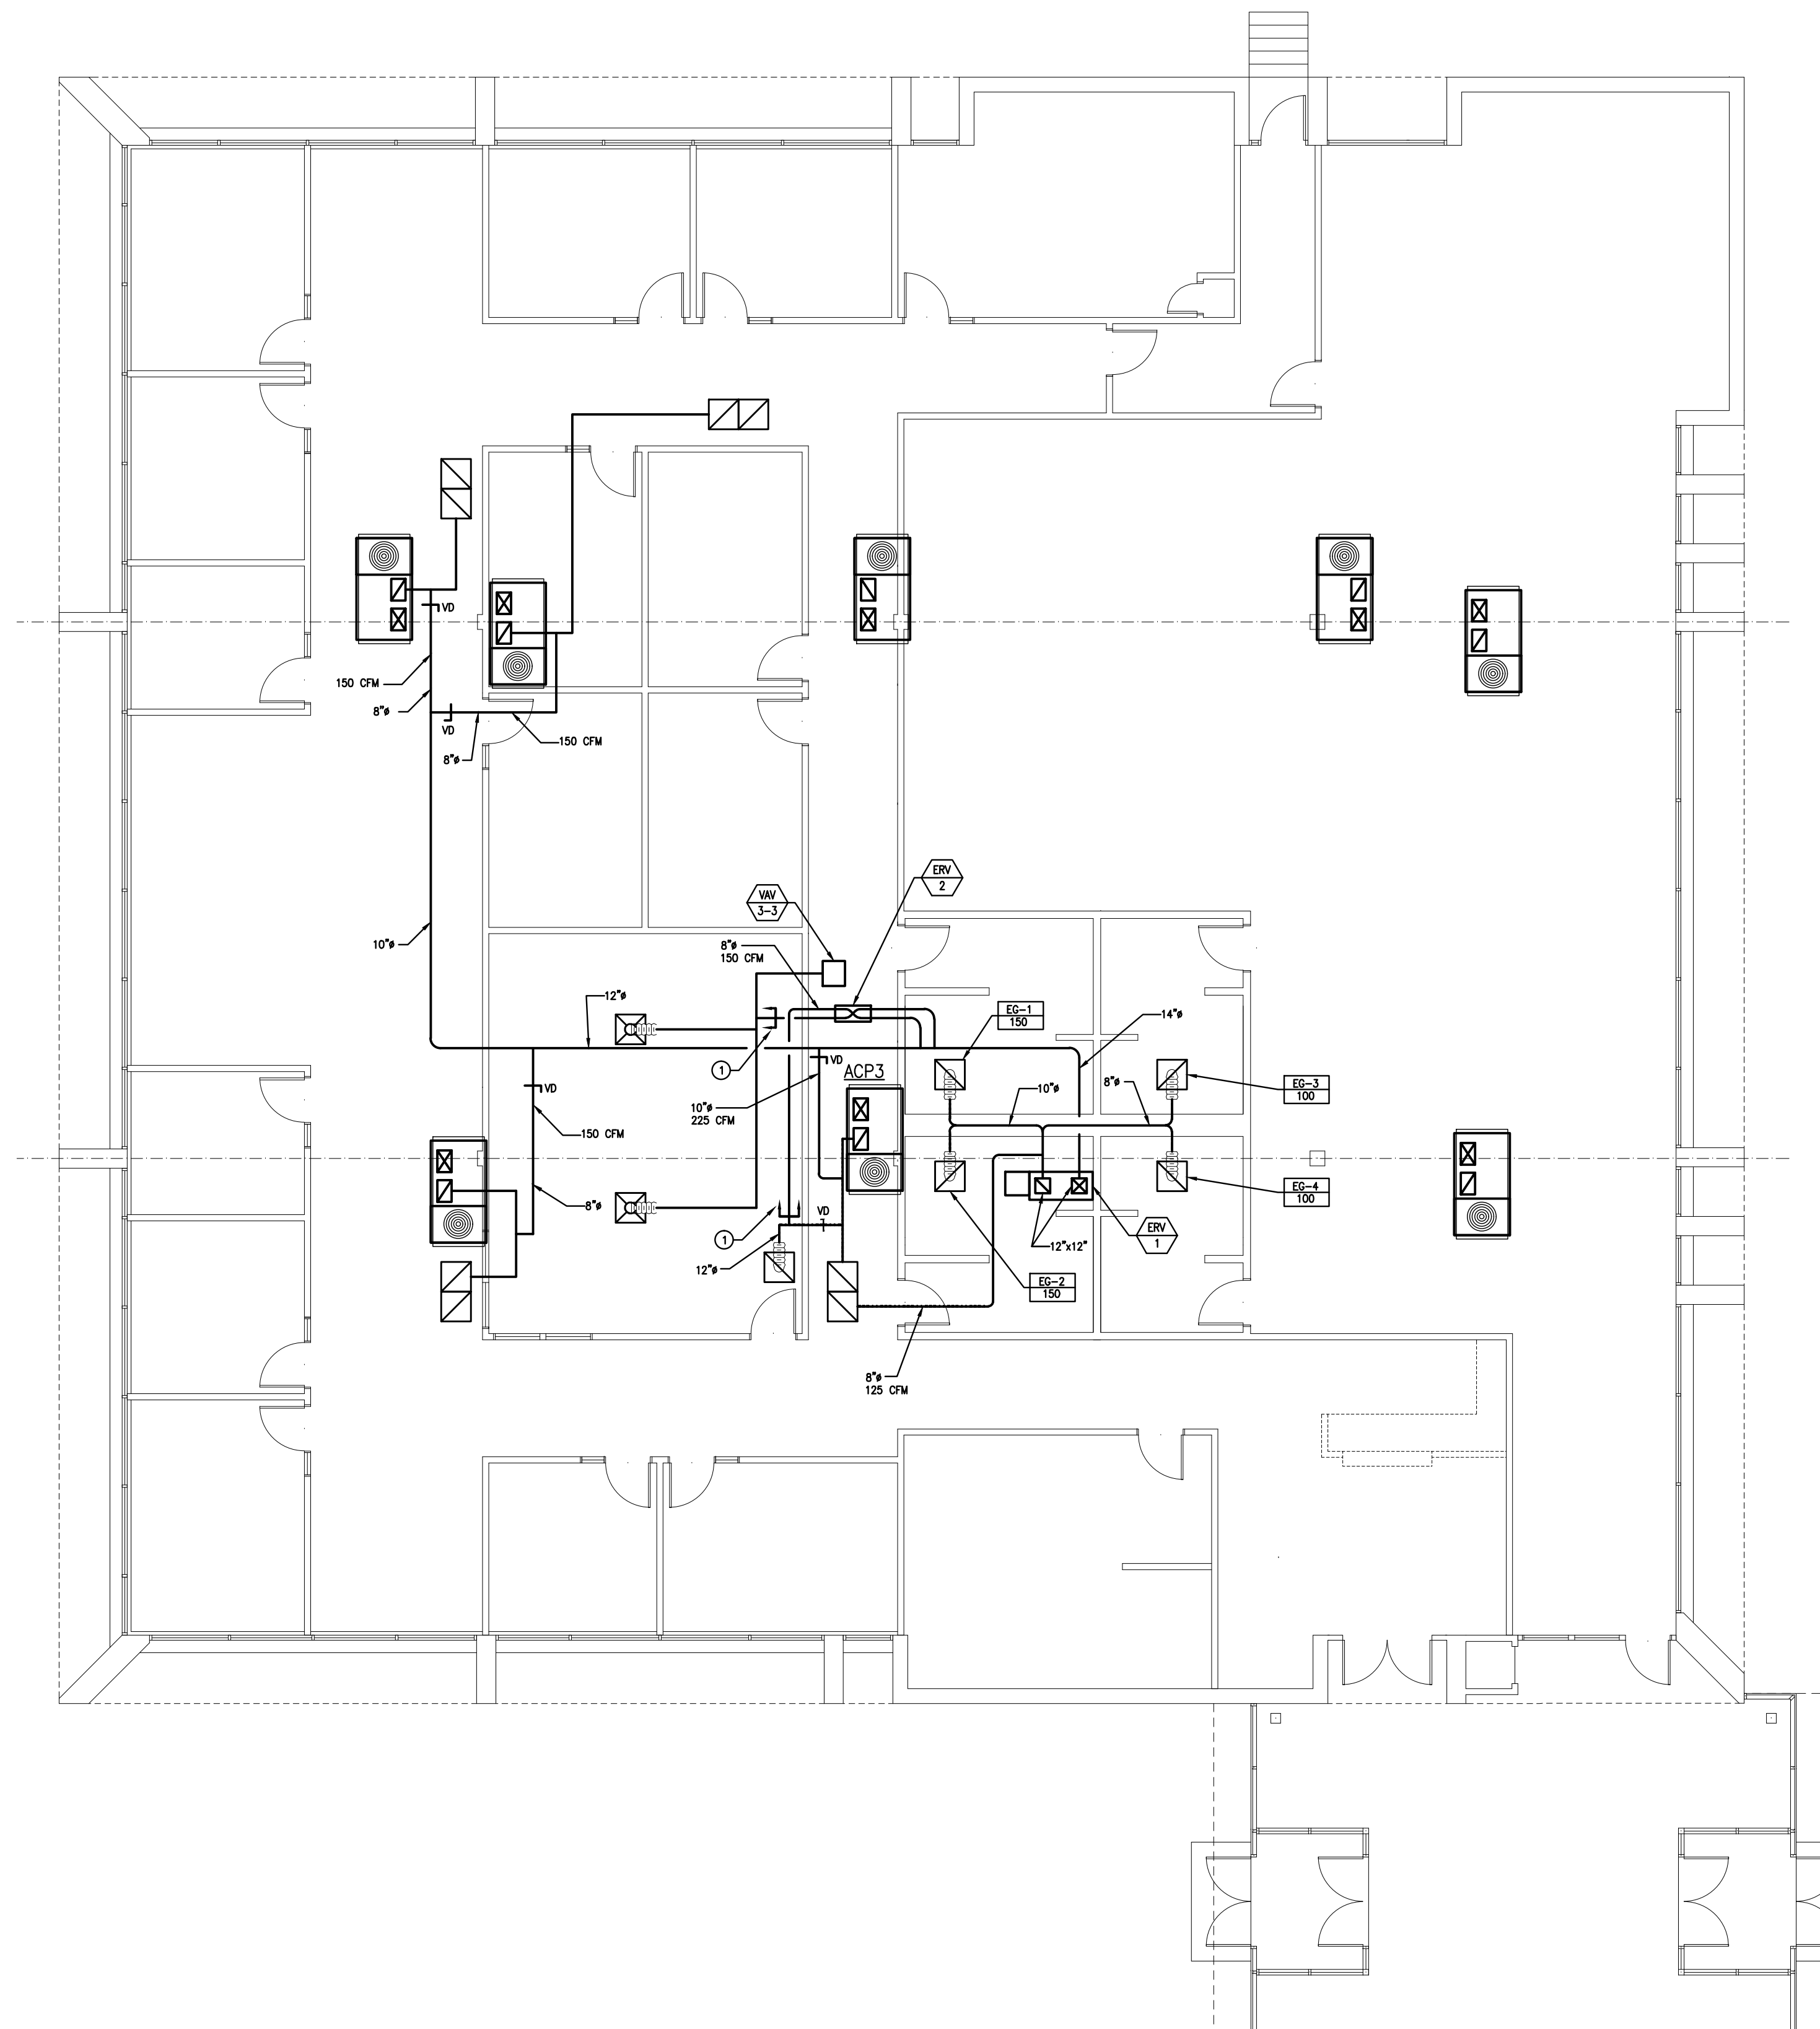

KEYED NOTES
① INSTALL WEIGHTED BACKDRAFT DAMPERS (2 LOCATIONS)

① **MECHANICAL DUCTWORK PLAN**
SCALE: 1/8" = 1'-0"

 **MECHANICAL SERVICES, INC.**
400 PRESUMPCOT STREET
PORTLAND, MAINE 04103
WWW.MECHANICALSERVICES.COM

HVAC SERVICE INSTALLATION PREVENTATIVE MAINTENANCE
OIL & GAS BURNERS CONTROLS 24 HOUR SERVICES
40 GABRIEL DRIVE, AUGUSTA, ME. 04330 (207) 626-0822
PORTLAND, ME, 774-1531 BANGOR 947-6250 EASTON 488-6112