


Project Title

**CROSS INSURANCE
RENOVATIONS**

2331 CONGRESS STREET
PORTLAND, MAINE


RGD	Size	VAV	Inlet
S-1	6"	9-1	5"
S-2	8"	9-2	5"
S-3	10"	9-3	5"
R-1	12x12	9-4	8"
R-2	22x10	9-5	5"
R-3	22x22	8-1	8"
		8-2	8"
		8-3	10"

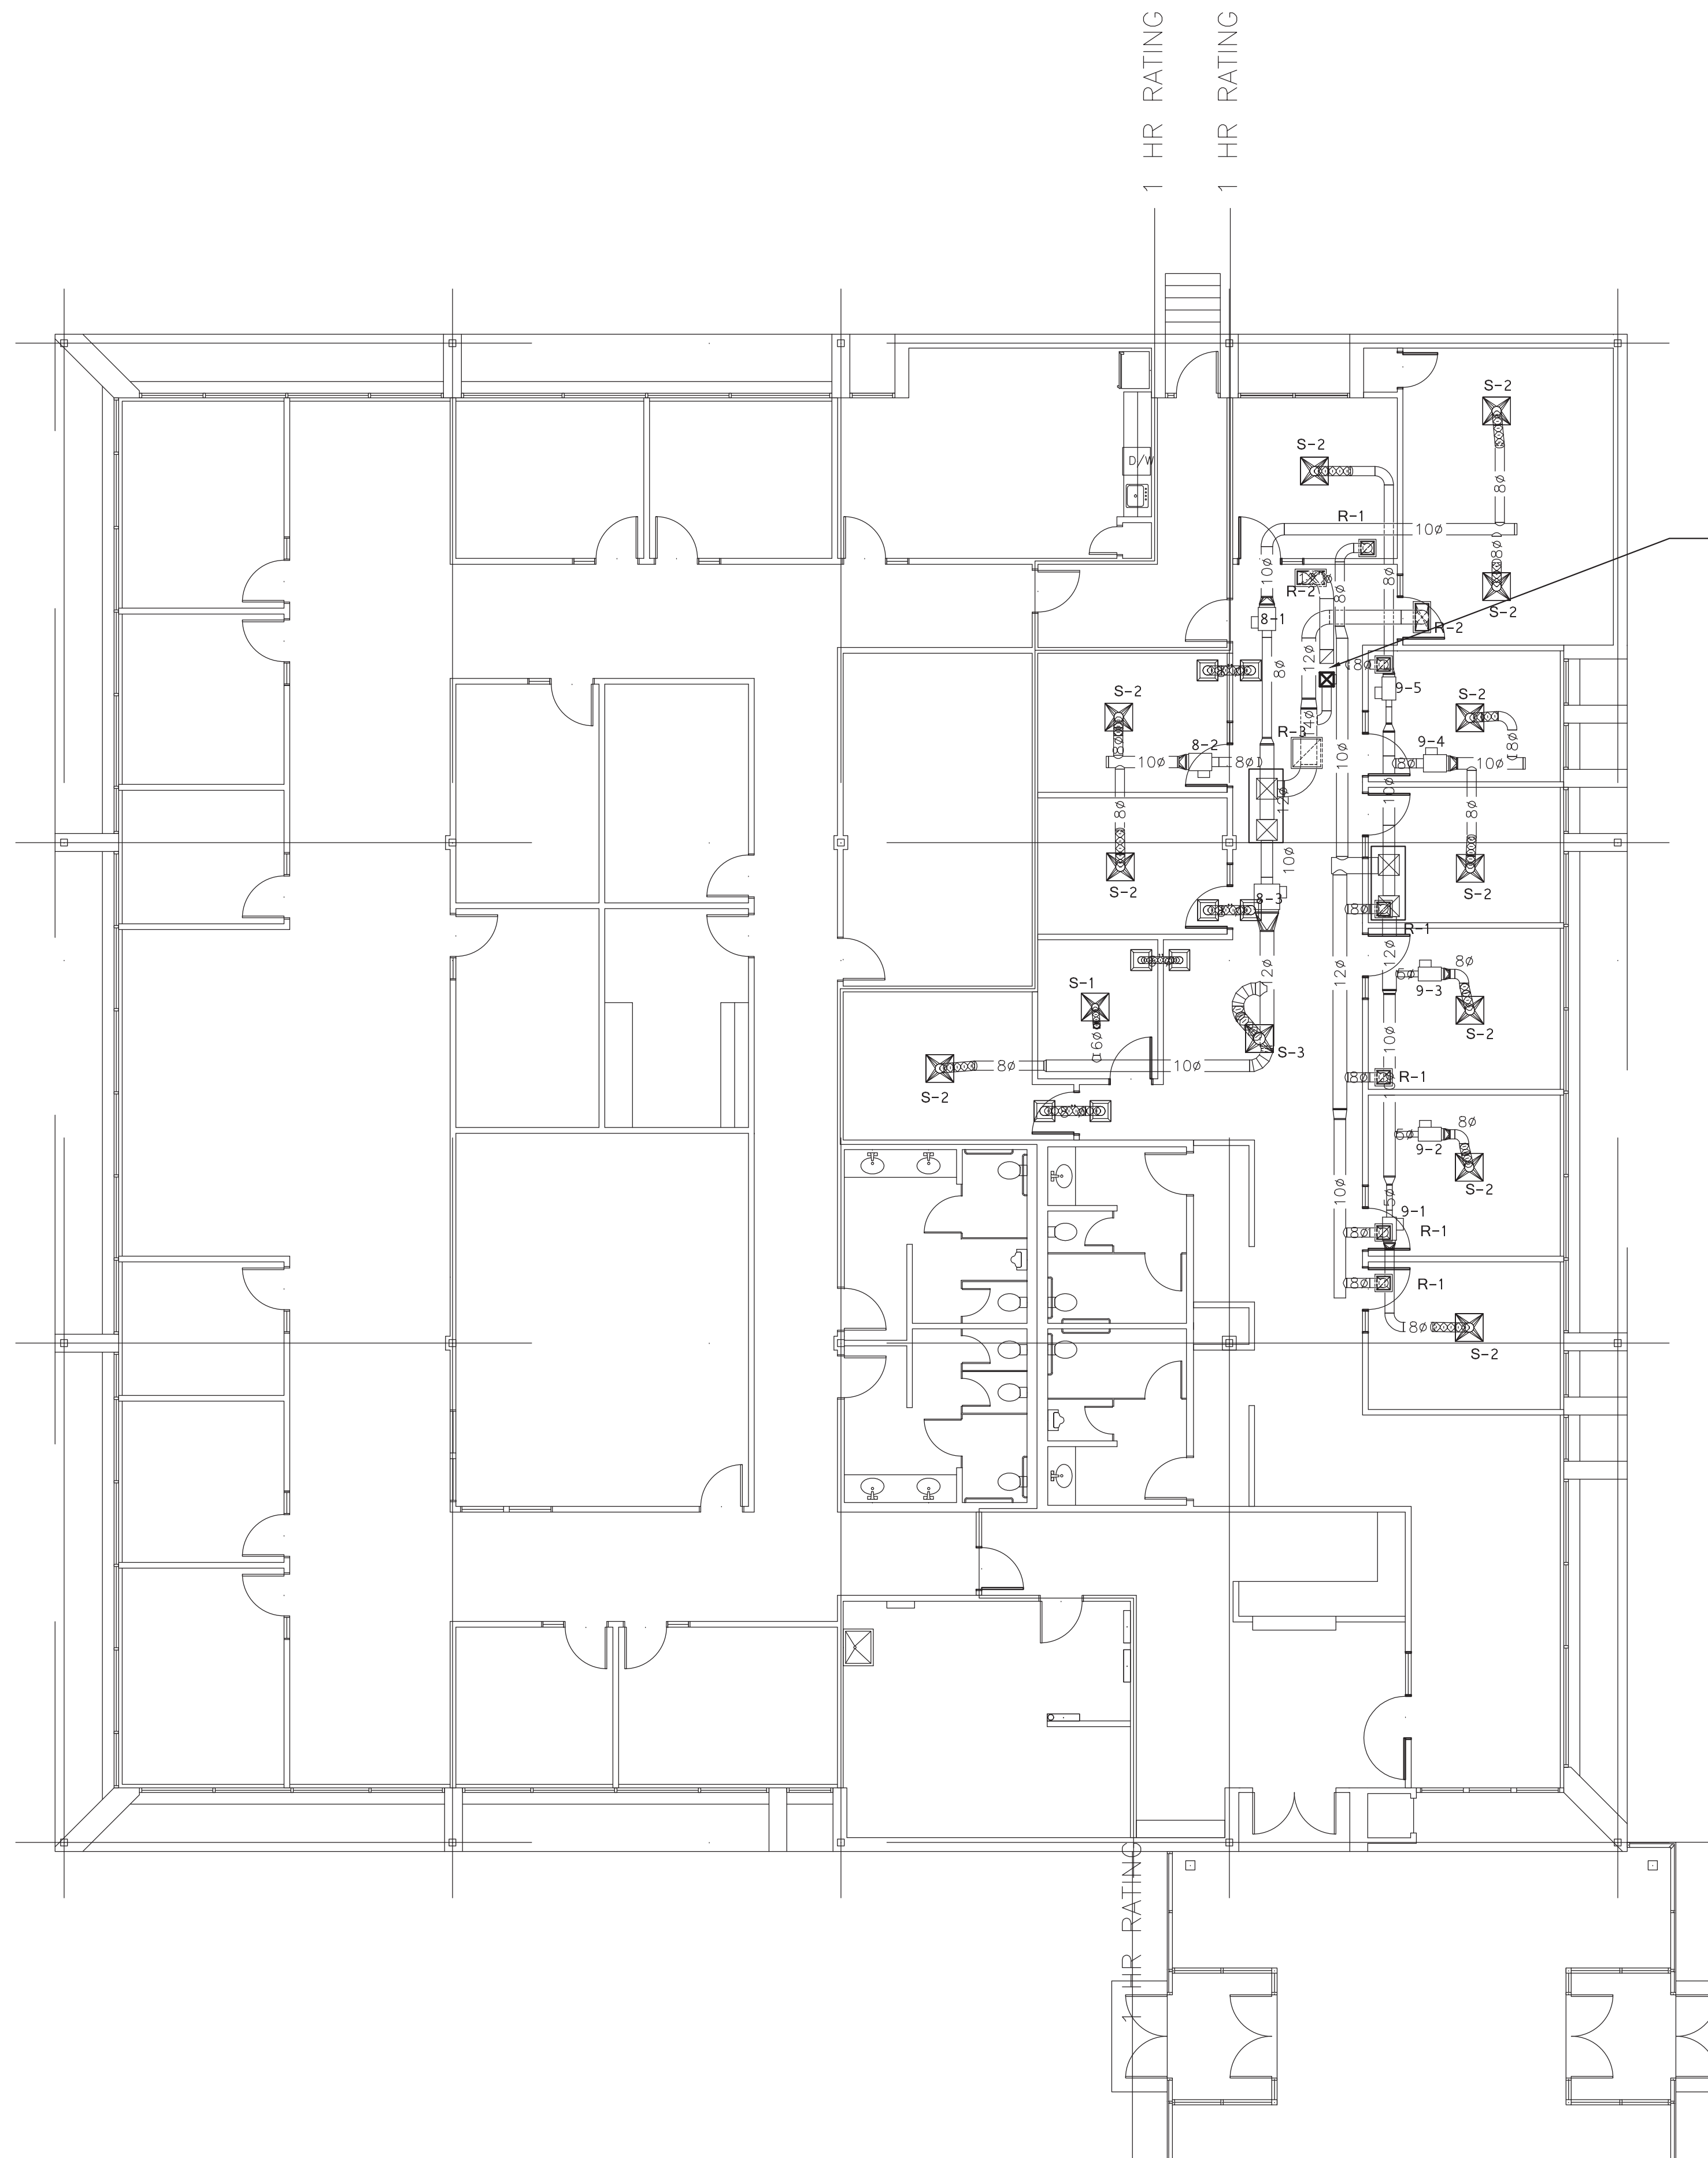

08 - 26 - 16 ISSUED FOR PERMIT

Mark	Date	Description

Issue Dates

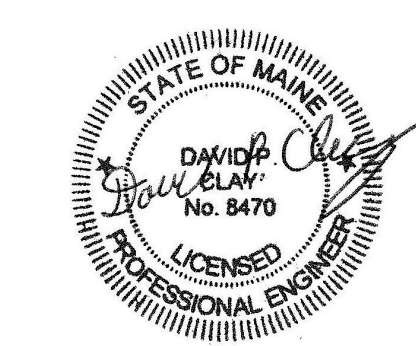

Drawing Title

**HEATING / COOLING
MECHANICAL
DUCTWORK PLAN**

Drawing Number

M-1