

Anthony Mancini, Inc.
 179 SHERIDAN ST.
 PORTLAND, ME 04101
 P: (207)774-5829 F: (207)772-1686
 E: info@mancinielec.com
 "We appreciate Your Business."



FIXTURE SCHEDULE					
QUANTITY	TYPE	MANUFACTURER	CATALOG NUMBER	DESCRIPTION	LAMPS
44	A	RAB	SWISH2X4-39Y/D10	LED 2X4 DIRECT/INDIRECT	LED
34	B	RAB	SWISH2X2-29Y/D10	LED 2X2 DIRECT/INDIRECT	LED
1	C	DAY-BRITE	OWL430L835UNV	LED WRAPAROUND	LED
17	D	LIGHTOLIER	L6R20AEUVA/L6R20835VA/L6RBW	RECESSED DOWNLIGHT	LED
11	D1	NORA	NHIOICD-28LE3/NIOB-2RC35XWW	RECESSED ADJUSTABLE	LED
15	DR			LED RETRO-FIT KITS	LED
-	F				
4	G	LIGHTOLIER	L4R10AE1VA/L4R10835VA/L4RBW	RECESSED DOWNLIGHT	LED
4	H	LUMARK	XTOR3B	LED WALL PACK	LED
13	EXIT	DUAL-LITE	EVEURWE	EXIT SIGN	LED
9	EBU	DUAL-LITE	LZ15	EMERGENCY BATTERY UNIT	
2	SRH	DUAL-LITE	LZRSW0605	SINGLE REMOTE HEAD	
3	ORH	DUAL-LITE	OCRSW0605	OUTDOOR SINGLE REMOTE HEAD	

POWER LEGEND



- DUPLEX CONVENIENCE RECEPTACLE
- DUPLEX CONVENIENCE RECEPTACLE - 46" AFF TO TOP
- GROUND FAULT INTERRUPTER RECEPTACLE
- GROUND FAULT INTERRUPTER RECEPTACLE - 46" AFF TO TOP
- SPECIAL EQUIPMENT WIRING
- PARTIAL CIRCUIT
- VOICE/DATA RECEPTACLE 18" AFF TO TOP
- CATV OUTLET
- RECESSED MOUNTED LIGHTING & POWER PANEL
- FUSED DISCONNECT SWITCH
- MOTOR SWITCH
- POWER POLE

LIGHTING & EMERGENCY LEGEND

- 2' x 4' LIGHT FIXTURE
- 2' x 2' LIGHT FIXTURE
- RECESSED LIGHT FIXTURE
- FLUORESCENT STRIP LIGHT FIXTURE
- FLUSH/SEMI-FLUSH LIGHT FIXTURE
- WALL MOUNTED LIGHT FIXTURE
- SINGLE-POLE SWITCH
- THREE-WAY SWITCH
- MOTION SENSOR - CEILING MOUNTED
- LED EXIT SIGN
- COMBINATION EMERGENCY LIGHT FIXTURE & EXIT SIGN
- EMERGENCY LIGHT FIXTURES W/ BATTERY PACK - MOUNTED 84" AFF TO TOP OF BOX OR 6" BELOW CEILING, WHICH EVER IS LOWER
- EMERGENCY LIGHT REMOTE FIXTURES 84" AFF TO TOP OF BOX OR 6" BELOW CEILING, WHICH EVER IS LOWER

FIRE ALARM LEGEND

- FIRE ALARM MANUAL PULL STATION - MOUNT 52" AFF TO TOP OF BOX
- FIRE ALARM KNOX BOX
- FIRE ALARM HORN AND STROBE UNIT - MOUNT 84" AFF TO TOP OF BOX OR 6" BELOW CEILING, WHICH EVER IS LOWER
- FIRE ALARM HORN AND STROBE UNIT - CEILING MOUNT
- FIRE ALARM STROBE UNIT - MOUNT ABOVE DOOR - MOUNT 84" AFF TO BOTTOM OF BOX OR 6" BELOW CEILING, WHICH EVER IS LOWER
- HEAT DETECTOR - CEILING MOUNTED
- SMOKE DETECTOR - CEILING MOUNTED
- DUCT SMOKE
- DOOR HOLDER

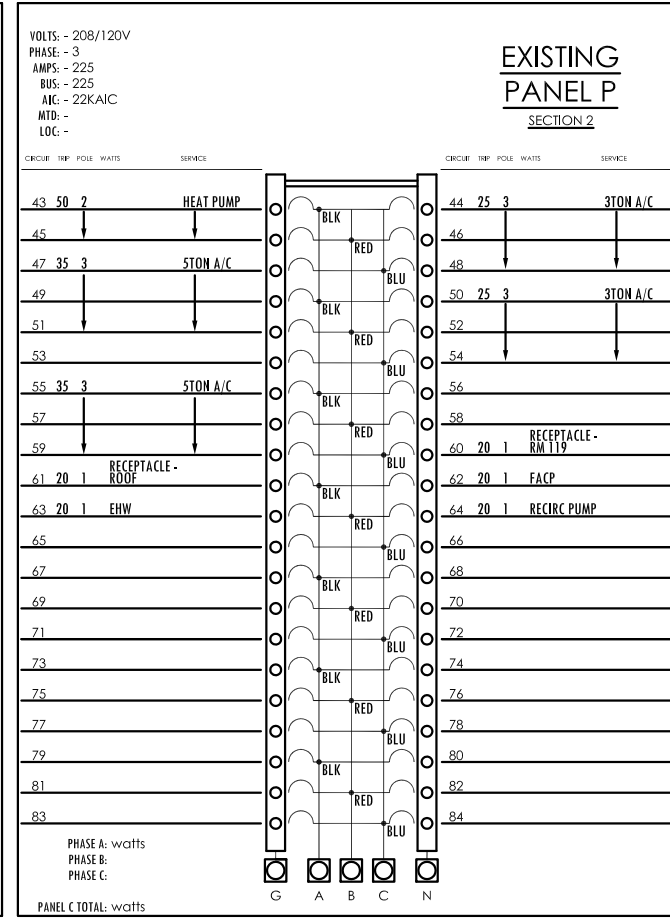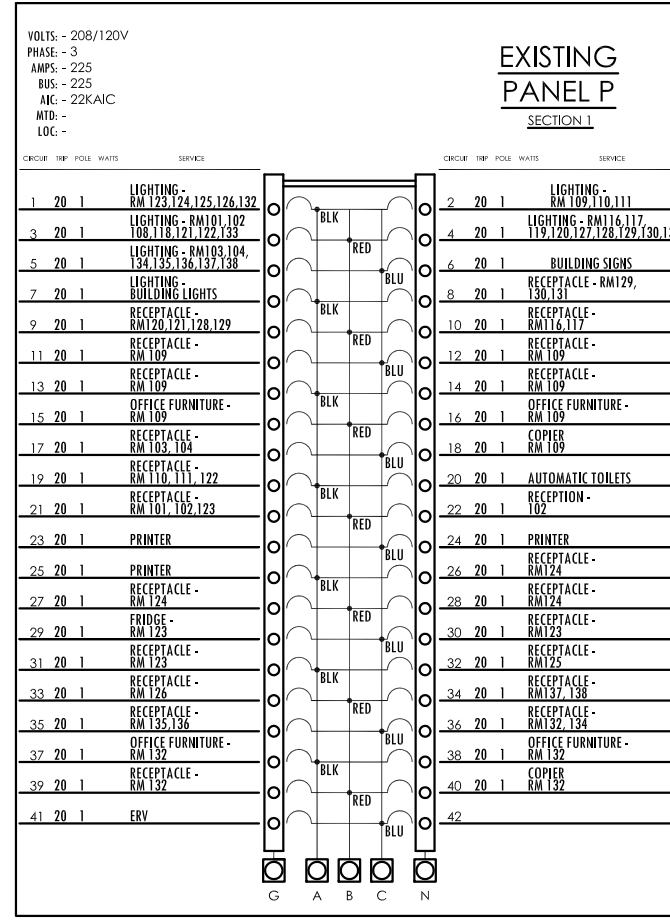

NO.	DATE	DESCRIPTION

PROJECT NAME & ADDRESS:
 Cross Insurance
 2367 Congress Street
 Portland, Maine

SHEET NAME:
 Legends & Schedules

Checked By: G. MANCINI
 Drawn By: A. AVES

Date: 11.28.2017
 Scale: As Noted