



# CEILING NOTES:

- SEE G-001 FOR GENERAL PROJECT NOTES.
- SEE FINISH SCHEDULE FOR CEILING AND CEILING GRID TYPES.
- EXCEPT WHERE INDICATED, CENTER CEILING GRIDS IN ROOMS, USE HALF TILES OF GREATER @ PERIMETERS WHEN POSSIBLE.
- ALIGN CEILING ITEMS AS SHOWN, WITH COMMON CENTERLINES TYPICALLY. CENTER ITEMS IN CEILING, OR IN AREAS UNLESS INDICATED OTHERWISE.
- WHERE TEGULAR OR BEVELED TILE IS USED, PAINT ALL CUT EDGES TO MATCH.
- CAULK JOINT BETWEEN CEILING GRID (WALL ANGLE) AND WALL WHERE GAPS ARE LARGER THAN 1/8\"/>


# CEILING LEGEND:

- 2x2 CEILING TILE AND GRID
- 2x4 CEILING TILE AND GRID
- GWb CEILING
- DOWN LIGHT
- 2x2 LIGHT FIXTURE
- 2x4 LIGHT FIXTURE
- 1x4 LIGHT FIXTURE
- SUPPLY DIFFUSER
- RETURN DIFFUSER
- EXHAUST DIFFUSER
- LINEAR DIFFUSER
- 1 HOUR CEILING

REV	DESCRIPTION	DATE
0	ISSUED FOR CONSTRUCTION	12-21-17

ISSUED FOR CONSTRUCTION  
12-21-17

CURRENT ISSUE STATUS:

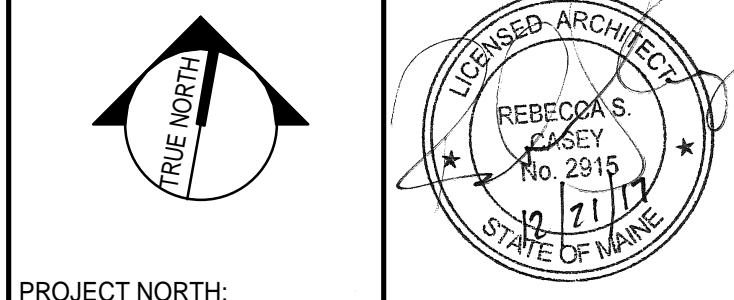

PROJECT NORTH:  
SMRT Architects and Engineers  
144 Fore Street/P.O. Box 618  
Portland, Maine 04104

ARCHITECTURE|ENGINEERING|PLANNING|INTERIORS|ENERGY

MAINE MEDICAL CENTER  
M.M.C. HUTCHINS DRIVE  
RENOVATION

PROJECT LOCATION  
REFLECTED CEILING PLAN -  
LEVEL 1

SHEET TITLE:  
0' 1/4' 1/2' 1' 2' 3'

SCALE: AS NOTED

PROJECT MANAGER:	RSC	PROJECT NO:	17123
A/E OF RECORD:	RSC		
JOB CAPTAIN:	SDL		
DRAWN BY:	SDL/JMM		
SMRT FILE:	AE111-17123	SHEET NO.	AE111