



STANDARD MOUNTING HEIGHTS FOR MISCELLANEOUS WALL-MOUNTED ACCESSORIES

STANDARD HEIGHTS FOR TRANSACTION COUNTER/ SHELVING/ SEATING

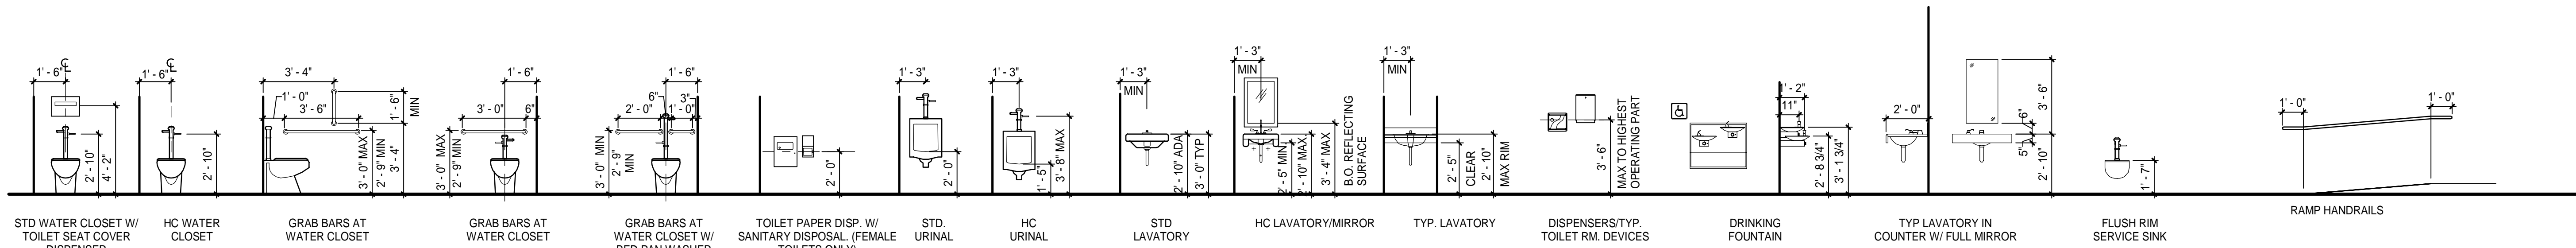

STANDARD PLUMBING FIXTURES AND WALL-MOUNTED ACCESSORY MOUNTING HEIGHTS

GENERAL MOUNTING HEIGHTS K1
1/4" = 1'-0"

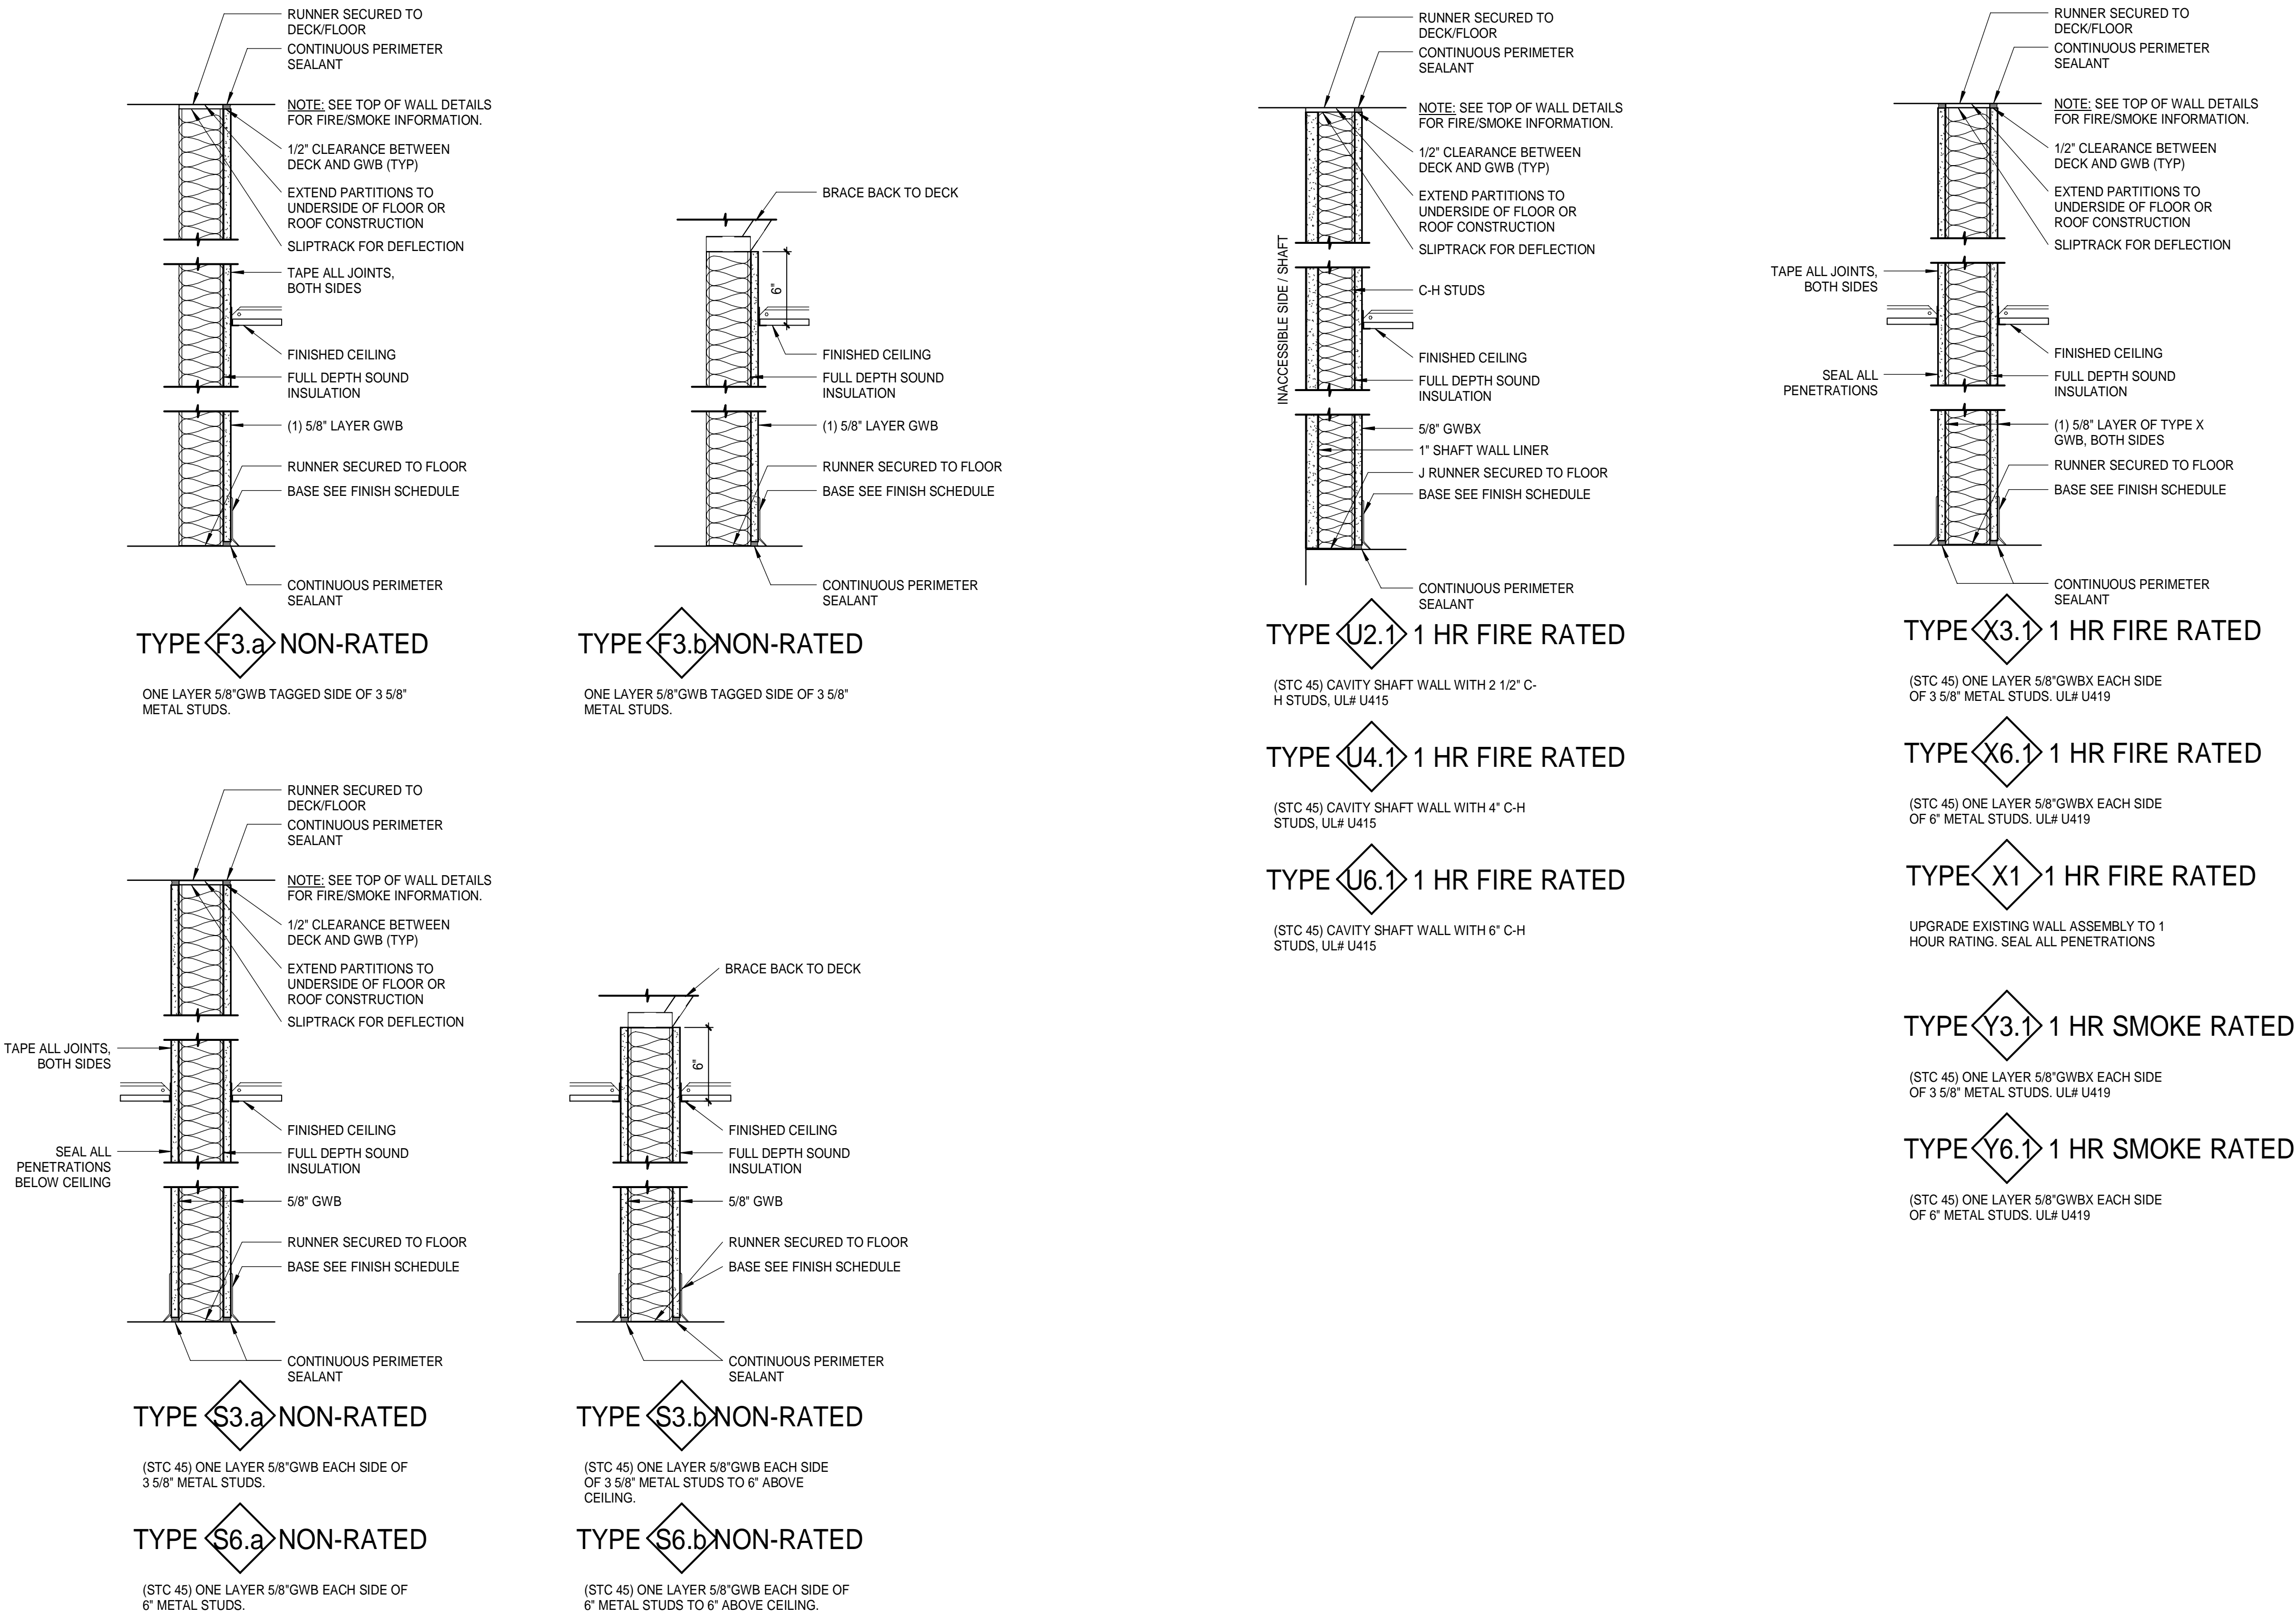


WALL TYPES A1
1 1/2" = 1'-0"

REV	DESCRIPTION	DATE
0	ISSUED FOR CONSTRUCTION	12-21-17

ISSUED FOR CONSTRUCTION
12-21-17

CURRENT ISSUE STATUS:

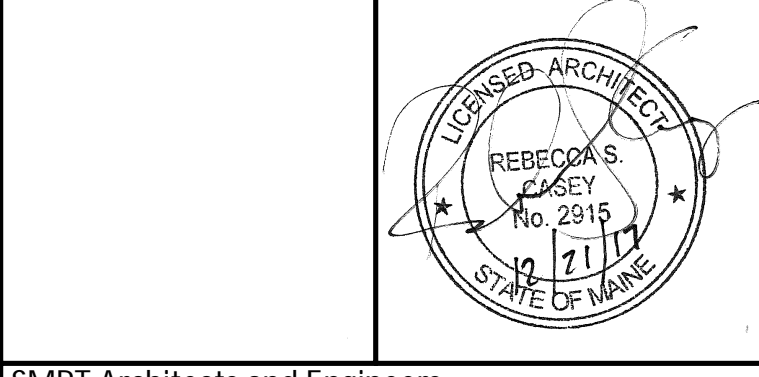

SMRT Architects and Engineers
144 Fore Street/P.O. Box 618
Portland, Maine 04104

ARCHITECTURE | ENGINEERING | PLANNING | INTERIORS | ENERGY

MAINE MEDICAL CENTER
M.M.C. HUTCHINS DRIVE
RENOVATION
PROJECT LOCATION

GENERAL MOUNTING HEIGHTS
AND WALL TYPES

SHEET TITLE:



SCALE: AS NOTED

PROJECT MANAGER: RSC PROJECT NO: 17123

AVE OF RECORD: RSC

JOB CAPTAIN: SDL

DRAWN BY: SDL/JMM

SMRT FILE: G1002-17123 SHEET NO. 17123

G1002