


PROJECT NAME:  
**PATRONS OXFORD OFFICES**

97 TECHNOLOGY PARK DRIVE  
PORTLAND, MAINE 04102  
UNITED STATES OF AMERICA

SEAL:

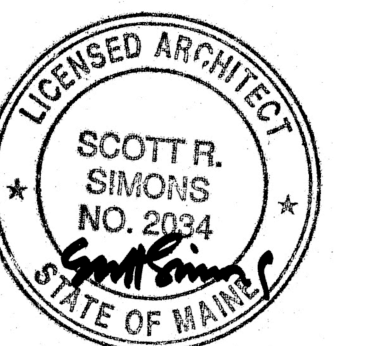

THIS DRAWING IS THE PROPERTY OF SCOTT SIMONS ARCHITECTS (SSA) AND IS NOT TO BE COPIED OR REPRODUCED IN PART OR WHOLE  
2016 © SCOTT SIMONS ARCHITECTS, LLC

REVISION:

1	DATE
2	DATE
3	DATE
4	DATE
5	DATE
6	DATE





DATE OF ISSUE: 14 JANUARY 2016  
PROJECT NUMBER: 2105-0100 PATRONS OXFORD  
STATUS: CONSTRUCTION DOCUMENTS

**FIRST FLOOR REFLECTED CEILING PLAN**

**A131**

- LEGEND**
- R1 - RECESSED LINEAR FIXTURE
  - R2 - RECESSED RECTANGULAR FIXTURE
  - R3 - RECESSED ROUND DOWN LIGHT
  - R4 - RECESSED SQUARE DOWN LIGHT
  - R5 - RECESSED LINEAR FIXTURE
  - R6 - RECESSED LINEAR T-BAR FIXTURE
  - S1 - SURFACE MOUNTED FIXTURE
  - S2 - SURFACE MOUNTED WET LOCATION FIXTURE
  - P1 - LINEAR DIRECT PENDANT FIXTURE
  - P2 - LED PENDANT FIXTURE
  - P3 - LINEAR DIRECT/INDIRECT PENDANT FIXTURE
  - P5 - DECORATIVE PENDANT FIXTURE
  - W1 - WALL WASHING FIXTURE
  - U1 - UTILITY LIGHT

- ACT 1  
2' x 4' PANELS
- ACT 2  
2' x 2' PANELS
- LINEAR/DECK WOOD CEILING
- GWB
- SUPPLY GRILL
- RETURN GRILL
- CASSETTE UNIT

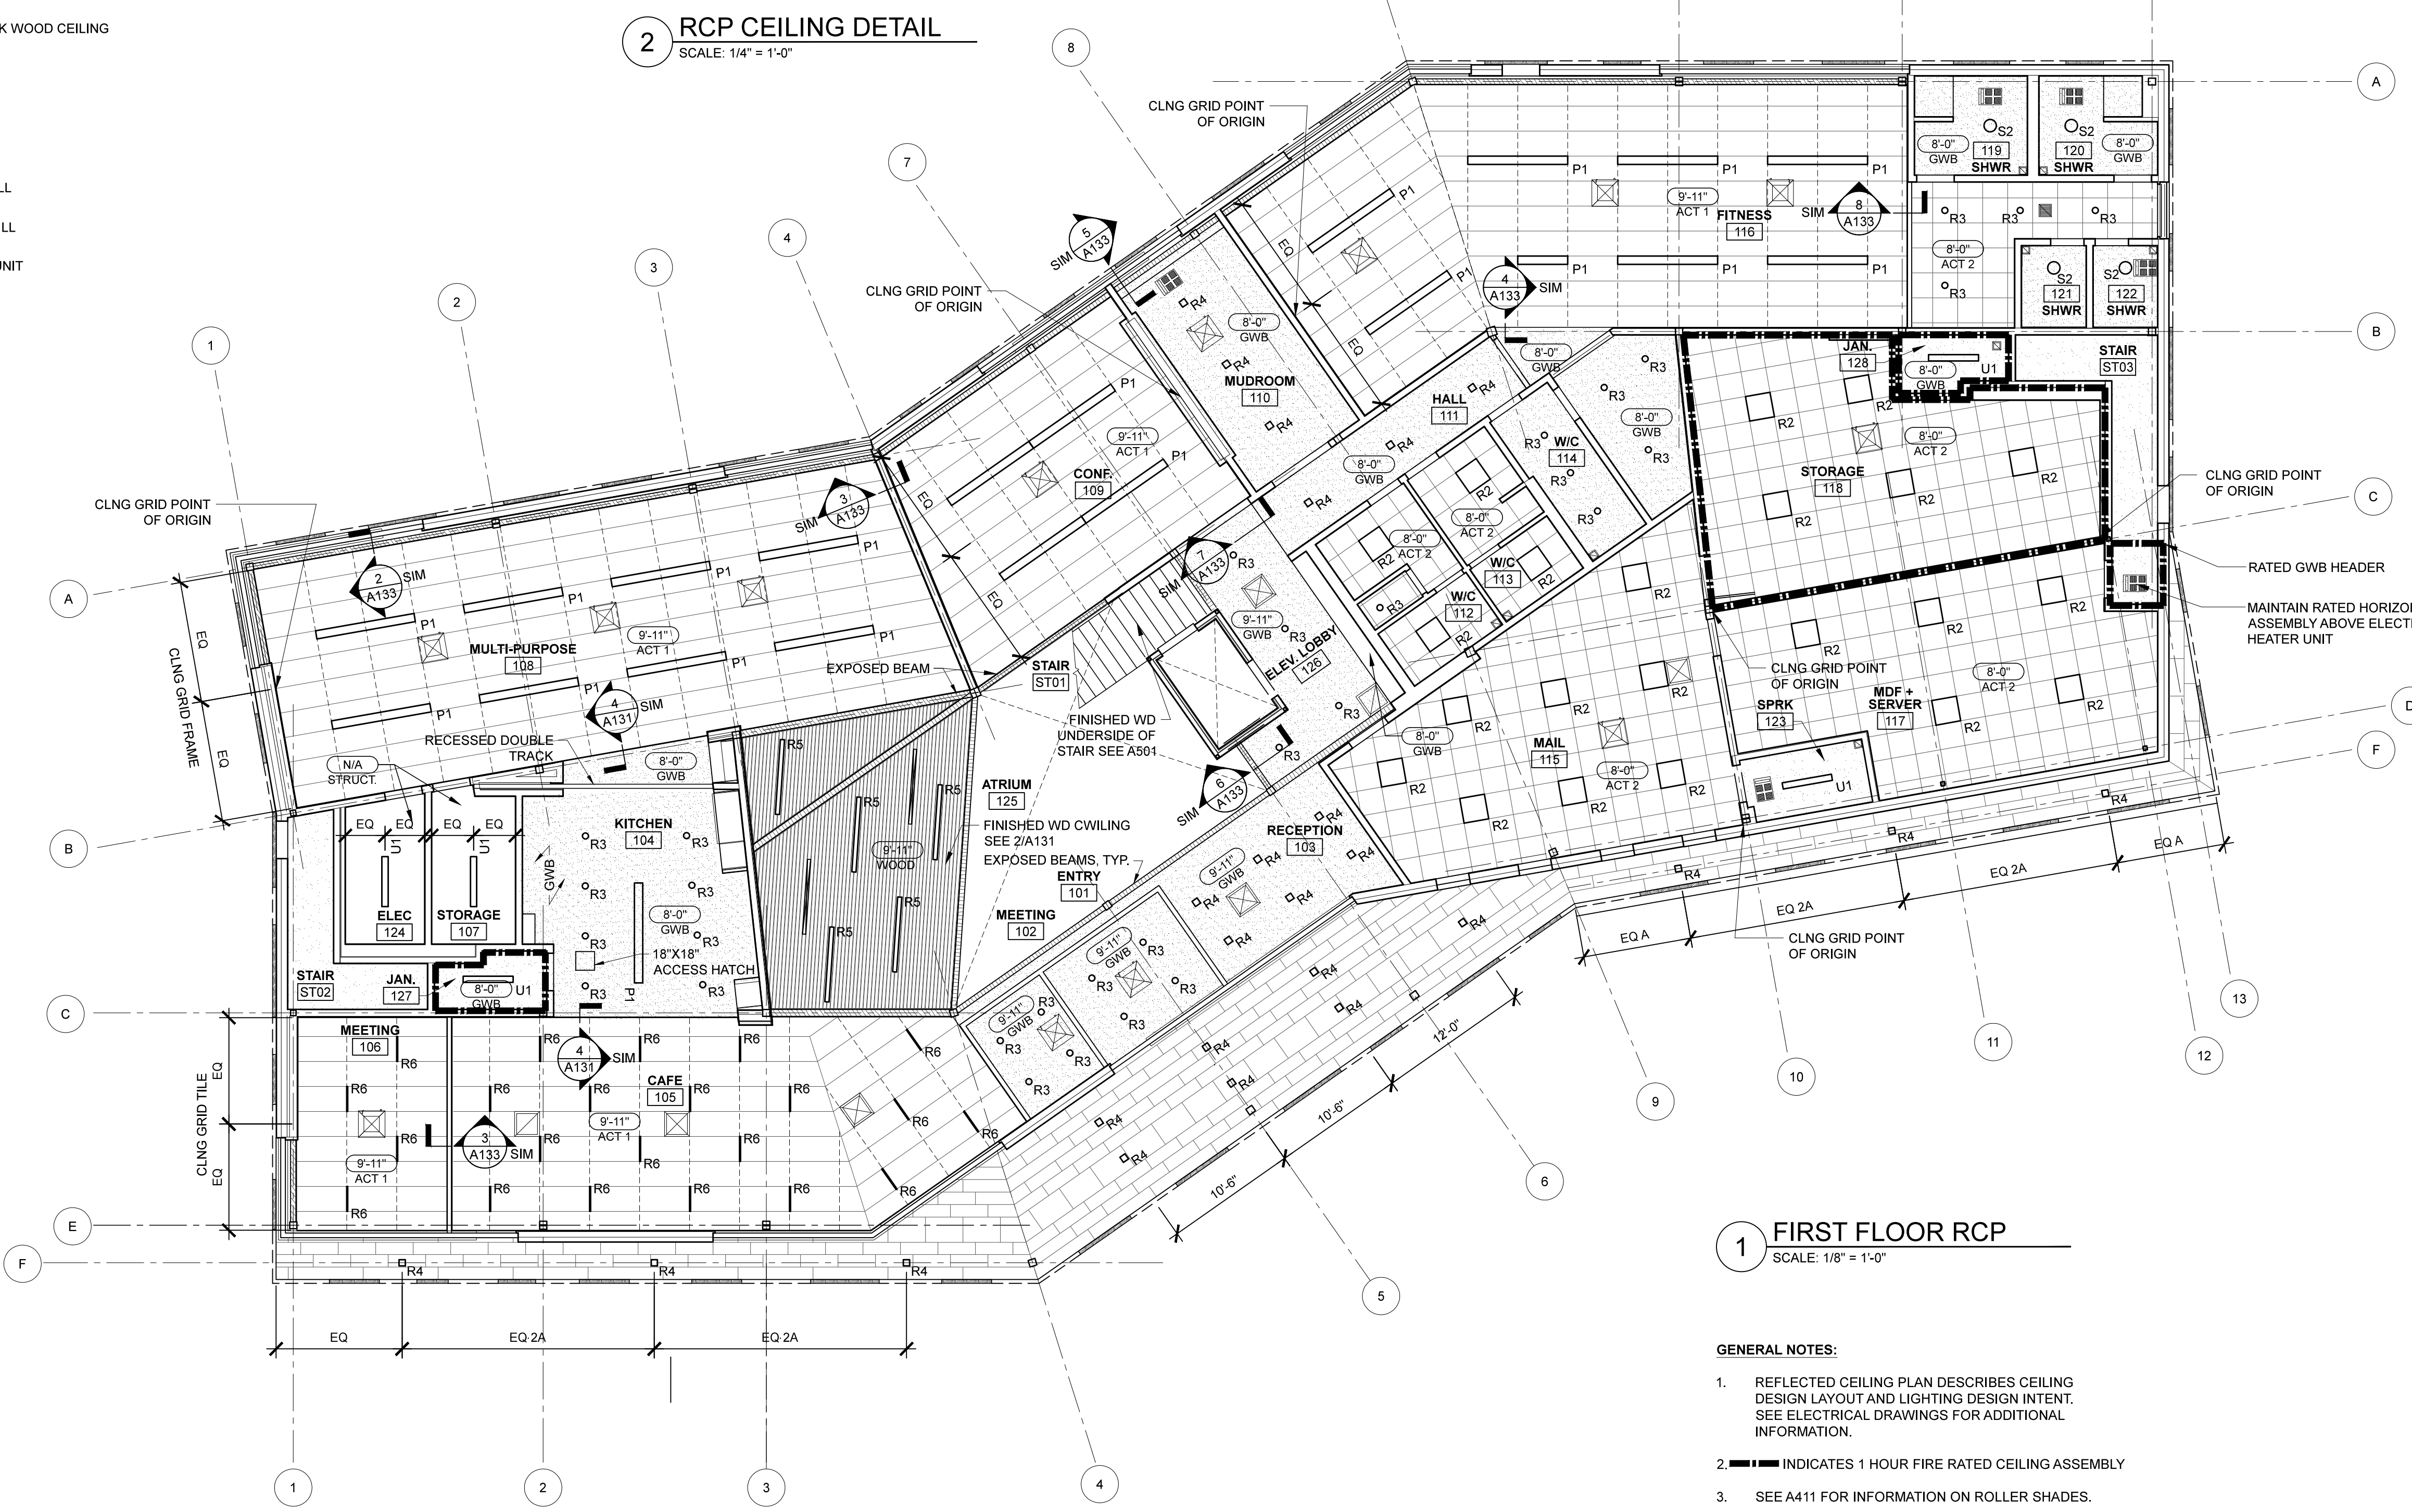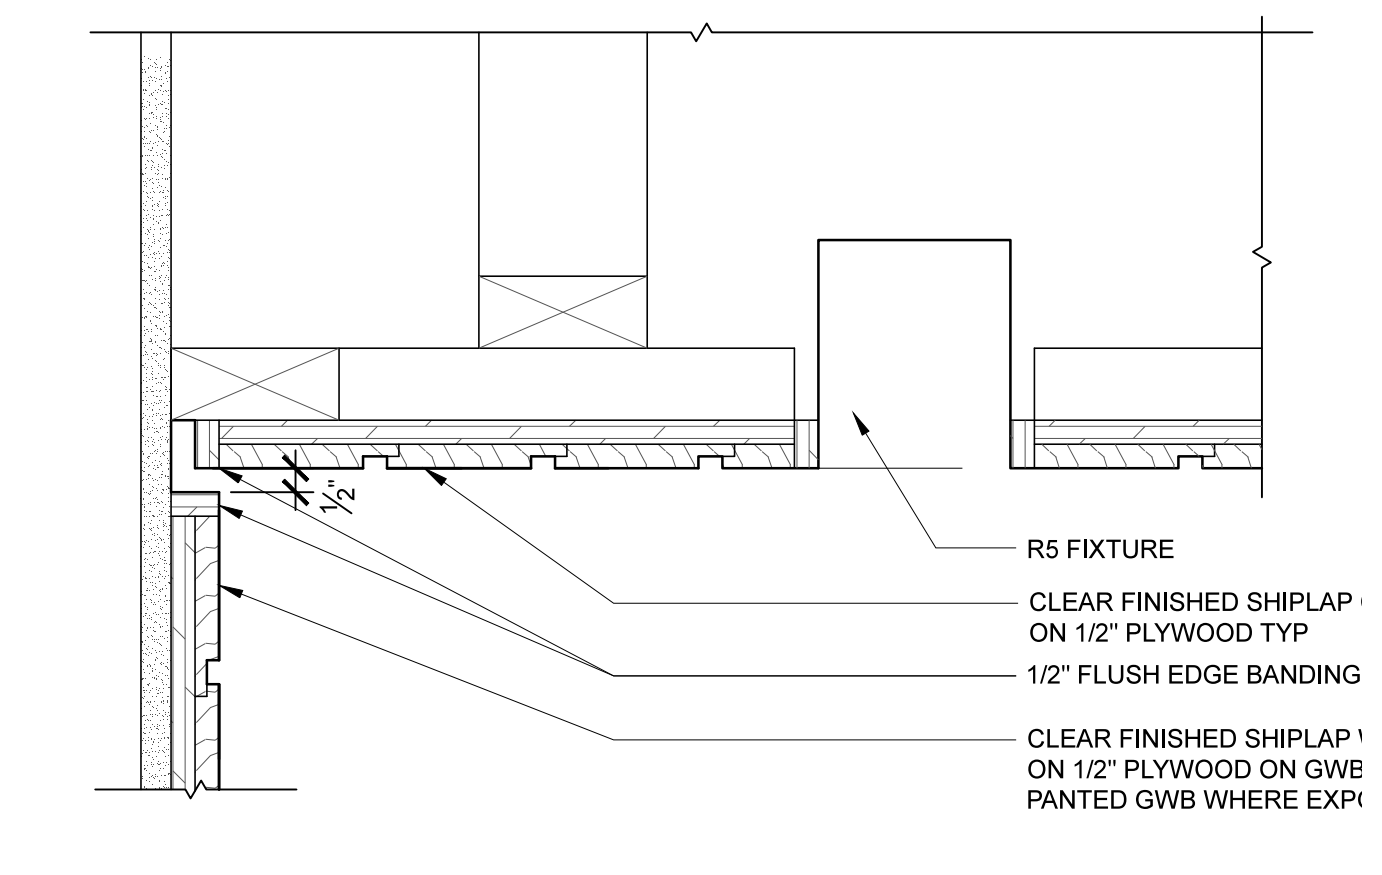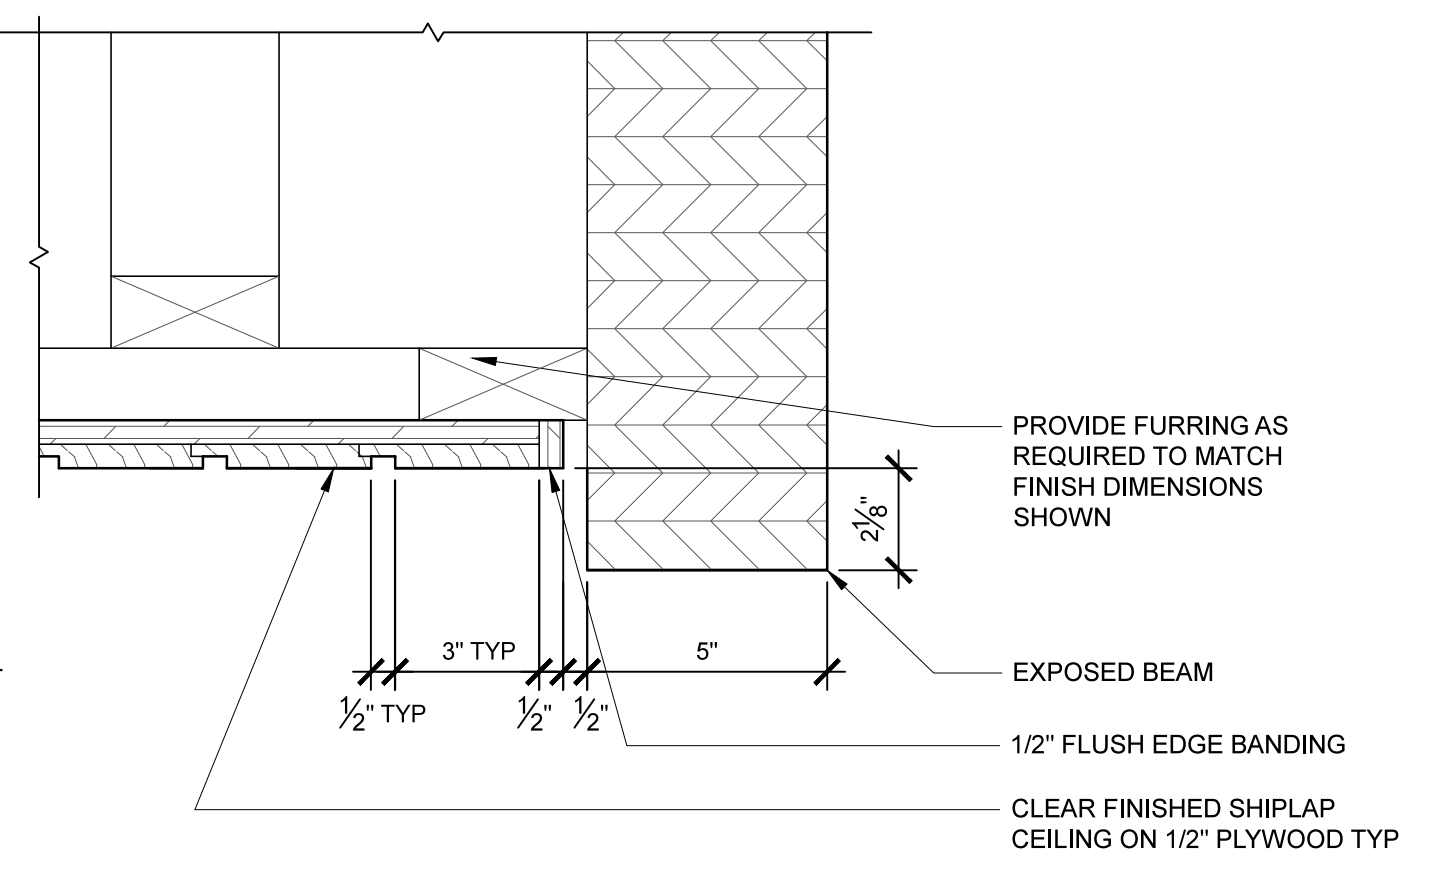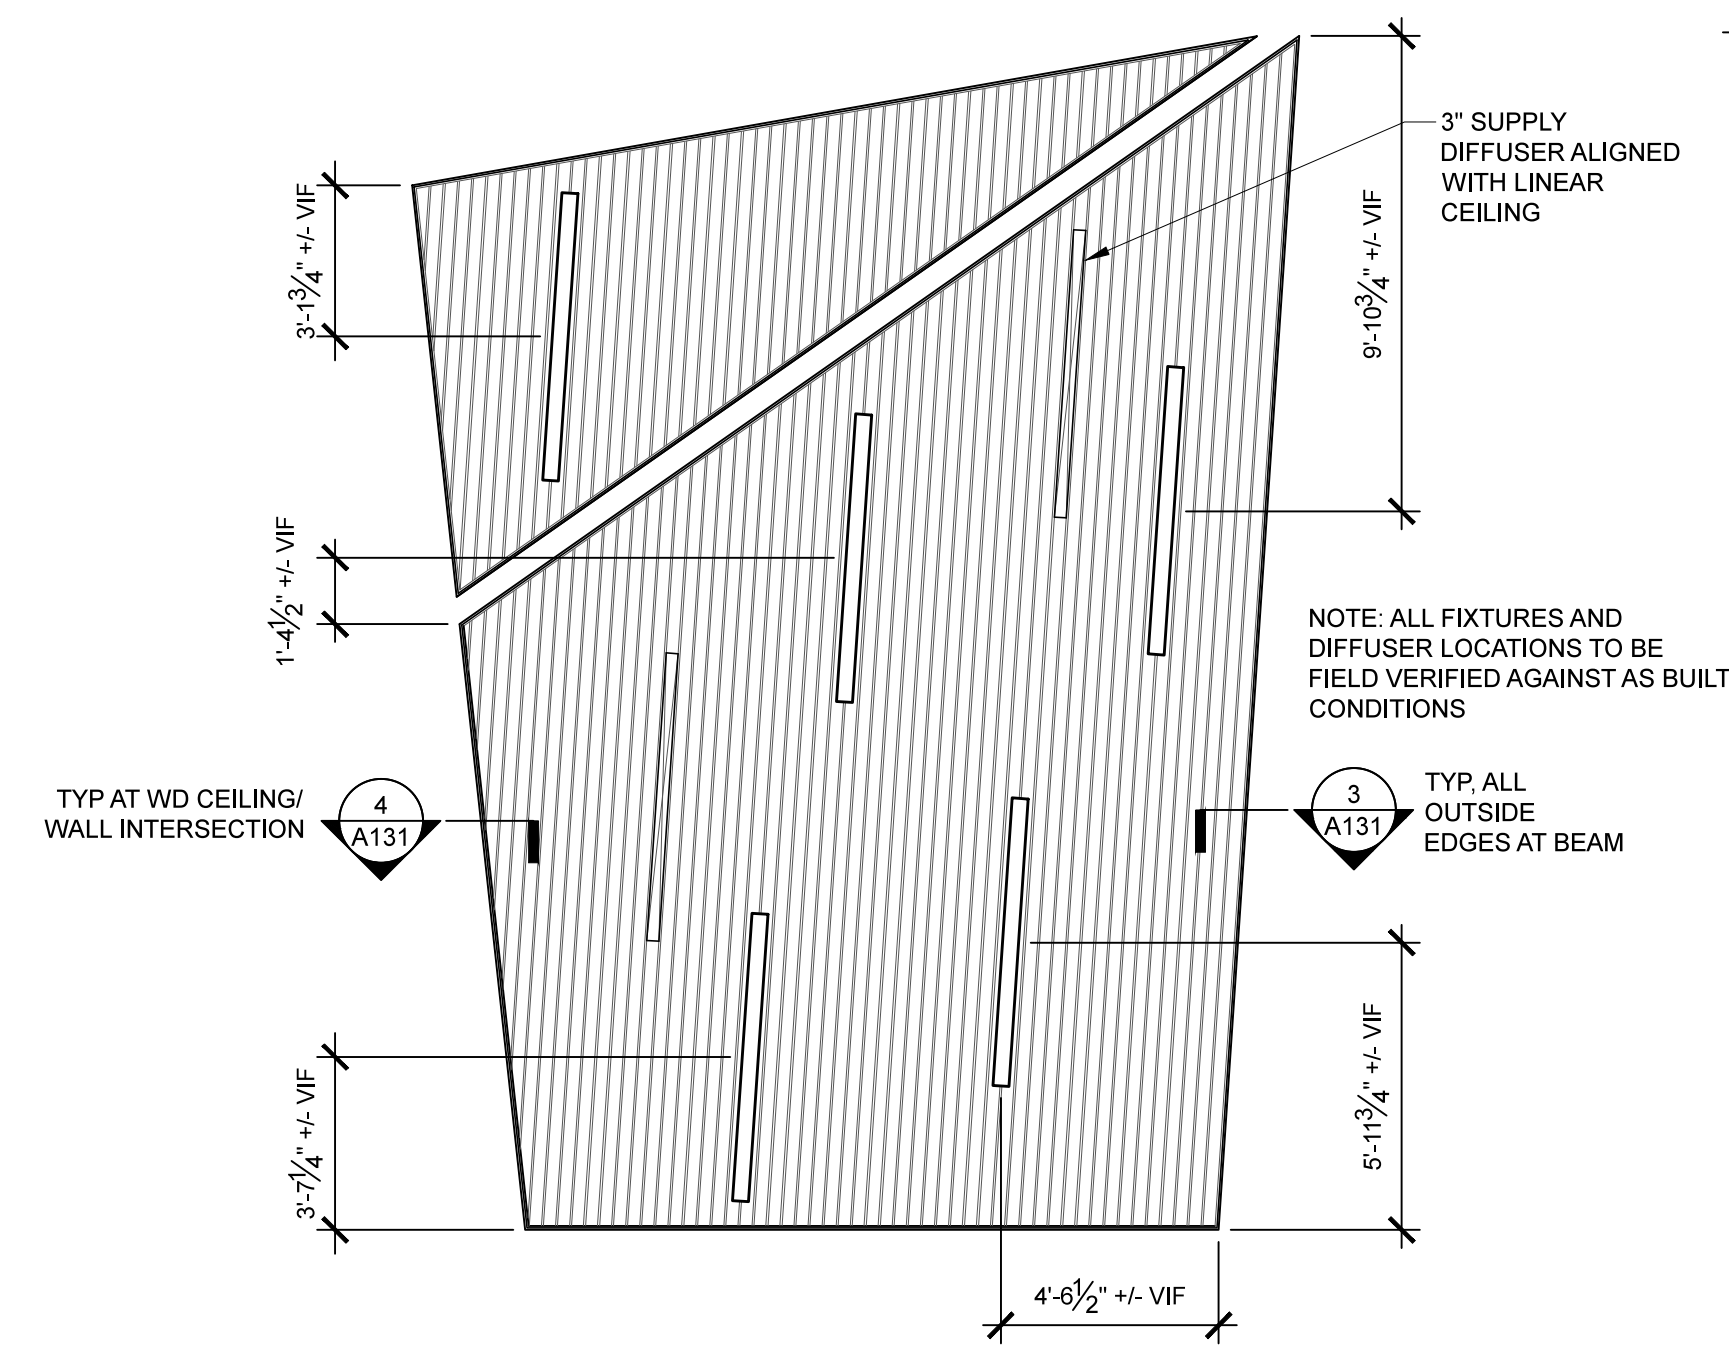

**1 FIRST FLOOR RCP**  
SCALE: 1/8" = 1'-0"

- GENERAL NOTES:**
- REFLECTED CEILING PLAN DESCRIBES CEILING DESIGN LAYOUT AND LIGHTING DESIGN INTENT. SEE ELECTRICAL DRAWINGS FOR ADDITIONAL INFORMATION.
  - INDICATES 1 HOUR FIRE RATED CEILING ASSEMBLY
  - SEE A411 FOR INFORMATION ON ROLLER SHADES.