

THIS DRAWING IS THE PROPERTY OF SCOTT SIMONS ARCHITECTS (SSA) AND IS NOT TO BE COPIED OR REPRODUCED IN PART OR WHOLE 2016 © SCOTT SIMONS ARCHITECTS, LLC

REVISION:

1	DATE
2	DATE
3	DATE
4	DATE
5	DATE
6	DATE


DATE OF ISSUE: 14 JANUARY 2016
PROJECT NUMBER: 2105-0100 PATRONS OXFORD
STATUS: CONSTRUCTION DOCUMENTS

SECOND FLOOR REFLECTED CEILING PLAN

A132

- LEGEND**
- R1 - RECESSED LINEAR FIXTURE
 - R2 - RECESSED RECTANGULAR FIXTURE
 - R3 - RECESSED ROUND DOWN LIGHT
 - R4 - RECESSED SQUARE DOWN LIGHT
 - R5 - RECESSED LINEAR FIXTURE
 - R6 - RECESSED LINEAR T-BAR FIXTURE
 - S1 - SURFACE MOUNTED FIXTURE
 - S2 - SURFACE MOUNTED WET LOCATION FIXTURE
 - P1 - LINEAR DIRECT PENDANT FIXTURE
 - P2 - LED PENDANT FIXTURE
 - P3 - LINEAR DIRECT/INDIRECT PENDANT FIXTURE
 - P5 - DECORATIVE PENDANT FIXTURE
 - W1 - WALL WASHING FIXTURE
 - U1 - UTILITY LIGHT

- ACT 1
2' x 4' PANELS
- ACT 2
2' x 2' PANELS
- LINEAR/DECK WOOD CEILING
- GWB
- SUPPLY GRILL
- RETURN GRILL
- CASSETTE UNIT

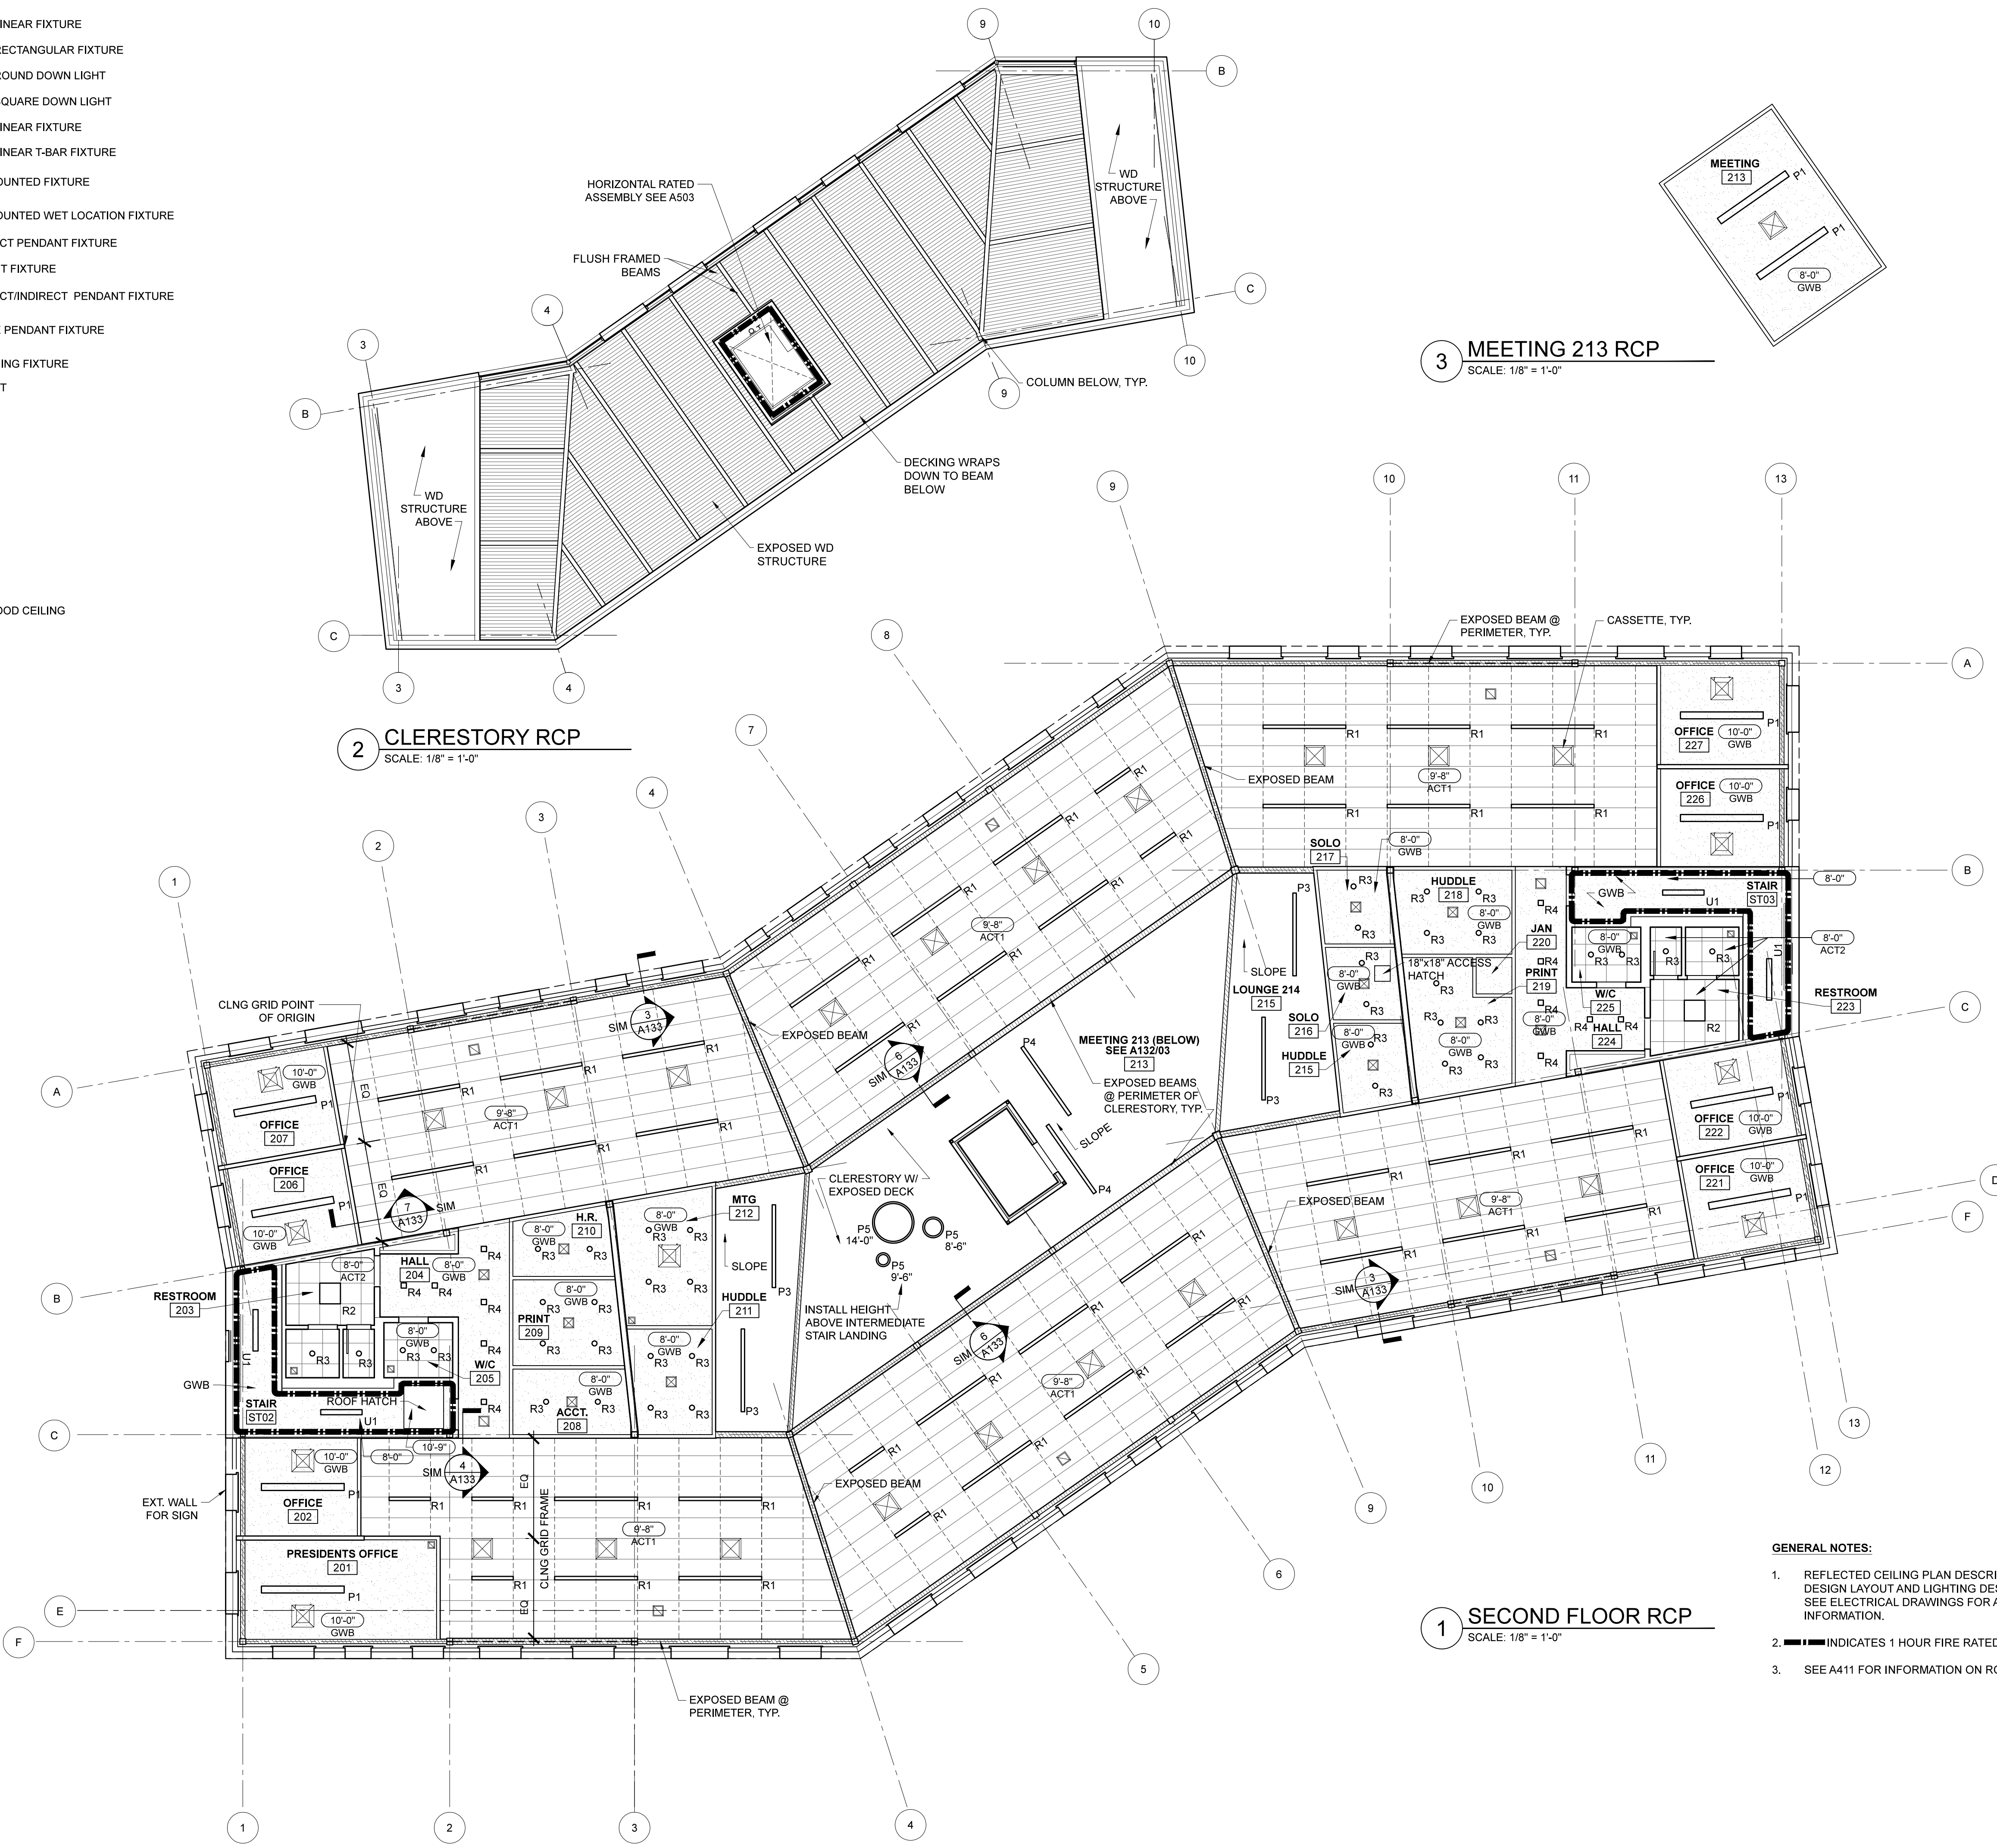

2 CLERESTORY RCP
SCALE: 1/8" = 1'-0"

3 MEETING 213 RCP
SCALE: 1/8" = 1'-0"

1 SECOND FLOOR RCP
SCALE: 1/8" = 1'-0"

- GENERAL NOTES:**
- REFLECTED CEILING PLAN DESCRIBES CEILING DESIGN LAYOUT AND LIGHTING DESIGN INTENT. SEE ELECTRICAL DRAWINGS FOR ADDITIONAL INFORMATION.
 - INDICATES 1 HOUR FIRE RATED CEILING ASSEMBLY
 - SEE A411 FOR INFORMATION ON ROLLER SHADES.