


- GENERAL NOTES:**
1. REFERENCE CIVIL SITE PLANS FOR COORDINATION WITH OTHER UTILITIES.
 2. REFERENCE SHEET G-01 FOR DRAWING LEGEND AND ABBREVIATIONS.
 3. REFERENCE SHEET E-03 FOR SITE DUCTBANK DETAIL AND REQUIREMENTS.

A

B

D

\\BANGOR\Projects\90000 Bangor General Office\203848.63\Rand Road\2013.01.18 Construction Drawings\Electrical CO #3\CAD Drawings\EI20384863-E01_E02.dwg, Jan 18, 2013 - 10:49am

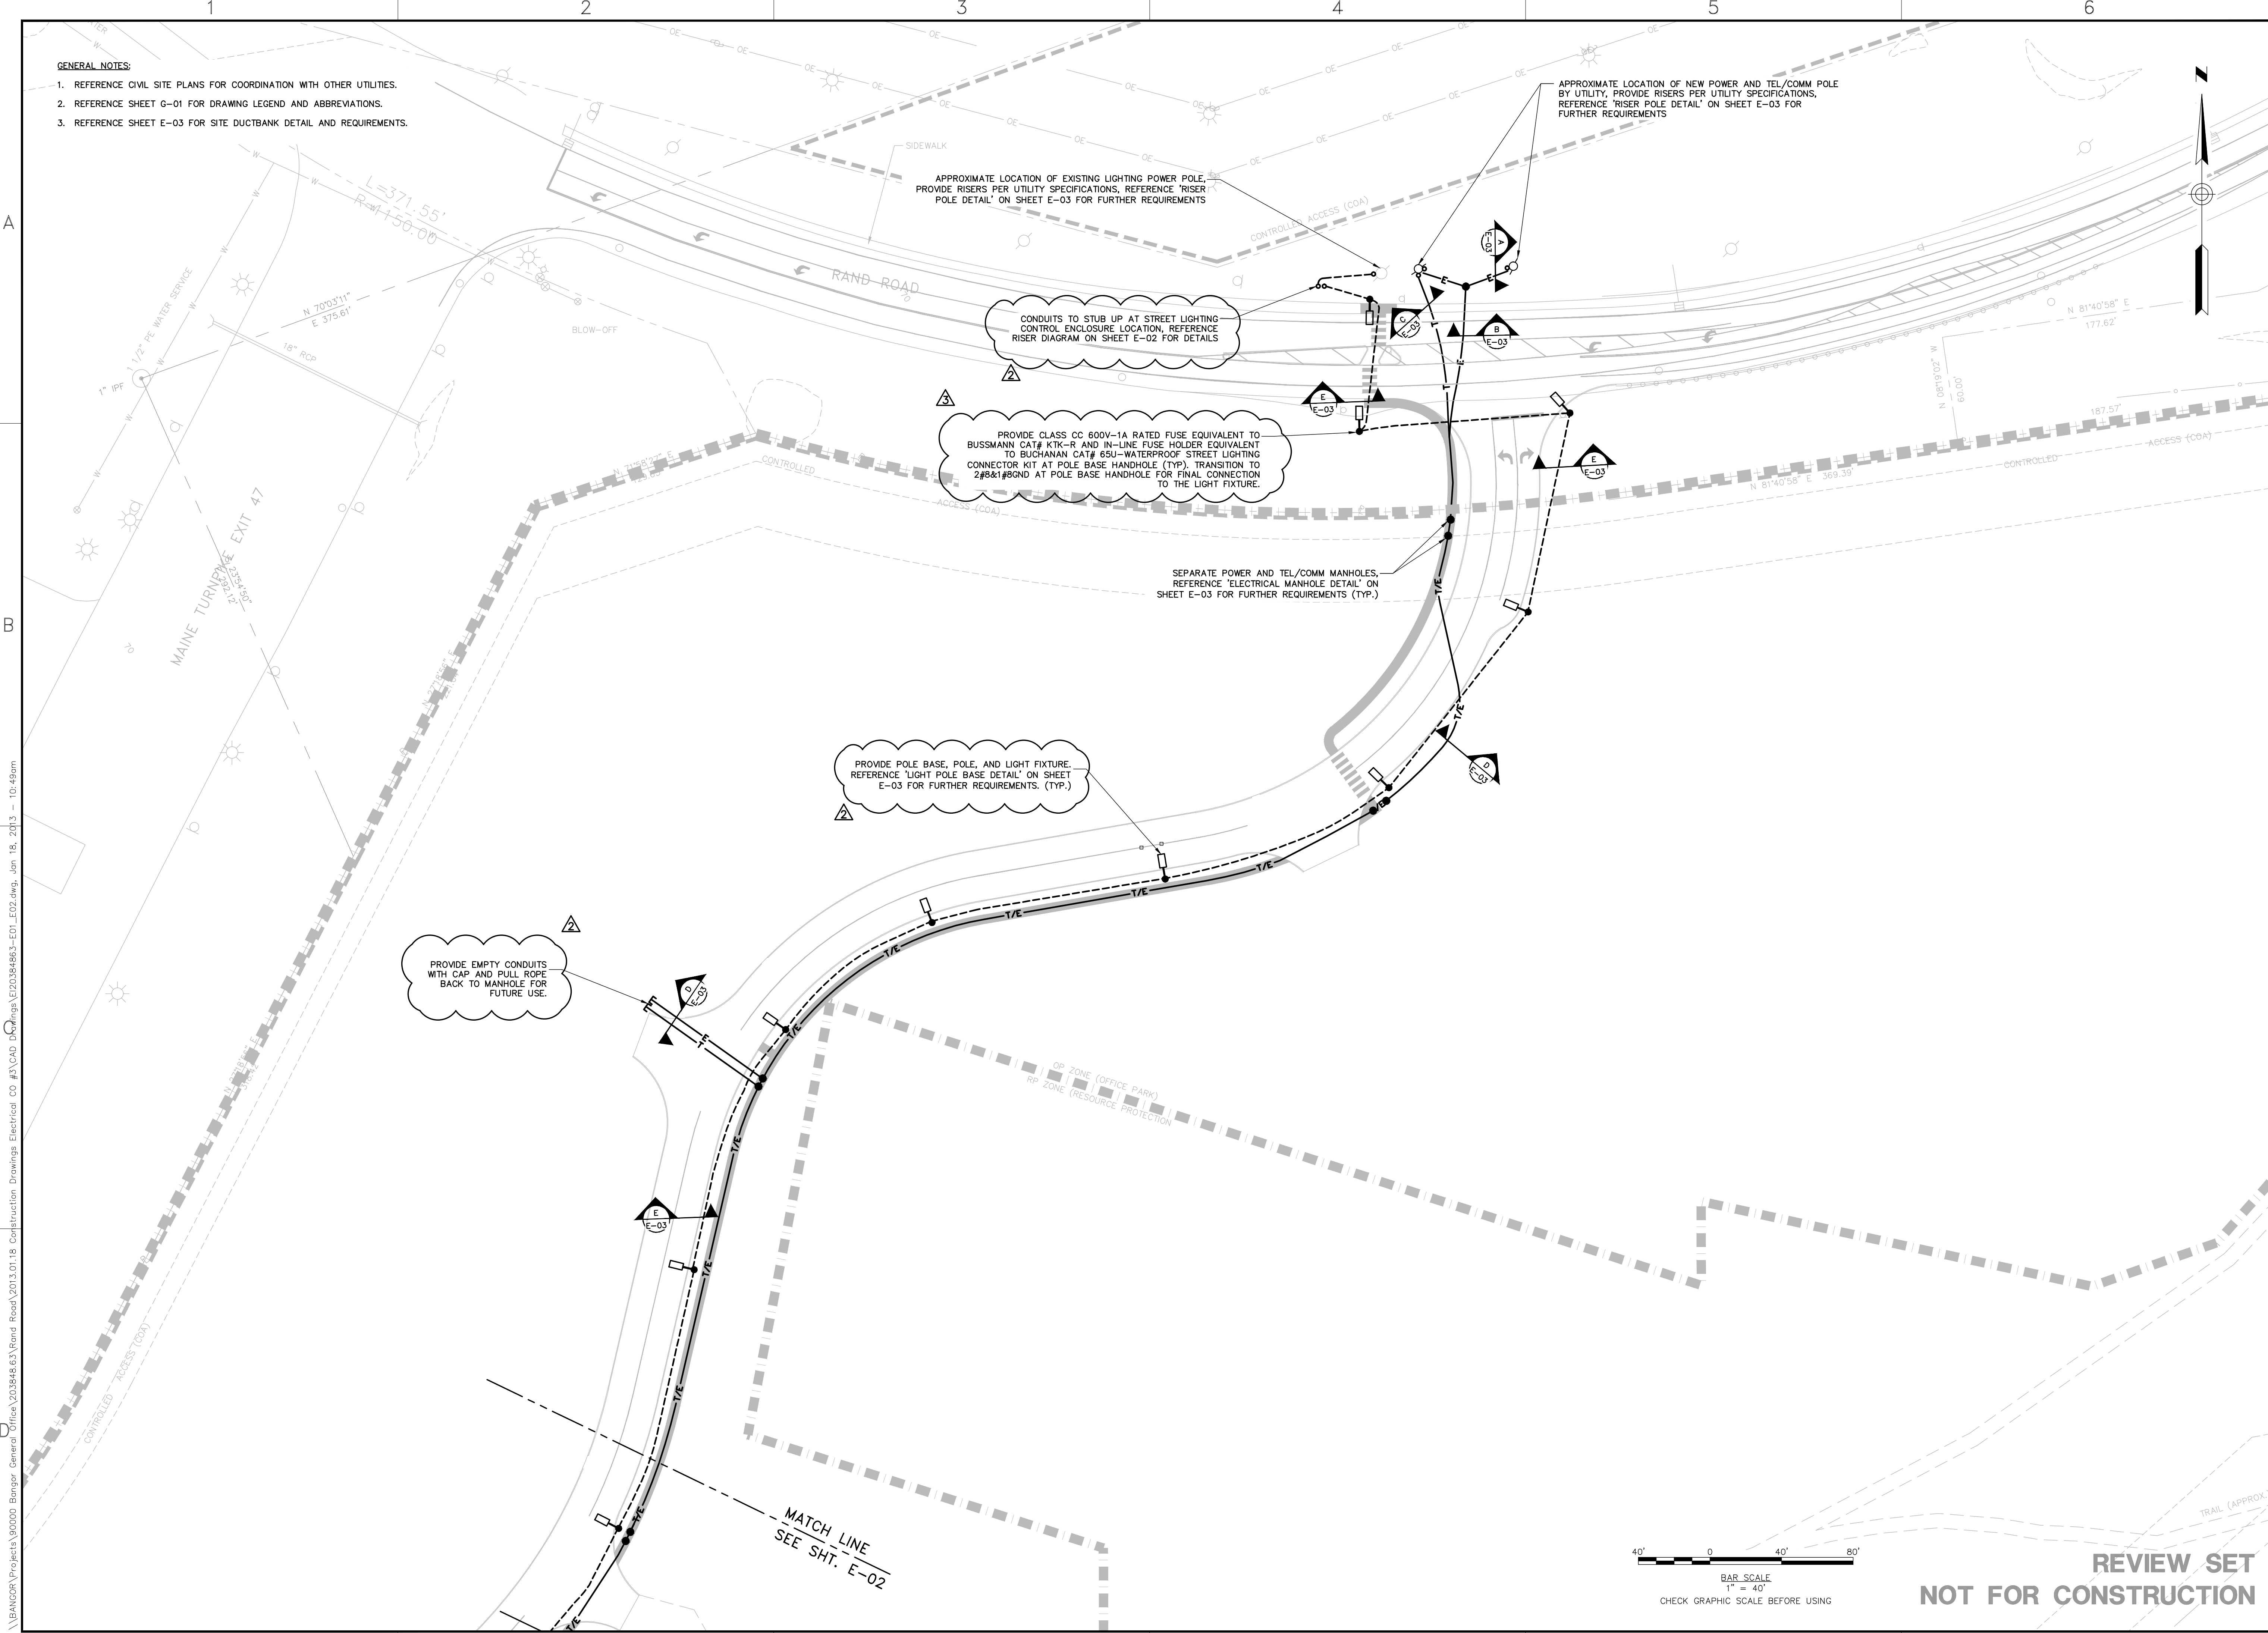


41 Hucklebush Drive
Portland, Maine 04102
800.426.4262 | www.woodardcurran.com

WOODARD & CURRAN

COMMITMENT & INTEGRITY DRIVE RESULTS

THIS DOCUMENT IS THE PROPERTY OF WOODARD & CURRAN, INC. AND ITS CLIENT. IT IS TO BE USED ONLY FOR THE PROJECT AND SITE SPECIFICALLY IDENTIFIED HEREIN.

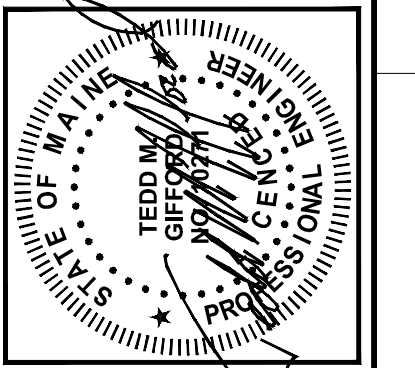

REV	DESCRIPTION	DATE	CHECKED BY	DATE
1	ISSUED FOR BID	8/12/12	SEH	TMG
2	LIGHTING CHANGE ORDER	1/11/13	SEH	TMG
3	FUSE HOLDER CHANGE ORDER	1/18/13	SEH	TMG


ELECTRICAL SITE PLAN 1

CITY OF PORTLAND
ECONOMIC DEVELOPMENT OFFICE
PORTLAND, MAINE

PORTLAND TECHNOLOGY PARK

JOB NO.: 203848.63
DATE: AUGUST 12, 2012
SCALE: AS NOTED
SHEET: 20 OF 22

E-01

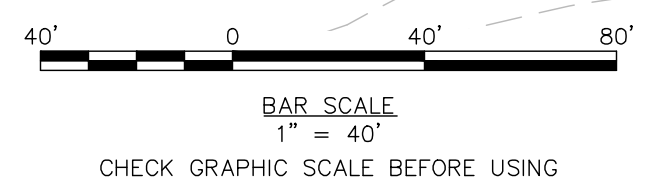

REVIEW SET
NOT FOR CONSTRUCTION

A

B

D

\\BANGOR\Projects\90000 Bangor General Office\203848.63\Rand Road\2013.01.18 Construction Drawings\Electrical CO #3\CAD Drawings\EI20384863-E01_E02.dwg, Jan 18, 2013 - 10:49am