


Scott Simons Architects  
75 York Street, Portland, Maine 04101  
www.simonsarchitects.com  
207.772.4656

**Allied Engineering**  
Structural Mechanical Electrical Commissioning  
160 Veranda Street  
Portland, Maine 04103  
T: 207.221.2260  
F: 207.221.2266  
Web: www.allied-eng.com

Allied Project No: 15-023  
Cad File: 14023\_M.dwg

PROJECT NAME:  
**PATRONS OXFORD OFFICES**  
PORTLAND TECHNOLOGY PARK  
RAND ROAD, PORTLAND, ME

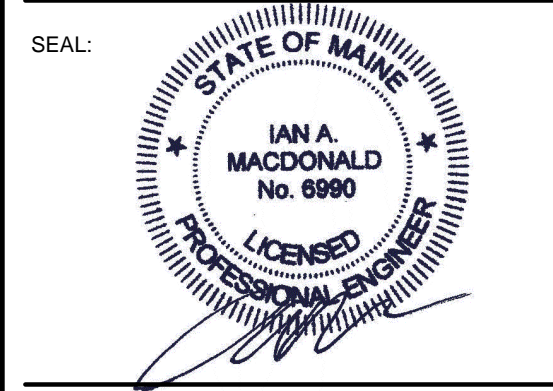

THIS DRAWING IS THE PROPERTY OF SCOTT SIMONS ARCHITECTS (SSA) AND IS NOT TO BE COPIED OR REPRODUCED IN PART OR WHOLE.  
©2015 © SCOTT SIMONS ARCHITECTS, LLC

REVISION:







1	DATE
2	DATE
3	DATE
4	DATE
5	DATE
6	DATE

DATE OF ISSUE: 14 January, 2016  
PROJECT NUMBER: 2105-0100 Patrons Oxford  
STATUS: Construction Documents

**PLUMBING SCHEDULES & DETAILS**

**PL-500**

2015 © Scott Simons Architects, LLC

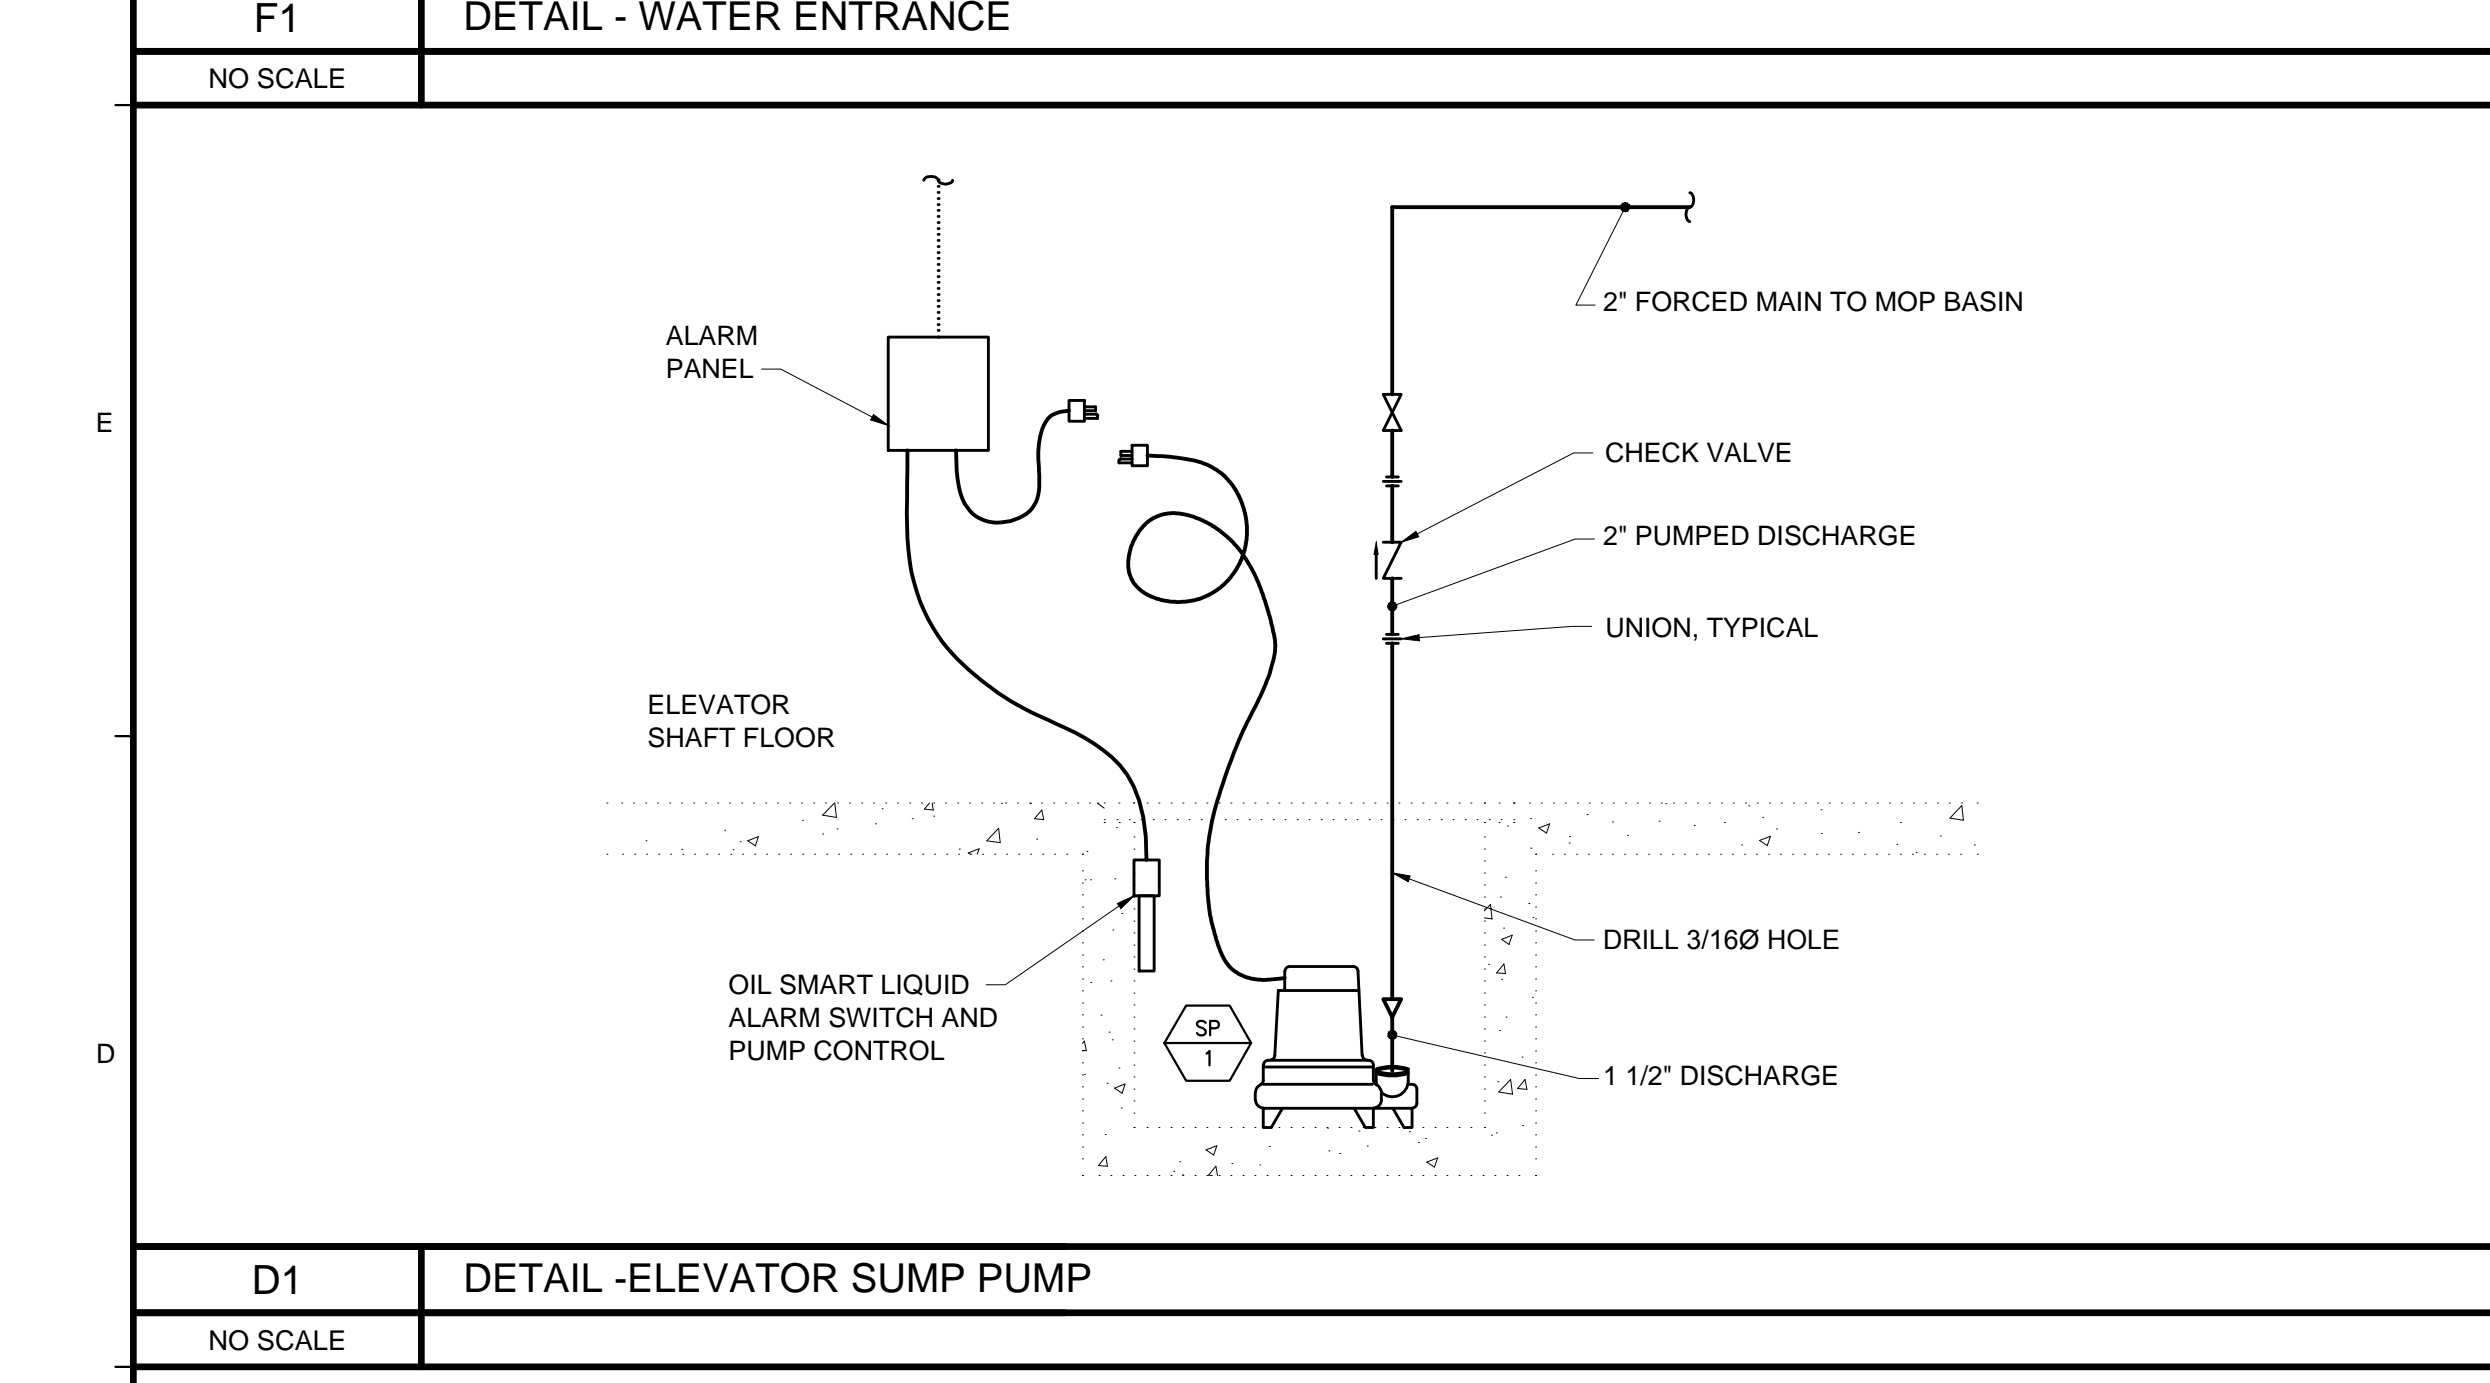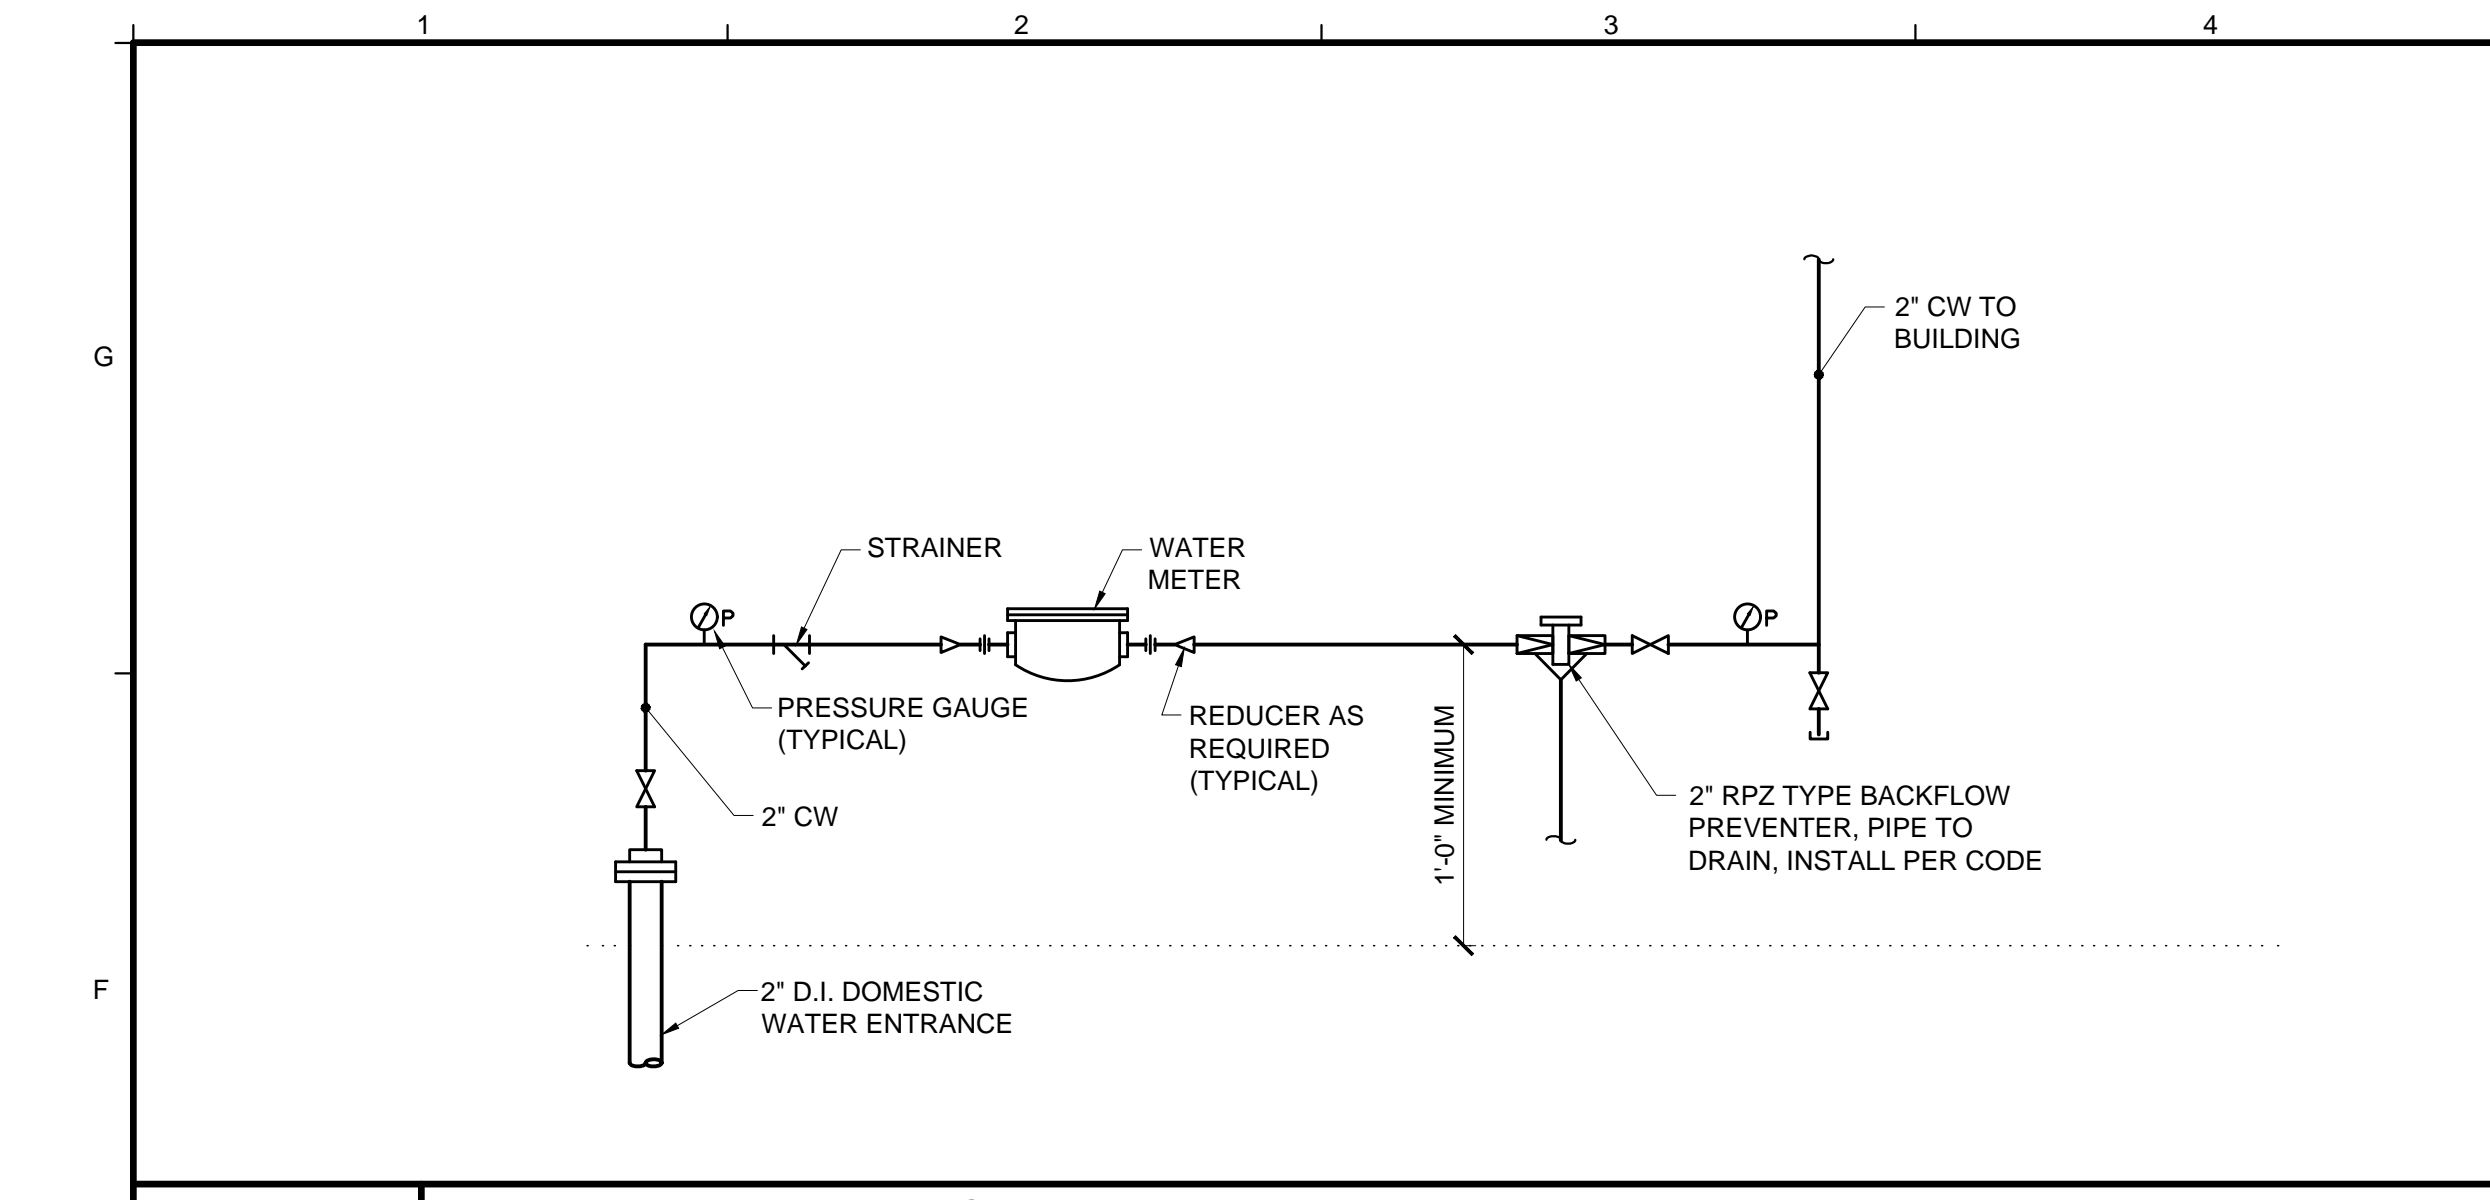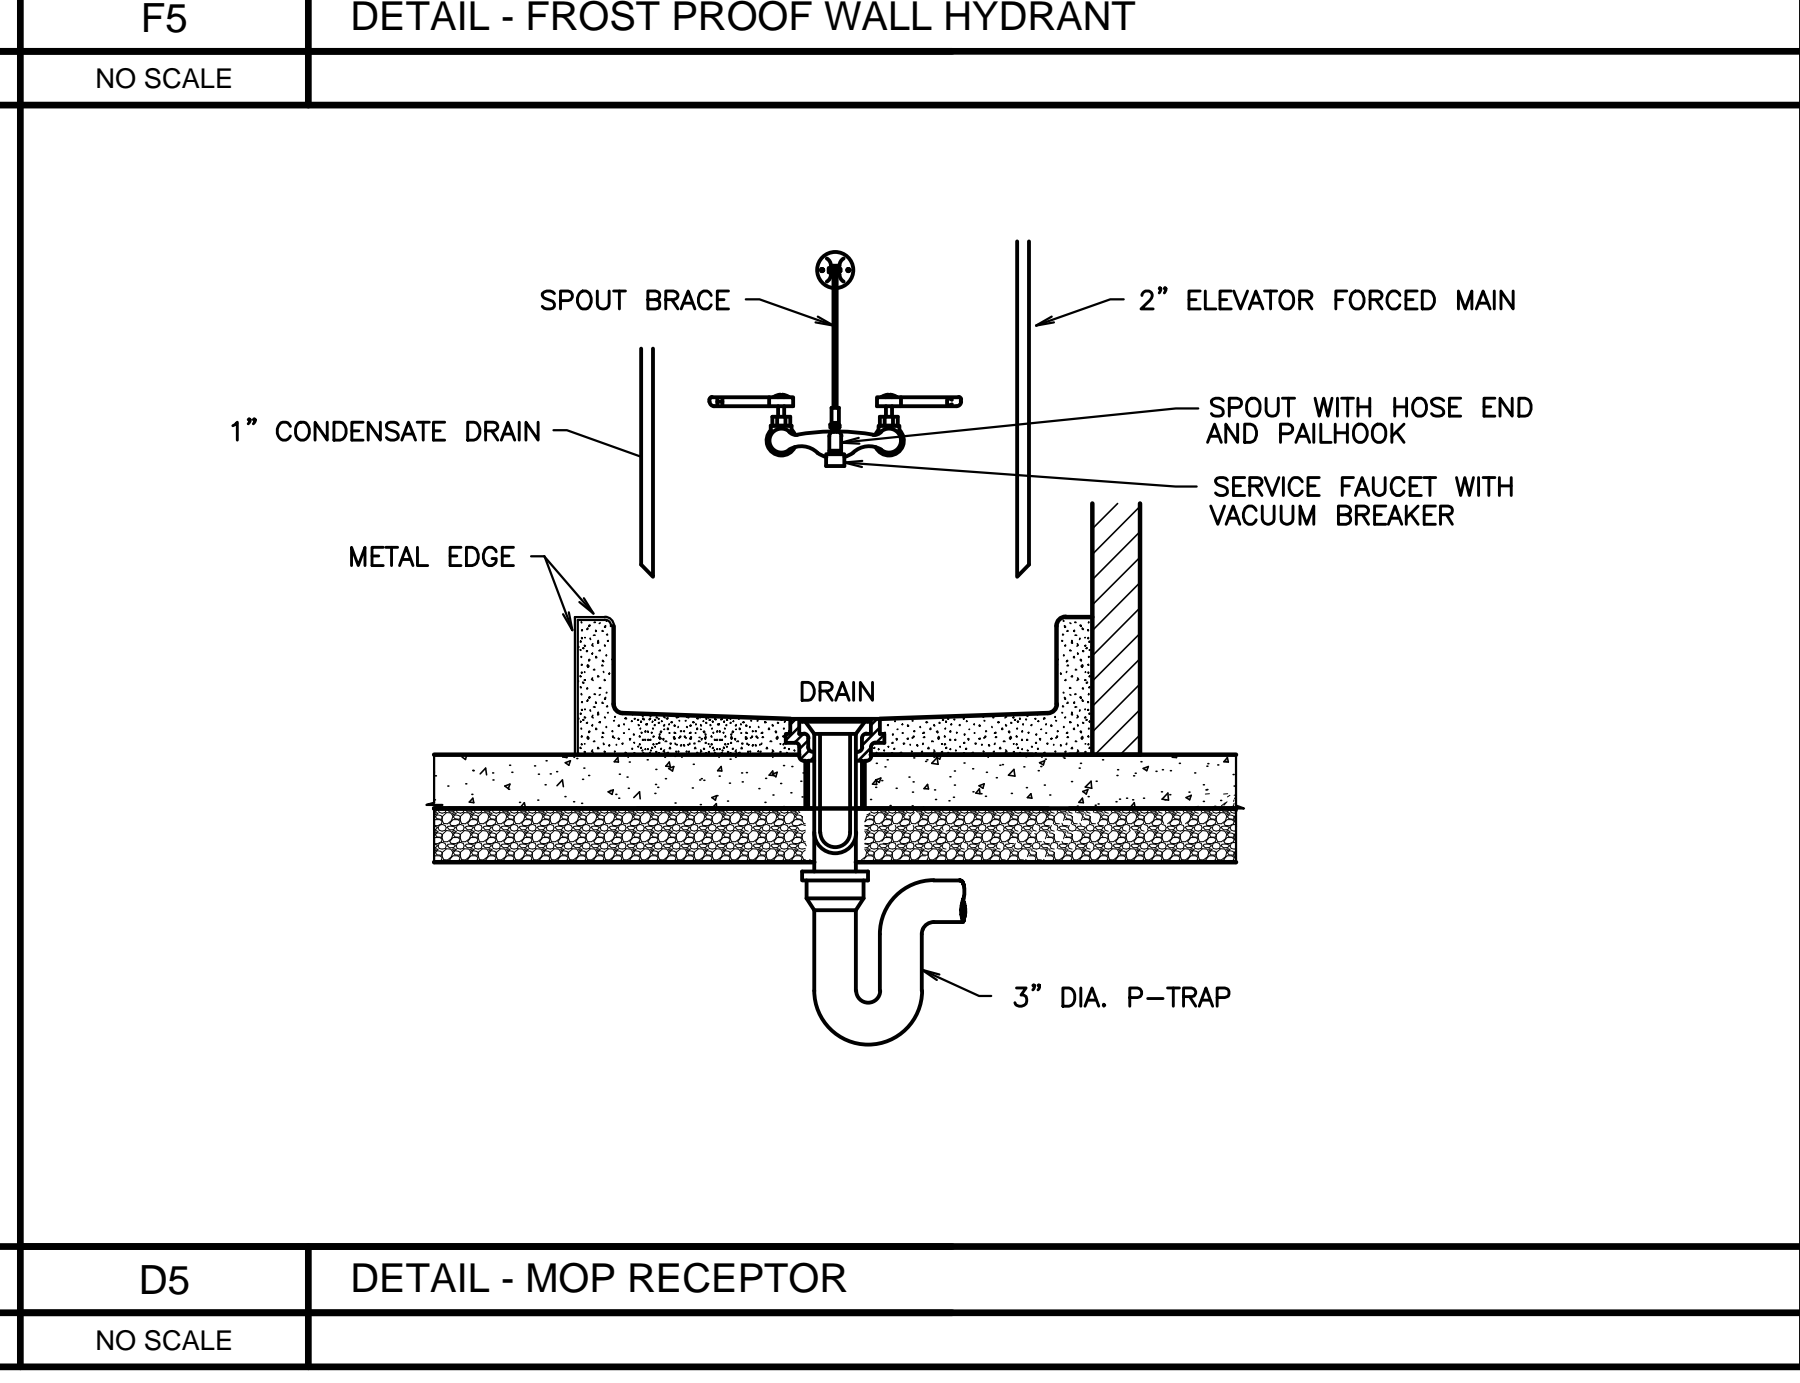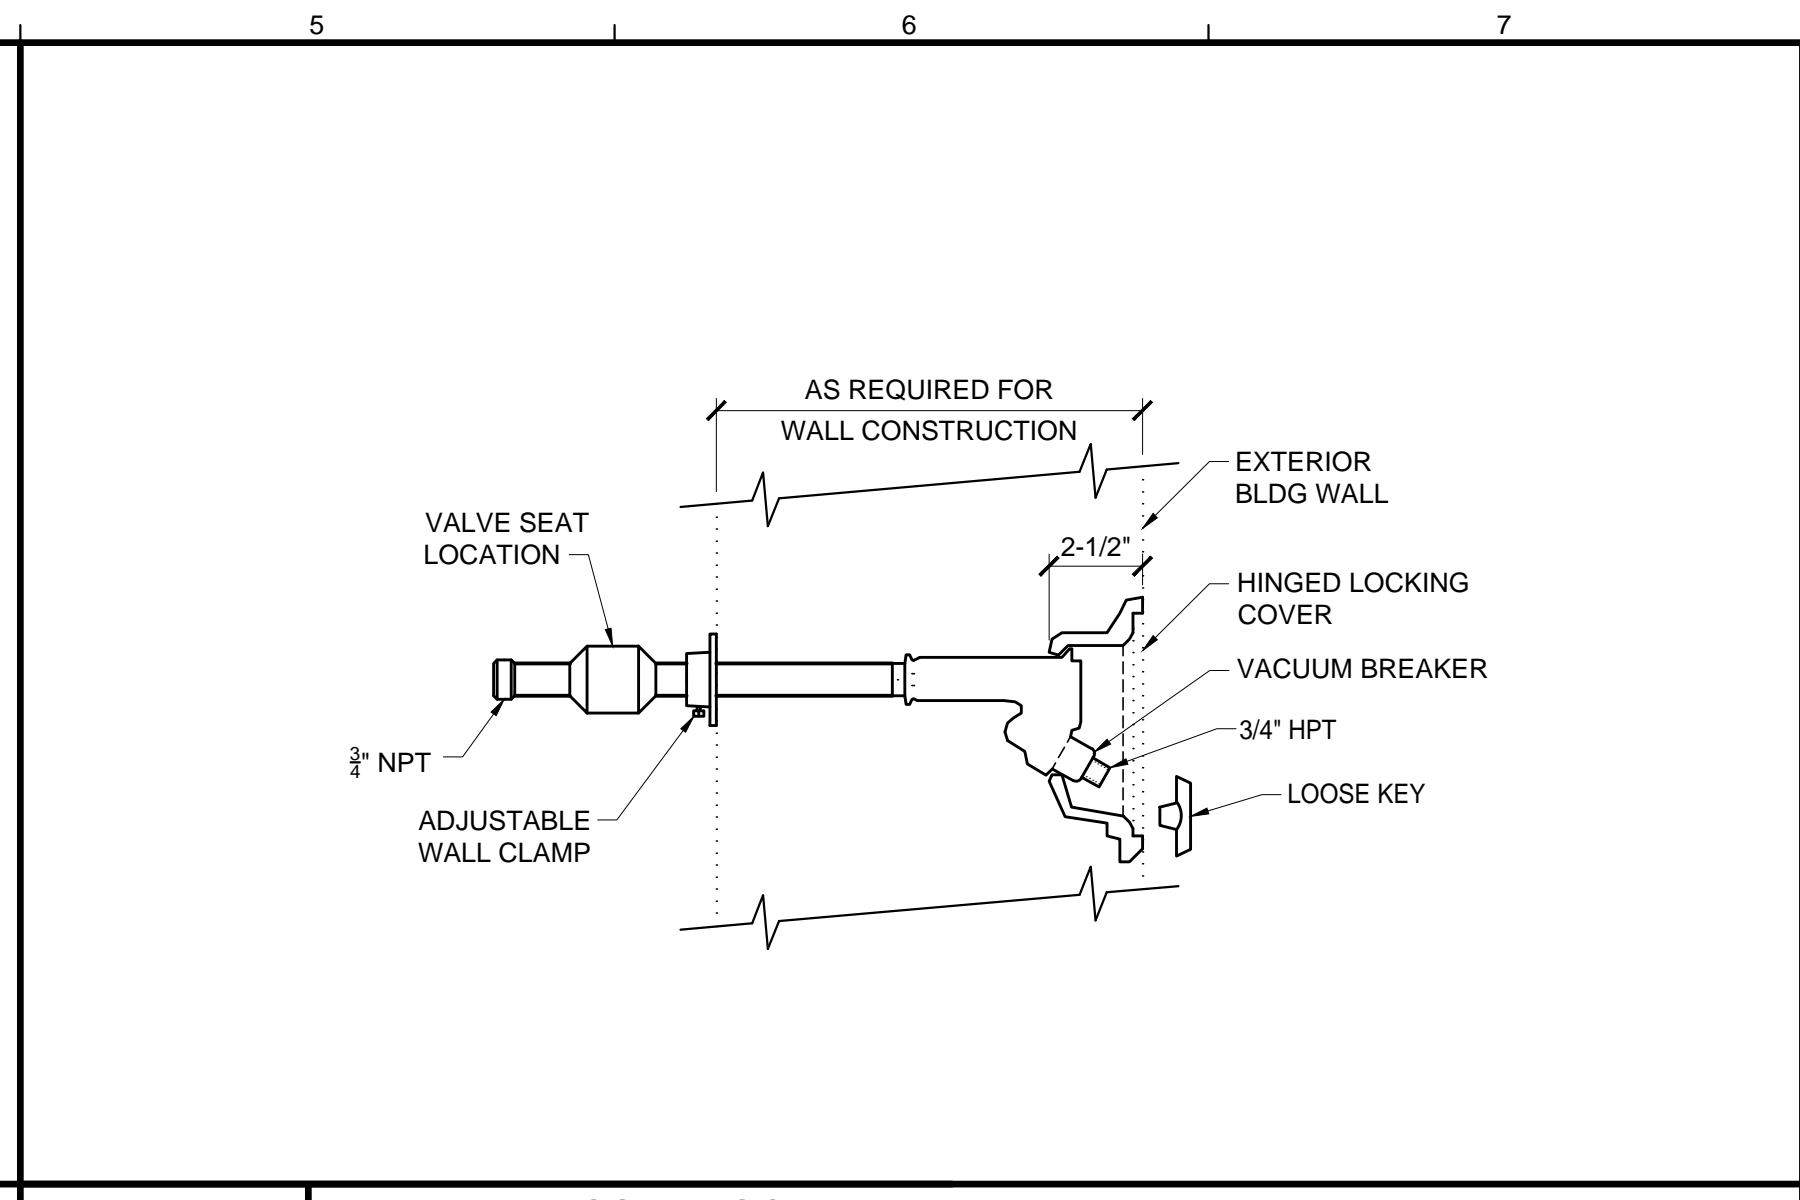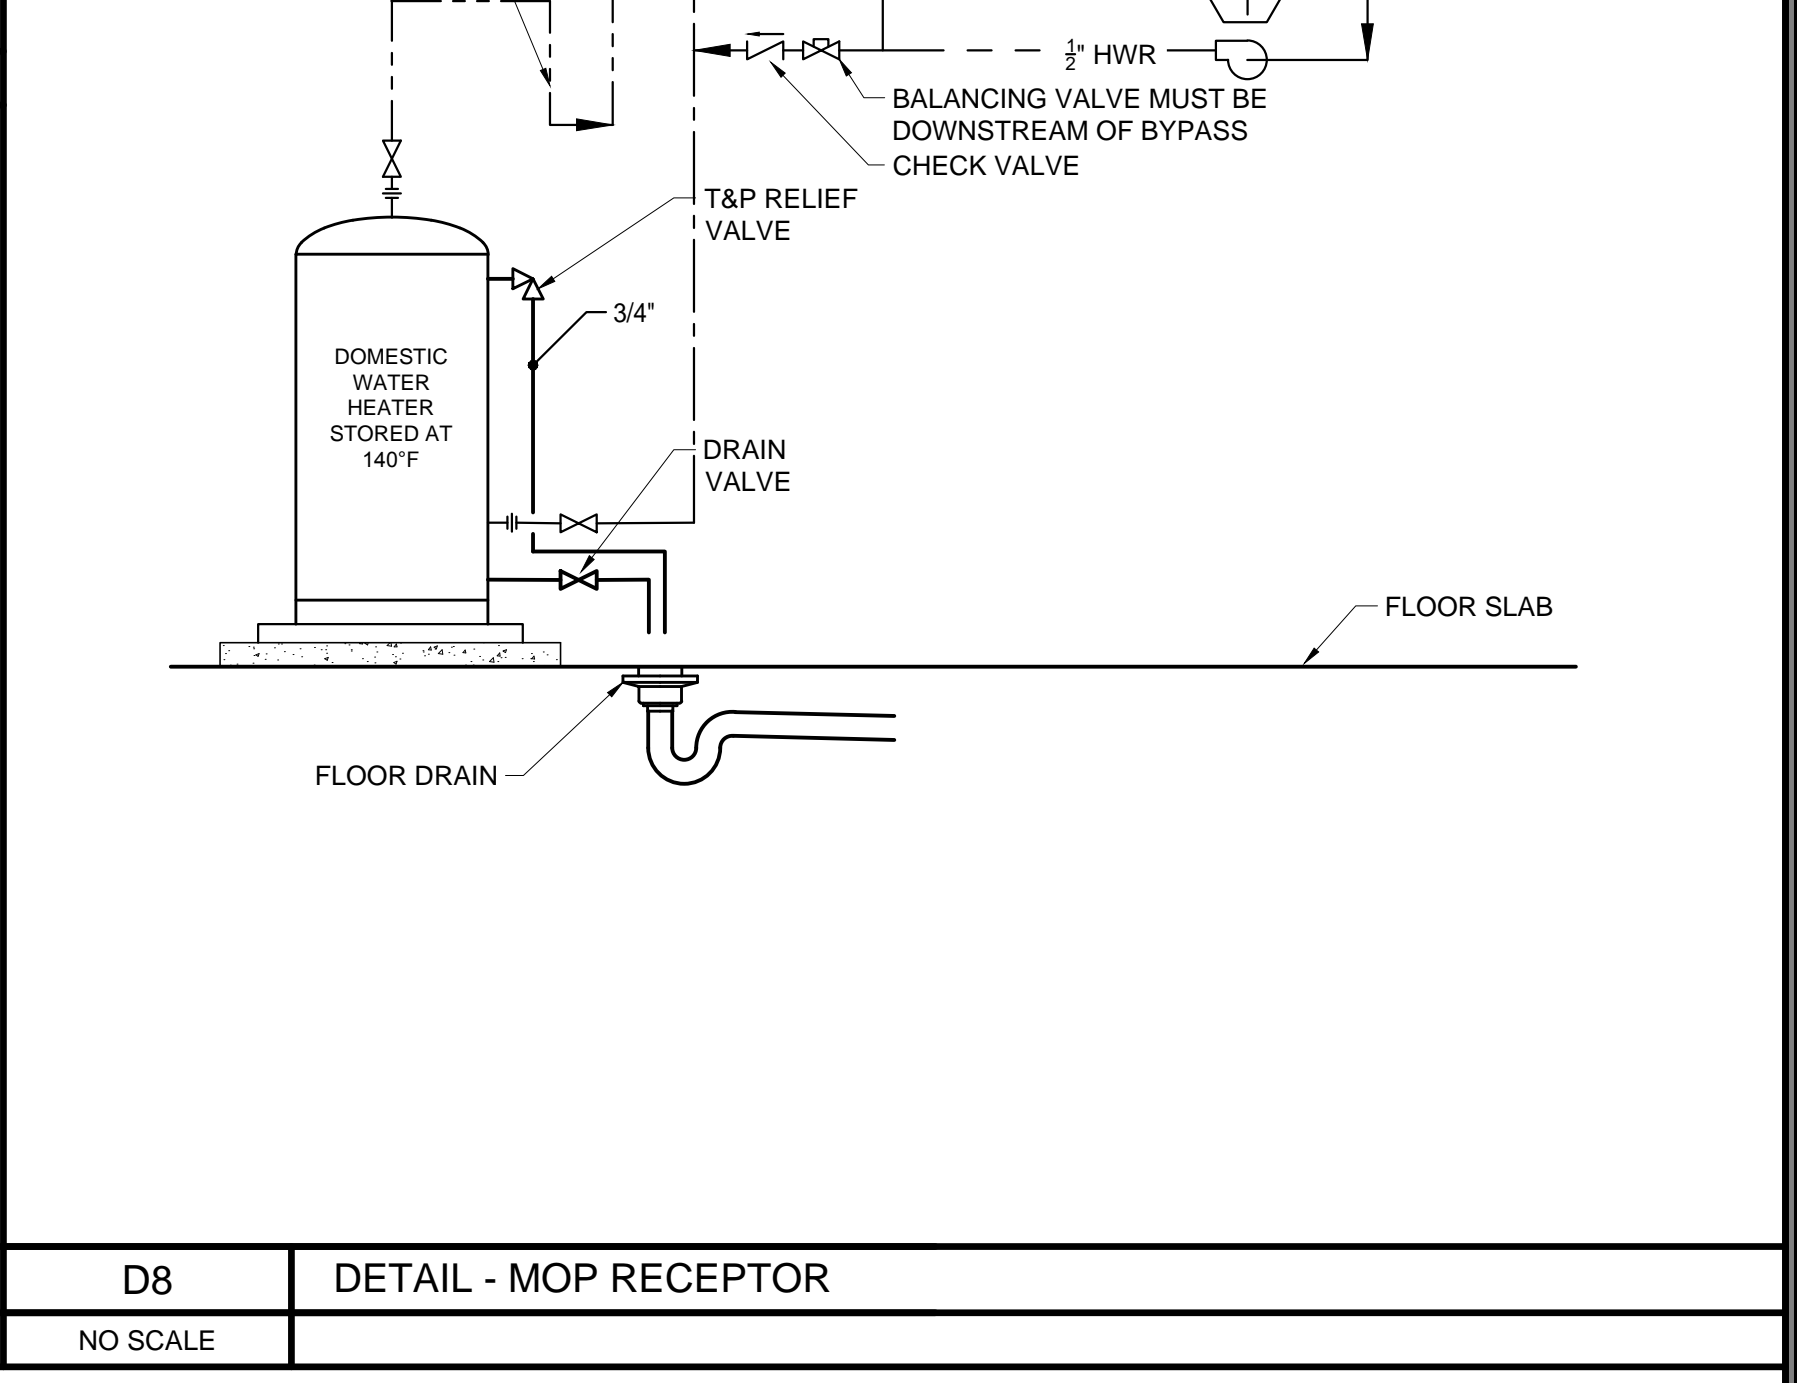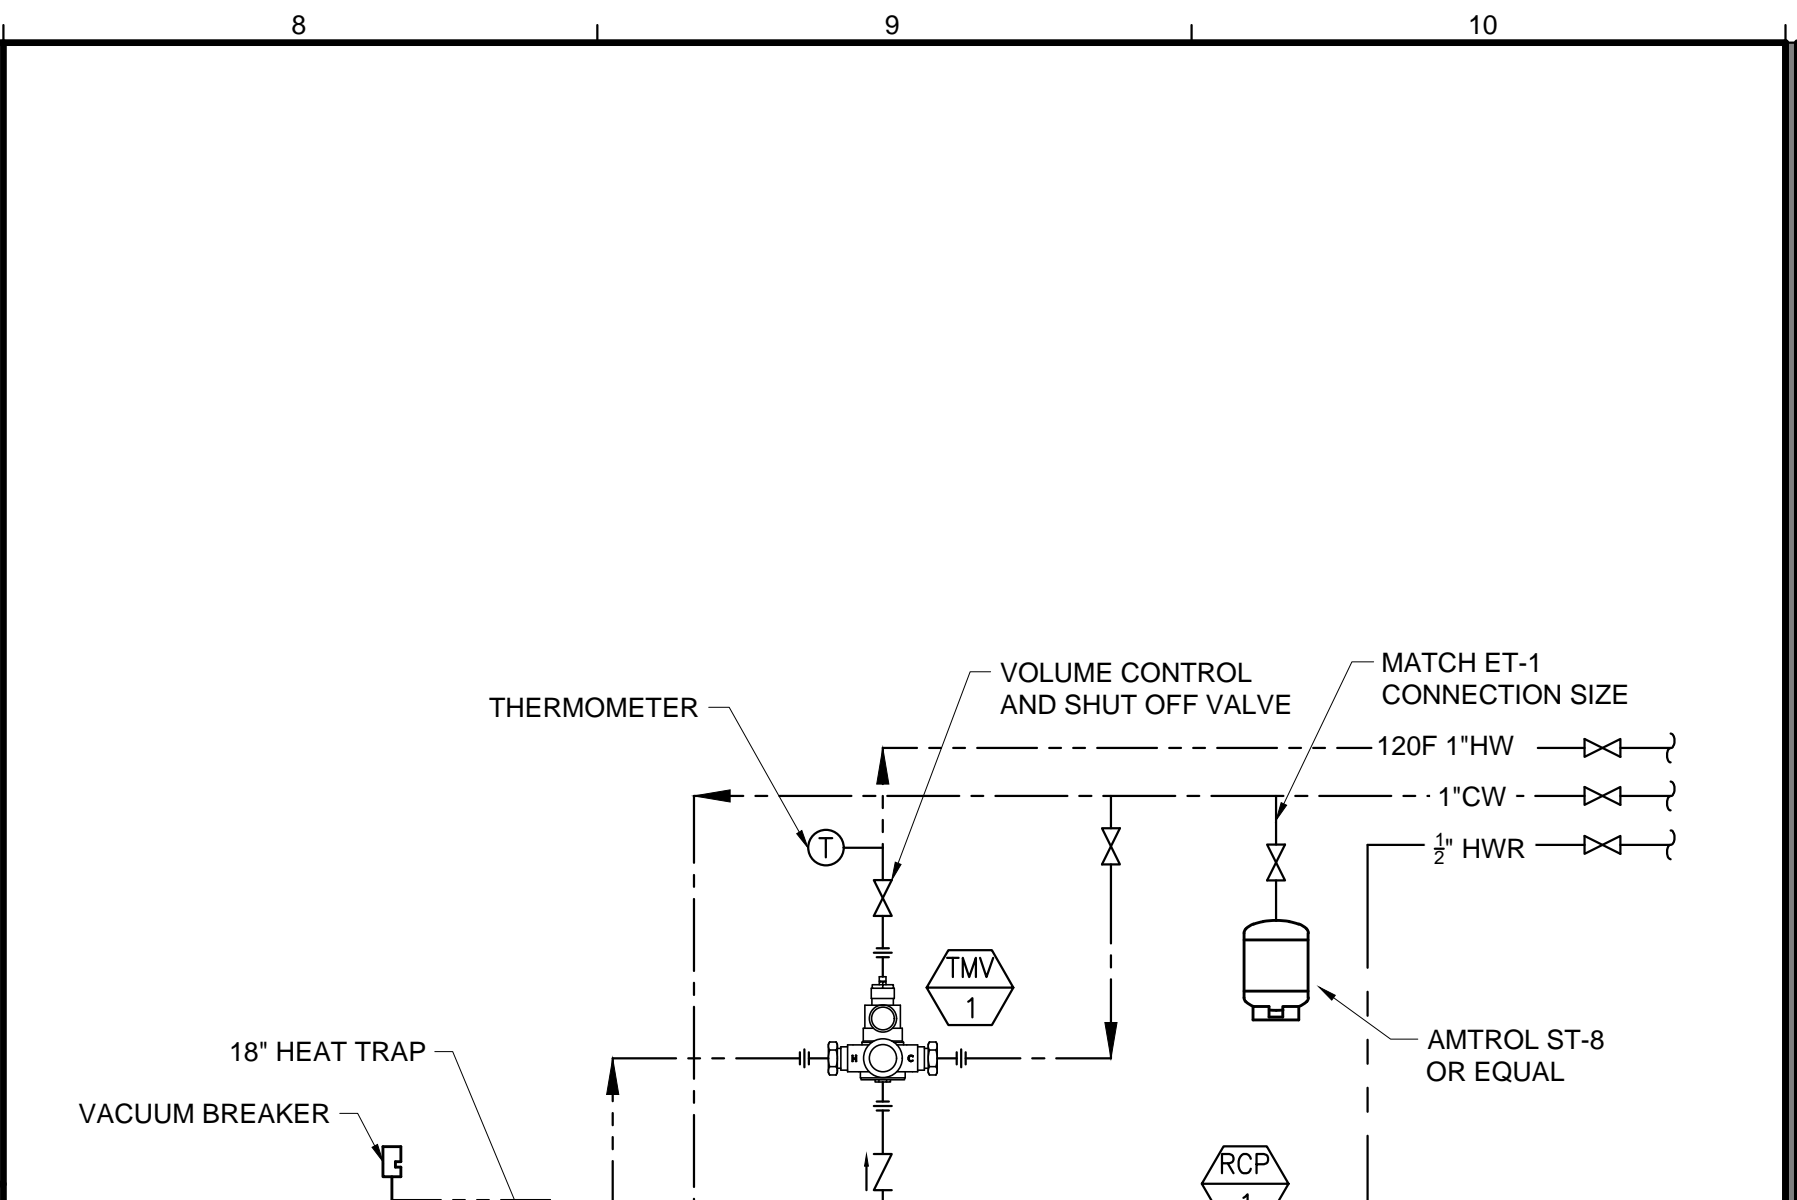

TAG	DESCRIPTION	BRANCH SIZES				NOTES
		CW	HW	VENT	WASTE	
P-1	WATER CLOSET - WALL MOUNTED, ELECTRONIC FV	1"	----	2"	3"	BATTERY
P-1A	WATER CLOSET - WALL MOUNTED, ELECTRONIC FV, ADA	1"	----	2"	3"	BATTERY
P-2	URINAL, WALL MOUNTED, ELECTRONIC FV	3/4"	----	1-1/2"	2"	BATTERY
P-2A	URINAL, WALL MOUNTED, ELECTRONIC FV, ADA	3/4"	----	1-1/2"	2"	BATTERY
P-3	LAVATORY - WALL HUNG	1/2"	1/2"	1-1/2"	1-1/2"	
P-4	SS SINK - KITCHEN	1/2"	1/2"	1-1/2"	1-1/2"	UNDERMOUNT
P-5	SHOWER	1/2"	1/2"	1-1/2"	2"	
P-5A	SHOWER - TRANSFER ADA	1/2"	1/2"	1-1/2"	2"	
P-6	MOP/SERVICE BASIN	3/4"	3/4"	1-1/2"	3"	PROVIDE CHECK VALVES AT WATER INLETS
P-7	DRINKING FOUNTAIN	3/8"	----	1-1/4"	1-1/4"	WITH GLASS FILLER MOUNTED ON DECK
P-8	BOTTLE FILLER	3/8"	----	1-1/4"	1-1/4"	
P-9	SS BAR SINK - KITCHEN	3/8"	----	1-1/4"	1-1/4"	UNDERMOUNT
FPWH	FROST PROOF WALL HYDRANT	3/4"	----	----	----	
FD-1	HEAVY DUTY FLOOR DRAIN	1/2"	----	1-1/2"	3"	TRAP PRIMER AS NOTED
FD-2	LIGHT DUTY FLOOR DRAIN	1/2"	----	1-1/2"	2"	TRAP PRIMER AS NOTED
DW	DISHWASHER - BY OTHERS	----	1/2"	1-1/2"	2"	ROUGH IN BY PLUMBING CONTRACTOR
FR	REFRIGERATOR - BY OTHERS	1/2"	----	----	----	ROUGH IN BY PLUMBING CONTRACTOR

NOTES:

TAG	SERVES	MAKE & MODEL	TYPE	GPM	HEAD	DISCHARGE	ELECTRICAL		SUMP	NOTES
							MOTOR HP	VOLTS/P H (60 Hz.)		
SP-1	ELEV SUMP	LIBERTY ELV 250	SUBMERSIBLE	53	12	1-1/2"	1/3	115/1	CONC - DIV 3	1, 2
RCP-1	DHW RECIRC	TACO HEC-2	IN LINE	6	5	1/2"	1/20	115/1	----	FLANGED INLET

NOTES:  
1. PLUG CONNECTIONS, COORDINATE LOCATION OF GFI OUTLETS.  
2. PROVIDE OIL SMART SYSTEM; SEE SPEC SECTION 22 14 29.

TAG	TYPE	MANUFACTURER	MODEL	VOLTS	PHASE	HEAT INPUT (KW)	AMPS	RECOVERY FLOW	TEMP RISE (DEG-F)	WATER STORAGE (GAL)	HEIGHT (INCHES)	DIA	NOTES

A1 PLUMBING SCHEDULES  
1/8"=1'-0"

N:\Projects\2015\15023 - Patrons Oxford Offices Building\00 Drawing Files\15023\_M.dwg Jan 13, 2016 - 3:56pm