



1 2ND FLOOR FA  
SCALE: 1/8" = 1'-0"

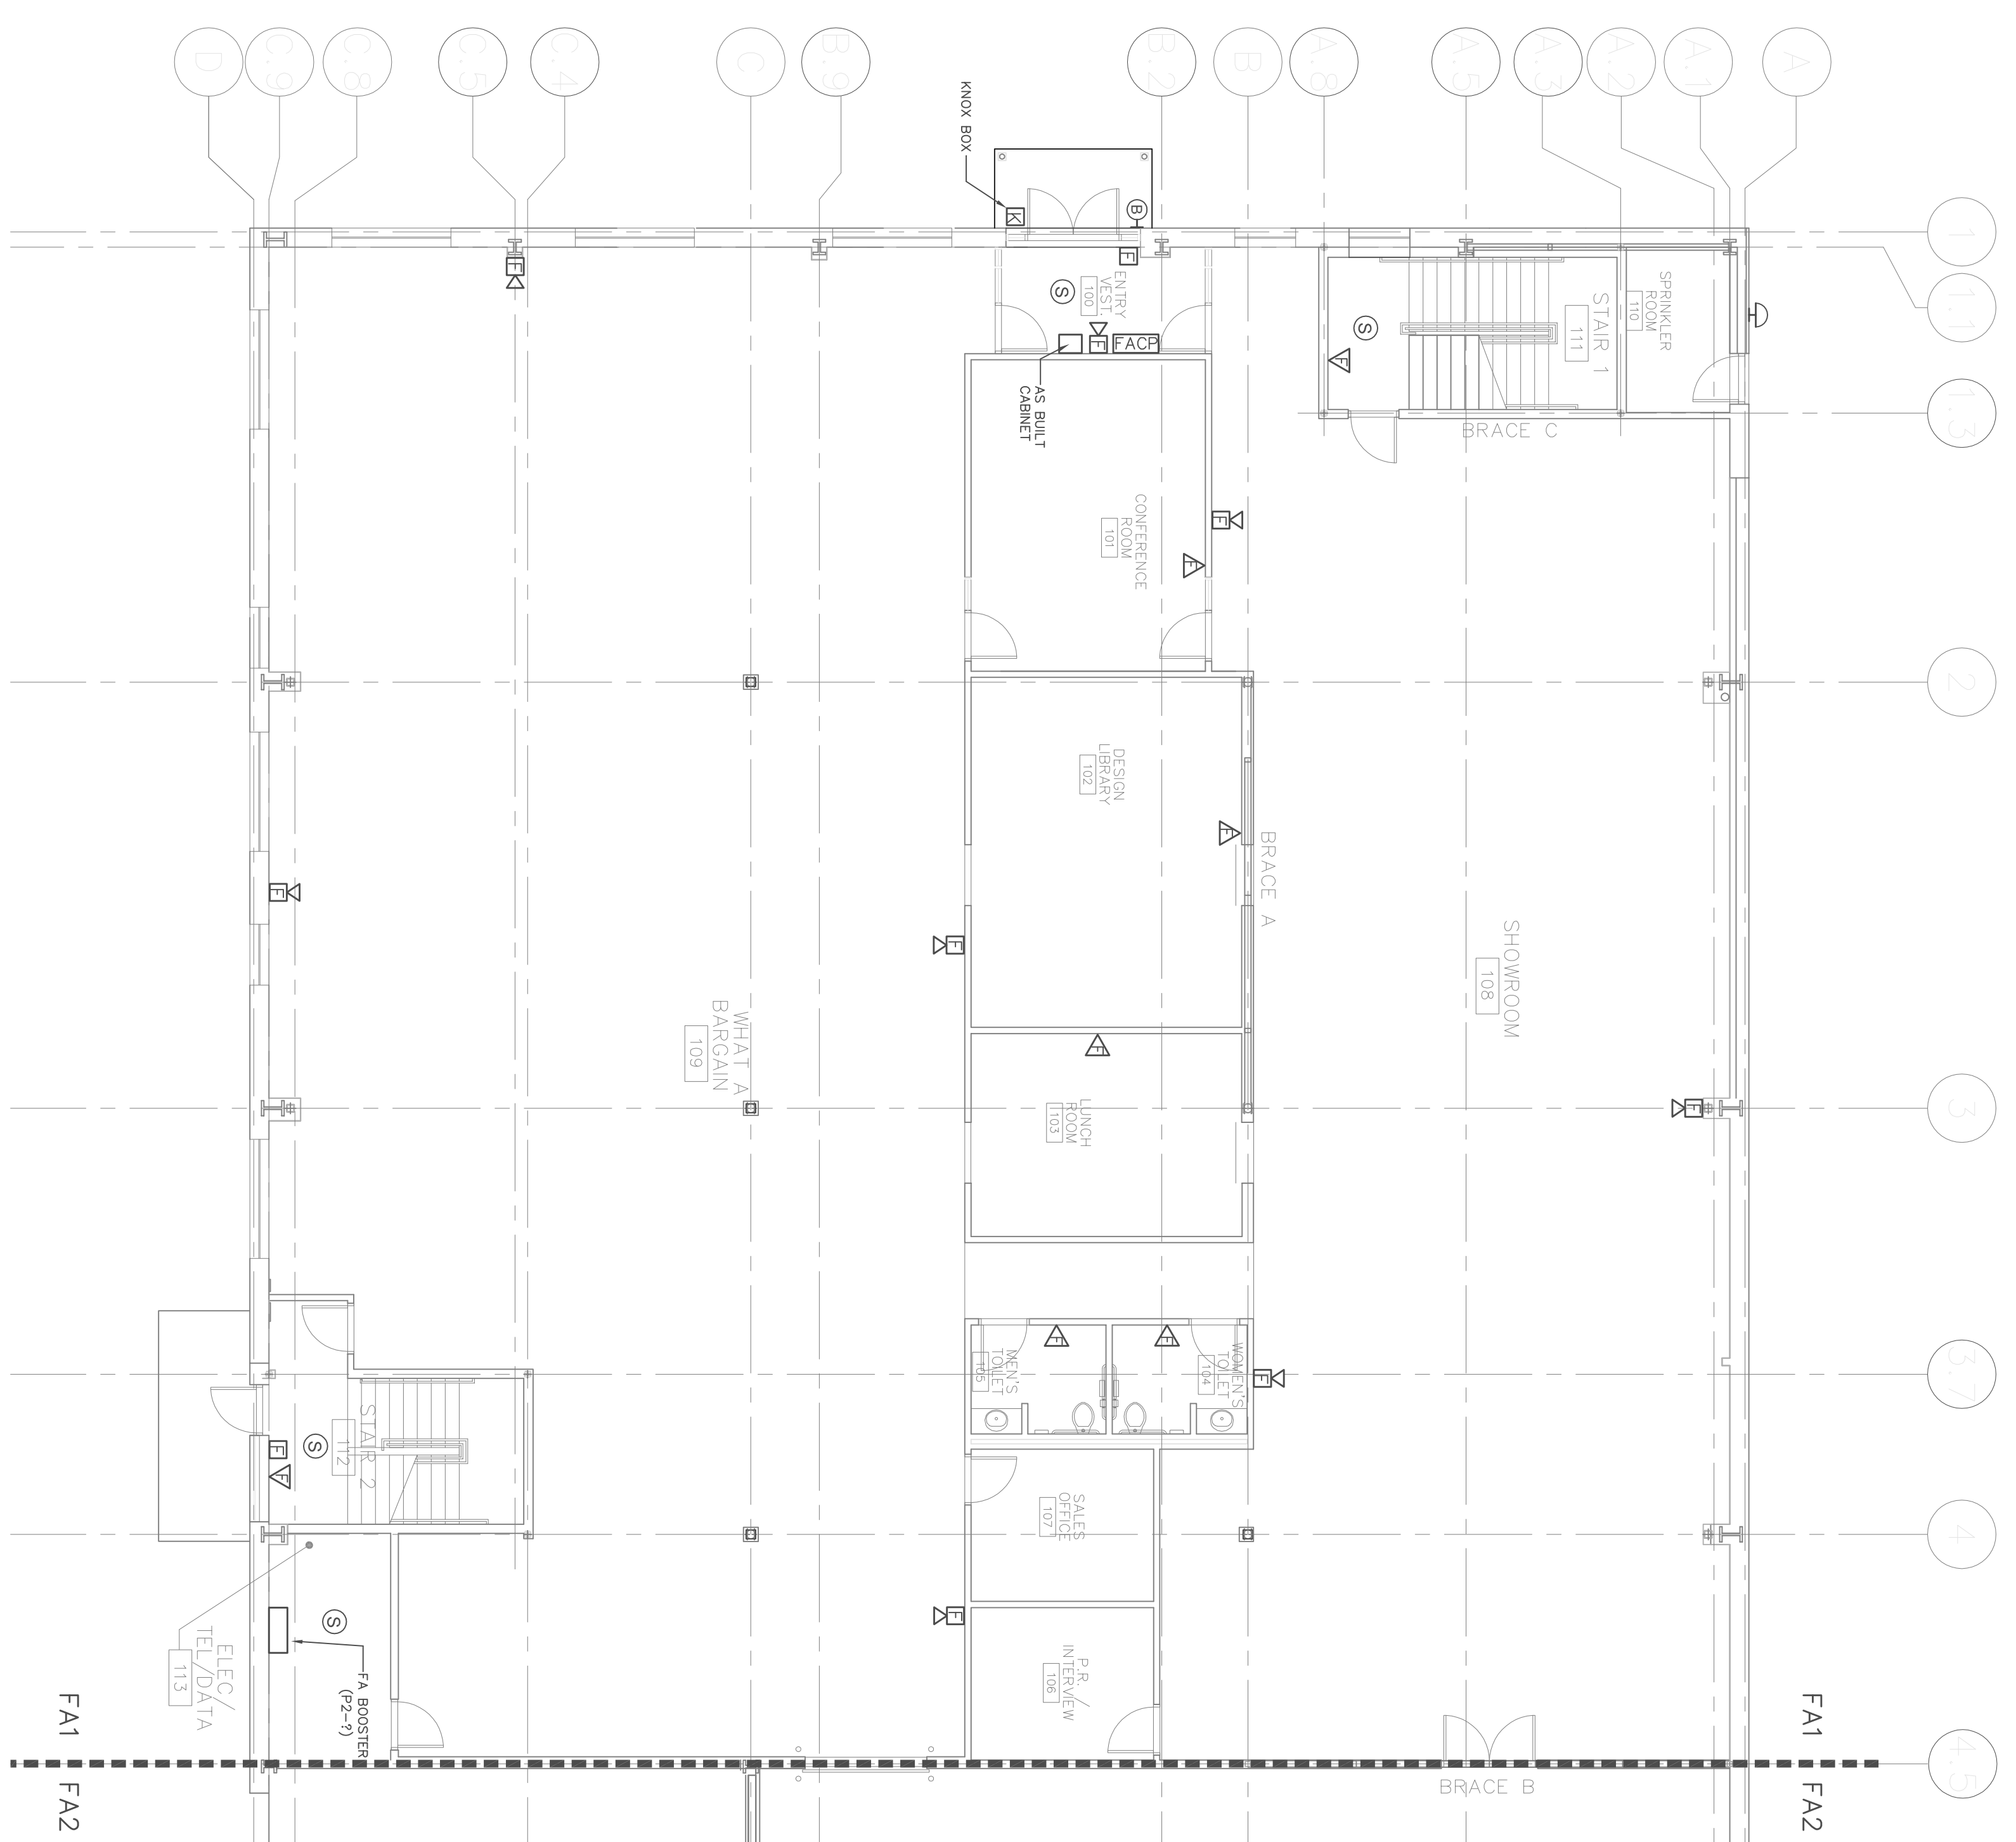

1 1ST FLOOR FA  
SCALE: 1/8" = 1'-0"

**FA LEGEND**

- HORN STROBE
- STROBE ONLY
- PULL STATION
- HEAT DETECTOR
- SMOKE DETECTOR
- BEACON
- CEILING MOUNT H/S 1100D
- CEILING MOUNT STR ONLY 1100D
- REMOTE TEST SW
- DUCT SMOKE
- SPRINKLER BELL

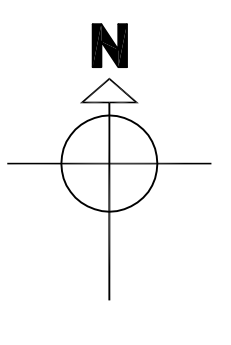

**FLORENCE ELECTRIC, LLC**  
 Florence Electric, LLC  
 125 John Hancock Rd.  
 Taunton, MA 02780  
 Tel: 508.823.5590  
 Fax: 508.823.5002

General Notes

**W.B. MASON**  
 106 PINE TREE INDUSTRIAL PARK  
 PORTLAND, ME

No.	Revision/Issue	Date

Project Name  
**1ST & 2ND FLOOR  
 FIRE ALARM PLAN**

Project  
 Date  
 3-18-10  
 Scale  
 AS NOTED

Sheet  
**FA1**