

RCP GENERAL NOTES

REFER TO GENERAL NOTES SHEET A0.2 FOR GENERAL CONDITIONS AND REQUIREMENTS FOR ALL CONSTRUCTION.

CONTRACTOR TO PERFORM THE WORK OUTLINED IN THESE NOTES IN ALL AREAS OF CONSTRUCTION UNLESS NOTED OTHERWISE IN THESE DOCUMENTS.

CEILING ELEMENTS (LIGHTING FIXTURES, MECHANICAL DIFFUSERS, ETC.) ARE SHOWN FOR LAYOUT AND DESIGN INTENT ONLY. REFER TO ENGINEERING DRAWINGS FOR ADDITIONAL INFORMATION.

ALL NEW CEILING ELEMENTS SHALL BE CENTERED IN TILE, UNLESS NOTED OTHERWISE.

REFER TO ENGINEERING DRAWINGS FOR EMERGENCY LIGHTING LOCATIONS AND COORDINATE WITH INDICATED DESIGN INTENT. EMERGENCY LIGHTING SHALL COMPLY WITH CODE REQUIREMENTS.

NEW SWITCHES ARE TO BE MOUNTED TO ALIGN WITH THE CENTERLINE OF THE DOOR LEVER 42" A.F.F. EACH ROOM TO BE SWITCHED INDIVIDUALLY UNLESS NOTED OTHERWISE.


 

 
 


 
 



 


ALL ADJACENT SWITCHES SHALL BE GANGED IN A SINGLE BOX WITH A SINGLE COVER PLATE. IF GANGING OF SWITCHES IS NOT POSSIBLE, INDIVIDUAL SWITCHES SHALL BE SPACED AN EQUAL AND MINIMUM DISTANCE APART AND LOCATED AT THE SAME ELEVATION AFF. STACKING OF SWITCHES MAY BE NECESSARY IF THE NUMBER IS EXCESSIVE.

ALL ABOVE CEILING SYSTEMS SHALL BE DESIGNED TO ACCOMMODATE CEILING HEIGHTS DOCUMENTED AND CEILING FIXTURES SPECIFIED. CEILING DROPS WILL NOT BE CONSIDERED TO ACCOMMODATE REROUTING OF SYSTEMS.

SUPPLY AND INSTALL NEW CEILING TILE AND GRID.

DOCK FRAMING WILL BE EXPOSED. PAINT BOTTOM OF DECK WHITE. STEEL SHALL BE FACTORY PRIMED GREY.

CEILING LEGEND


-  2 X 2 DROP-IN FLUORESCENT LIGHT FIXTURE
-  2 X 4 DROP-IN FLUORESCENT LIGHT FIXTURE
-  PENDANT FIXTURE
-  12" LOBBY PENDANT FIXTURE
-  RECESSED CAN LIGHT
-  RECESSED WALL WASHER
-  1 X 4 FLUORESCENT FIXTURE
-  1 X 4 SUSPENDED FLUORESCENT FIXTURE
-  8" 12" X 4" WALL MOUNTED FLUORESCENT FIXTURE
-  1 X 12 SUSPENDED FLUOR. FIXTURE
-  WALL MOUNTED EXIT SIGN
-  CEILING MOUNTED EXIT SIGN
-  PROJECTOR
-  PROJECTION SCREEN
-  WALL SCONCE

CEILING TYPES

A	EXPOSED STRUCTURE
C	ACOUSTICAL TILE LAY-IN CEILING
C1	VINYL FACED LAY-IN CEILING



909 10th Ave South • Suite 414
Nashville, Tennessee 37203
v. 615.296.9146 • f. 615.733.0059

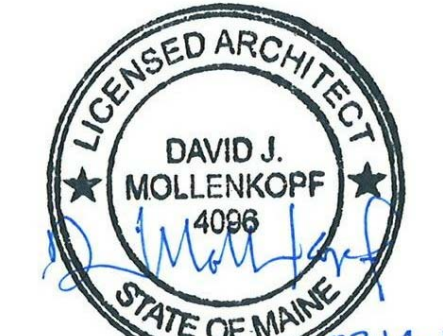

ME LICENSE #ARC009 - EXP 4/31/2015
Architect: David J. Mollenkopf



Contractor:
DF Chase, Inc.
3001 Armory Drive
Suite 225
Nashville, TN 37204



Terminal Renovation for:
Old Dominion Freight Line
ODFL PORTLAND, ME
185 RAND ROAD,
PORTLAND, ME 04102

PERMIT ISSUE 02/14/2014


Project No. 13061.00

The Architect hereby reserves its common law copyright and other property rights in these plans, ideas, and designs which are not to be reproduced, changed or copied in any form or manner whatsoever, nor are they to be assigned to any third party without first obtaining the express written permission from the Architect. This drawing is not final or to be used for construction until signed by the Architect.

Sheet Name:
REFLECTED CEILING PLAN

Sheet Number:

A6.1

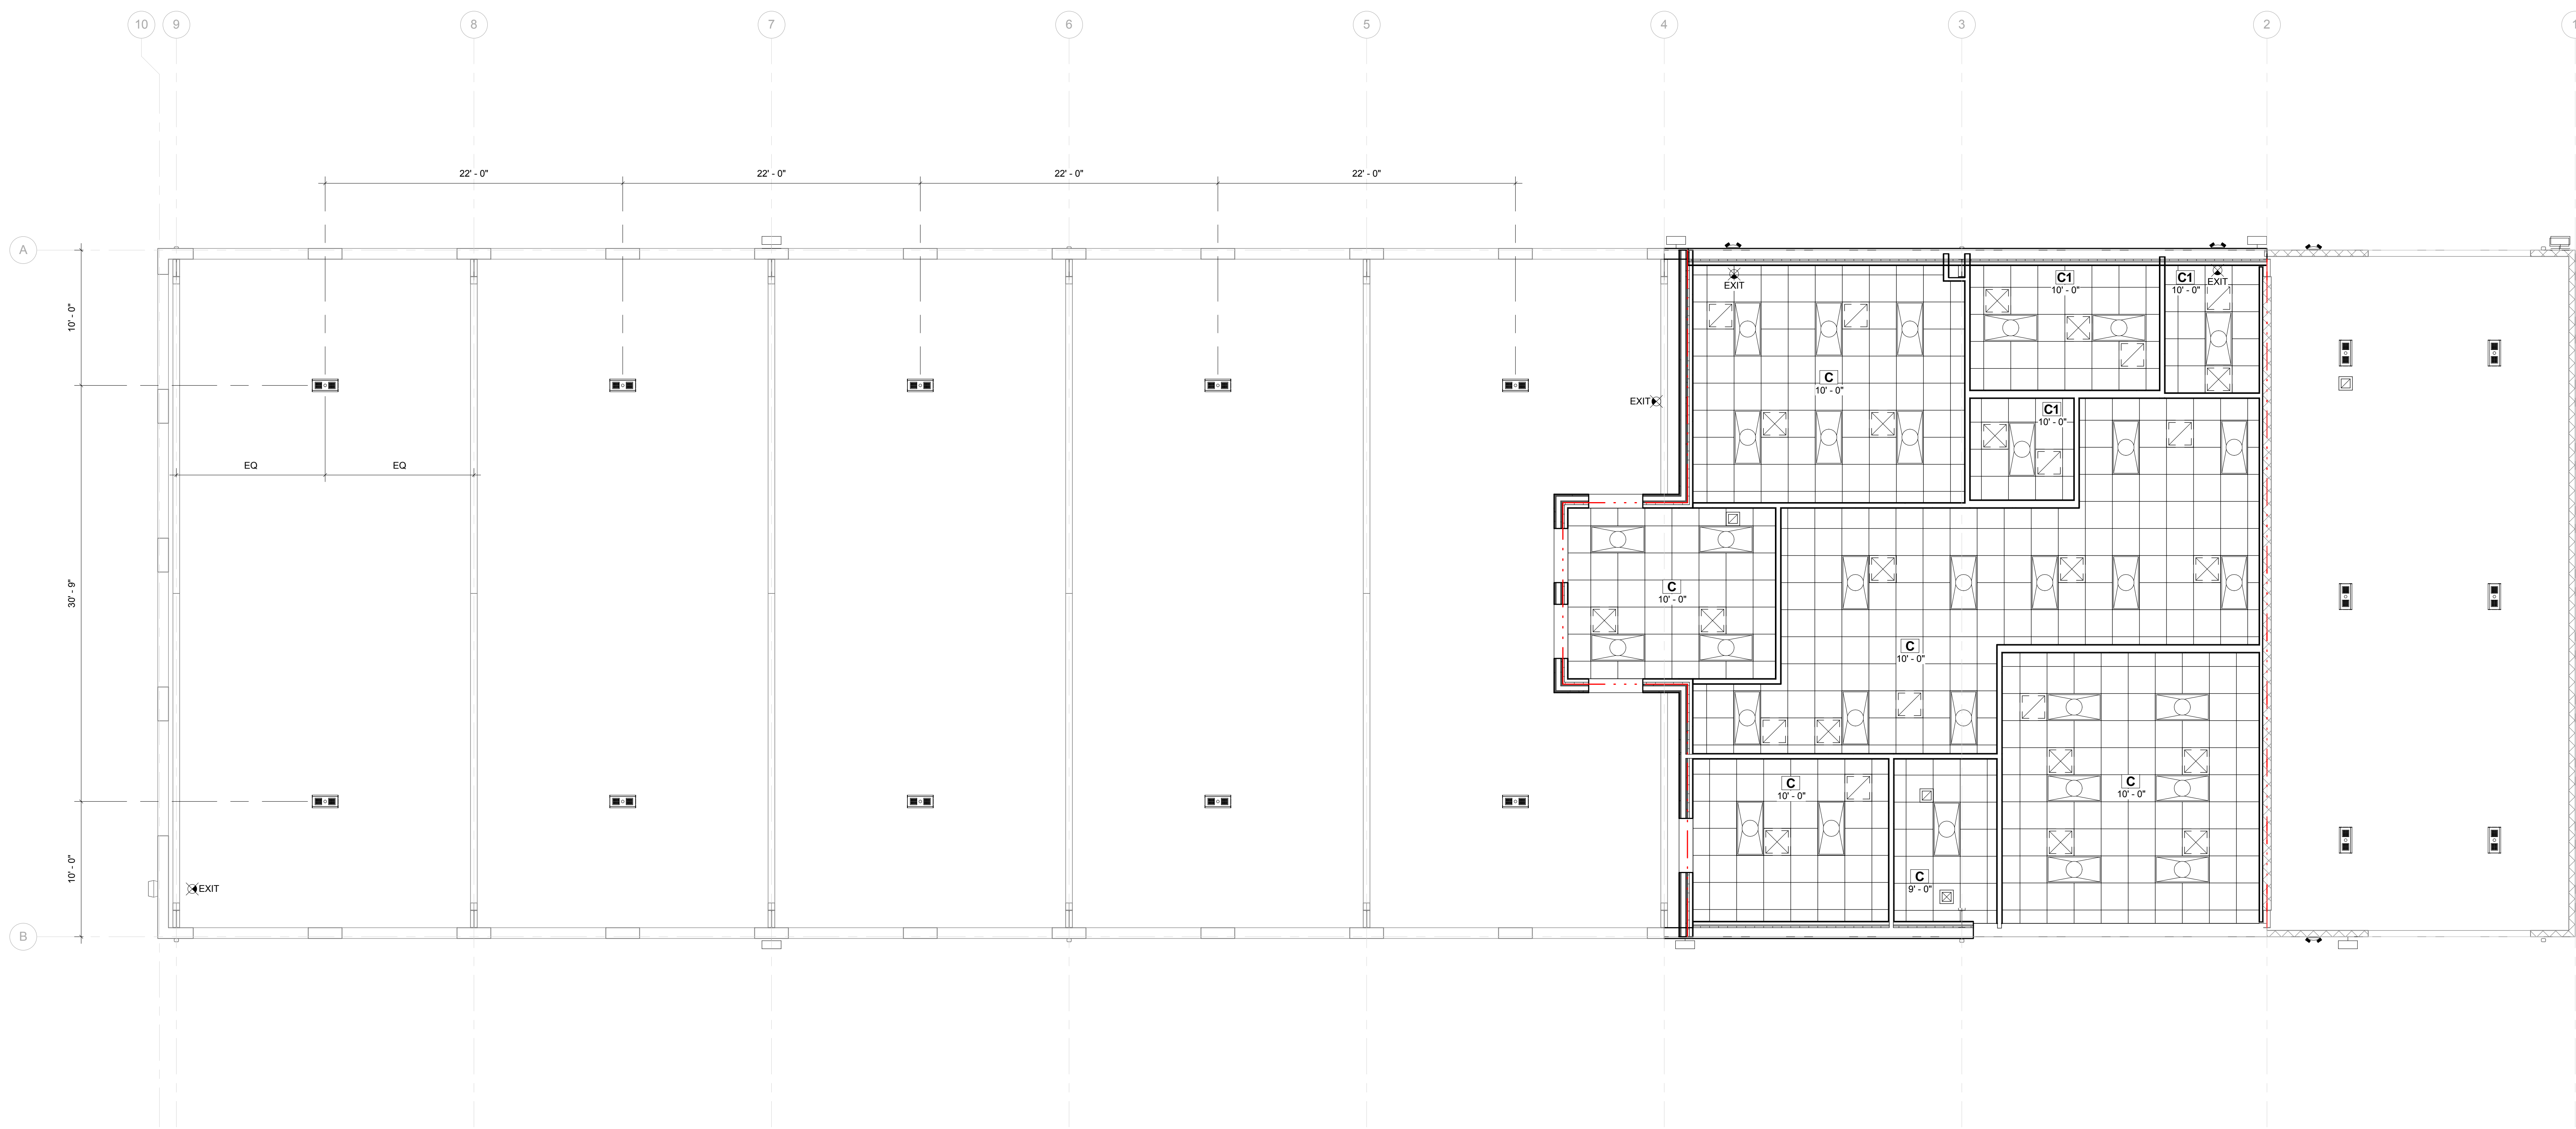

1 FIRST FLOOR PLAN
3/16" = 1'-0"

