

Contractor:
DF Chase, Inc.
3001 Armory Drive
Suite 225
Nashville, TN 37204





OFFICE RENOVATION & DOCK ADDITION:
OLD DOMINION FREIGHT LINE
ODFL PORTLAND, ME
185 RAND ROAD
PORTLAND, ME 04102

CONSTRUCTION 4/25/2014
DRAWINGS FOR PERMIT

Project No. 13061.00
The Architect hereby reserves its common law copyright and other property rights in these plans, items and designs which are not to be reproduced, changed or copied in any form or manner whatsoever nor are they to be assigned to any third party without first obtaining the express written permission from the Architect. The drawing is not final or to be used for construction until signed by the Architect.

Sheet Name:
PIPING PLAN
Sheet Number:

P1.1
ORA JOB# 01014

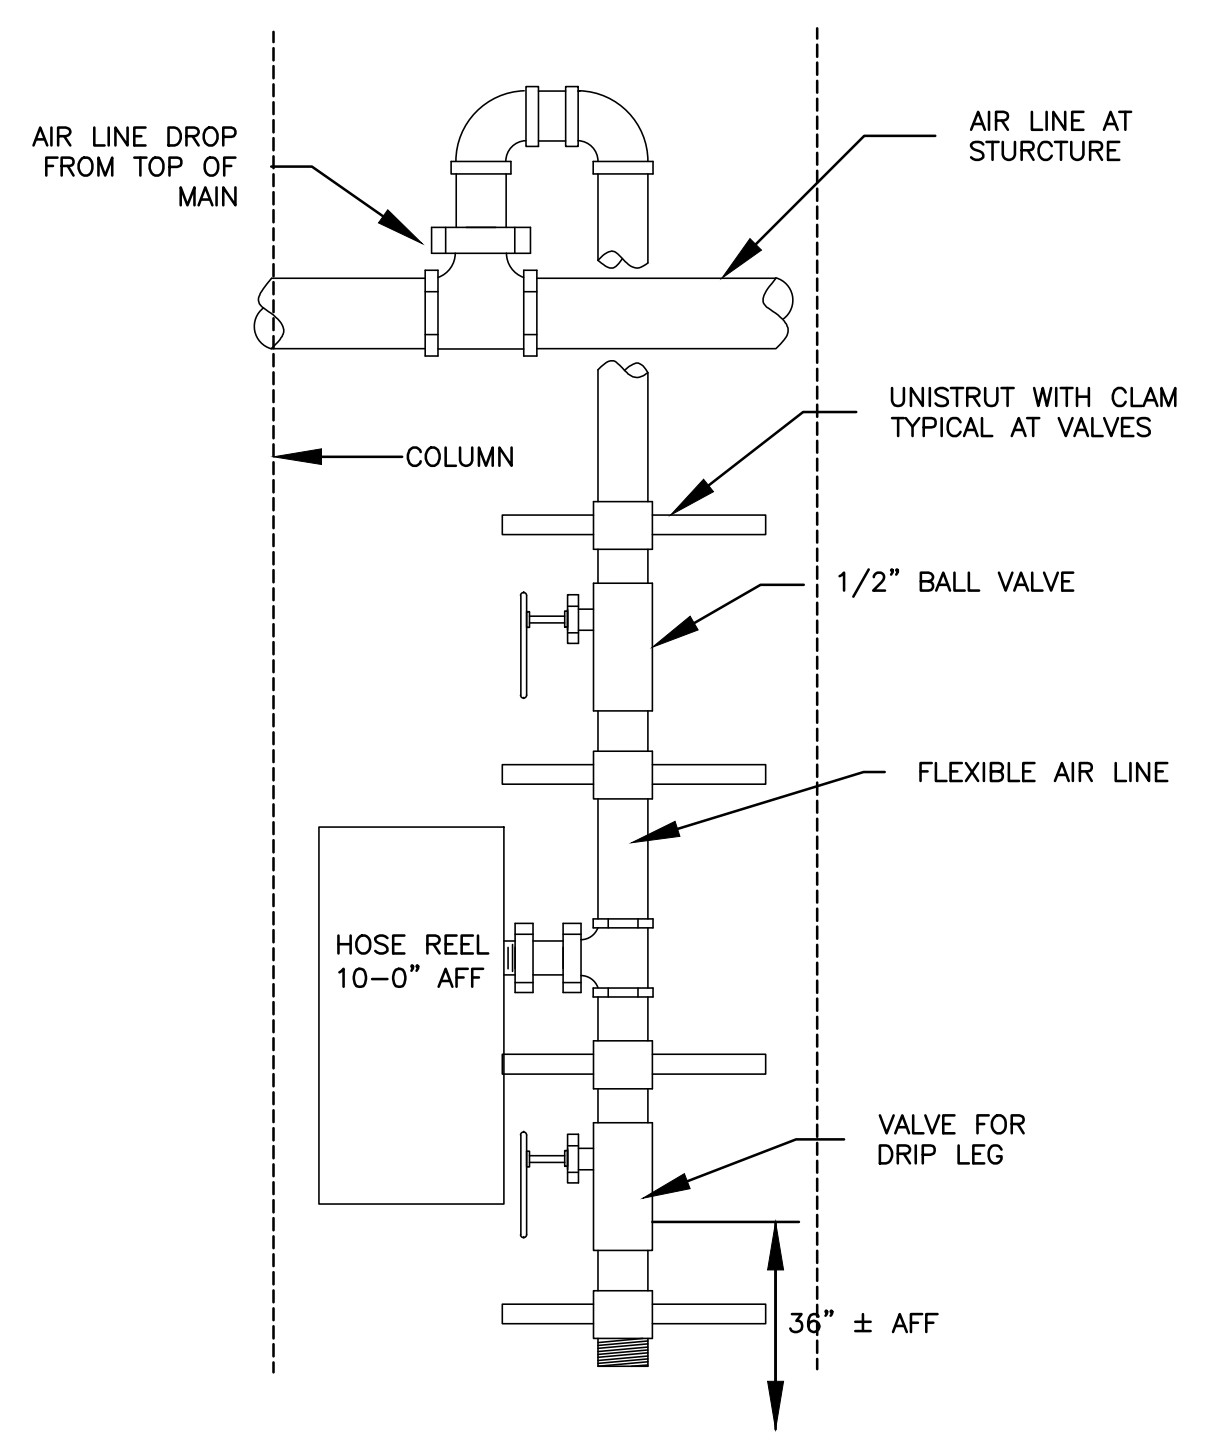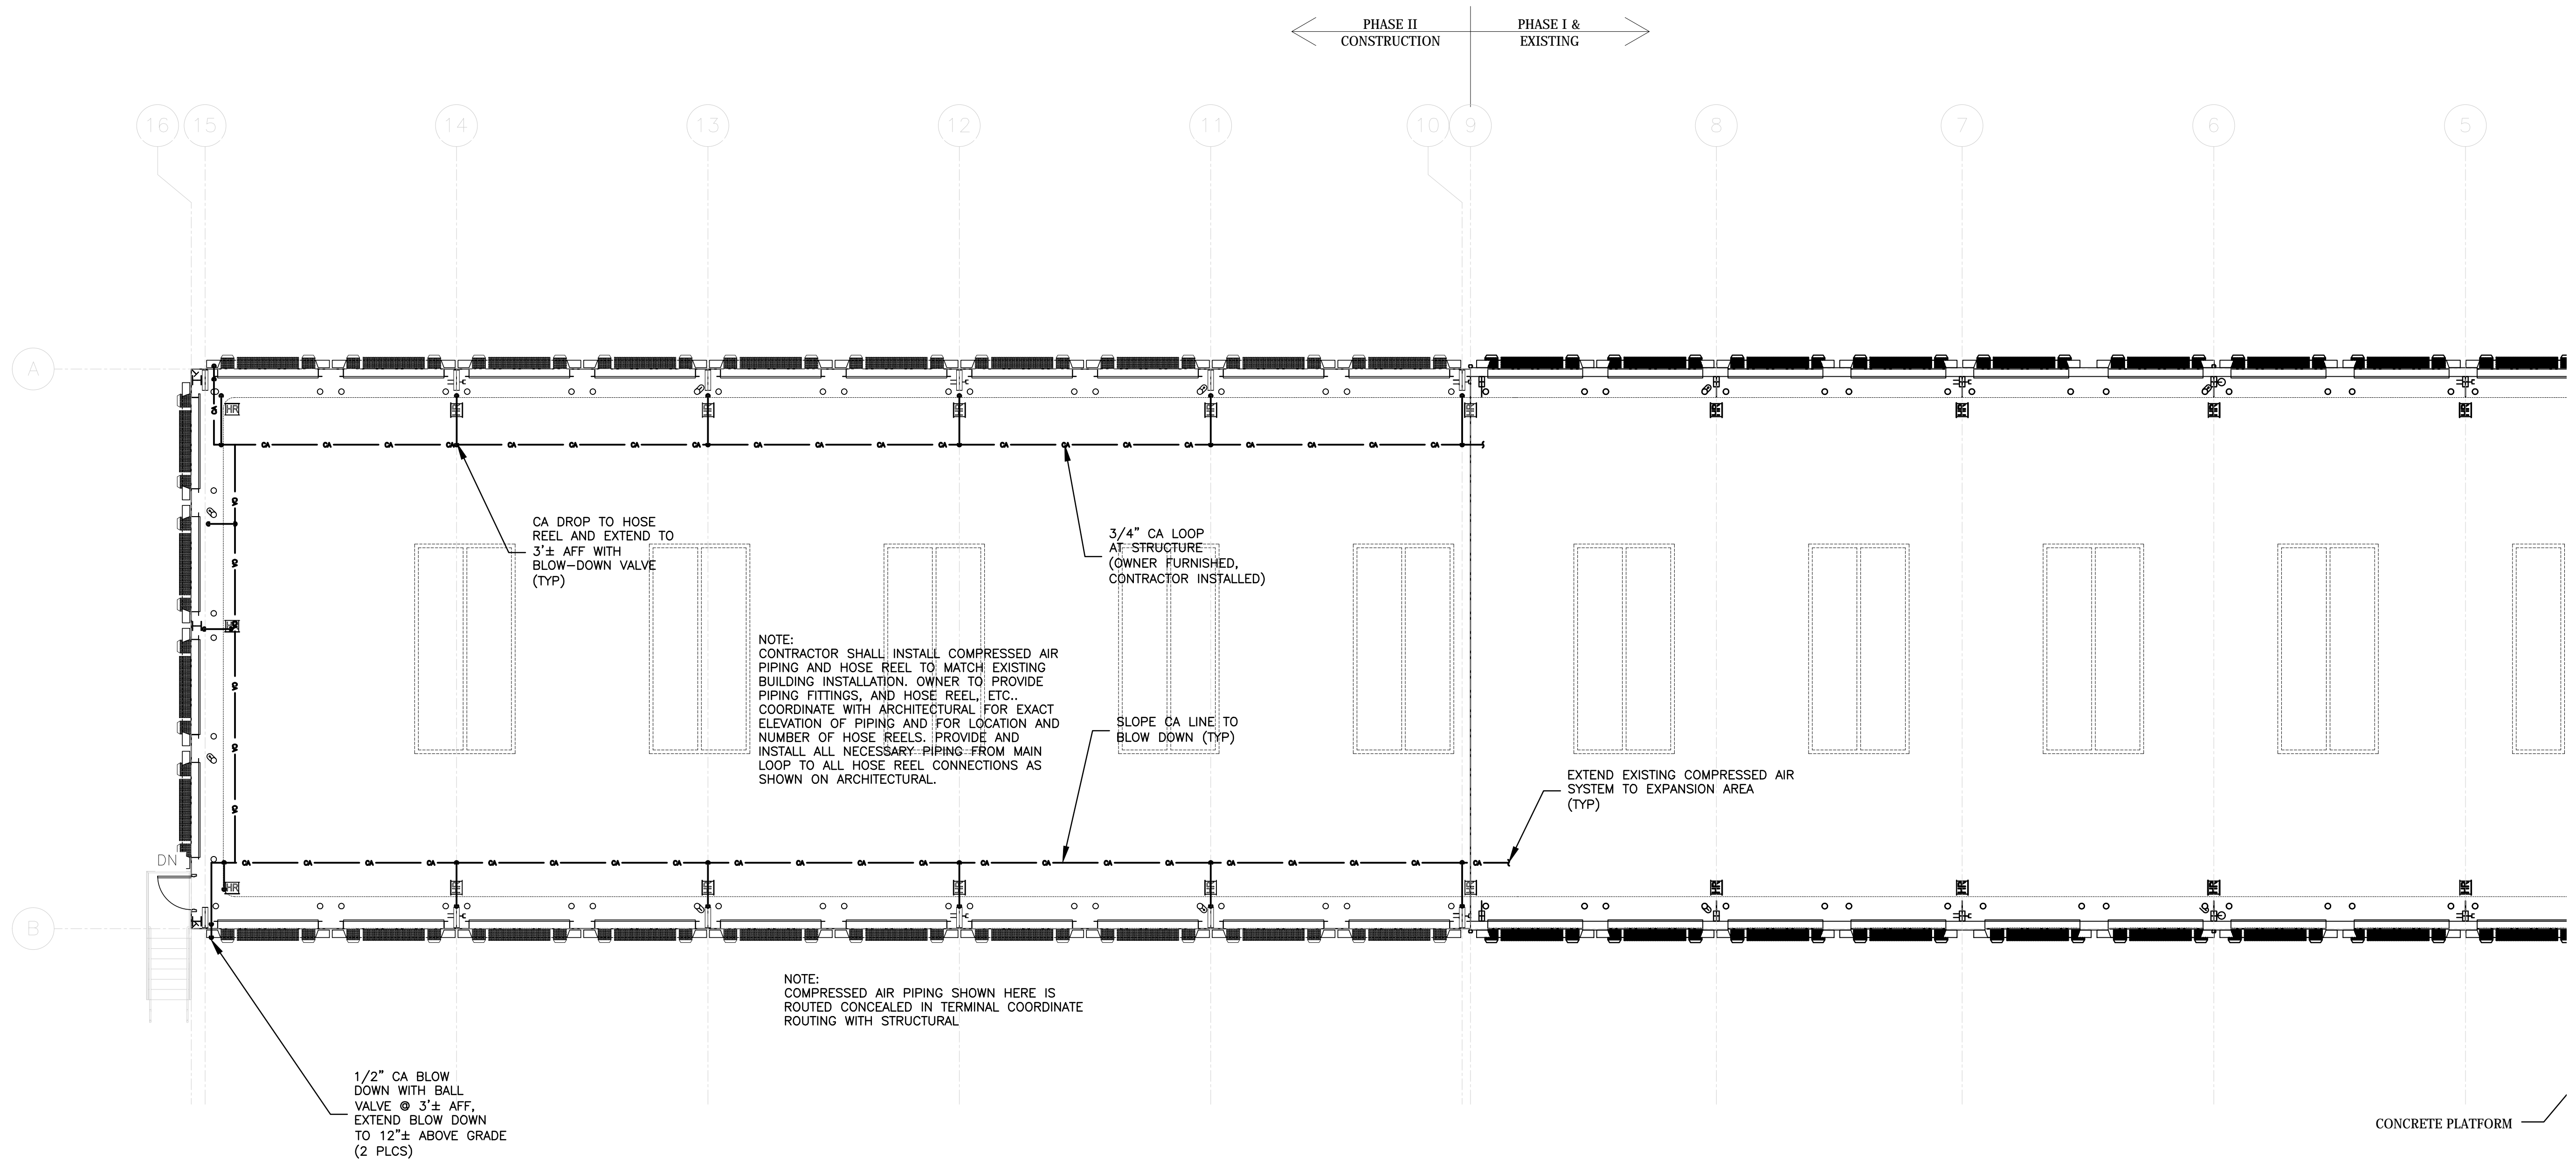

TYPICAL AIR DROP DETAIL
NTS

PIPING PLAN
SCALE: 1/8" = 1'
NORTH