



1 APT. FIRST FLOOR ELECTRICAL PLAN
SCALE: 1/4" = 1'-0"

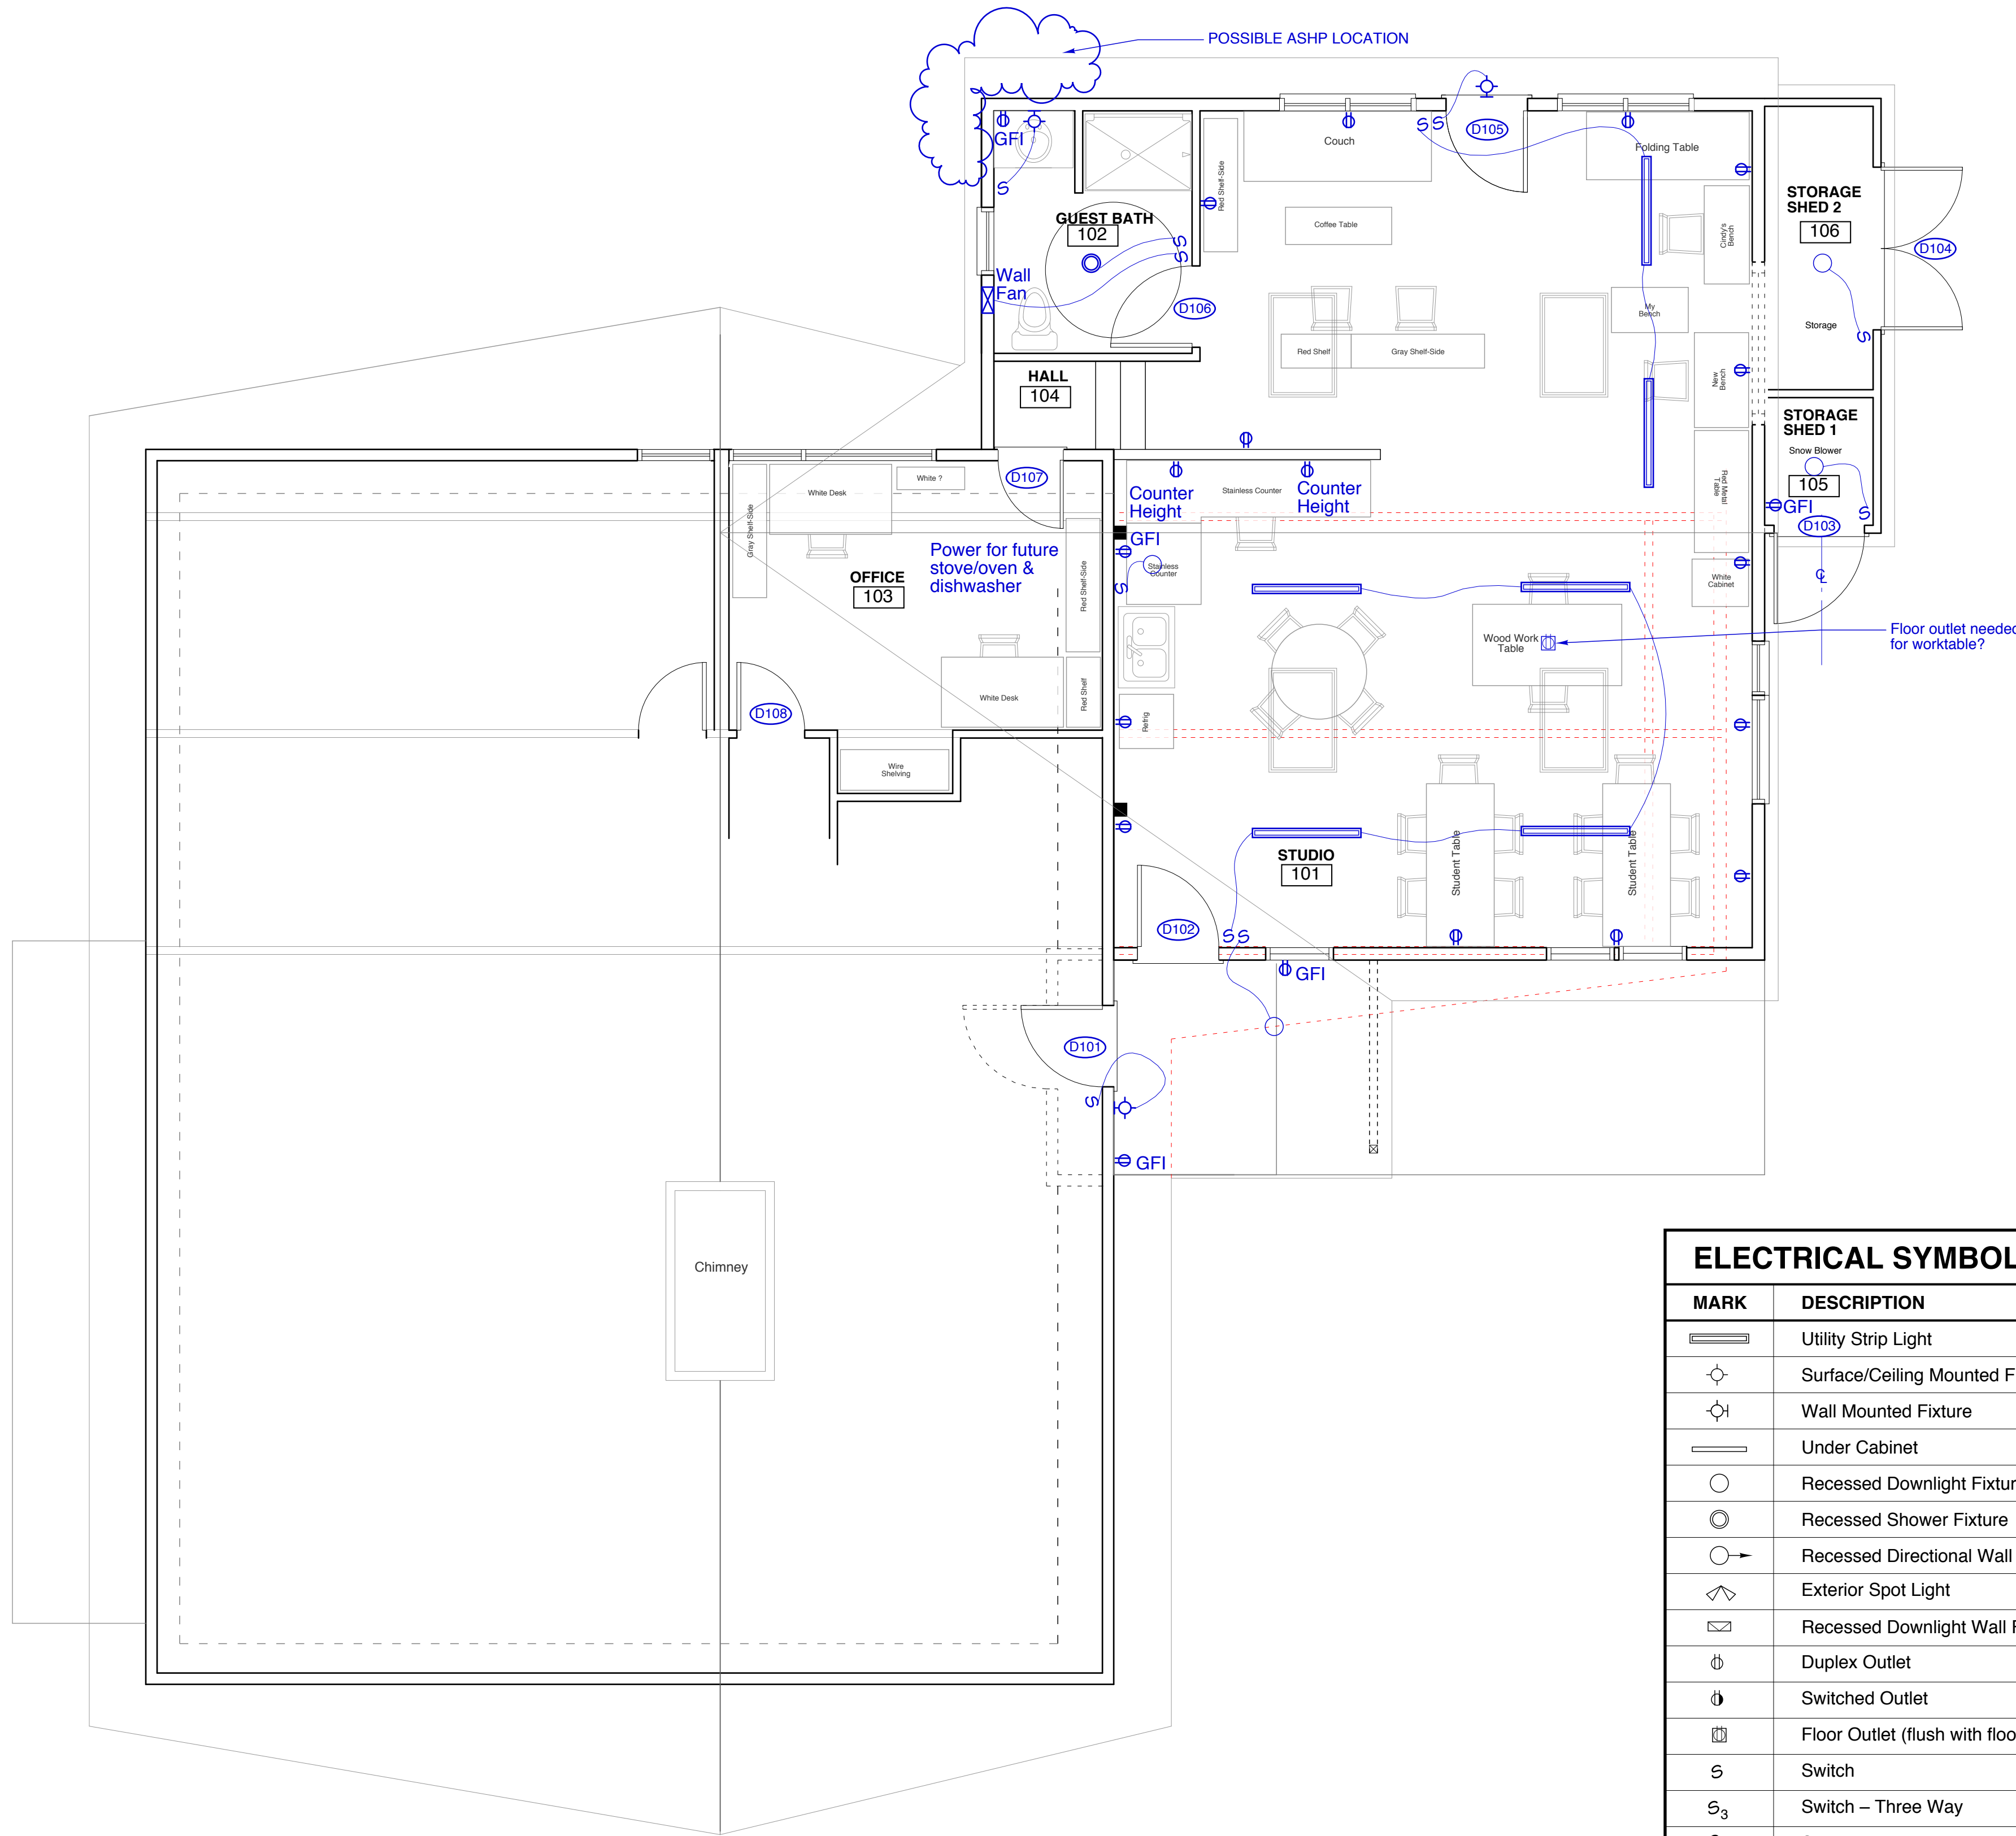

1 FIRST FLOOR ELECTRICAL PLAN
SCALE: 1/4" = 1'-0"

ELECTRICAL SYMBOLS	
MARK	DESCRIPTION
	Utility Strip Light
	Surface/Ceiling Mounted Fixture
	Wall Mounted Fixture
	Under Cabinet
	Recessed Downlight Fixture
	Recessed Shower Fixture
	Recessed Directional Wall Washer
	Exterior Spot Light
	Recessed Downlight Wall Fixture
	Duplex Outlet
	Switched Outlet
	Floor Outlet (flush with floor)
	Switch
	Switch - Three Way
	Switch - Dimmer
	Switch - Jamb
	Switch - Pilot Light
	Ceiling Mounted Exhaust Fan
	Data/Cable TV Jack
	Telephone Jack
	Ground Fault Interrupter
	Weatherproof
	Dishwasher
	Fixture By Owner

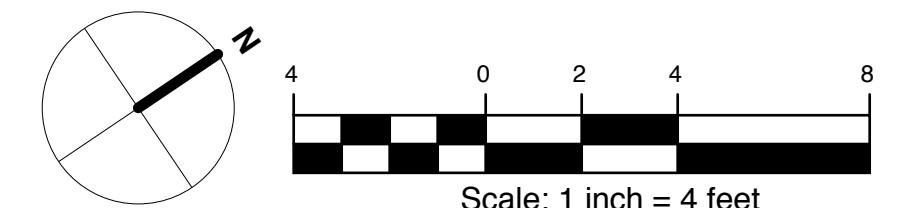

Copyright 2015 Richard Renner | Architects

RRA
Richard Renner | Architects
Portland, ME
207.773.9699
Sherborn, MA
508.651.2385

REGISTERED ARCHITECT
RICHARD K. RENNER
No. 1056
STATE OF MAINE

Consultants:
Structural Engineer
(company) Structural Engineers

**Redman Residence:
Studio Addition**

480 Capisic Street
Portland, ME 04102

Permit Set 4.20.2015

First Floor Electrical Plan

Drawn by: RRA
Scale: 1/4" = 1'-0"
Date: 03/31/15

File Name: East Elevation
Project No.: 2014-12.00
Revised: 04/20/15

**Redman
Studio**

A5.1