


1 FIRST FLOOR ELECTRICAL PLAN
SCALE: 1/4" = 1'-0"

MARK	DESCRIPTION
	Utility Strip Light
	Surface/Ceiling Mounted Fixture
	Wall Mounted Fixture
	Under Cabinet
	Recessed Downlight Fixture
	Recessed Shower Fixture
	Recessed Directional Wall Washer
	Exterior Spot Light
	Recessed Downlight Wall Fixture
	Duplex Outlet
	Switched Outlet
	Floor Outlet (flush with floor)
	Switch
	Switch - Three Way
	Switch - Dimmer
	Switch - Jamb
	Switch - Pilot Light
	Ceiling Mounted Exhaust Fan
	Data/Cable TV Jack
	Telephone Jack
	Ground Fault Interrupter
	Weatherproof
	Dishwasher
	Fixture By Owner

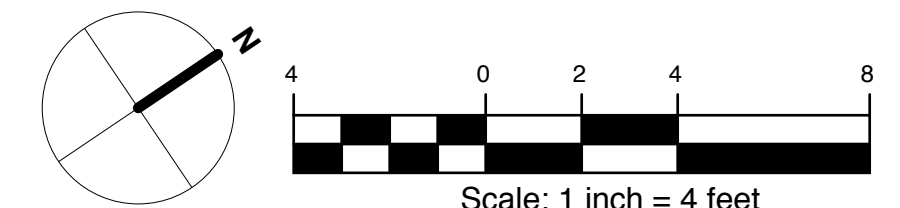

Copyright 2015 Richard Renner | Architects

RRA
Richard Renner | Architects
 Portland, ME
 Sherborn, MA
 207.773.9699
 508.651.2385

Consultants:
 Casco Bay Engineering
 Peter D. Rand, P.E.
 Senior Project Manager
 424 Fore Street, 04101
 Portland, ME 04103
 P: 207-842-2800, ext. 203
 F: 207-842-2828
 www.cascobayengineering.com

Redman Residence: Addition
 480 Capisic Street
 Portland, ME 04102

Permit Set 6.19.2015
First Floor Electrical Plan
 Drawn by: RRA
 File Name: East Elevation
 Scale: 1/4" = 1'-0"
 Project No.: 2014-12.00
 Date: 03/31/15
 Revised: 06/19/15

Redman Addition
A5.1