

LEFT ELEVATION
SCALE: 1/8" = 1'-0"

UL #S

- 1- BH 718832
- 1- B4 718830
- 1- B4 718833
- 1- B1+ 712831

AMPS	
APPLEBEE'S	13.7
NEIGHBORHOOD	3.2
GRILL & BAR	4.0
TOTAL CIRCUITS	
APPLEBEE'S	1
NEIGHBORHOOD	1
GRILL & BAR	
TOTAL SQUARE FOOTAGE	
APPLEBEE'S	67
NGB	25.6


NOTE: ALL PRIMARY PENETRATIONS THRU WALL SURFACE TO BELOW ROOF FOR WALL SIGNS.
ALL PRIMARY HOOK-UP BY GENERAL CONTRACTOR'S ELECTRICIAN.

1.17 x 20.5 = 23.905
376 x 11 = 4136
33.605

NOTE: THIS SKETCH IS THE EXCLUSIVE PROPERTY OF SIGN LITE CORPORATION. IT SHOULD NOT BE COPIED, REPRODUCED DISPLAYED OR USED IN ANY WAY WITHOUT THE WRITTEN APPROVAL OF SIGN LITE CORPORATION. Feb 5 2 9-15-98

CLIENT APPLEBEE'S		SIGN SPECIFICATIONS		CABINET		MOUNTING		ELECTRICAL		LETTERS		
LOCATION	BRIGHTON RD PORTLAND, ME	S/F	HEIGHT	LENGTH	WIDTH	ALUMINUM EXTRUSION	CENTER POLE	NON-ILLUMINATED	ILLUMINATED	STYLE	NON-ILLUMINATED	ILLUMINATED
DATE	9/15/98	D/F	FACE			FABRICATED BOX	WALL MOUNT	INTERNAL	EXTERNAL	METAL	METAL	PLASTIC
DRAWING	980915-02	SALES REP	FLAT	PAN	EMBOSSD	COLOR	STRUCTURE	LAMPS	BALLASTS	FLAT	FLAT	FORMED
DESIGNER	CS	PAM	COLOR	EMBOSSD	FLEX	BASE	PLATES	120V	277	TRIM CAP	OTHER	NEON
REVISIONS		REVISIONS				HEIGHT ABOVE GRADE	HEIGHT ABOVE GRADE	TOTAL AMPS	NOTED	OTHER	OTHER	NEON
PAGE	2	SCALE				Windload @	PSF	FIXTURE	UL			
OF	3	1/8" = 1'-0"										

SIGN-LITE
SIGN • LIGHTING • SERVICE

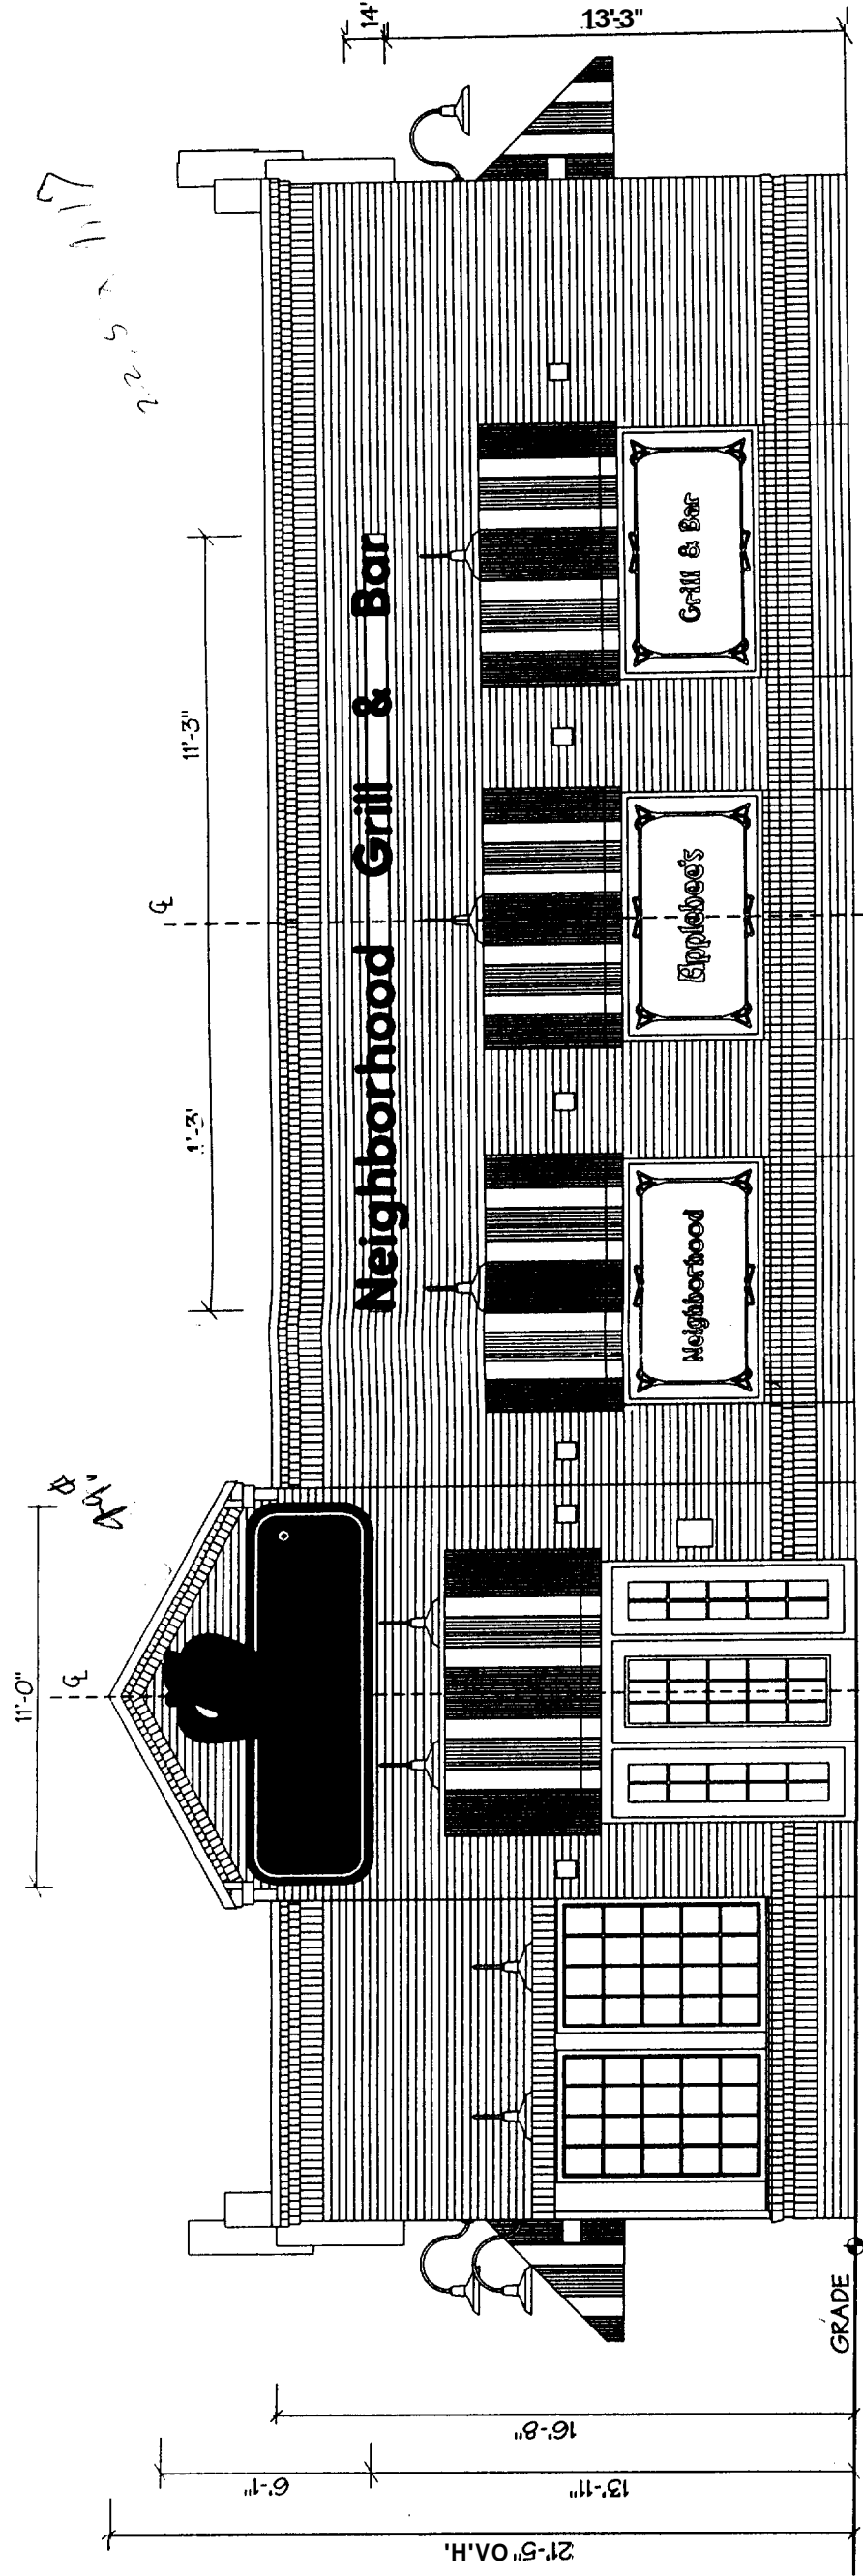

FRONT ELEVATION

SCALE: 3/16" = 1'-0"

AMPS	
APPLEBEE'S	13.7
NEIGHBORHOOD	3.2
GRILL & BAR	4.0
TOTAL CIRCUITS	
APPLEBEE'S	1
NEIGHBORHOOD	1
GRILL & BAR	
TOTAL SQUARE FOOTAGE	
APPLEBEE'S	67
NGB	25.6


NOTE: ALL PRIMARY PENETRATIONS THRU WALL SURFACE TO BELOW ROOF FOR WALL SIGNS.
ALL PRIMARY HOOK-UP BY GENERAL CONTRACTOR'S ELECTRICIAN.

NOTE:
OVERALL LENGTH OF NEIGHBORHOOD GRILL & BAR RACEWAY AS SHOWN MUST BE PLACED SO
EQUAL DISTANCE APPEARS BALANCED ABOVE THE THREE GOOSENECKS. INSTALLER MUST MEASURE
PLACEMENT FIRST BEFORE SECURING TO WALL. INSTALLER TO VERIFY ROOFLINE.

NOTE: THIS SKETCH IS THE EXCLUSIVE PROPERTY OF SIGN LITE CORPORATION. IT SHOULD NOT BE COPIED, REPRODUCED DISPLAYED OR USED IN ANY WAY WITHOUT THE WRITTEN APPROVAL OF SIGN LITE CORPORATION. **FOR SL 9-15-98 D**

CLIENT APPLEBEE'S		SIGN SPECIFICATIONS		CABINET		MOUNTING		ELECTRICAL		LETTERS	
LOCATION BRIGHTON RD PORTLAND, ME	DATE 9/15/98	SALES REP PAM	DESIGNER CS	SCALE 3/16" = 1'-0"	ALUMINUM EXTRUSION FABRICATED BOX	ALUMINUM EXTRUSION FABRICATED BOX	CENTER POLE	NO: ILLUMINATED <input type="checkbox"/> ILLUMINATED <input type="checkbox"/>	STYLE	NON-ILLUMINATED <input type="checkbox"/> ILLUMINATED <input type="checkbox"/>	LETTERS
REVISIONS	REVISIONS	REVISIONS	REVISIONS	REVISIONS	WIDTH	LENGTH	WIDTH	INTERNAL	METAL	ILLUMINATED	LETTERS
DATE 9/15/98	DESIGNER CS	SCALE 3/16" = 1'-0"	FACE	FACE	FACE	FACE	FACE	LAMPS	FLAT	PLASTIC	LETTERS
DRAWING 980915-01	REVISIONS	REVISIONS	FLAT	PAN	EMBOSS	FLEX	STRUCTURE	BALLASTS	FLAT	FORMED	LETTERS
PAGE 1	PAGE 1	PAGE 1	COLOR	COLOR	COLOR	COLOR	PLATES	120V <input checked="" type="checkbox"/> 277 <input type="checkbox"/> OTHER <input type="checkbox"/>	TRIM CAP	OTHER	LETTERS
OF 3	OF 3	OF 3	BASE	BASE	BASE	BASE	HEIGHT ABOVE GRADE	TOTAL AMPS NOTED	OTHER	NEON	LETTERS
			W <input type="checkbox"/> X <input type="checkbox"/> D <input type="checkbox"/>	W <input type="checkbox"/> X <input type="checkbox"/> D <input type="checkbox"/>	W <input type="checkbox"/> X <input type="checkbox"/> D <input type="checkbox"/>	W <input type="checkbox"/> X <input type="checkbox"/> D <input type="checkbox"/>	Windload @	FIXTURE UL	NEON	NEON	LETTERS
											LETTERS

SIGN-LITE
SIGN • LIGHTING • SERVICE

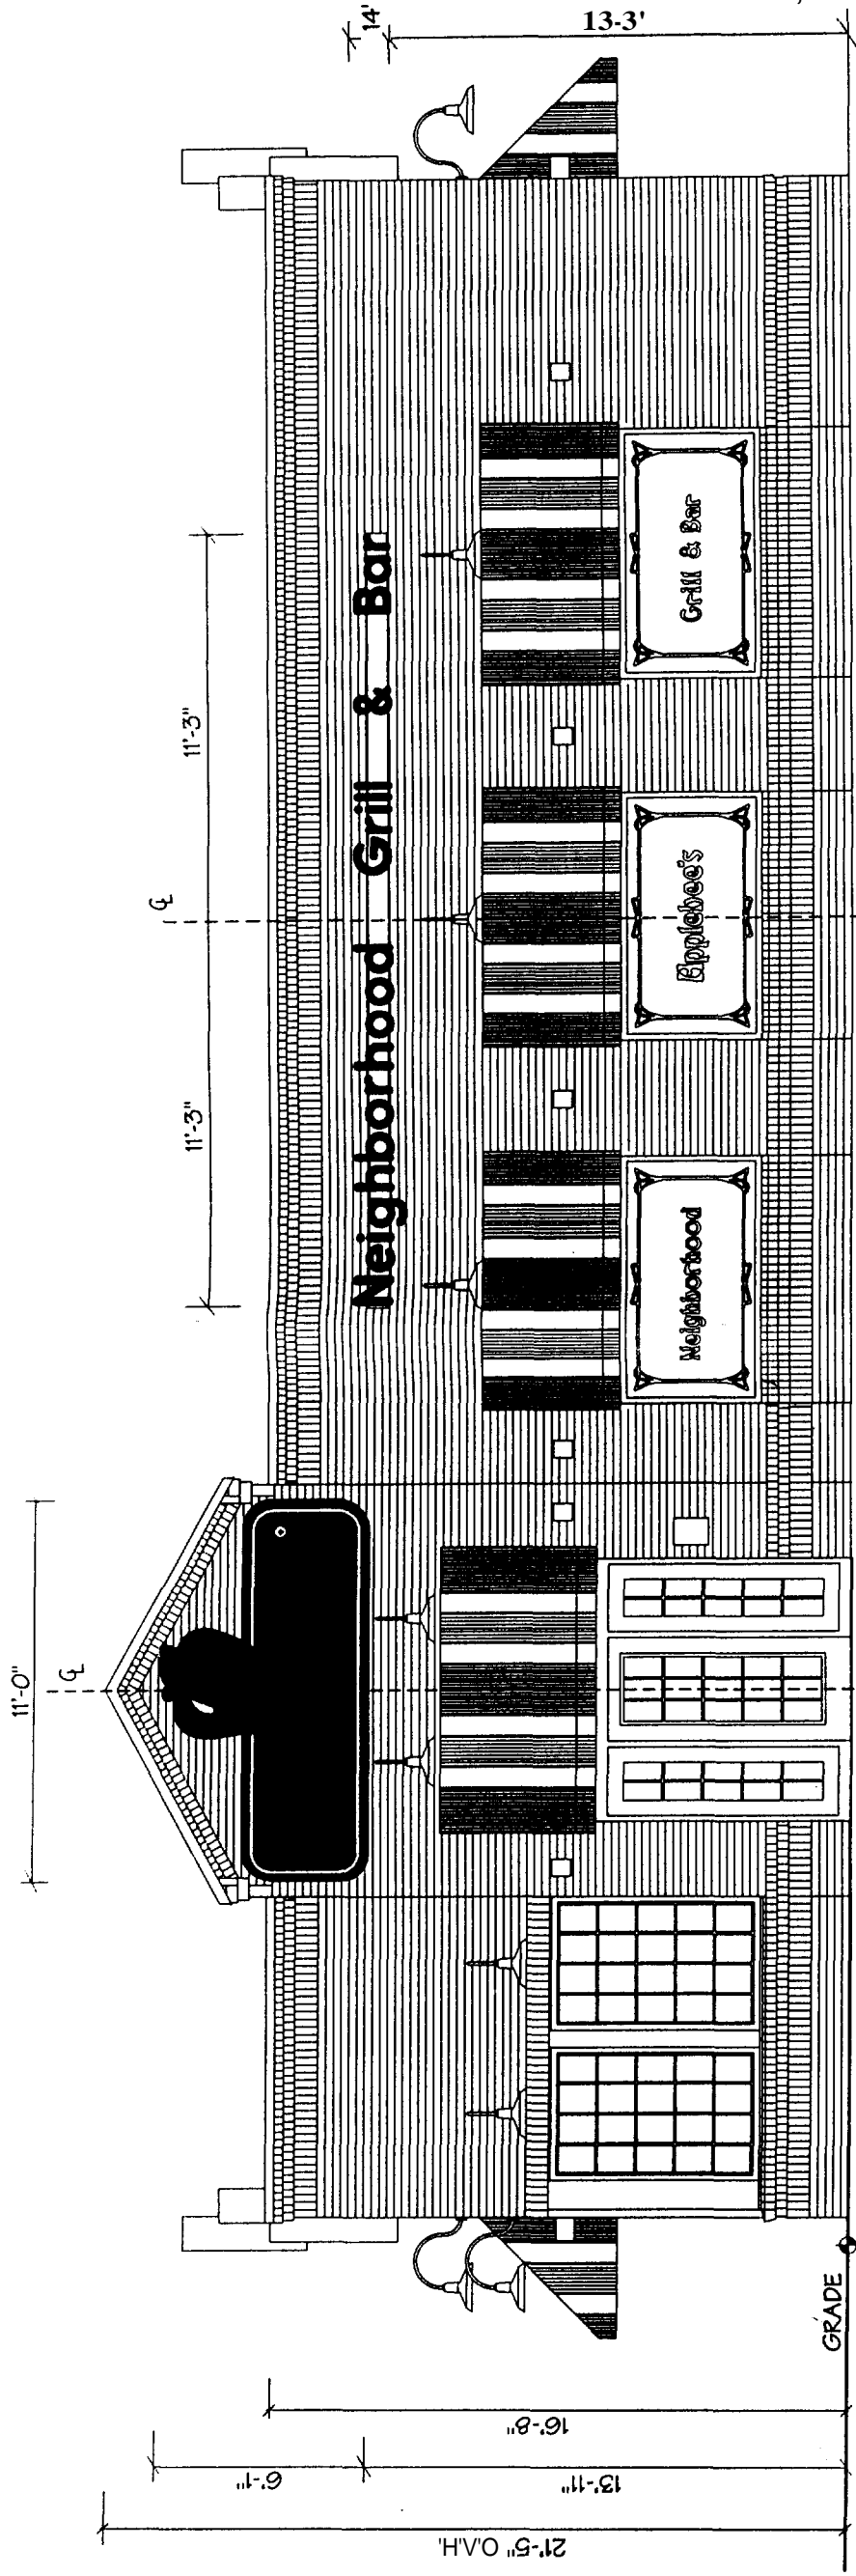

FRONT ELEVATION

SCALE: 3/16" = 1'-0"

AMPS	
APPLEBEE'S	13.7
NEIGHBORHOOD	3.2
GRILL & BAR	4.0
TOTAL CIRCUITS	
APPLEBEE'S	1
NEIGHBORHOOD	1
GRILL & BAR	
TOTAL SQUARE FOOTAGE	
APPLEBEE'S	67
NGB	25.6

NOTE: ALL PRIMARY PENETRATIONS THRU WALL SURFACE TO BELOW ROOF FOR WALL SIGNS.
ALL PRIMARY HOOK-UP BY GENERAL CONTRACTOR'S ELECTRICIAN.

NOTE:
OVERALL LENGTH OF NEIGHBORHOOD GRILL & BAR RACEWAY AS SHOWN MUST BE PLACED SO
EQUAL DISTANCE APPEARS BALANCED ABOVE THE THREE GOOSENECKS. INSTALLER MUST MEASURE
PLACEMENT FIRST BEFORE SECURING TO WALL. INSTALLER TO VERIFY ROOFLINE.


NOTE: THIS SKETCH IS THE EXCLUSIVE PROPERTY OF SIGN LITE CORPORATION. IT SHOULD NOT BE COPIED, REPRODUCED DISPLAYED OR USED IN ANY WAY WITHOUT THE WRITTEN APPROVAL OF SIGN LITE CORPORATION. **FOR SL 9-15-98**

DATE 9/15/98		DESIGNER CS		SCALE 3/16" = 1'-0"	
DRAWING 980915-01		SALES REP PAM		LOCATION APPLEBEE'S BRIGHTON RD PORTLAND, ME	
PAGE 1		REVISIONS		FACE	
OF 3				FLAT PAN EMBOSSED FLEX	
				COLOR	
				BASE	
				L x D	
				Concrete	
				PSF	
				Windload @	
				HEIGHT ABOVE GRADE	
				PLATES	
				STRUCTURE	
				WALL MOUNT	
				CENTER POLE	
				TWIN POLE	
				MOUNTING	
				NON-ILLUMINATED	
				ILLUMINATED	
				ELECTRICAL	
				NON-ILLUMINATED	
				ILLUMINATED	
				LETTERS	
				STYLE	
				NON-ILLUMINATED	
				ILLUMINATED	
				METAL	
				PLASTIC	
				FLAT	
				FORMED	
				TRIM CAP	
				OTHER	
				NEON	
				TOTAL AMPS	
				277	
				OTHER	
				NOTED	
				FIXTURE	
				UL	

SIGN-LITE
SIGN · LIGHTING · SERVICE


APPLE FILLER & BACK .063 ALUM. (GLOSS BLACK)
 12 MM COATED GREEN NEON
 STEM PMS 360
 BORDER & HIGHLIGHT SHOW THRU TO PLEX (EGGSHELL WHITE)
 13MM CL. RED NEON AROUND APPLE

BOTTOM OF STEM PMS 360
 TOP OF LEAF PMS 360
 BOTTOM OF LEAF PMS 348
 BLACK RETURNS- "EGGSHELL WHITE" INSIDE.
 F36T12 CW H/O LAMPS
 "APPLE 3/16" FORMED ACRYSTEEL PAINTED PMS 200 RED

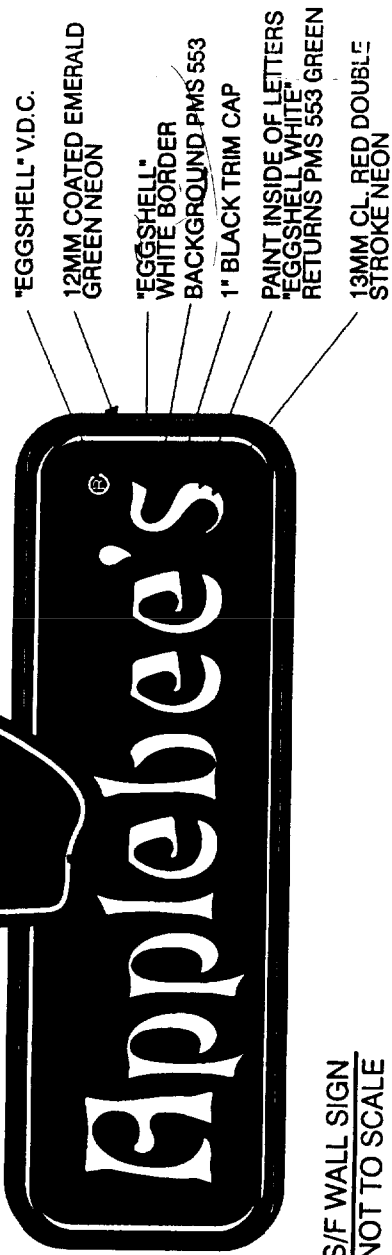


S/F WALL SIGN
 NOT TO SCALE

ULHS
 1-B4 728279
 1-B4 728228

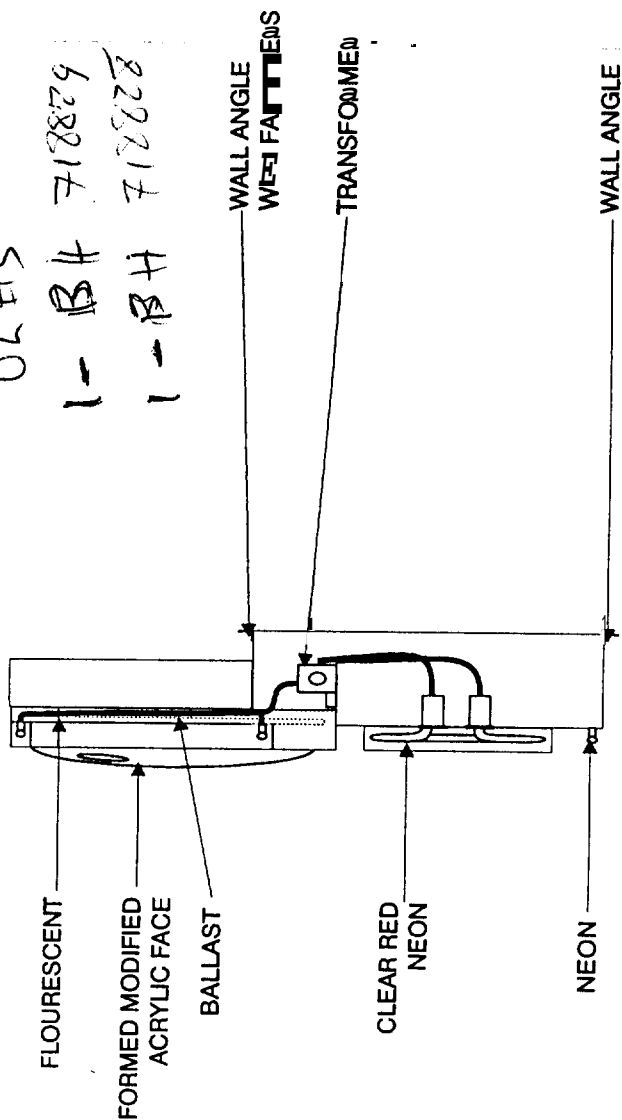

TYPICAL SIDE DETAIL
 NOT TO SCALE

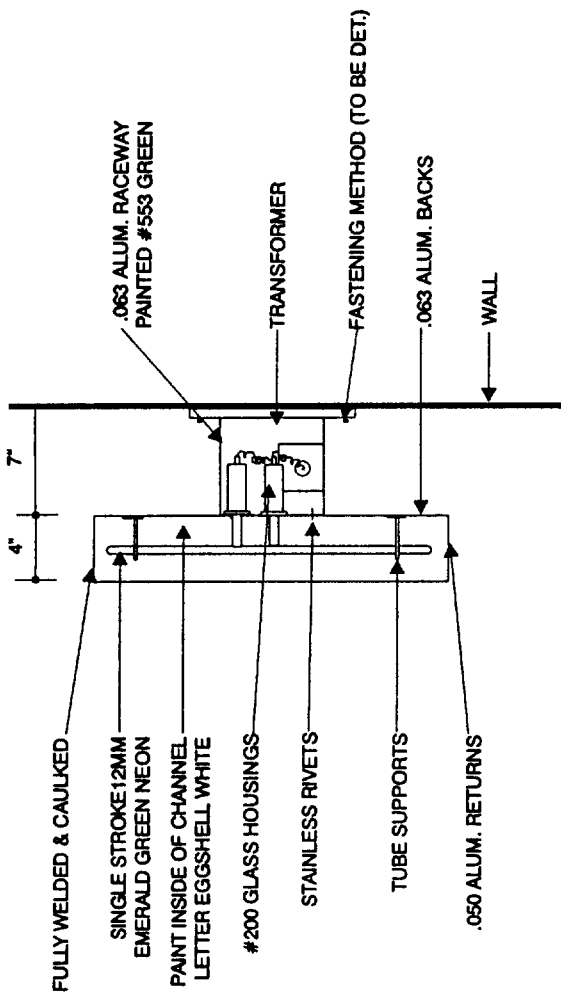

TYPICAL SIDE DETAIL
 NOT TO SCALE

NOTE: THIS SKETCH IS THE EXCLUSIVE PROPERTY OF SIGN LITE CORPORATION. IT SHOULD NOT BE COPIED, REPRODUCED DISPLAYED OR USED IN ANY WAY WITHOUT THE WRITTEN APPROVAL OF SIGN LITE CORPORATION. PBR SL 1-K-18

CLIENT		APPLEBEE'S		SIGN SPECIFICATIONS		CABINET		MOUNTING		ELECTRICAL		LETTERS	
LOCATION	BRIGHTON RD PORTLAND, ME	S/F	HEIGHT	LENGTH	WIDTH	ALUMINIUM EXTRUSION	BASE	CENTER POLE	TWIN POLE	NON-ILLUMINATED	ILLUMINATED	STYLE	LETTERS
DATE	9/15/98	D/F				FABRICATED BOX COLOR		WALL MOUNT	OTHER	INTERNAL	EXTERNAL	NON-ILLUMINATED	ILLUMINATED
DRAWING	980915-03							STRUCTURE		LAMPS		METAL	PLASTIC
PAGE	3 OF 3							PLATES		BALLASTS		FLAT	FORMED
								HEIGHT ABOVE GRADE		120V	277	TRIM CAP	OTHER
								Windload @		TOTAL AMPS		OTHER	NEON
										FIXTURE			

SIGN-LITE
 SIGN · LIGHTING · SERVICE