

© 2015 RYAN SENATORE ARCHITECTURE

BATTERIES AND BULBS FIT-UP
BRIGHTON AVENUE
PORTLAND, MAINE



RYAN SENATORE
ARCHITECTURE
565 CONGRESS STREET
PORTLAND, MAINE 04101
207-650-6414
senatorearchitecture.com

CONSULTANTS:

REVISIONS:

DATE: DECEMBER 22, 2015

PROJECT No.

DRAWN BY:


CHECKED BY: RJS

SCALE: AS NOTED


SHEET TITLE:

FLOOR PLAN

A1-0

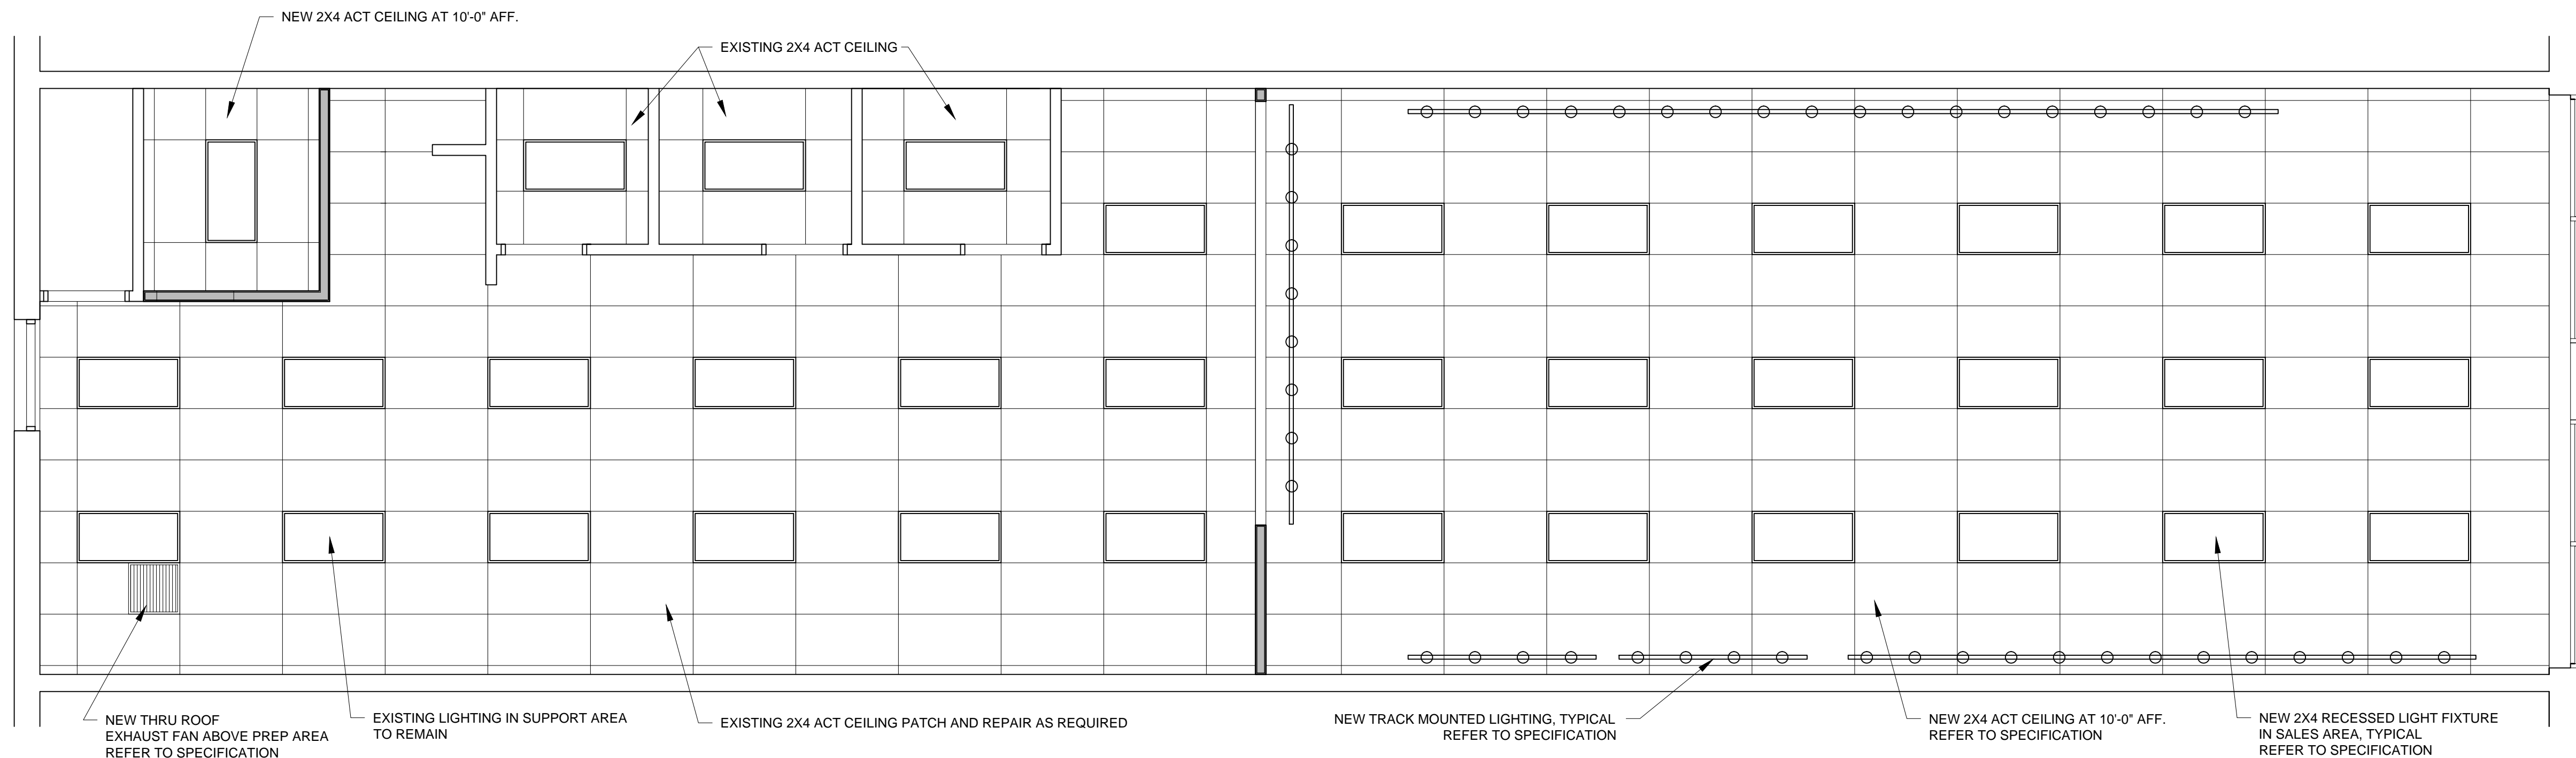

2 REFLECTED CEILING PLAN
1/4" = 1'-0"

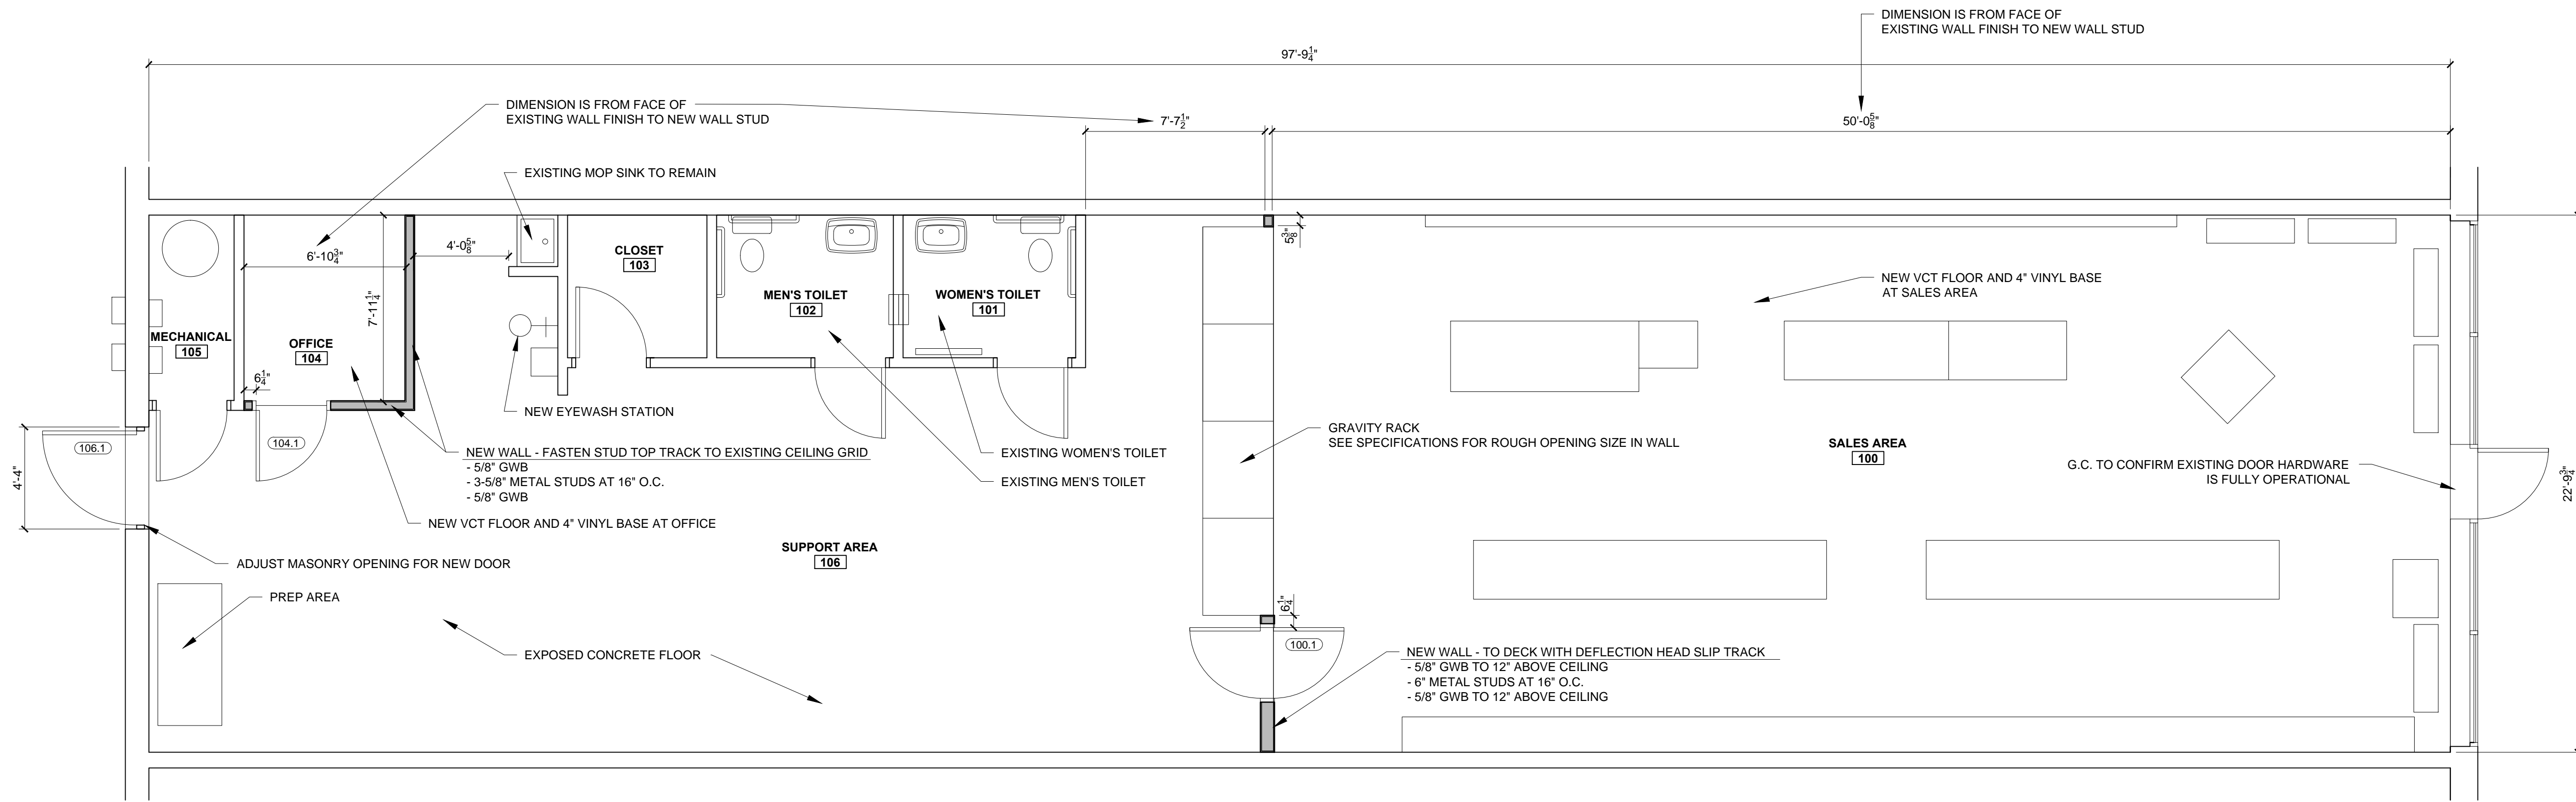

1 FLOOR PLAN
1/4" = 1'-0"

WALL LEGEND	
EXISTING WALL	
NEW WALL	