

Tenant Demising Project
 Vanilla Box Fit Out
 Space #s 200 & 240 I, Pine Tree Shopping Center
 1040 Brighton Ave, Portland, ME


Red Barn Architecture
 84 HIGH STREET
 IPSWICH, MA 01938
 (978) 595-6764

GENERAL CEILING NOTES

- ALL ACT CEILINGS SHALL BE SET AT HEIGHT TO MATCH EXISTING UNO
- CENTER ACT GRIDS IN ROOMS AS SHOWN. CENTER FIXTURES, AND OTHER CEILING MOUNTED ITEMS IN CENTER OF PANEL
- ALL LIGHTS TO BE 2x2' or 2x4' LED FLUSH MOUNTED LAY-IN TYPE FIXTURES
- COORDINATE ALL SWITCHING LOCATIONS WITH TENANT PRIOR TO INSTALLATION
- MECHANICAL AND FIRE PROTECTION LAYOUTS SHOWN FOR SCHEMATIC PURPOSES ONLY. CONTRACTOR SHALL COORDINATE LAYOUTS BETWEEN ALL SUB-CONTRACTORS TO AVOID CONFLICTS
- ALL LIFE SAFETY EQUIPMENT SHALL BE HARD WIRED, INTERCONNECTED, AND ON BATTERY BACK UP WHERE APPROPRIATE

LEGEND

- SUSPENDED CEILING GRID
- GYP. BRD. CEILING OR SOFFIT.
- CEILING MOUNTED RECESSED LIGHT FIXTURE
- EXHAUST FAN VENTED TO OUTSIDE
- CEILING MOUNTED SPEAKER
- 2 x 4 RECESSED FLUORESCENT LIGHT FIXTURE
- SPRINKLER HEAD
- 2 x 2 RECESSED FLUORESCENT LIGHT FIXTURE
- HORN AND STROBE
- EMERGENCY LIGHT
- EXIT SIGN
- PULL STATION
- SMOKE DETECTOR
- FIRE EXTINGUISHER

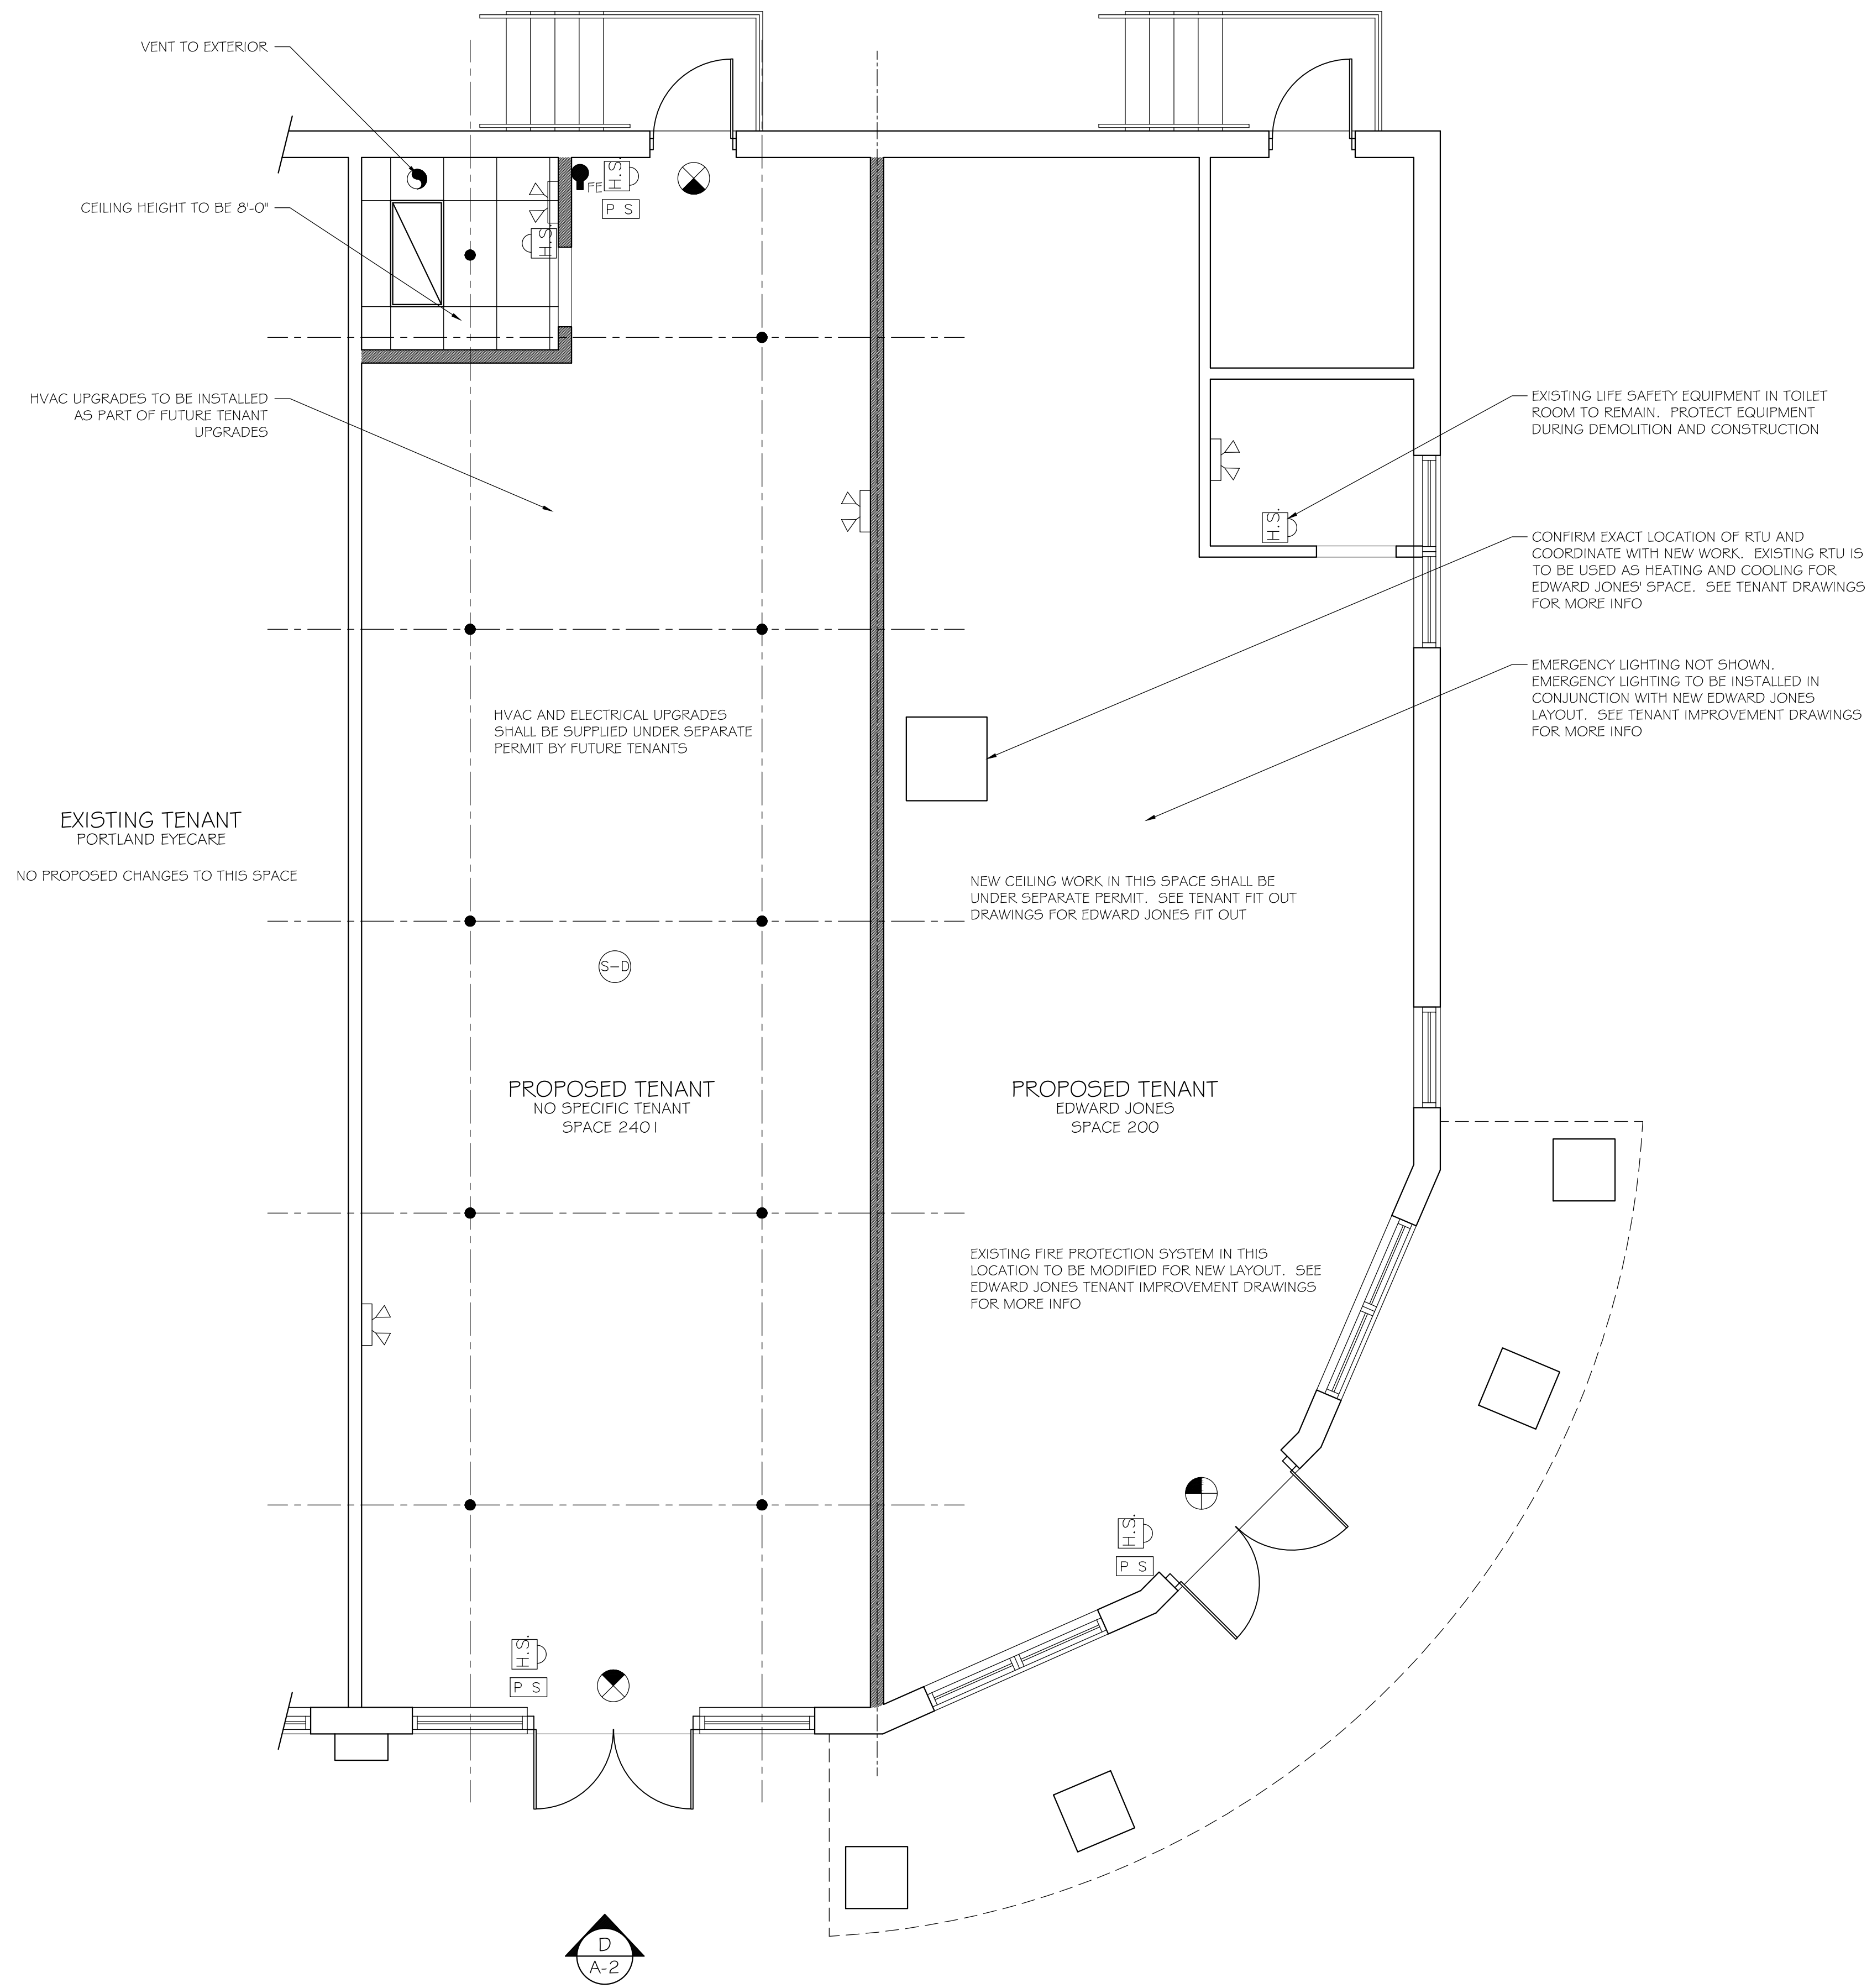

PROPOSED FLOOR PLAN
 SCALE: 1/4" = 1'-0"

No.	Date	Description
1	11.7.16	CD-1

Sheet Title:
 PROPOSED FLOOR
 PLAN AND REFLECTED
 CEILING PLAN

Sheet Number:
 A-3