

PORT CITY ARCHITECTURE

65 NEWBURY STREET
PORTLAND, ME 04101
207.761.9000
fax: 207.761.2010
info@portcityarch.com



BrandPartners Group Inc
10 Main St.
Rochester, NH 03839
Phone: 603.335.1400
Fax: 603.335.1765



Bangor Savings Bank


**BRIGHTON AVE
Portland, Maine**

DATE	DESCRIPTION
--	Design Review

REVISIONS	
Date Issued	10/16/06
Project Number	06108
Drawing Scale	
SHEET NAME	

MECHANICAL PLAN

Drawn By	SHR
Checked By	SFD/col

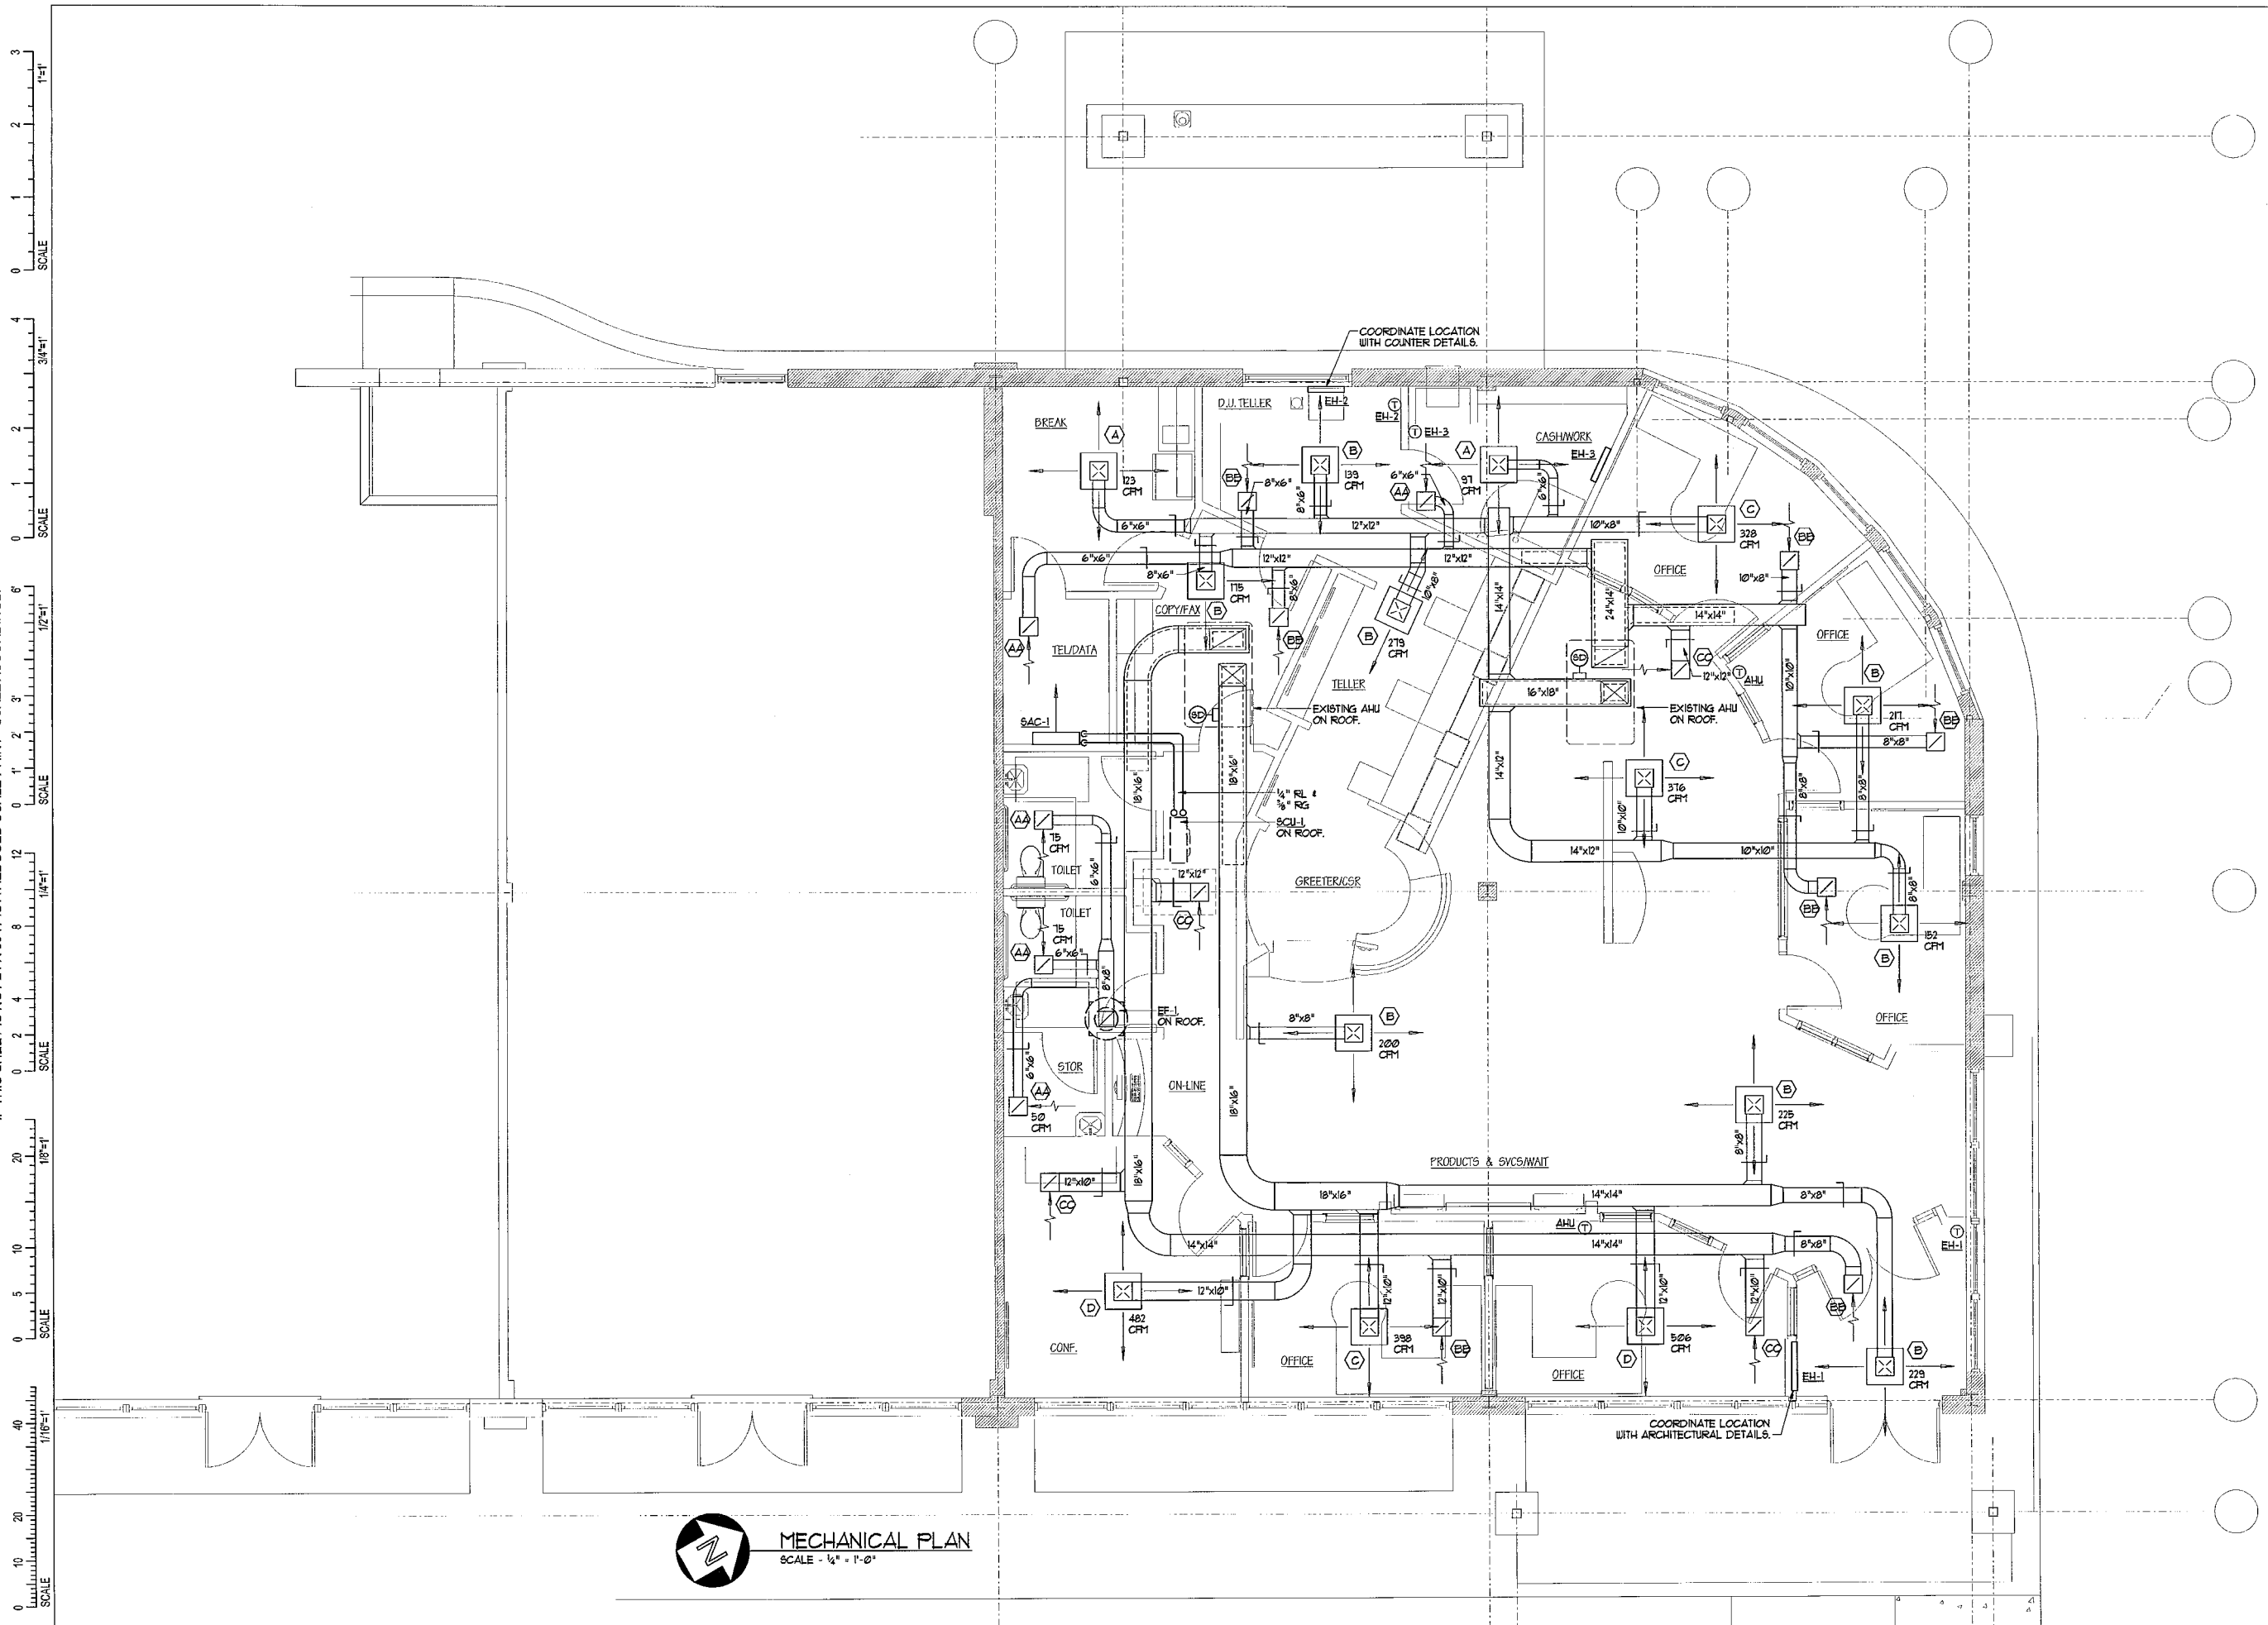

MECHANICAL PLAN
SCALE - 1/4" = 1'-0"

IF THIS SHEET IS NOT 24 X 36 IT IS A REDUCED SCALE PRINT - SCALE ACCORDINGLY

