


PROPOSED LIFE SAFETY FLOOR PLAN

SCALE: 3/16"=1'-0"

- NOTE:
1. EXISTING LIFE SAFETY DEVICES AND HARDWARE TO REMAIN AS APPROVED BY EXISTING CERTIFICATE OF OCCUPANCY CBL 265 B004001 NO. 08-0527
 2. PROPOSED SPACE LIFE SAFETY DEVICES TO BE INSTALLED BY A PROFESSIONAL ELECTRICIAN AS NOTED ON PLAN.

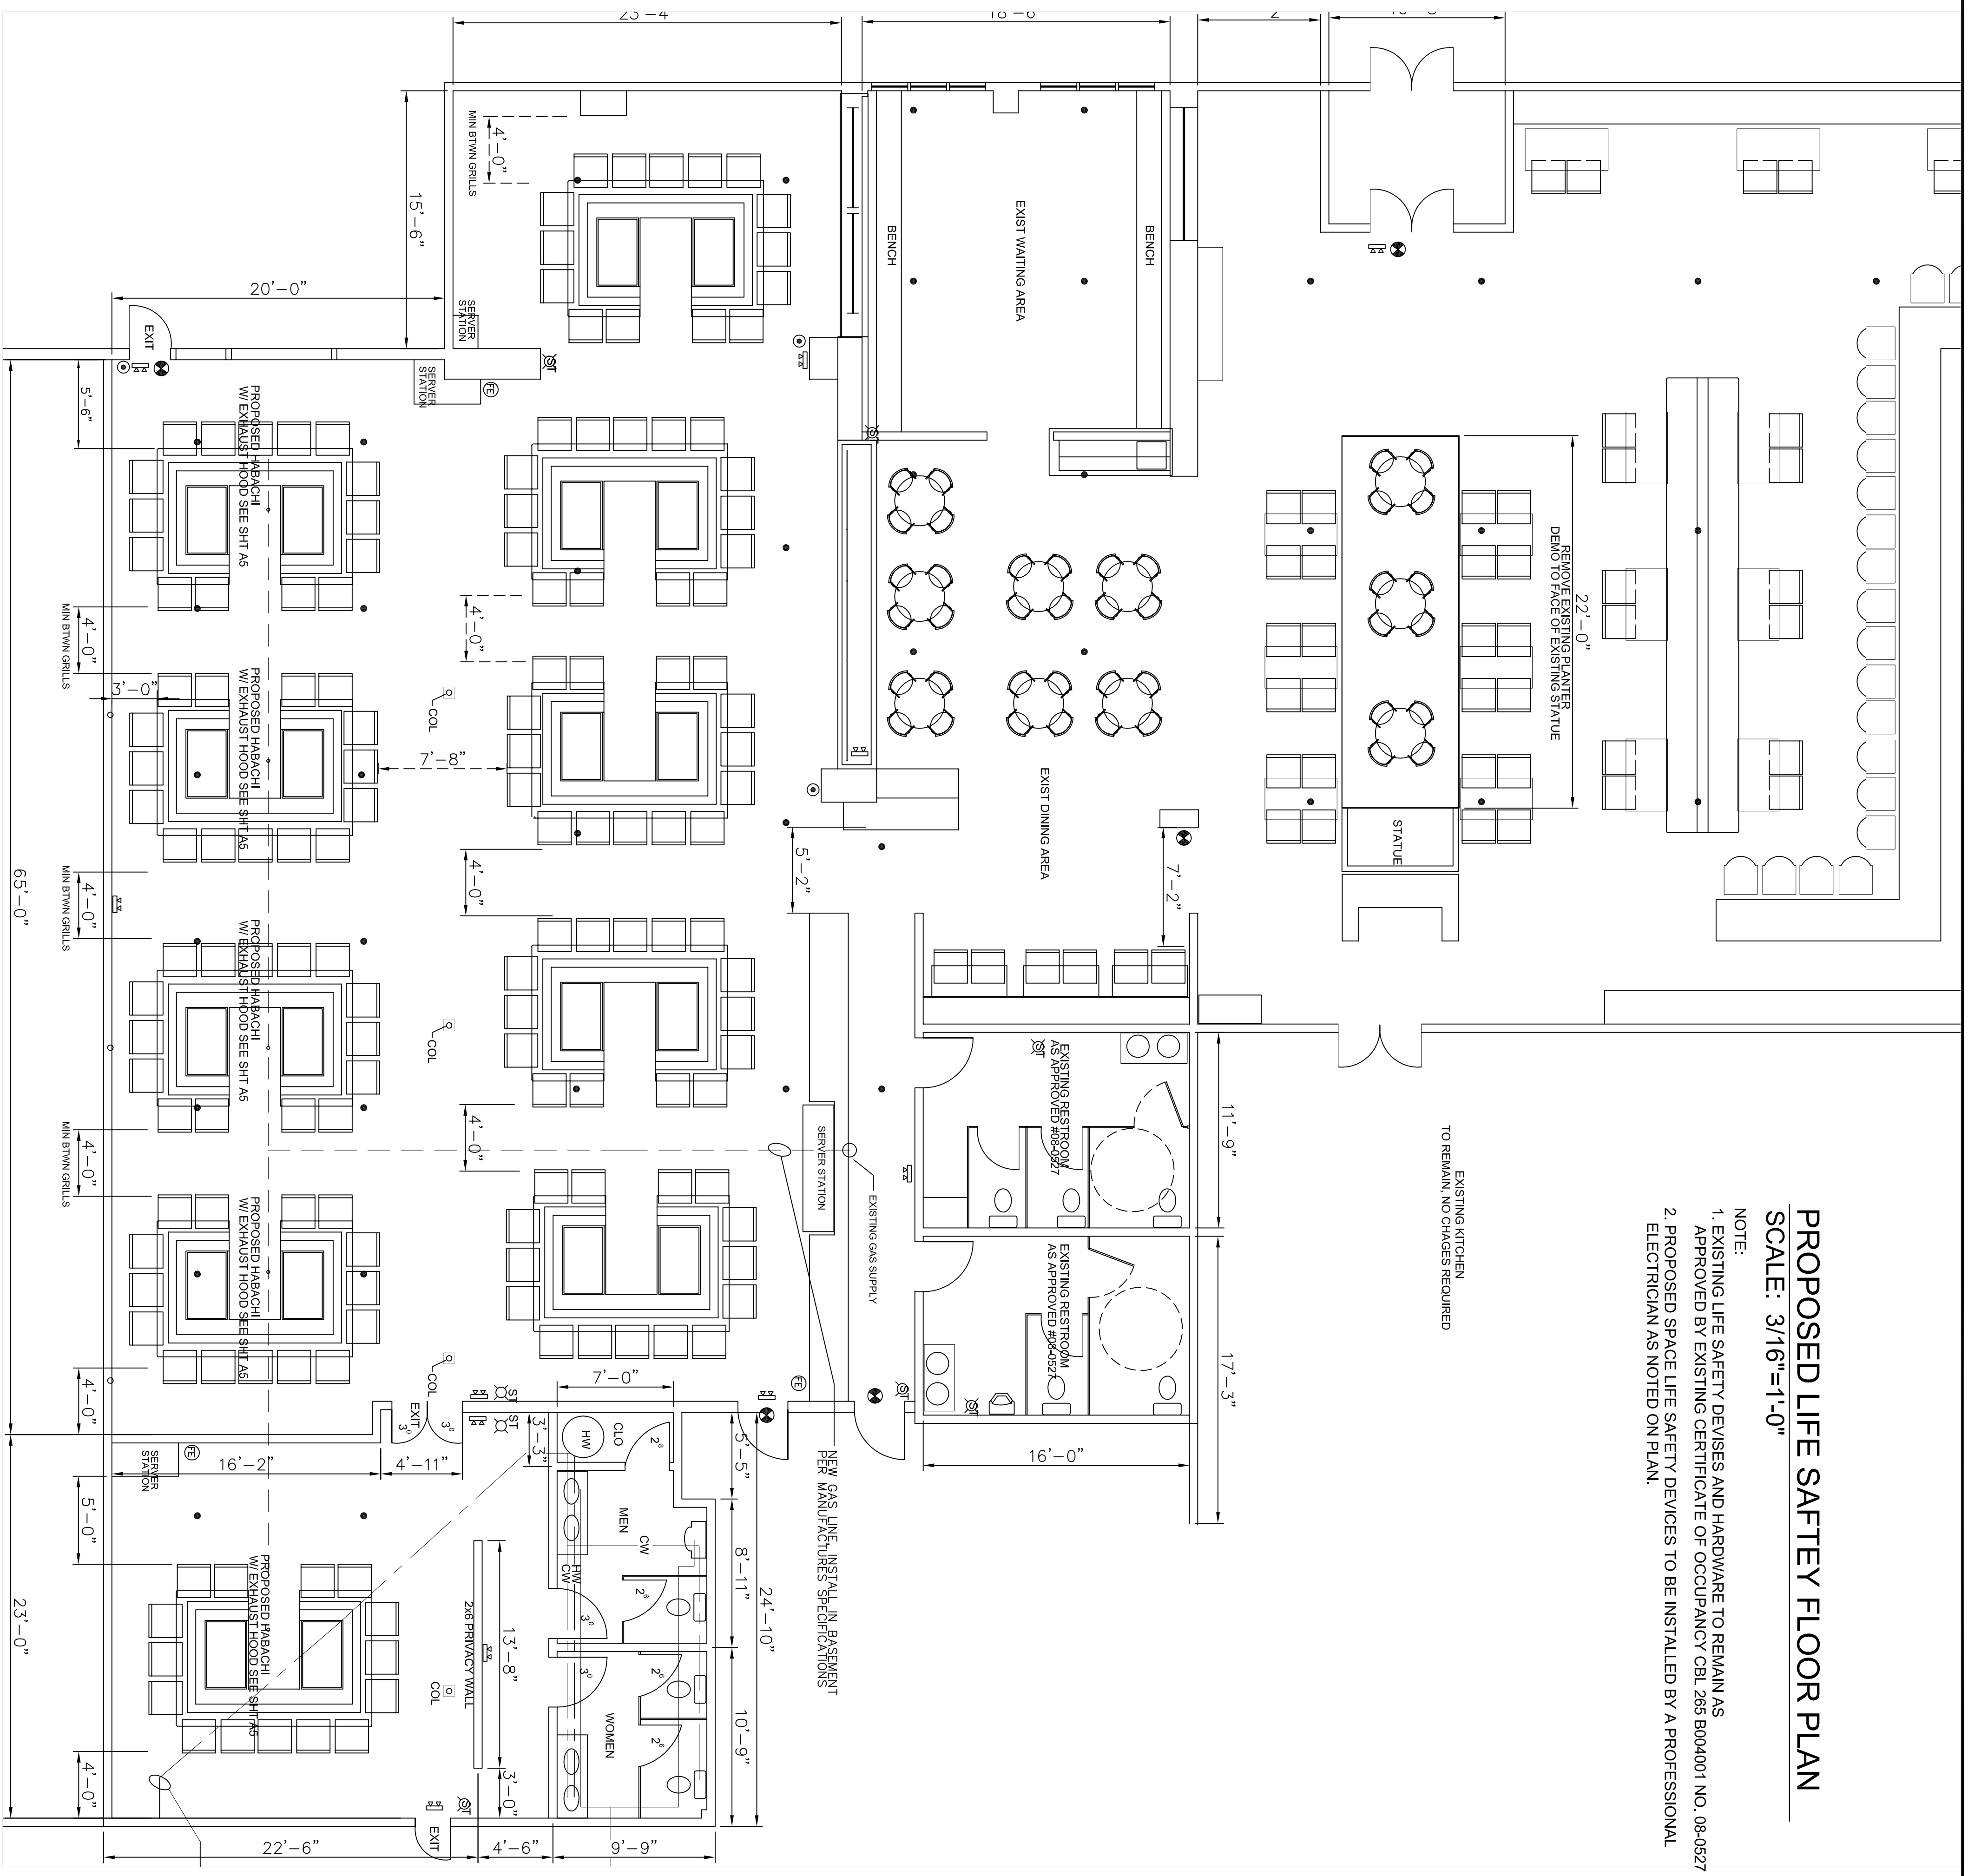

LEGEND

	"K" SERIES FIRE EXTINGUISHER FOR KITCHENS
	CO2 FIRE EXTINGUISHER
	EXIT SIGN
	EMERGENCY LIGHT PACK
	ADA STROBE
	APPROVED EXIST SPRINKLER HEADS
	APPROVED FIRE SUPPRESSION SYSTEM

PROJECT NAME:

Kon Asian Bistro

1140 Brighton Ave, Portland, Maine 04102

DRAFTSMEN:
Stephen S. Andrews
23 Panter Pond Pines Rd.
Raymond, Maine 04071
207-415-5065

REV.	DESCRIPTION	BY	DATE
1	Wall Demo and Construction Add x 4 Habachi Grills w/ approved ventilation	SSA	12-15-10

CODE: _____
TOWN: Portland, Me.
DATE: 05-02-16
SCALE: _____
DESIGNED: SSA
DRAWN: SSA
TITLE: Life Safety Drawing: Egress and Fire Suppression
FILE: _____
SHEET: A-6