




**5 DOMESTIC WATER PIPING TO STORAGE WATER HEATER**  
NO SCALE

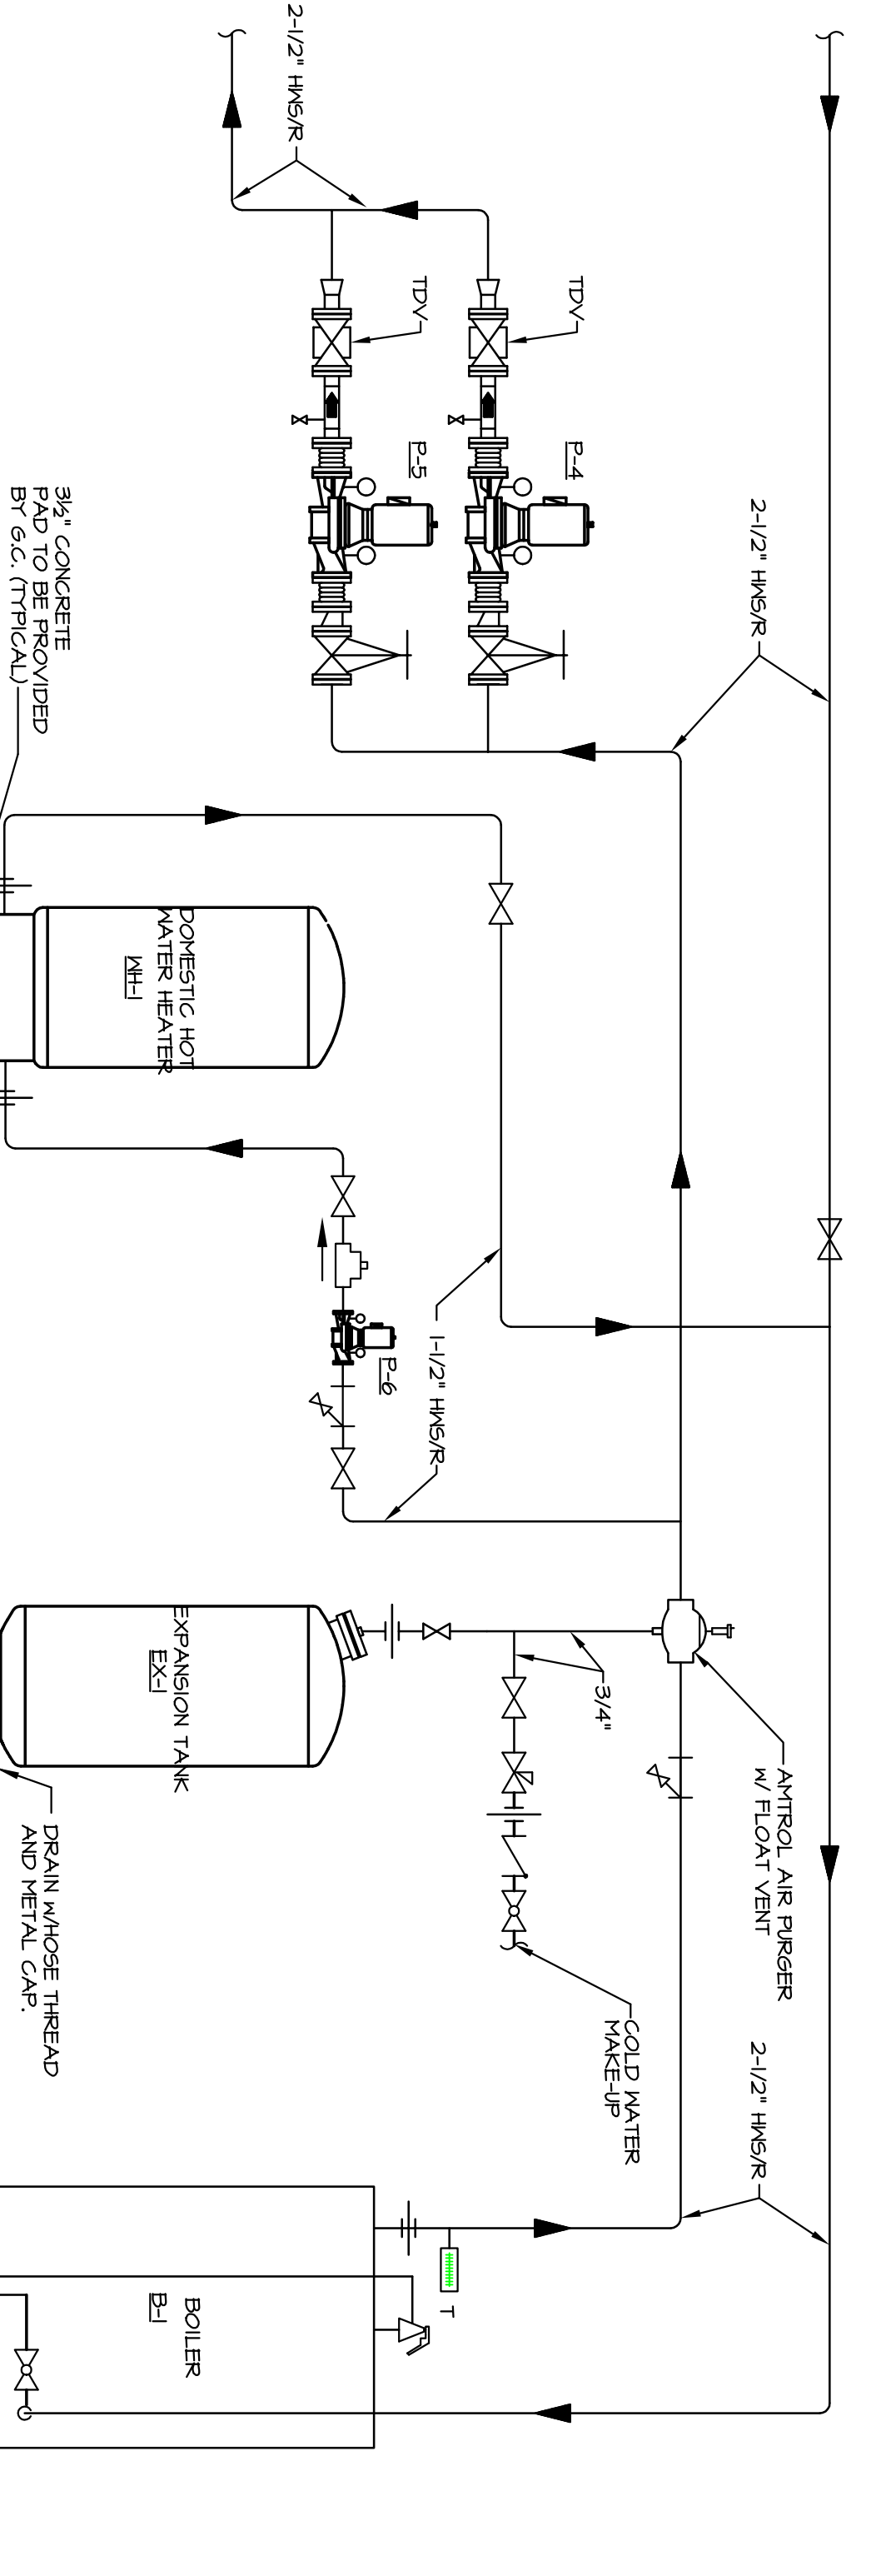



**4 BOILER SCHEMATIC**  
NO SCALE

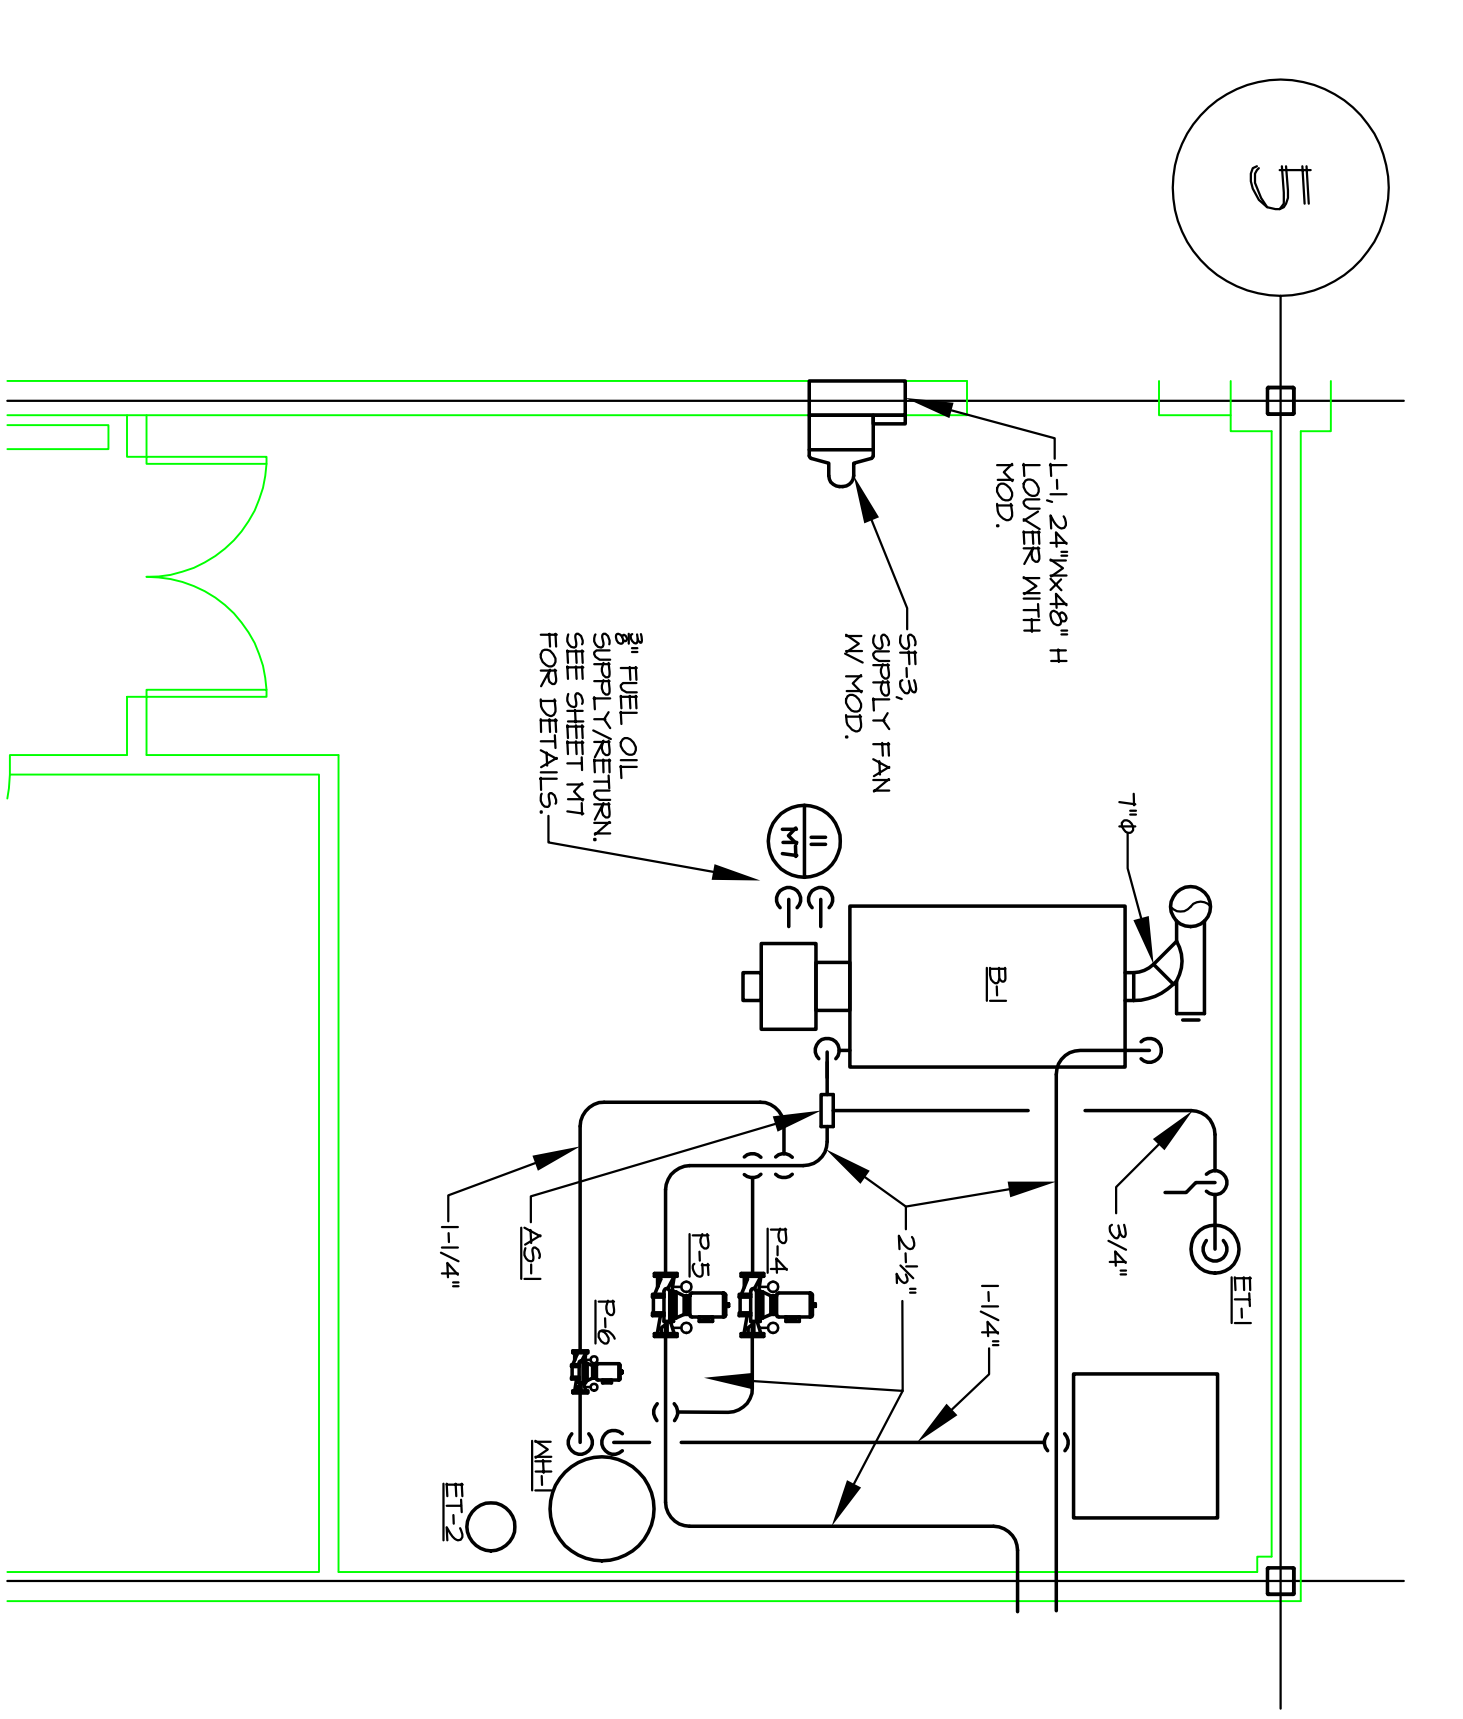


**3 MECHANICAL ROOM LAYOUT**  
SCALE: 1/4" = 1'-0"

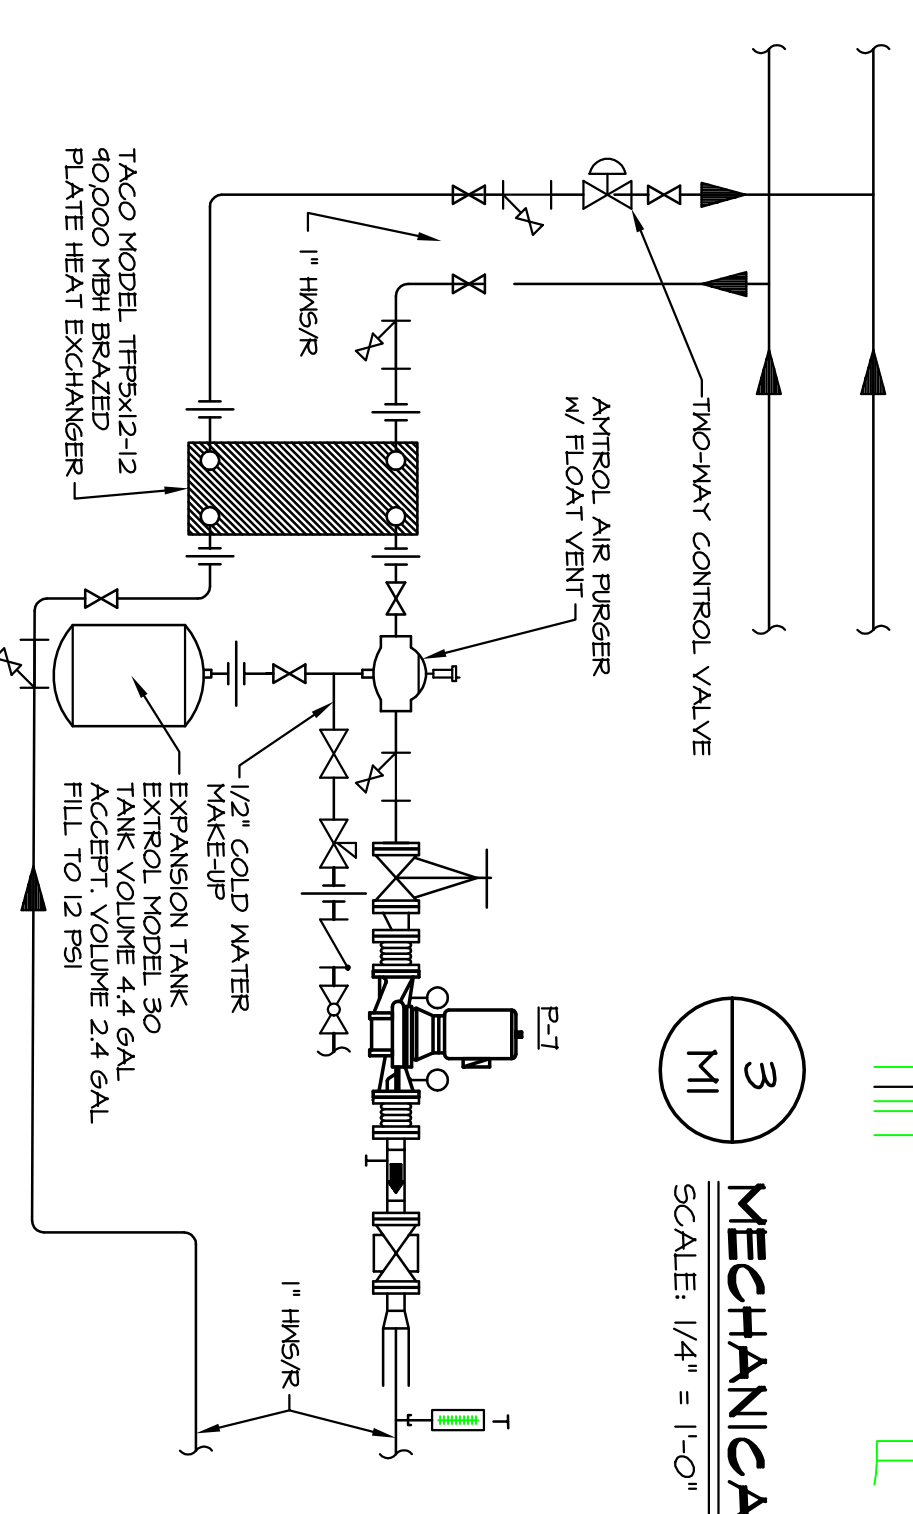


**2 SNOW MELT SYSTEM DETAIL**  
NO SCALE

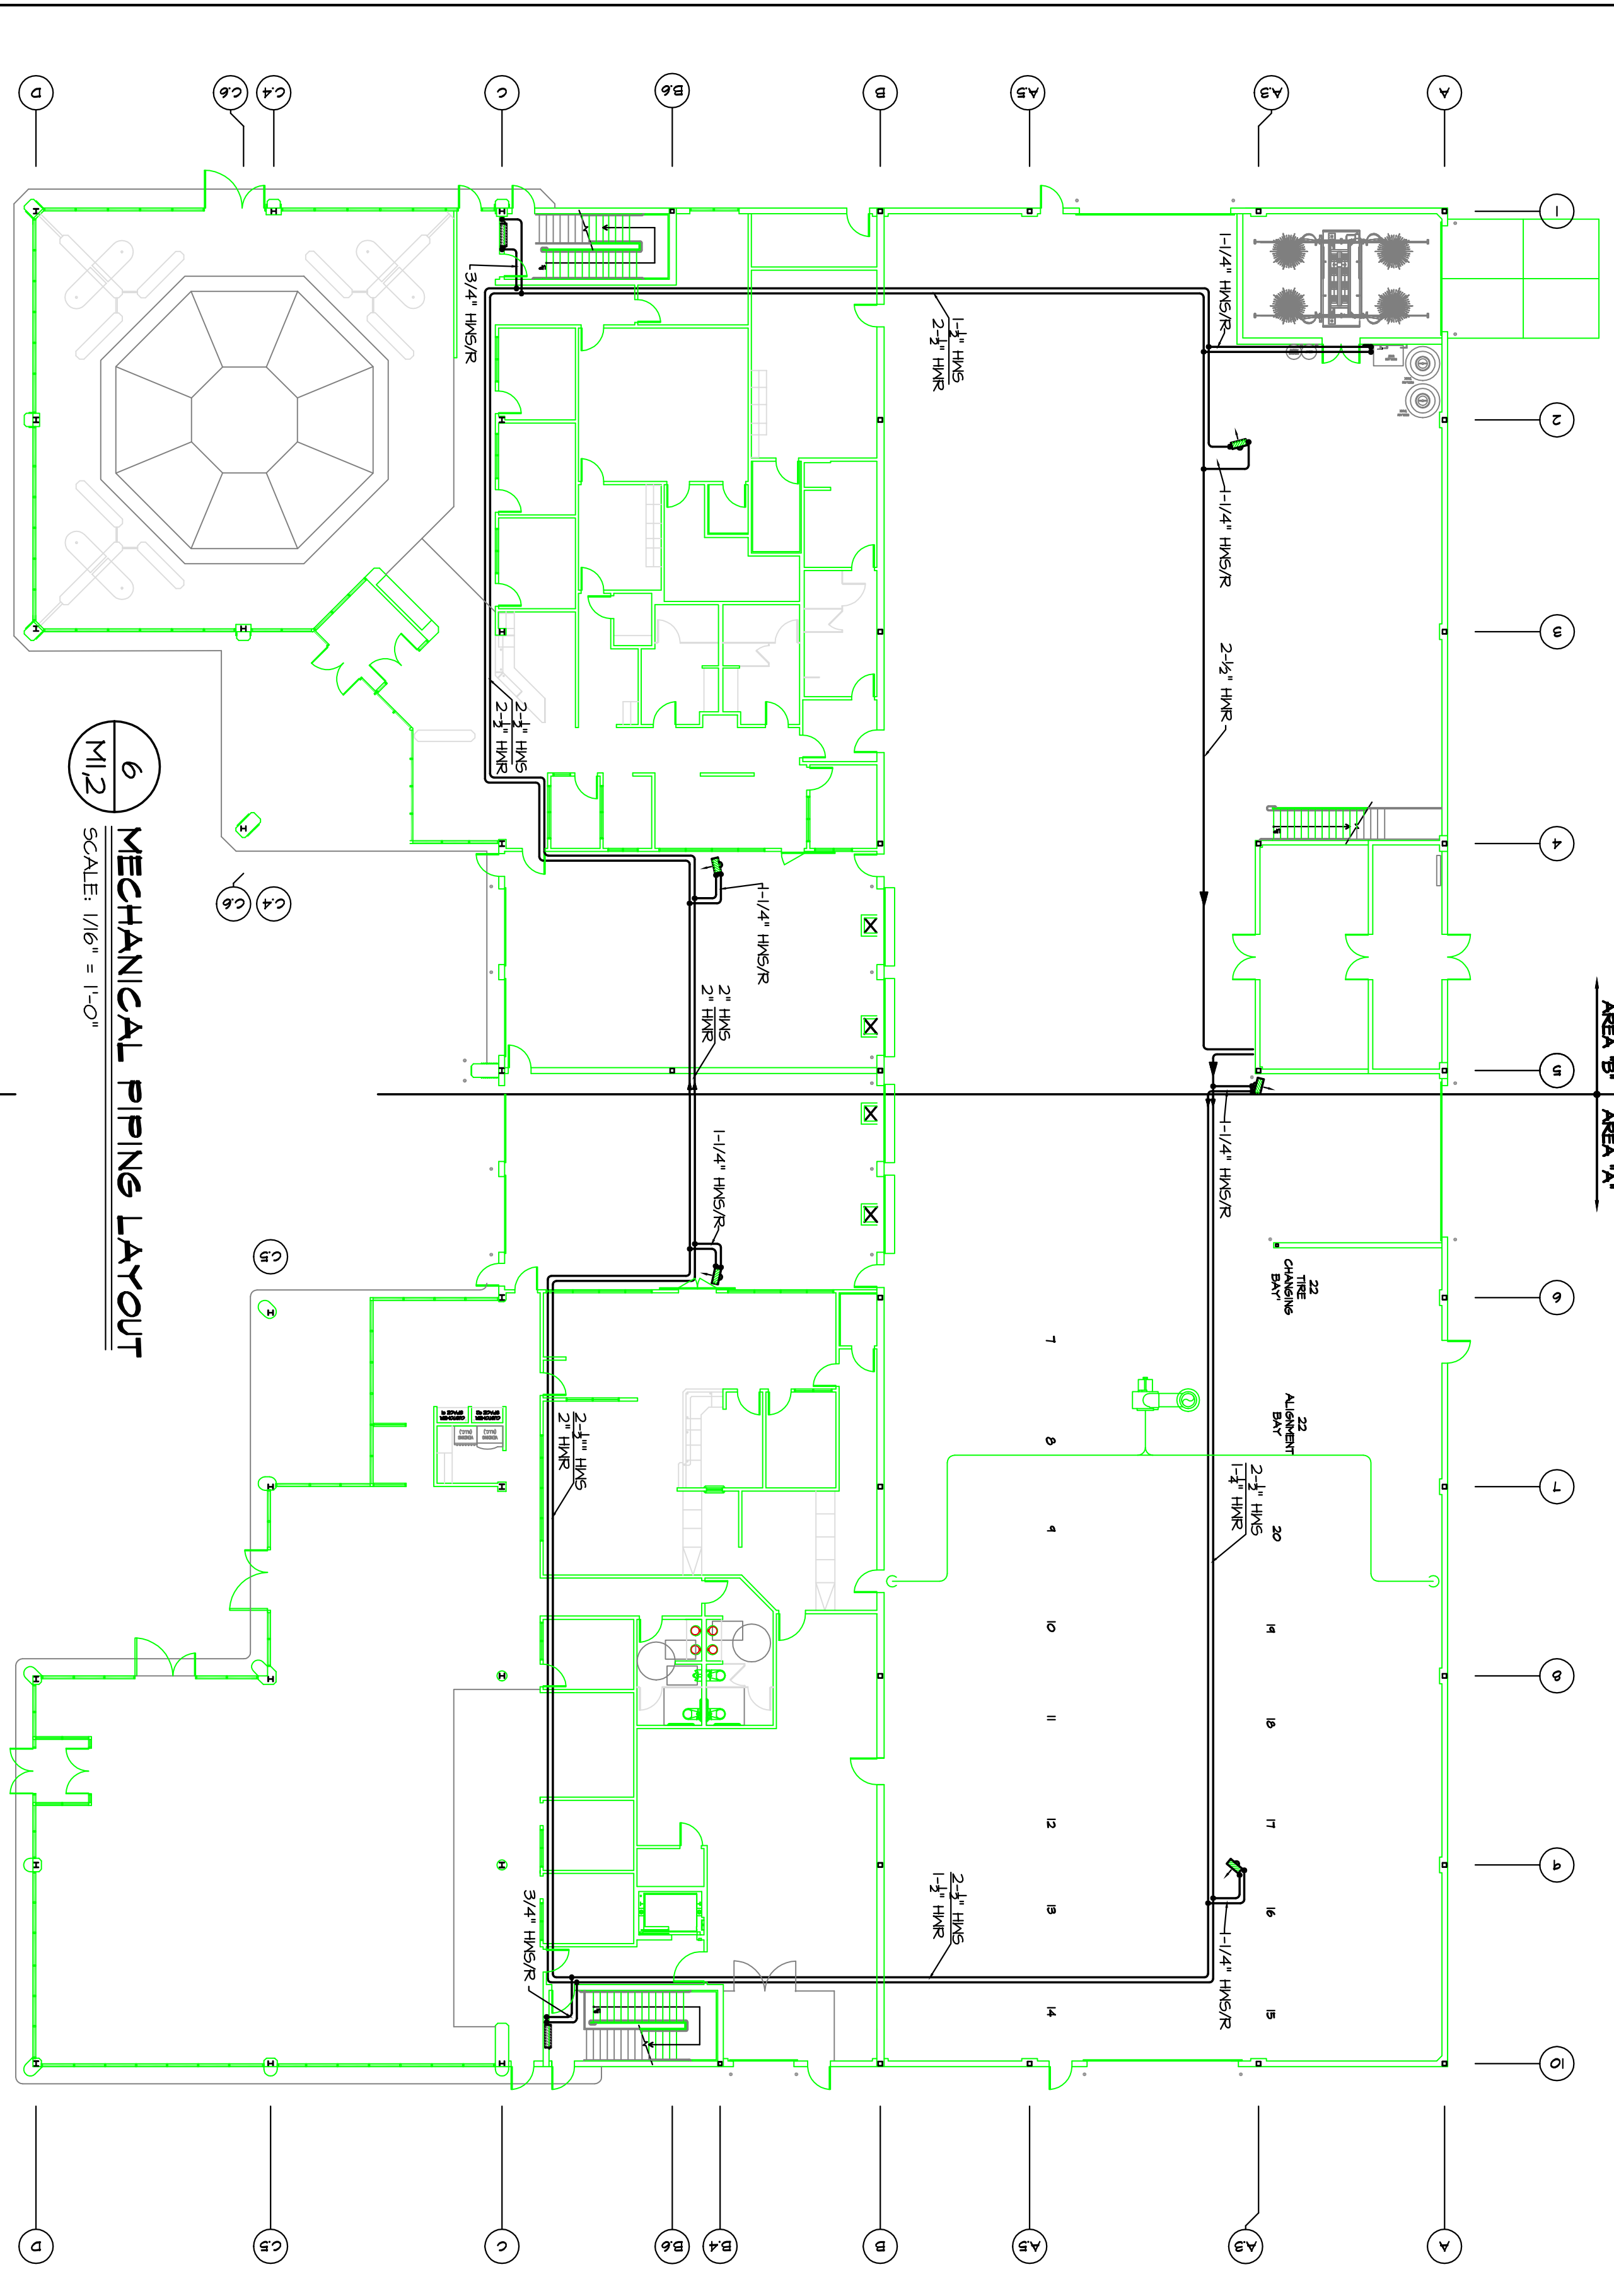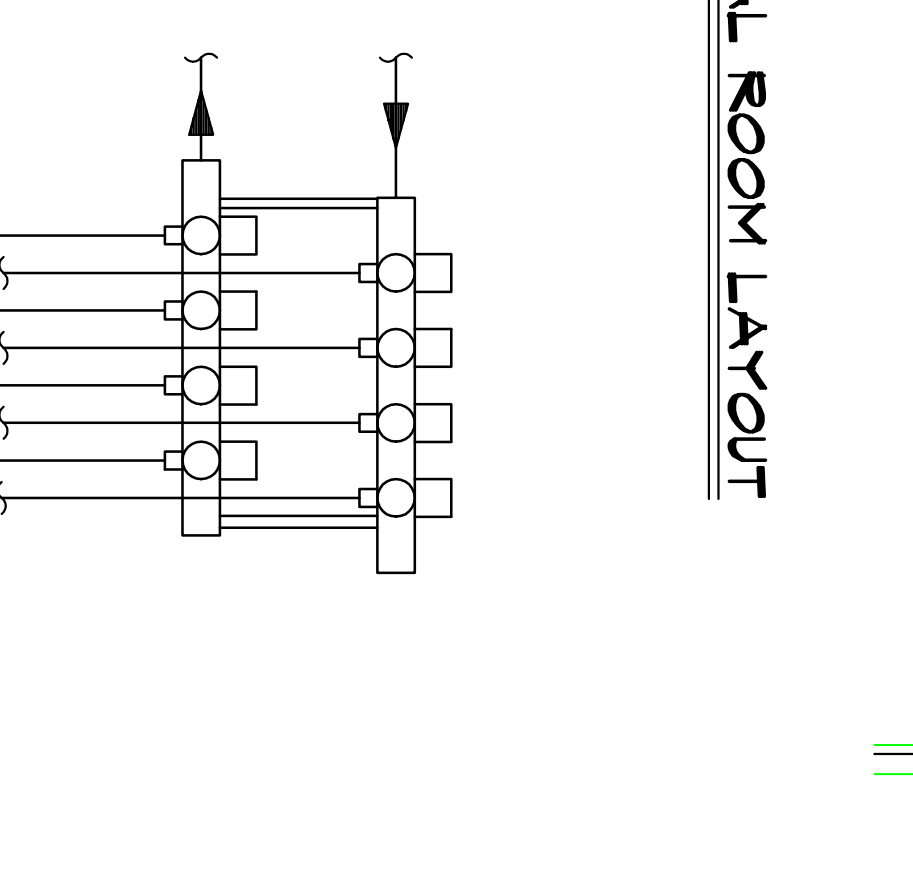

**6 MECHANICAL PIPING LAYOUT**  
SCALE: 1/8" = 1'-0"

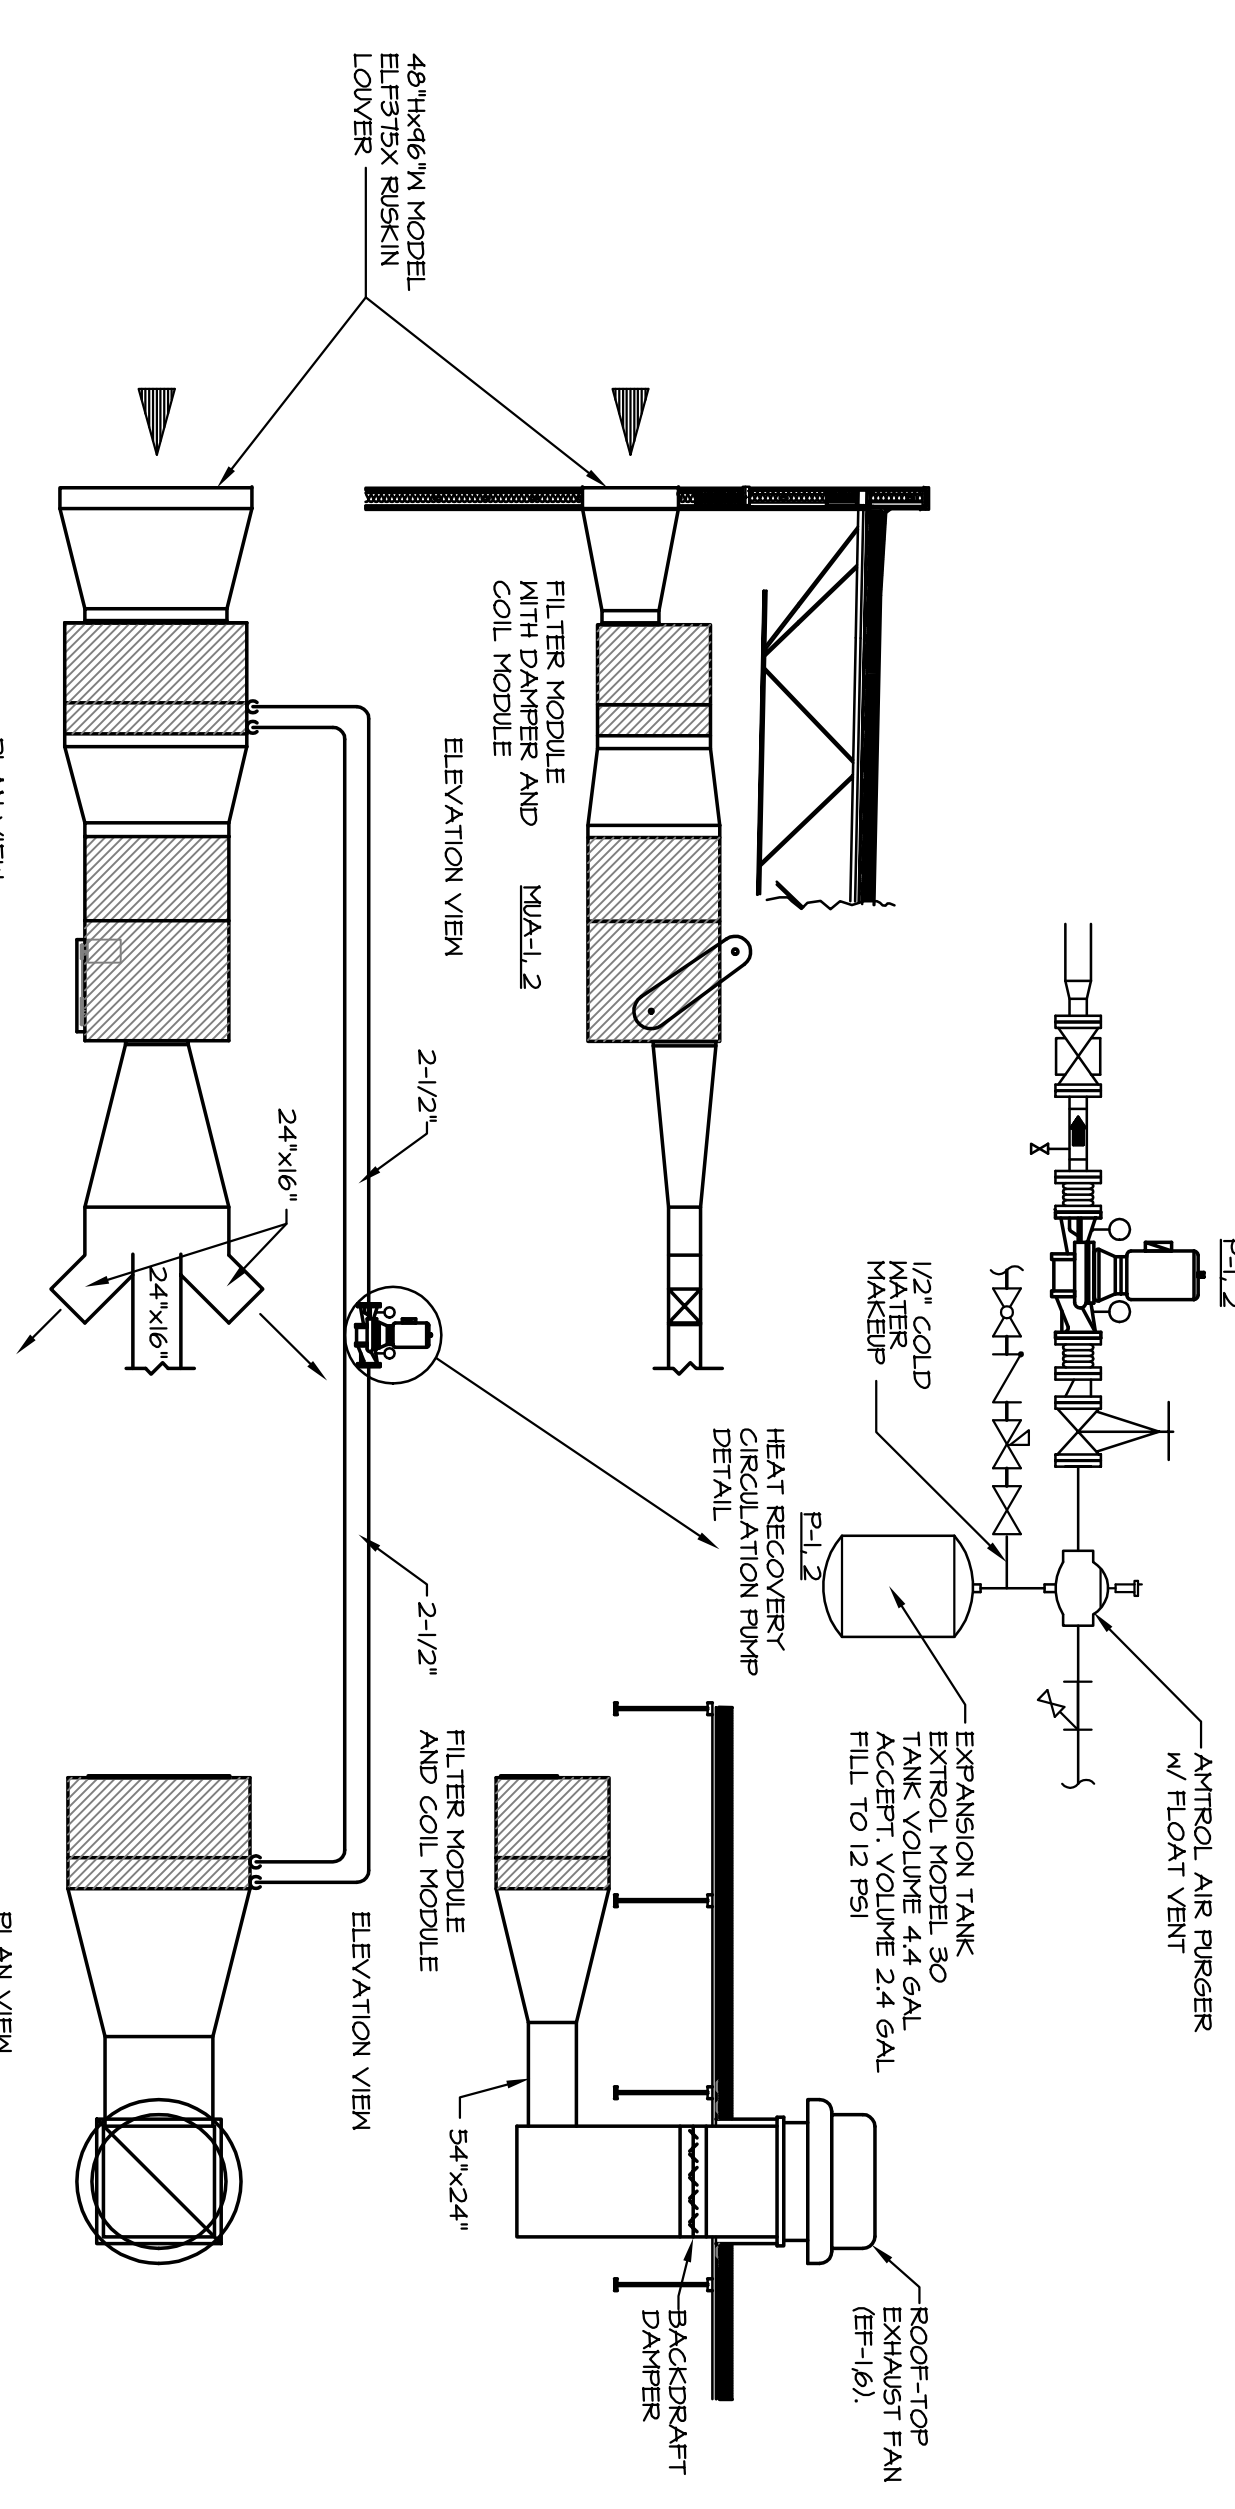

**MUA-1 & 2 DETAIL**  
NOT TO SCALE

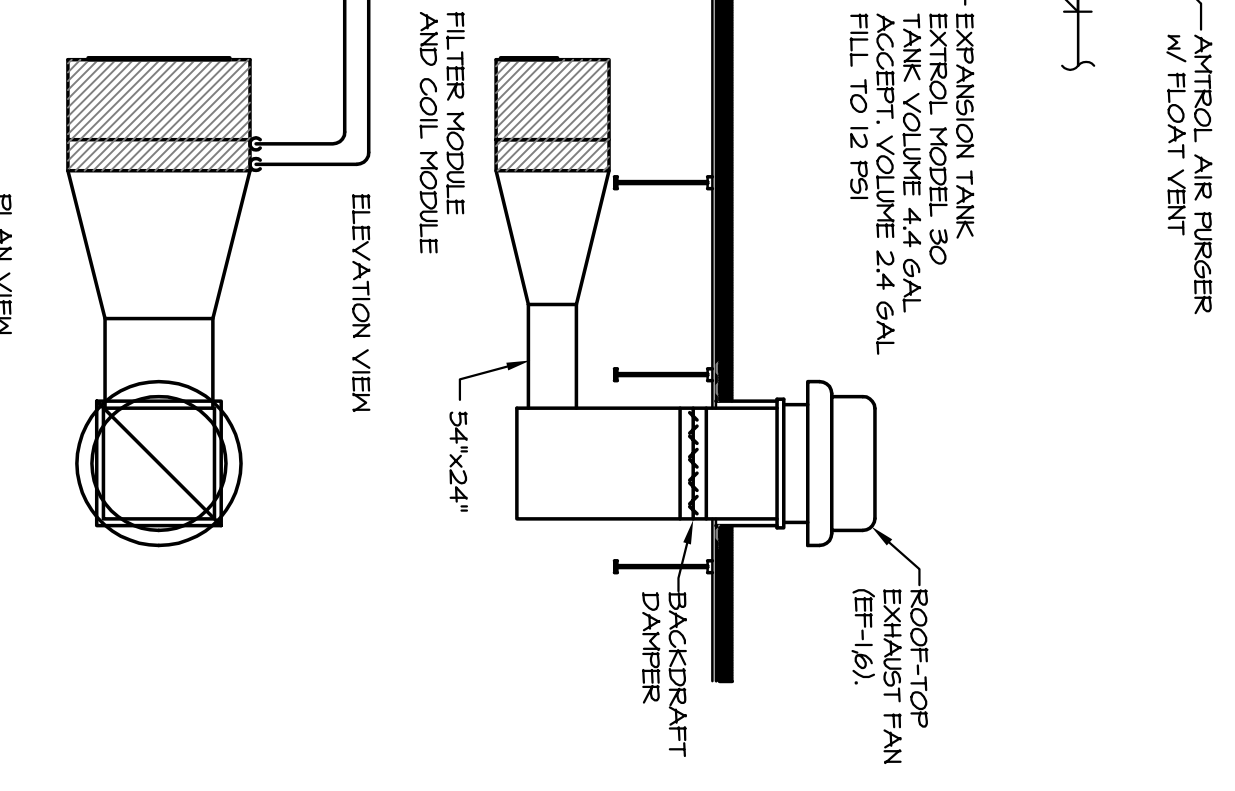

**EF-1 & 6 DETAIL**  
NOT TO SCALE


**1 SERVICE AREA HEAT RECOVERY DETAIL**  
NOT TO SCALE

DETAILS ADDED & RELOCATED 7-26-04  
ISSUED FOR PERMITTING & APPROVAL

REVISIONS	DATE
DETAILS ADD/REL.	7-26

This document is owned by and the information contained in it is proprietary to Titan Mechanical Inc. By receipt hereof the holder agrees not to use the information, disclose it to any third party, nor reproduce this document without the prior written consent of Titan Mechanical Inc. and agrees to return this document forthwith upon request.

**Titan Mechanical, Inc.**  
Design Build Engineering - Mechanical Contracting  
P.O. Box 3927 / 41 Evergreen Drive  
Portland, Maine 04104  
Ph. (207) 878-5223 Fax. (207) 878-5235

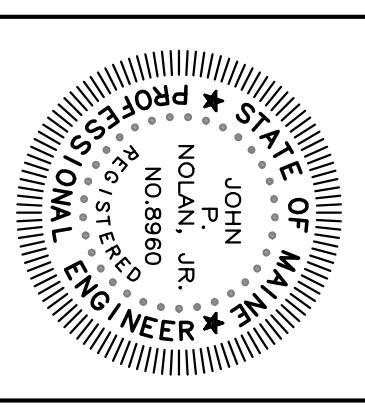

<b>MAINE MALL MOTORS</b>
CLIENT
<b>NEW DEALERSHIP</b>
PROJECT
<b>DETAILS</b>
DRAWING TITLE
DATE: 3/26/04
SCALE: AS NOTED
DRAWN BY: JPN
CHECKED BY: JPN
JOB NUMBER: XXXX
CAD FILE: XXXX
SHEET NUMBER
<b>M5</b>
SHEET 5 OF 7