


ADJUST AND BALANCE EXISTING BY-PASS VAV BOX AND EXISTING AIR HANDLING UNIT TO DESIGN CFM.

1 LEVEL TWO HVAC PLAN  
SCALE: 1/8" = 1'-0"

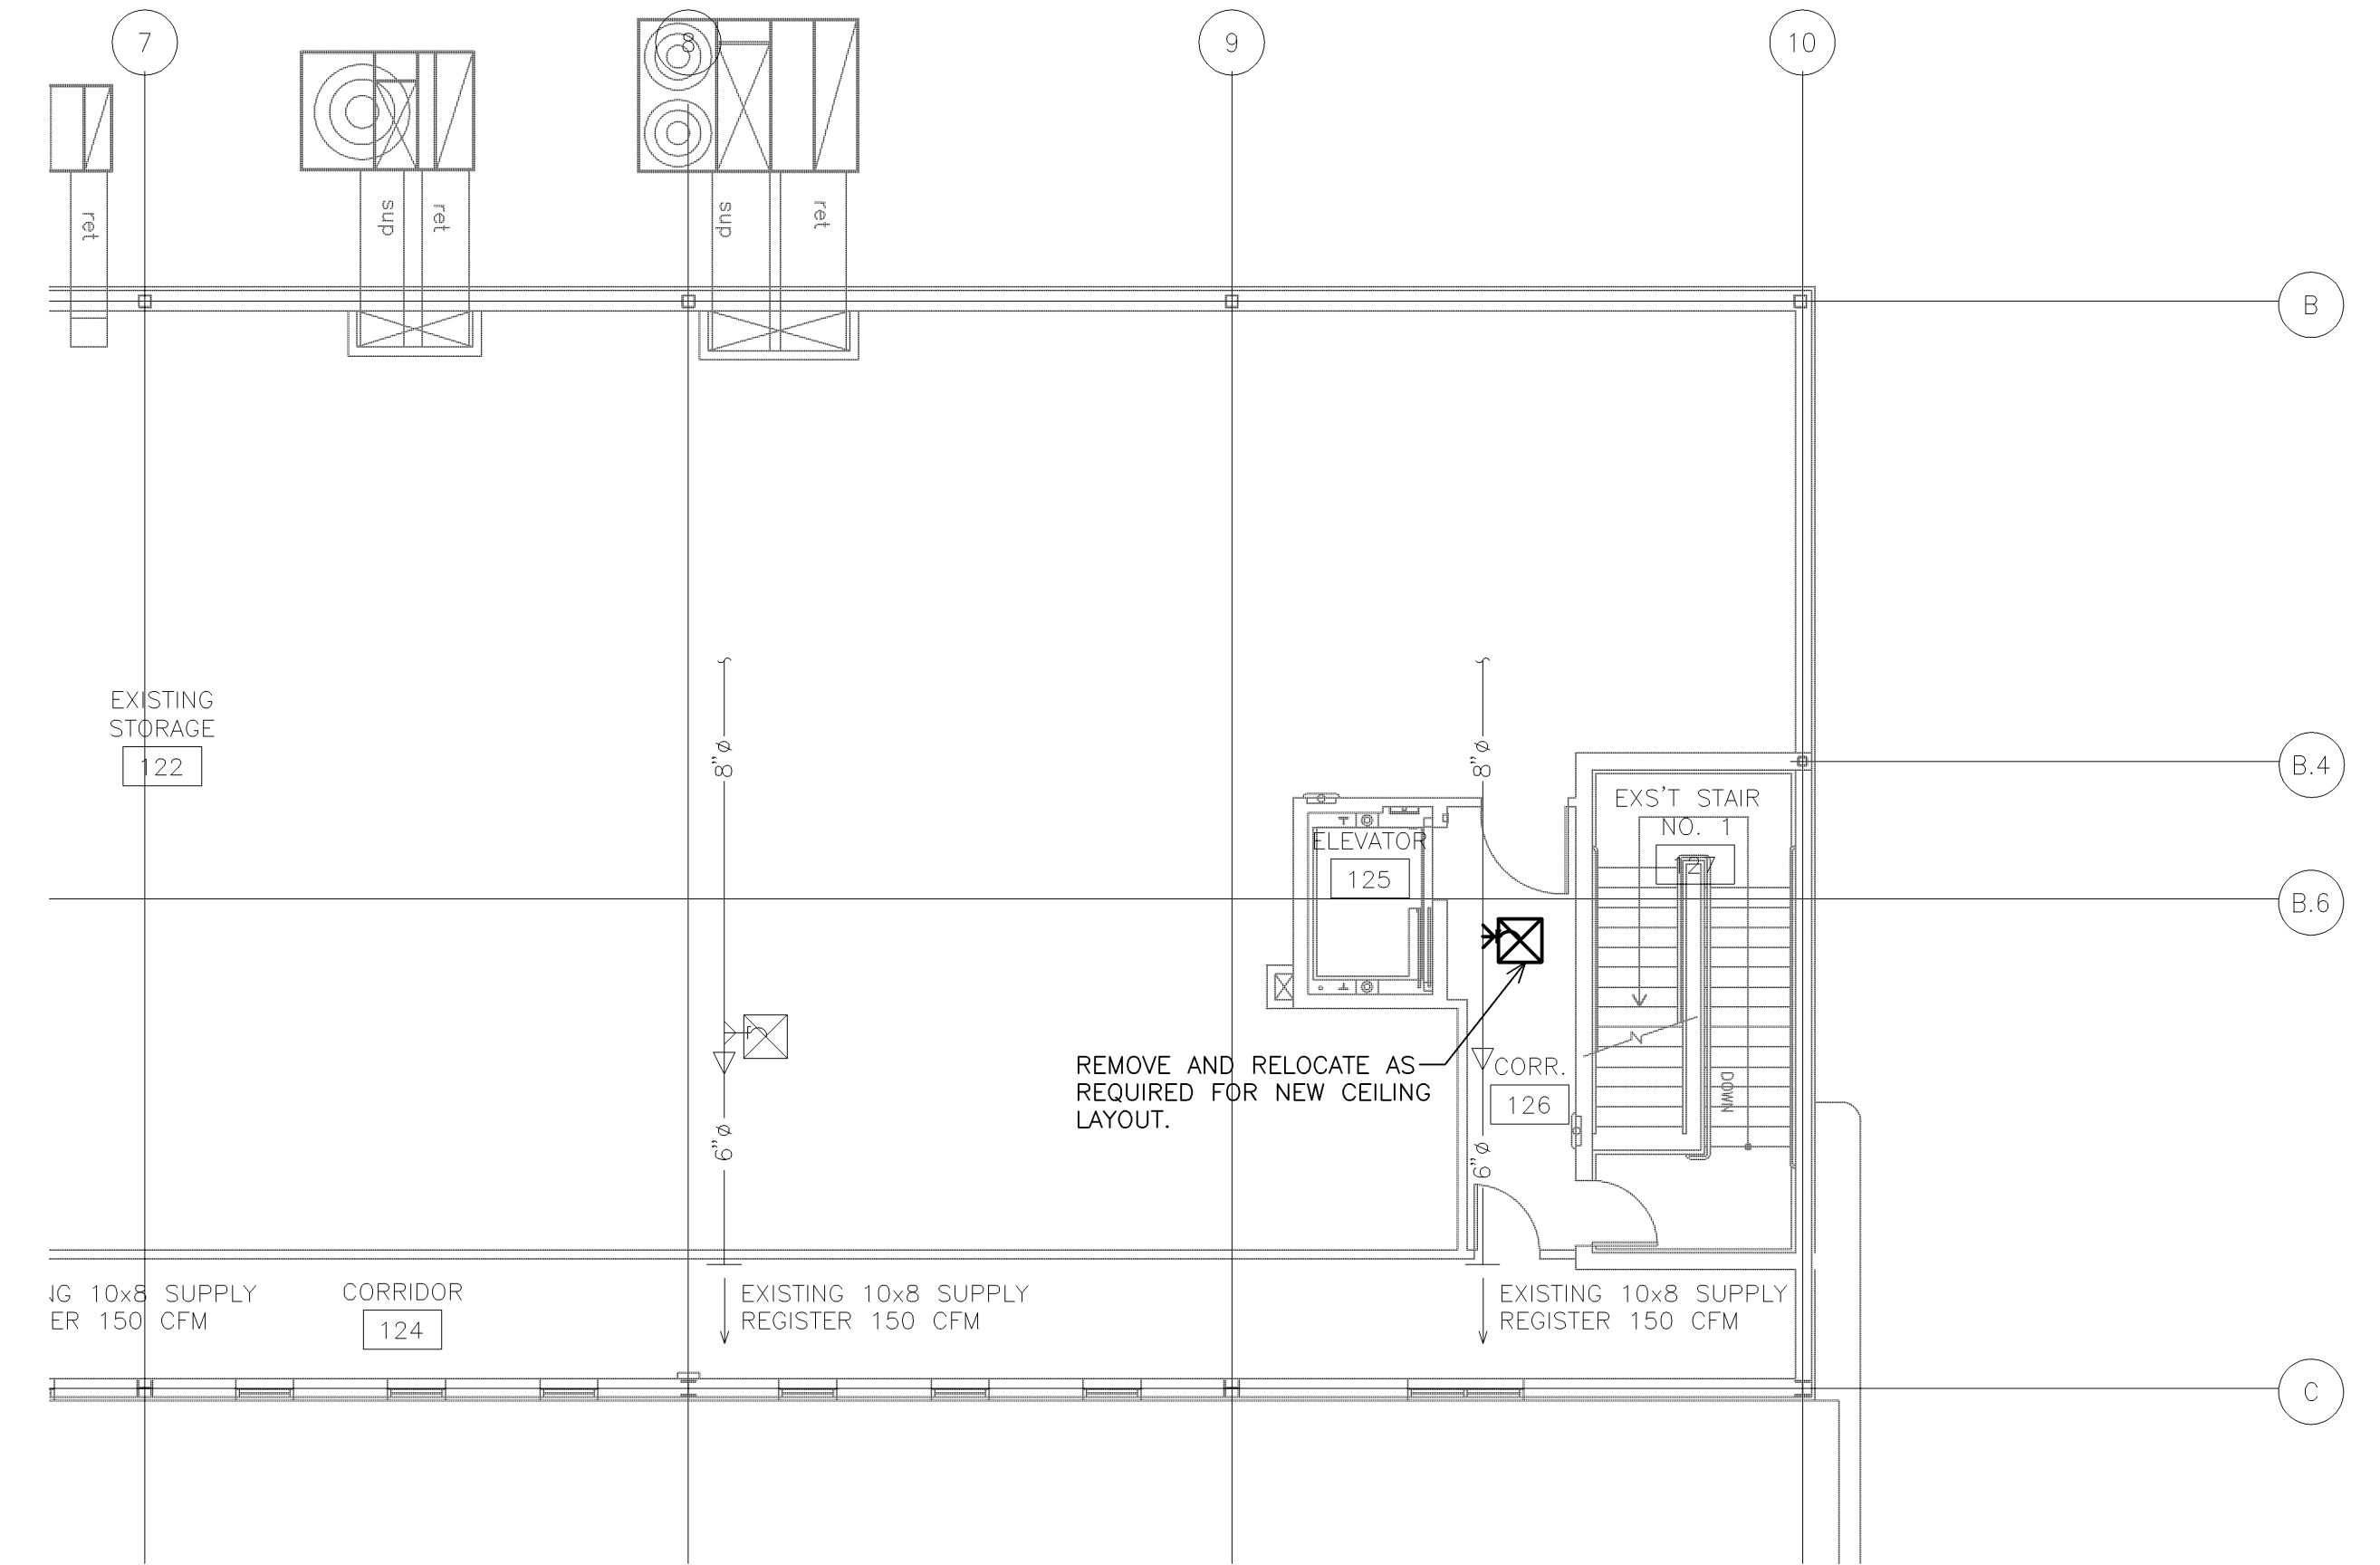

NOTES FOR THIS DRAWING  
◇ INSTALL DUCTWORK BETWEEN TRUSSES.



**SIMPSON ASSOCIATES**  
ARCHITECT  
3280 Edgewood Park Dr.  
Commerce, Michigan 48382  
248-360-7821

**David R. Gebhardt** Architect  
Professional Corporation  
203 W. Michigan Ave. Saline, MI 48176 (734) 429-5193



Dunham Associates, Inc.  
50 South Sixth Street / Suite 1100  
Minneapolis, Minnesota 55402-1540  
PHONE 612.465.7550 FAX 612.465.7551  
WEB dunhameng.com  
mechanical + electrical consulting engineering



**Construction Manager**  
**Frank Baxter General Contractor, Inc.**  
3225 Avenue N  
Fort Madison, IA 52627  
319-372-7285

PROJECT :



EXECUTIVE OFFICE LAYOUT  
191 RIVERSIDE  
PORTLAND, MAINE

DATE:	ISSUED FOR:
11.12.07	90% REVIEW
11.16.07	PERMIT
11.28.07	ADDENDUM #1

SHEET TITLE :  
**LEVEL TWO HVAC PLAN**

SHEET NO. :  
**M201**