


REPRODUCTION OR MISUSE OF THIS DOCUMENT WITHOUT WRITTEN PERMISSION FROM GRANT HAYS ASSOCIATES IS PROHIBITED

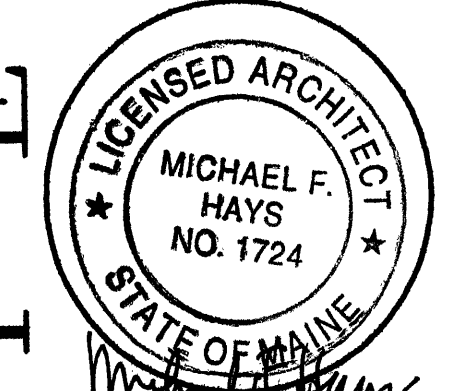


REVISIONS

PHASE II
EVERGREEN CREDIT UNION
 225 RIVERSIDE STREET PORTLAND, MAINE

GRANT HAYS ASSOCIATES ARCHITECTURE
 INTERIOR DESIGN
 P.O. BOX 6179 FALMOUTH, MAINE 04105
 (207) 871-6900

REFLECTED CEILING PLAN
 DRAWING TITLE

SCALE 1/4" = 1'-0"
 DATE 12 NOV. 07
 DRAWN BY SAM/MT
 JOB NO. 070901
 DRAWING NO. **A-3**

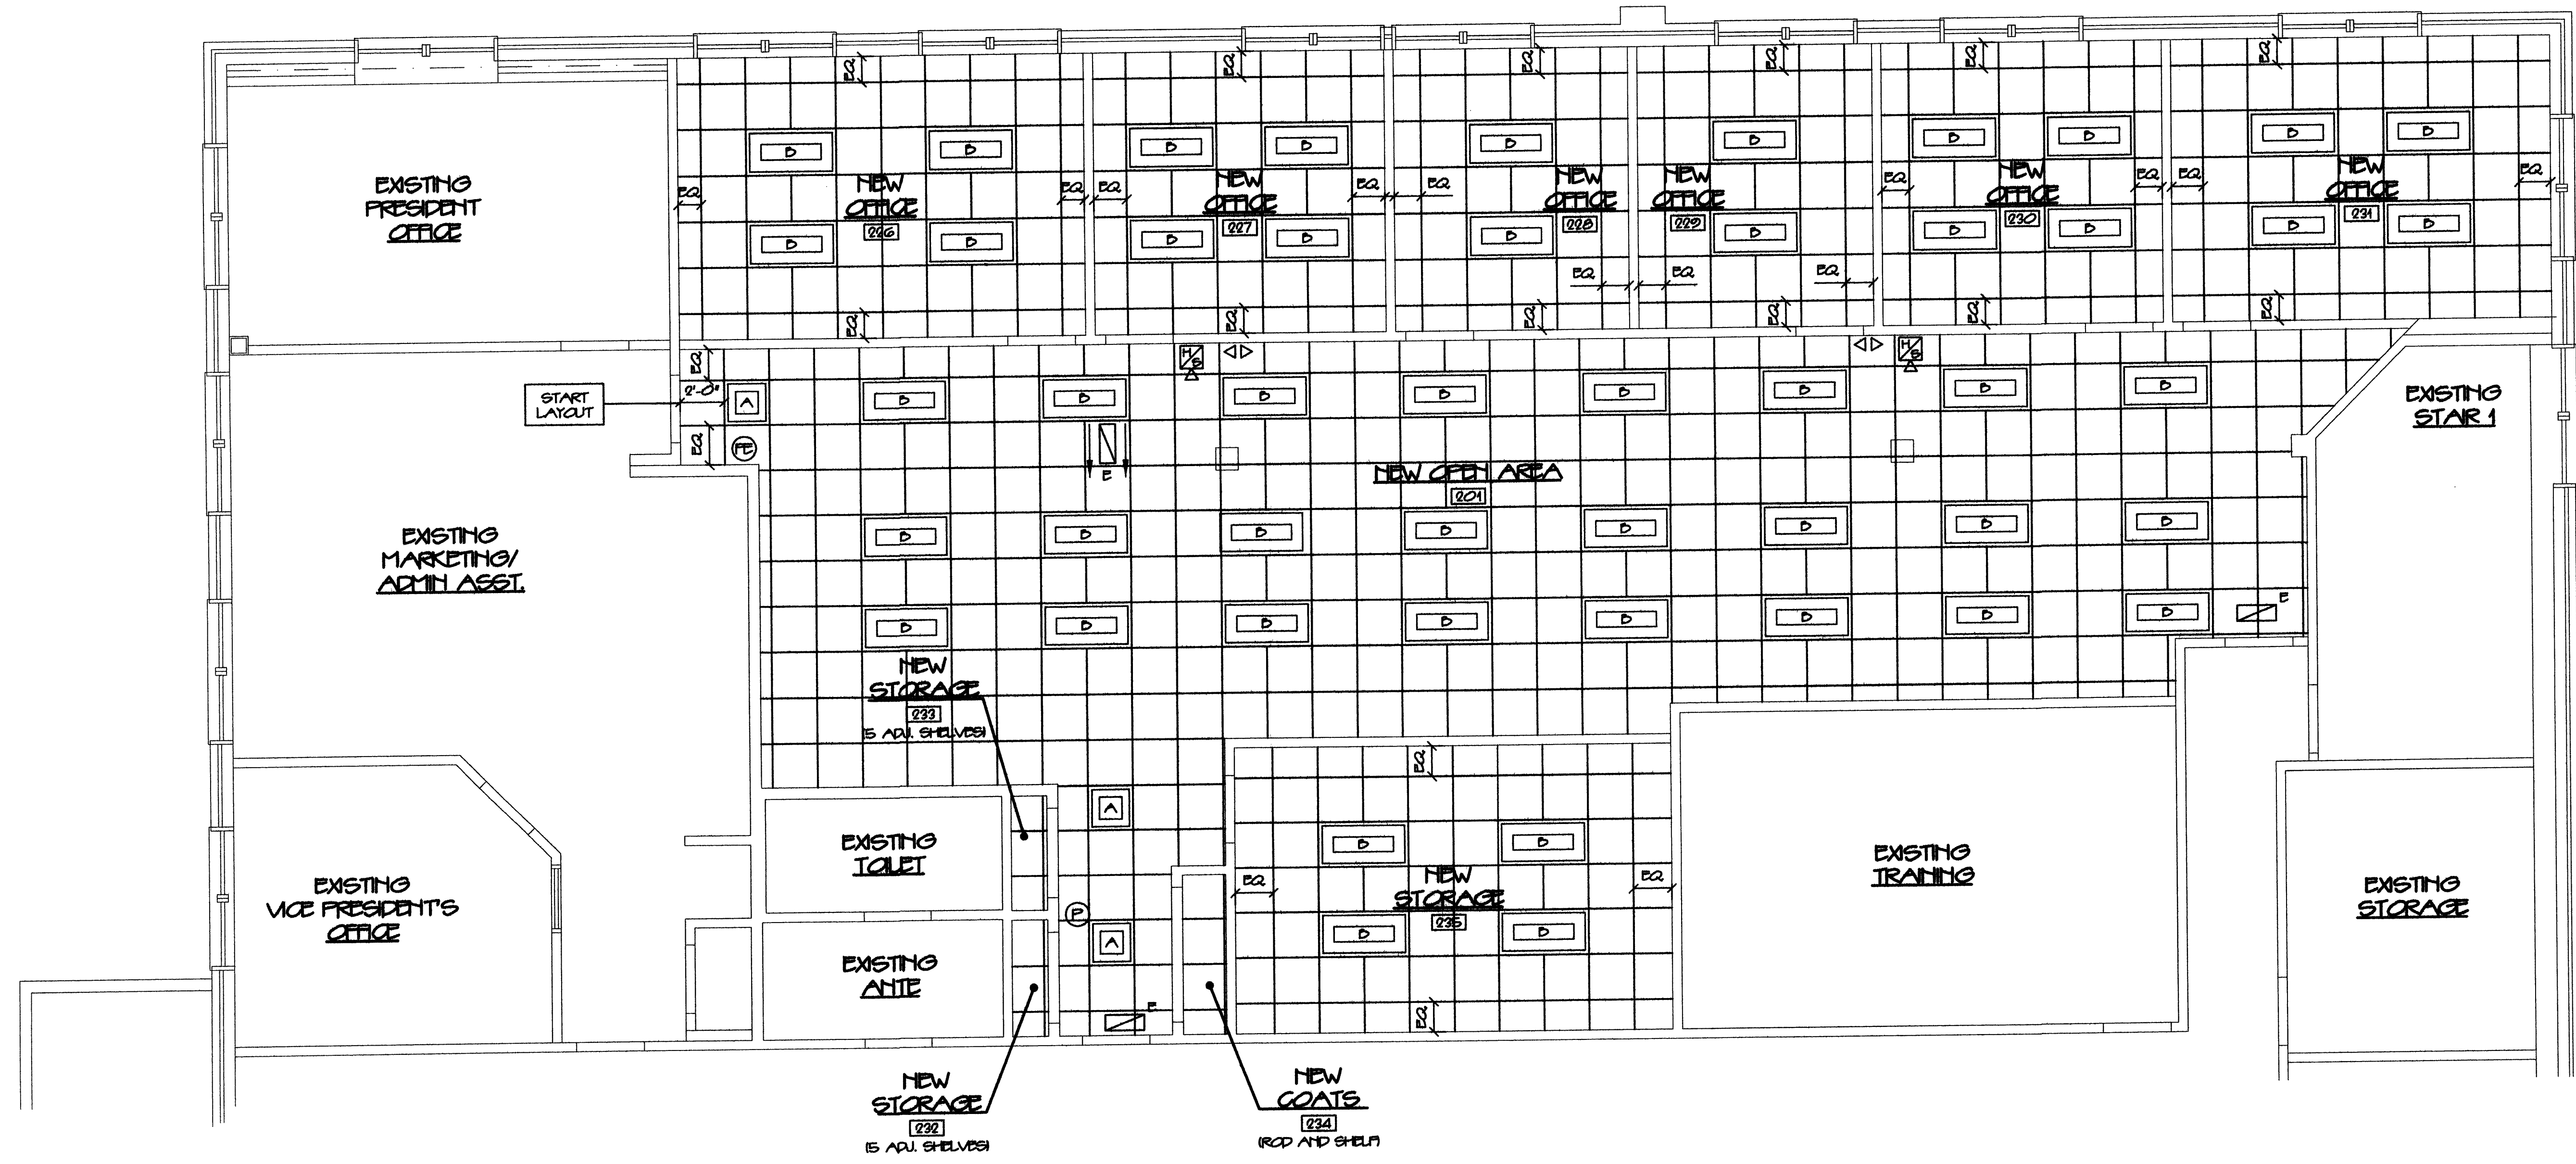

PARTIAL REFLECTED CEILING PLAN
 SCALE 1/4" = 1'-0"

NFPA LEGEND

- FIRE EXTINGUISHER
- FIRE ALARM PULL
- EXIT SIGN/LIGHT
- EMERGENCY LIGHT
- NORTH STROBE UNIT NO. CD/15DD

SYMBOLS

- 2x2 SAT
- 2x2 LAY-IN LIGHT FIXTURE
- 2x4 LAY-IN LIGHT FIXTURE

