


272-B-13

Original permit -08-1503

RECEIVED

MAY 02 2008

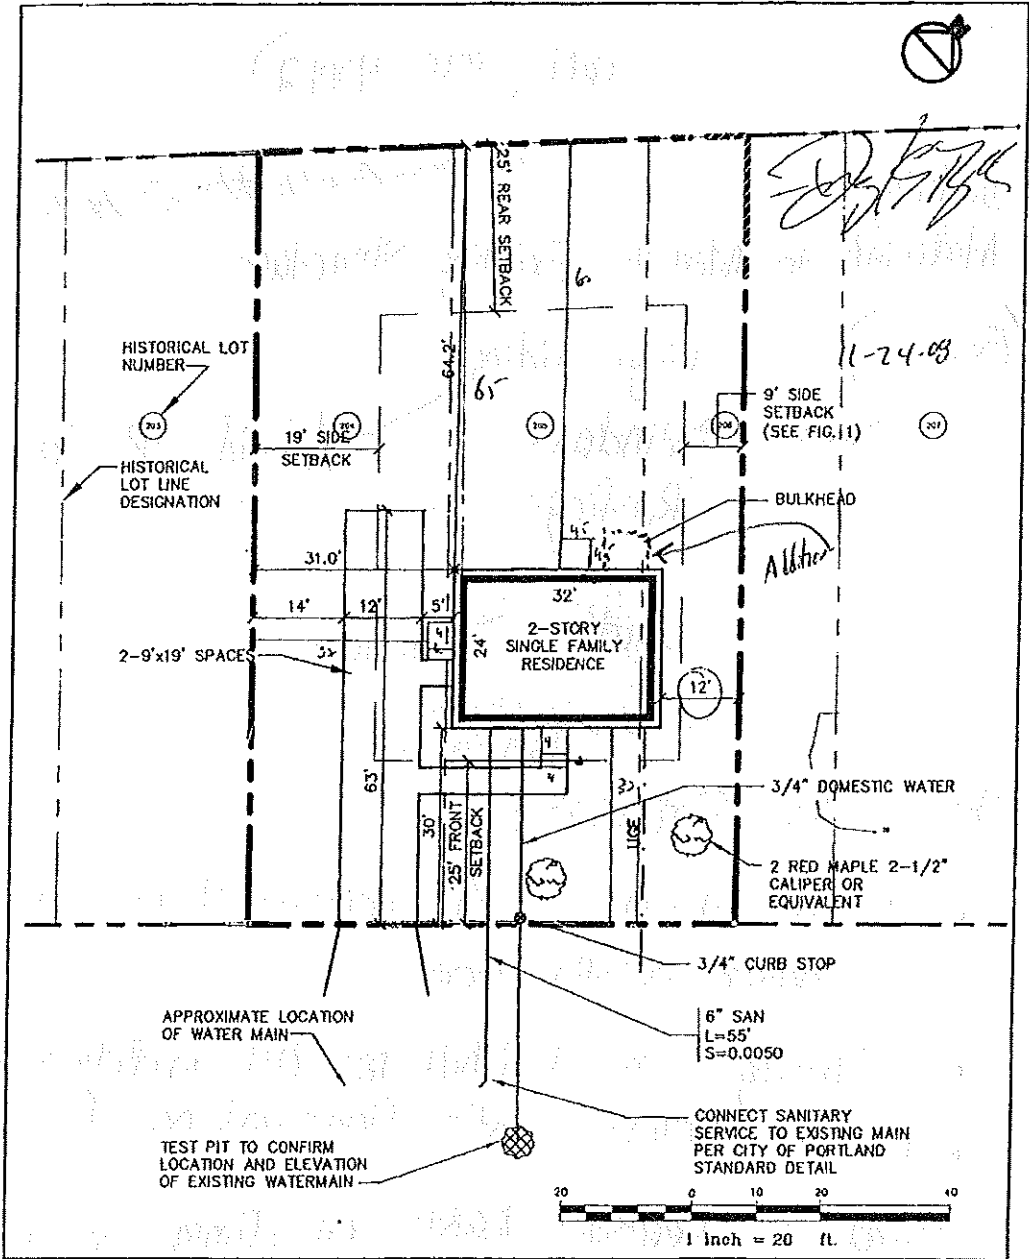

Design: DER	Date: 3/06
Draft: CAH	Job No: 1543
Checked: DER	Scale: 1"=20'
File Name: 1543-PRASE_02	

GP Gerrill-Palmer Consulting Engineers, Inc.
 Traffic and Civil Engineering Services
 PO Box 1237
 15 State Road
 Scarborough, ME 04109
 Phone: 207-837-8800
 Fax: 207-837-8812
 Email: mpr@sagegripalmer.com

Drawing Name:	Layout & Utility Plan
Project:	HOLM AVENUE Portland, ME

Figure No.	2
------------	---