


PROJECT DATA



USE			
OCCUPANCY CLASSIFICATION		BUSINESS	
OCCUPANCY CALCULATION			
GROSS S.F. AREA	1,755 S.F.	1,755/100	17.5
CALCULATED OCCUPANT LOAD BASED ON GROSS SQUARE FOOTAGE:			17.5
EXITS AND EXIT ACCESS DOORWAYS			
	REQUIRED	PROVIDED	
EXITS	1	2	
DOOR WIDTH	32" MINIMUM	60" & 36"	
COMMON PATH OF TRAVEL	75'-0"	0'-0"	
EXIT ACCESS TRAVEL DISTANCE (W/O SPRINKLERS)	200'-0" (NFPA)	56'-0"	
DEAD END CORRIDORS	20'-0"	NA	
EGRESS WIDTH:			
OCCUPANTS x (0.2 - OTHER EGRESS COMPONENTS)			
18 x 0.2' = 3.6" WIDTH REQUIRED	3.6"	36"	
PLUMBING FIXTURES			
WATER CLOSETS - MEN/WOMEN	1	1	
LAVATORIES - MEN/WOMEN	1	1	

3 NTS BUILDING CODE INFORMATION

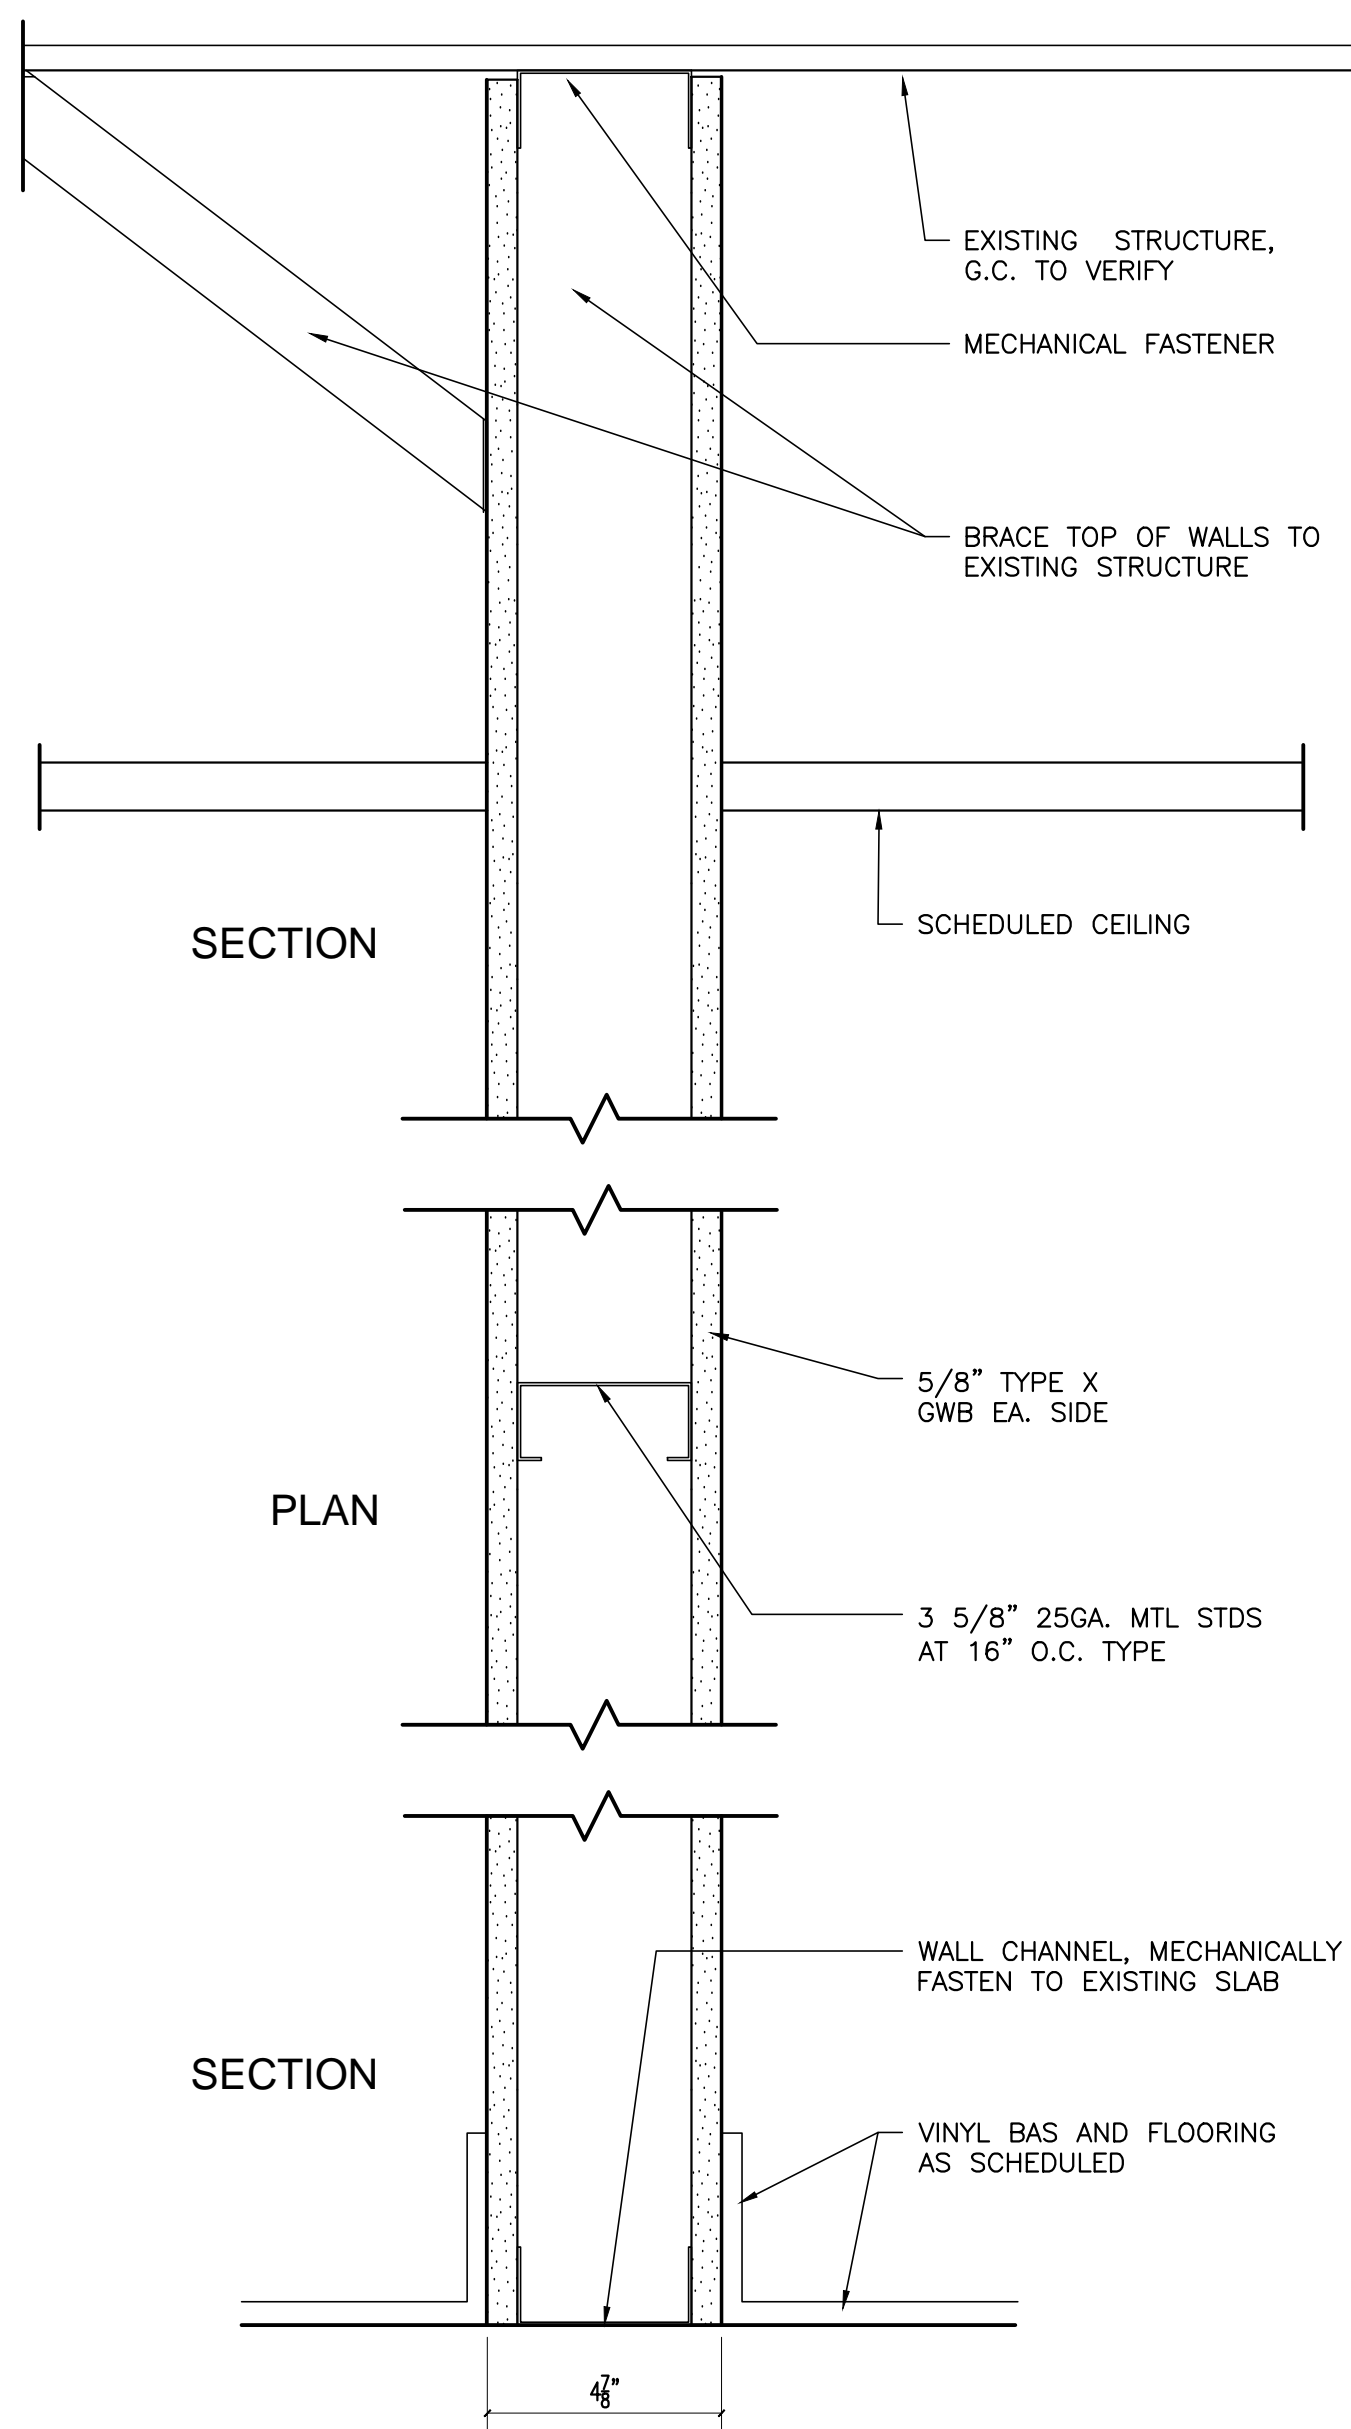

LIFE SAFETY SYMBOLS LEGEND

	DIRECTIONAL EXIT LIGHT
	AUTOMATIC EMERGENCY LIGHT
	FIRE EXTINGUISHER - WALL MOUNTED

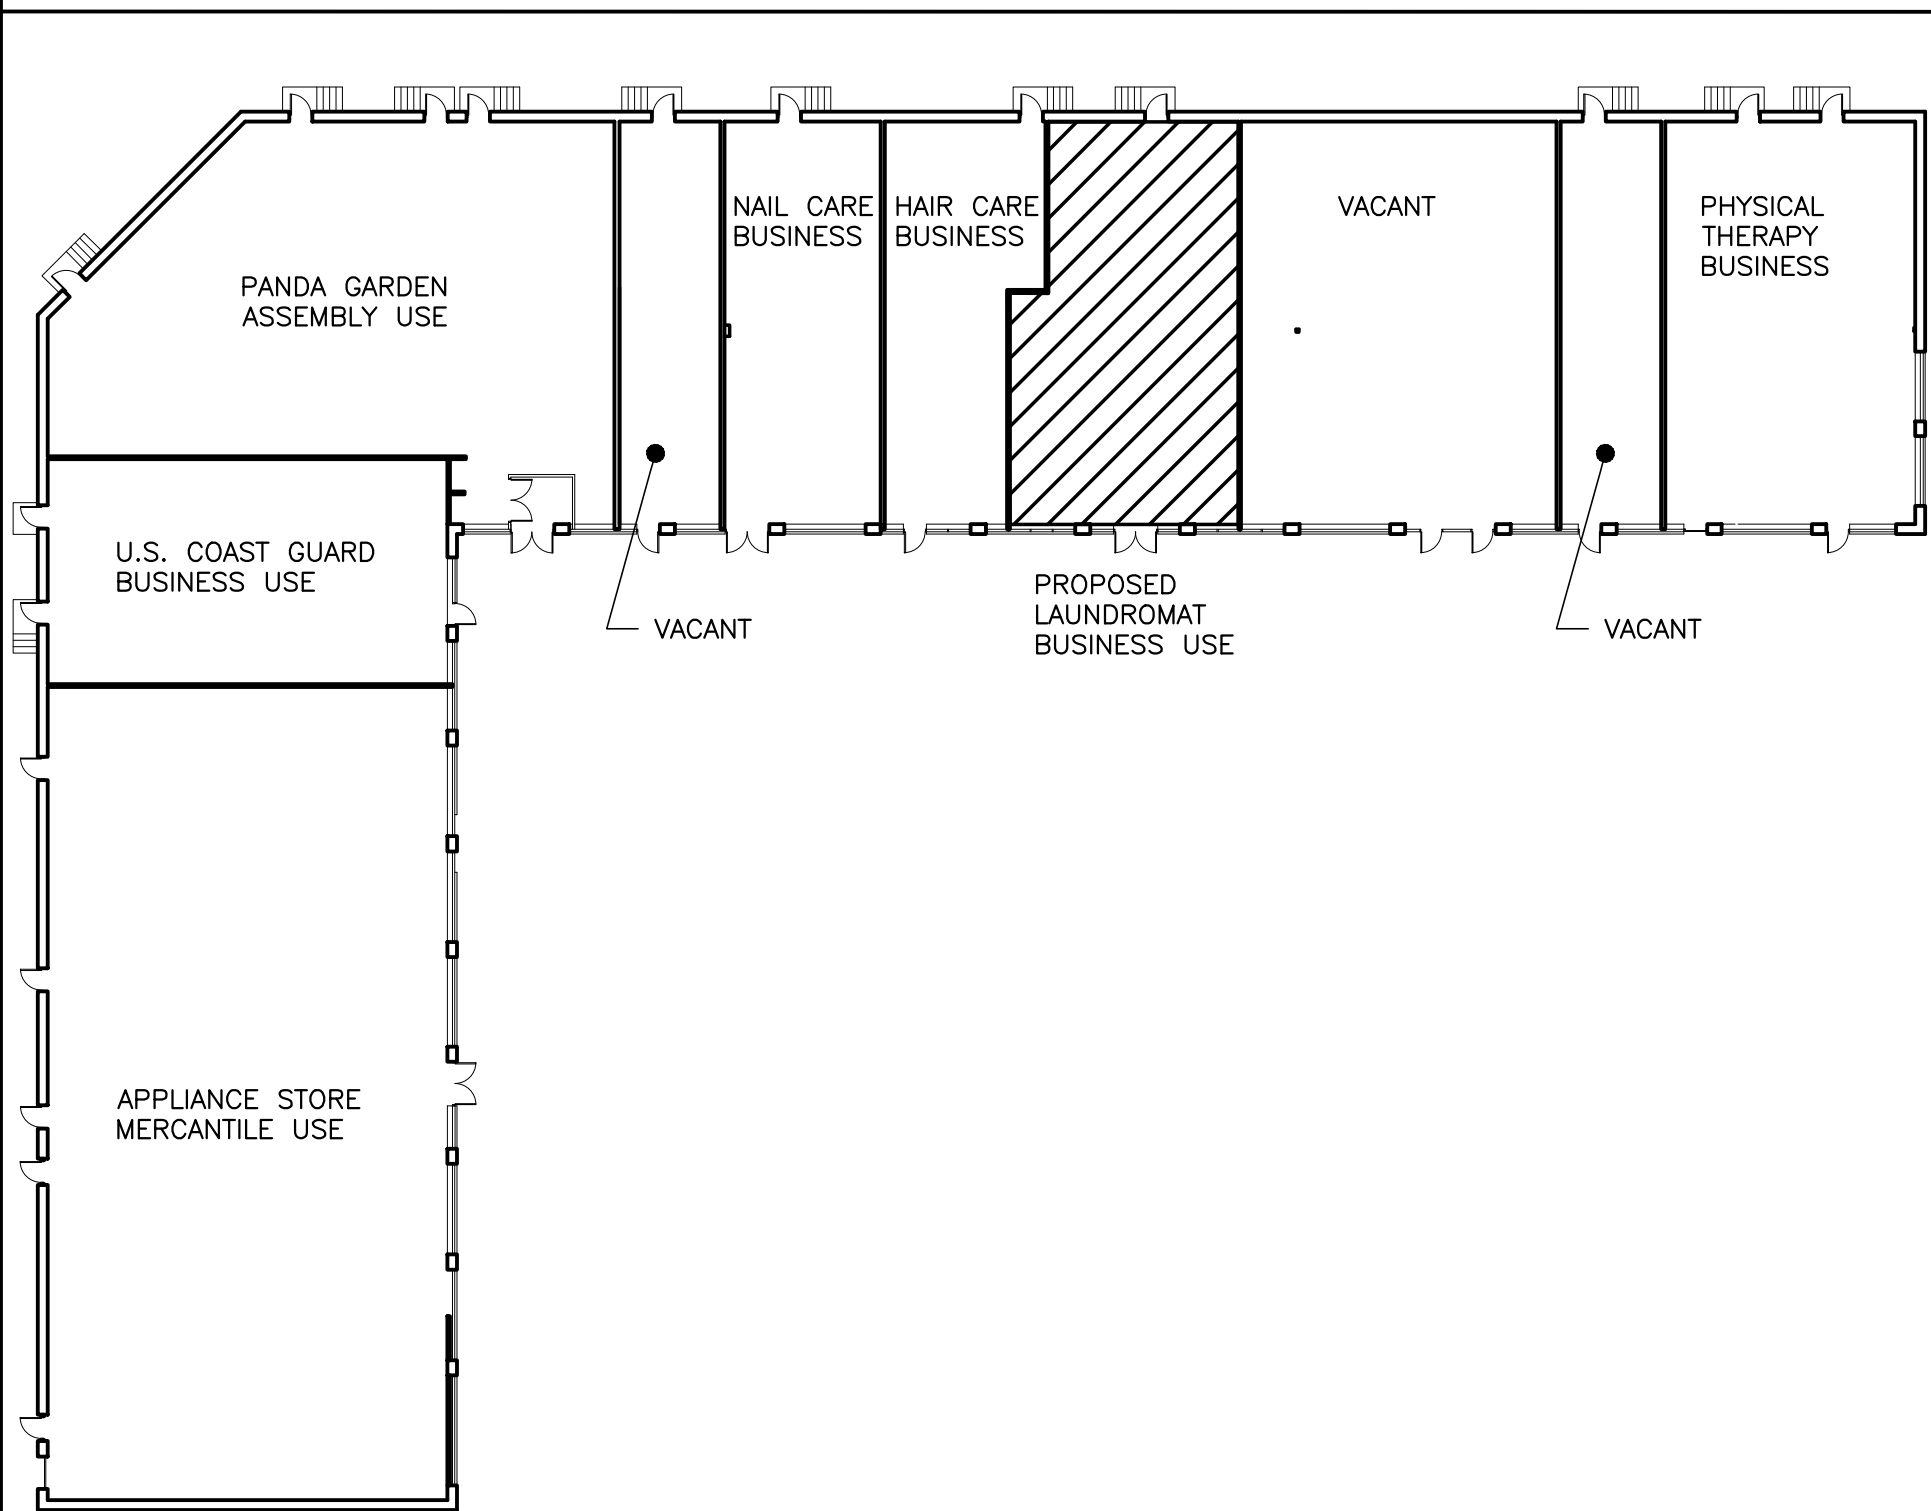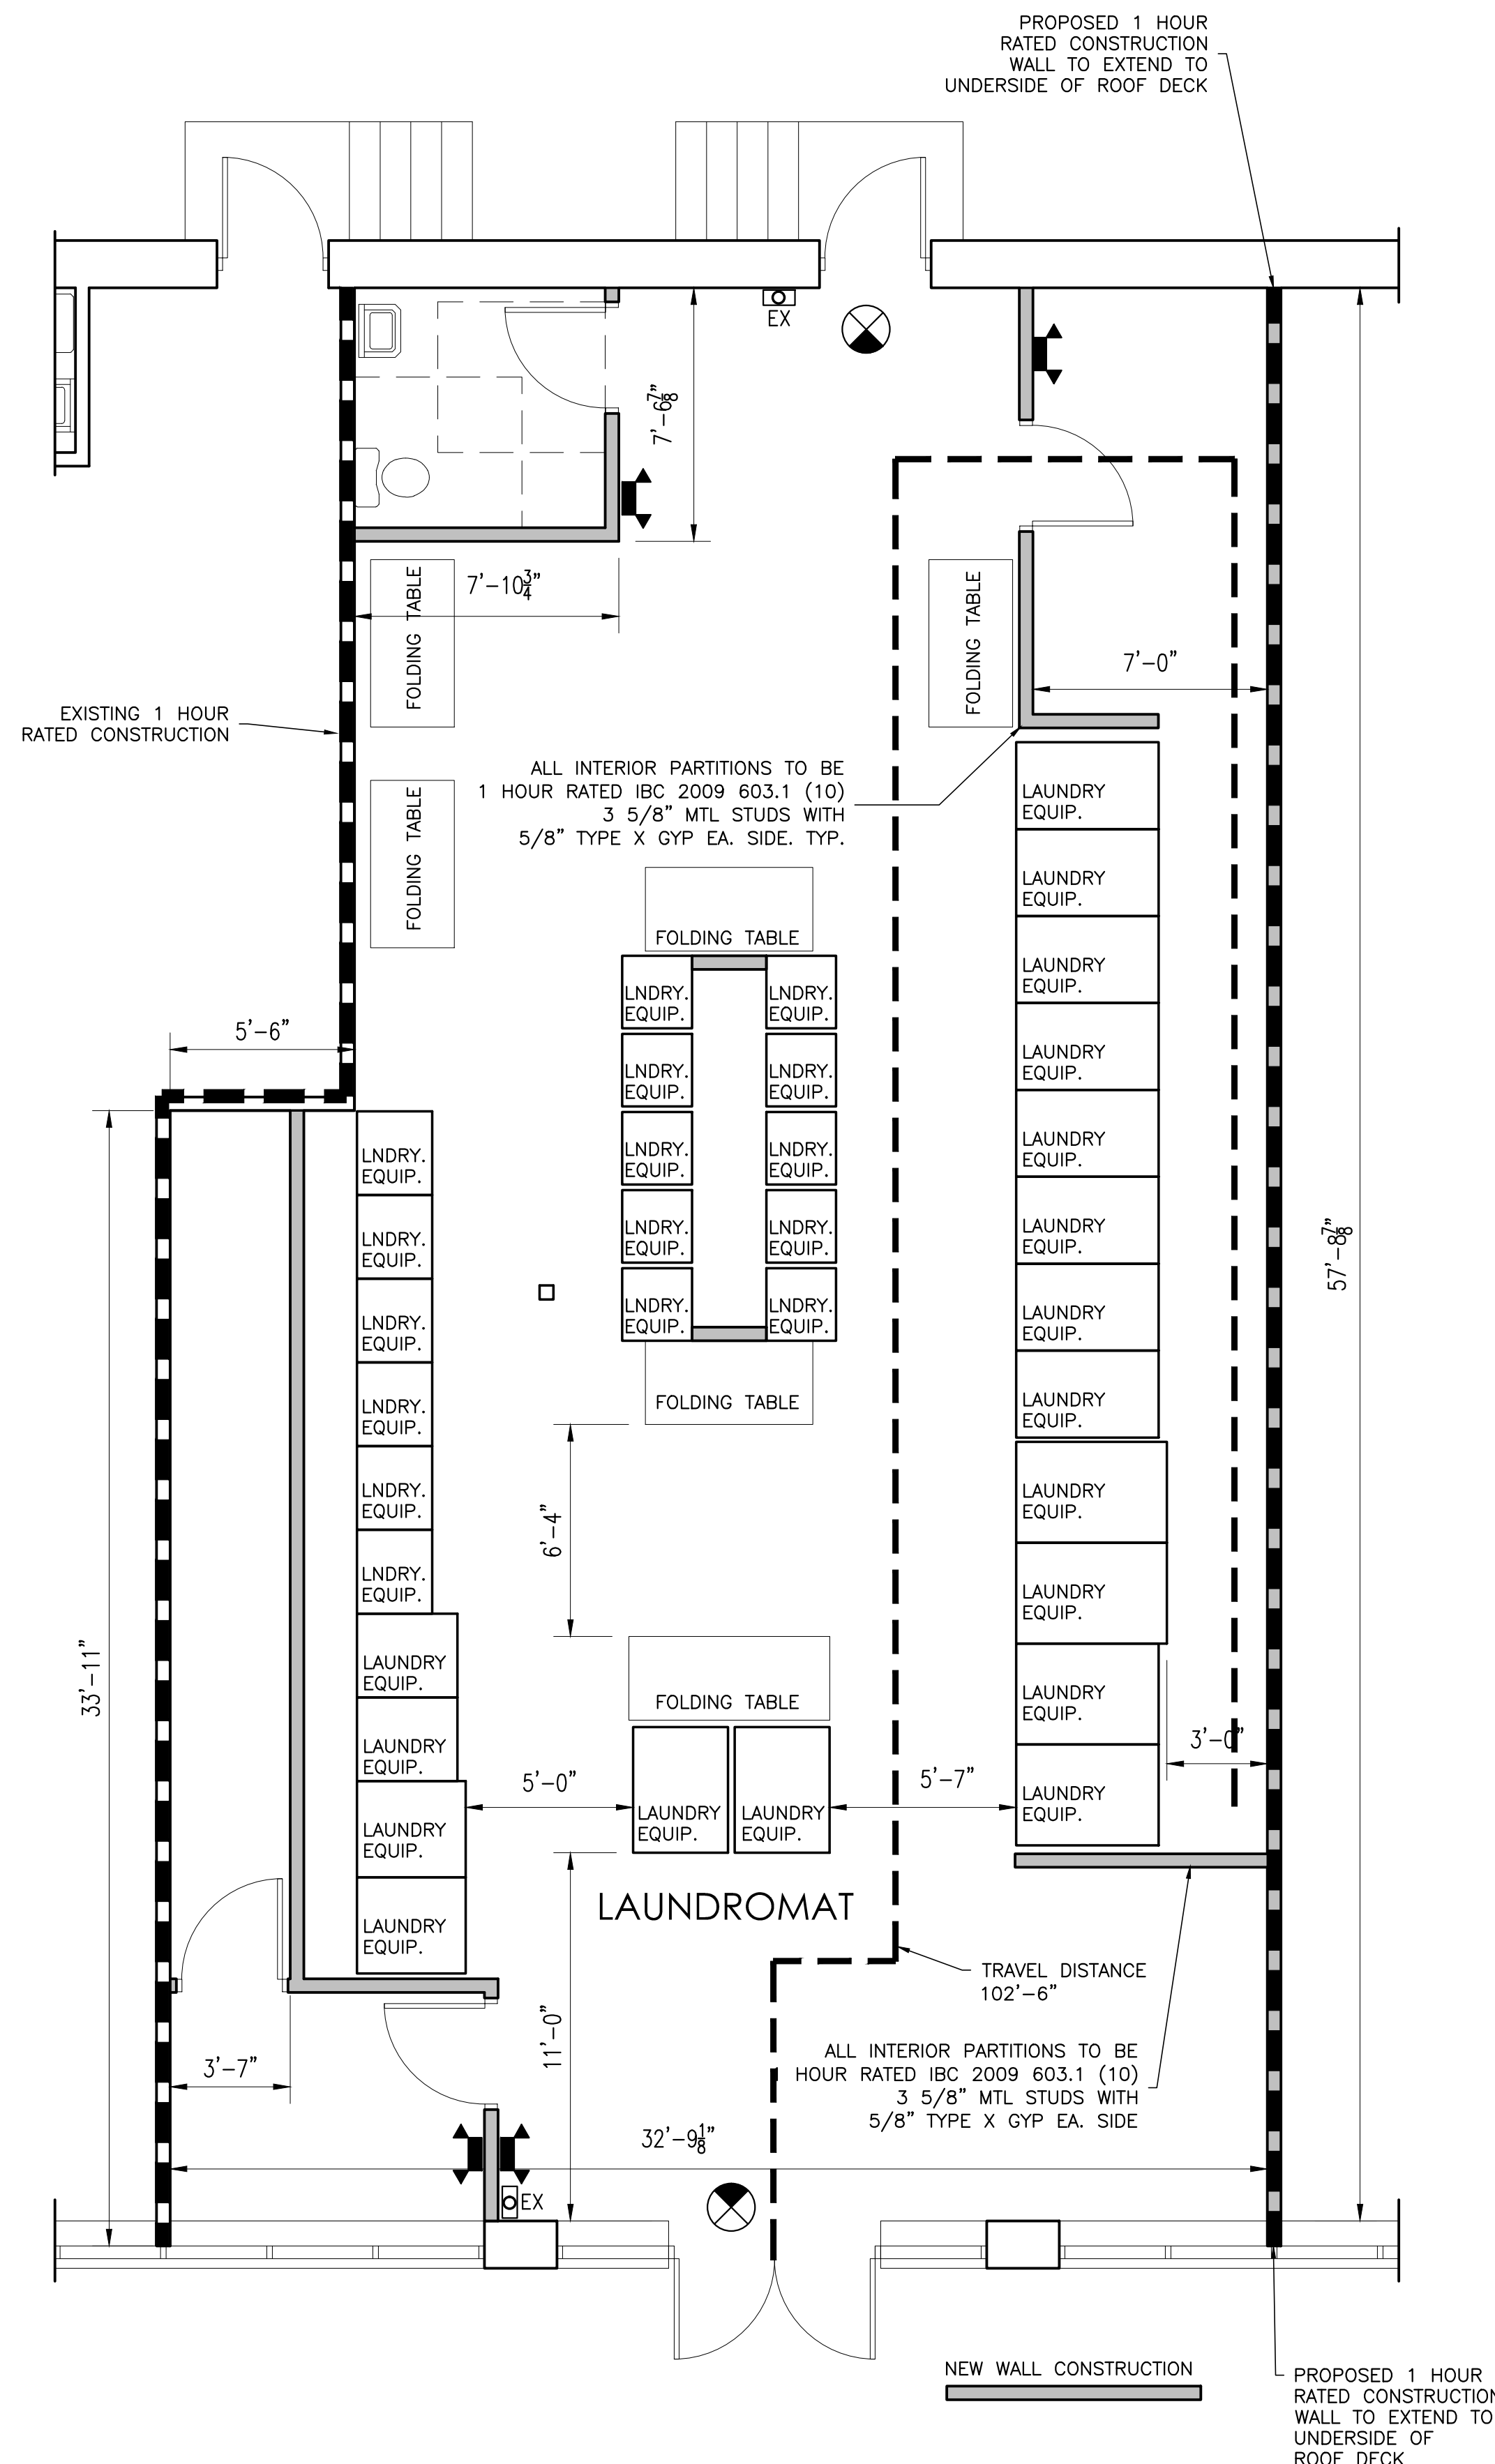

4 NTS BUILDING KEY PLAN AND OCCUPANCY

2 3"=1'-0" TYPICAL 1 HOUR RATED WALL

1 1/4"=1'-0" LIFE SAFETY AND EGRESS DIAGRAM

DO NOT SCALE DRAWINGS

GENERAL CONTRACTOR

STRUCTURAL ENGINEER

MEP ENGINEER

CLIENT

PROJECT
Laundromat

1041 Brighton Ave
 Portland, ME 04101



ISSUED FOR PERMIT

INFORMATION

Path: M:/boulos/1041 Brighton

Issue Date: 05/29/14

Drawn By: dijg

Checked By:

Revision:

- 1.
- 2.
- 3.
- 4.

TITLE

LIFE SAFETY

SCALE

1/4"=1'-0"

© 2014 Graham Architects. All rights reserved. Information, material, and designs in this document are proprietary to and owned by Graham Architects and may not be disclosed to any third party, reproduced, posted on a global computer information network, or distributed in any way without the written consent from Graham Architects.