

MATCHLINE SEE SHEET AE 703 FOR CONTINUATION

MATCHLINE SEE SHEET AE 703 FOR CONTINUATION

MATCHLINE SEE SHEET AE 703 FOR CONTINUATION

MATCHLINE SEE SHEET AE 703 FOR CONTINUATION


2 SECOND FLOOR RCP MECH
AE201 AE704/ SCALE: 1/8" = 1'-0"

1 SECOND FLOOR REFLECTED CEILING PLAN
AE201 AE704/ SCALE: 1/8" = 1'-0"

RCP LEGEND: (THIS SHEET ONLY)

- 2x2 ACT
- 2x4 ACT
- GYP BD
- MECH DIFFUSERS
- GRID-MOUNTED LIGHTING FIXTURES
- HANGING LIGHTING FIXTURE
- SPEAKER

GRAPHIC SCALE

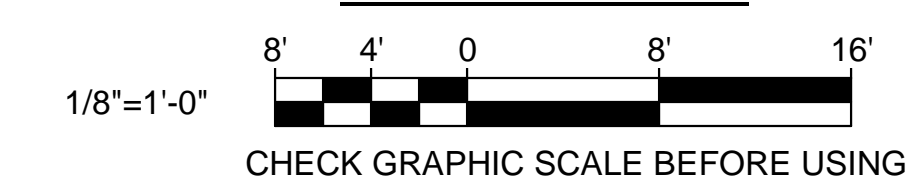

		STATE OF MAINE PUBLIC SCHOOL PROJECT TITLE: PORTLAND PUBLIC SCHOOLS NEW FRED P. HALL ELEMENTARY SCHOOL LOCATION: 23 ORONO ROAD, PORTLAND, ME TITLE THIS DWG.: SECOND FLOOR REFLECTED CEILING PLAN	
		DRAWN BY: DEN CHECK BY: TGB	OAK POINT ASSOCIATES ARCHITECTS 231 Main Street, Biddeford, Maine 04005 207.283.9192
NO. DATE	DESCRIPTION	BY	DATE
	REVISIONS		03/17/17