




1 KITCHEN SINK & DISHWASHER DETAIL
P-501 SCALE: N.T.S.

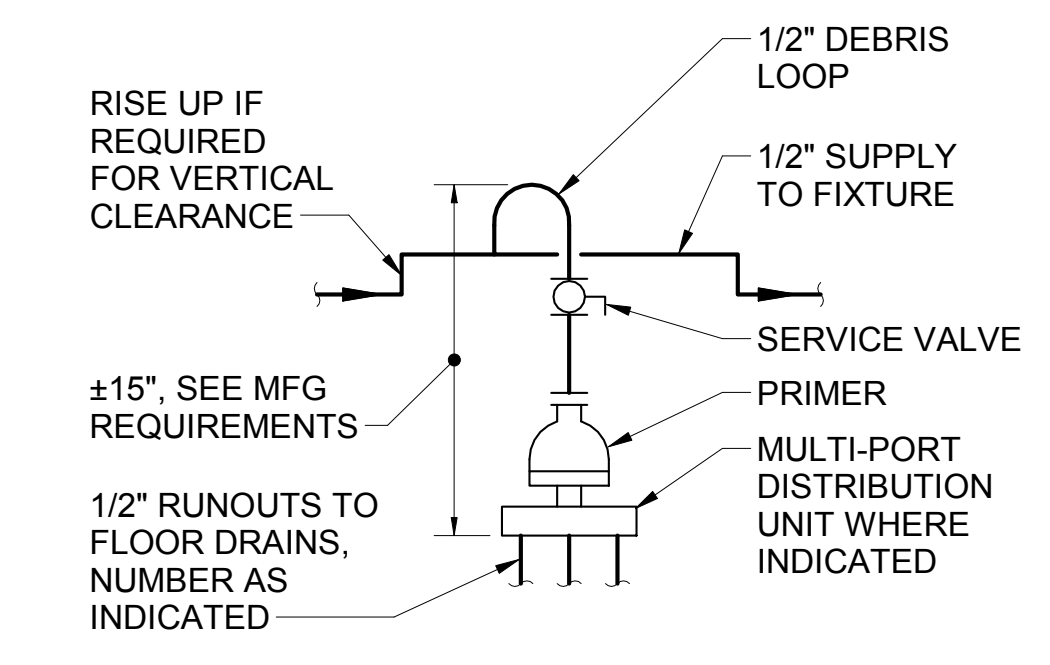


2 TRAP PRIMER VALVE DETAIL
P-501 SCALE: N.T.S.

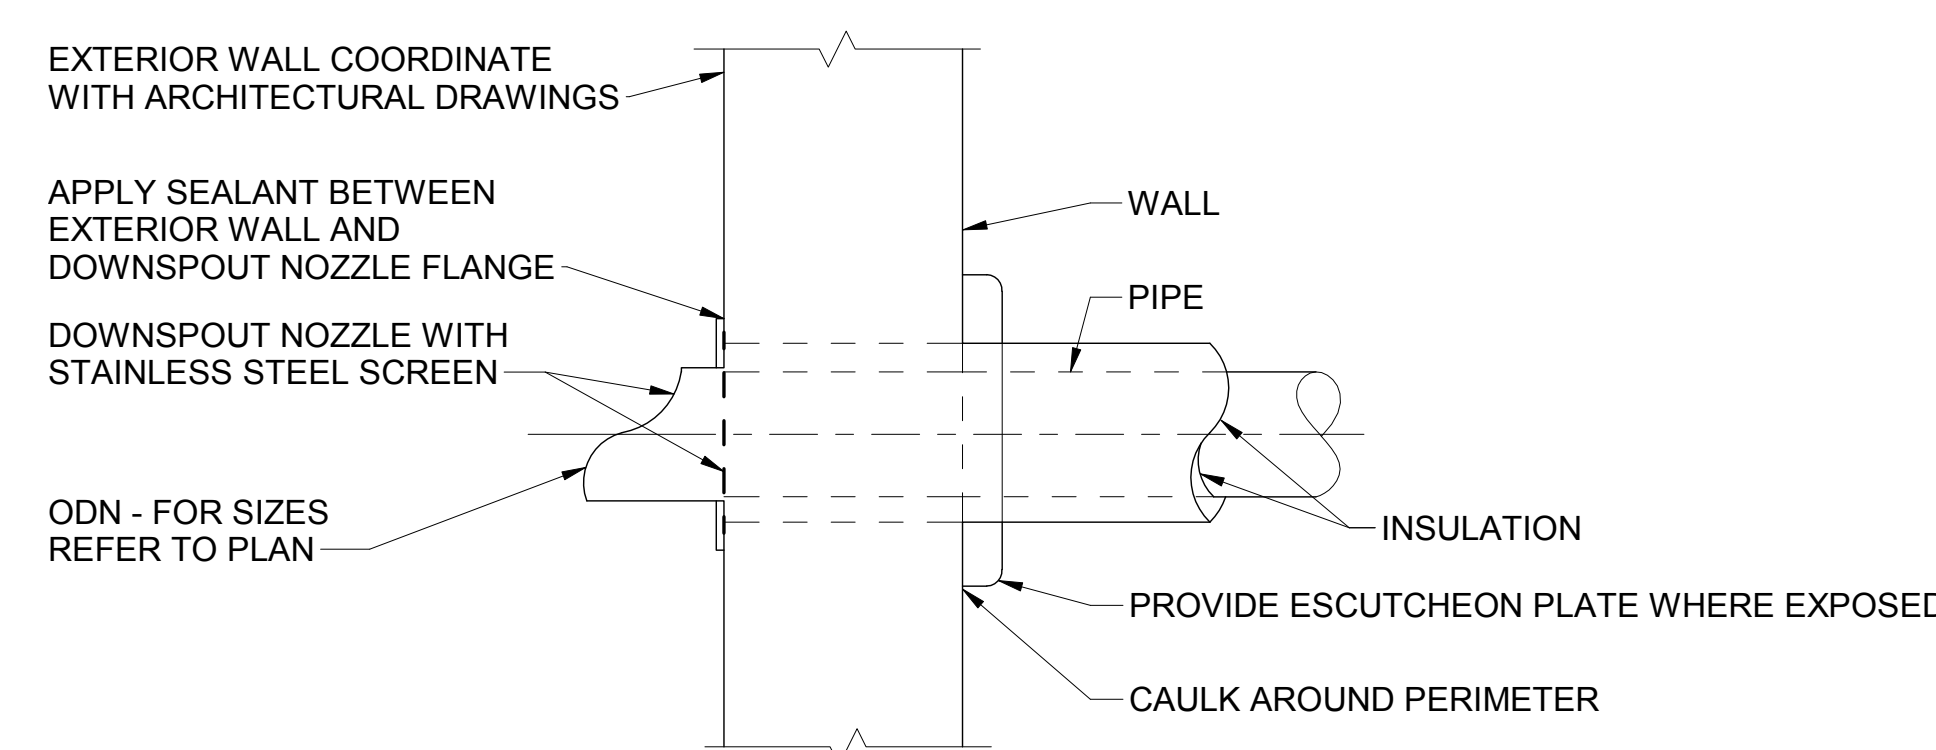


3 THRU WALL OVERFLOW DRAIN DETAIL
P-106, P-105, P-104 P-501 SCALE: N.T.S.

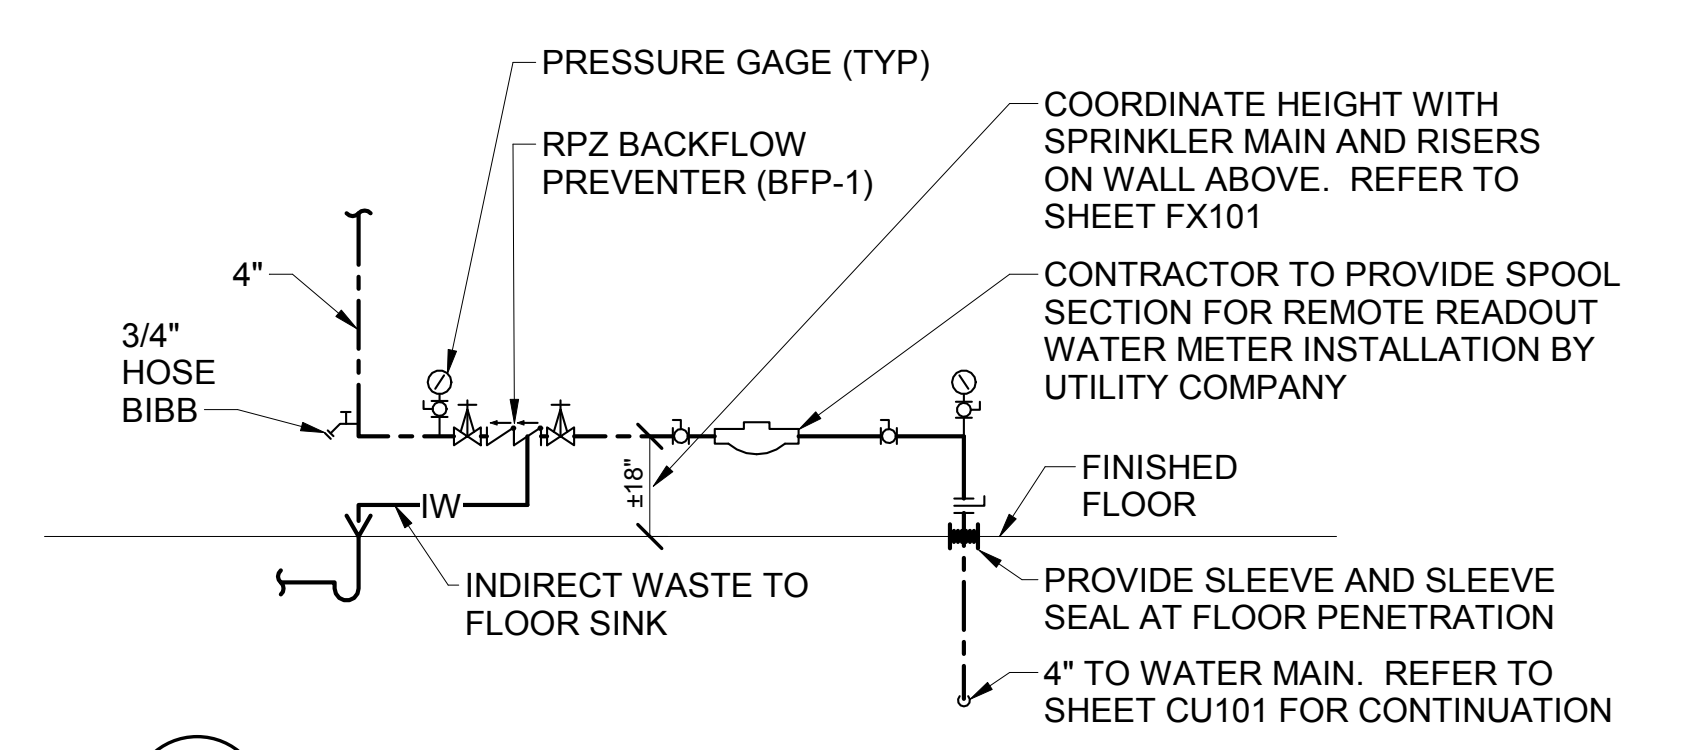


4 WATER SUPPLY ENTRANCE DETAIL
P-501 SCALE: N.T.S.

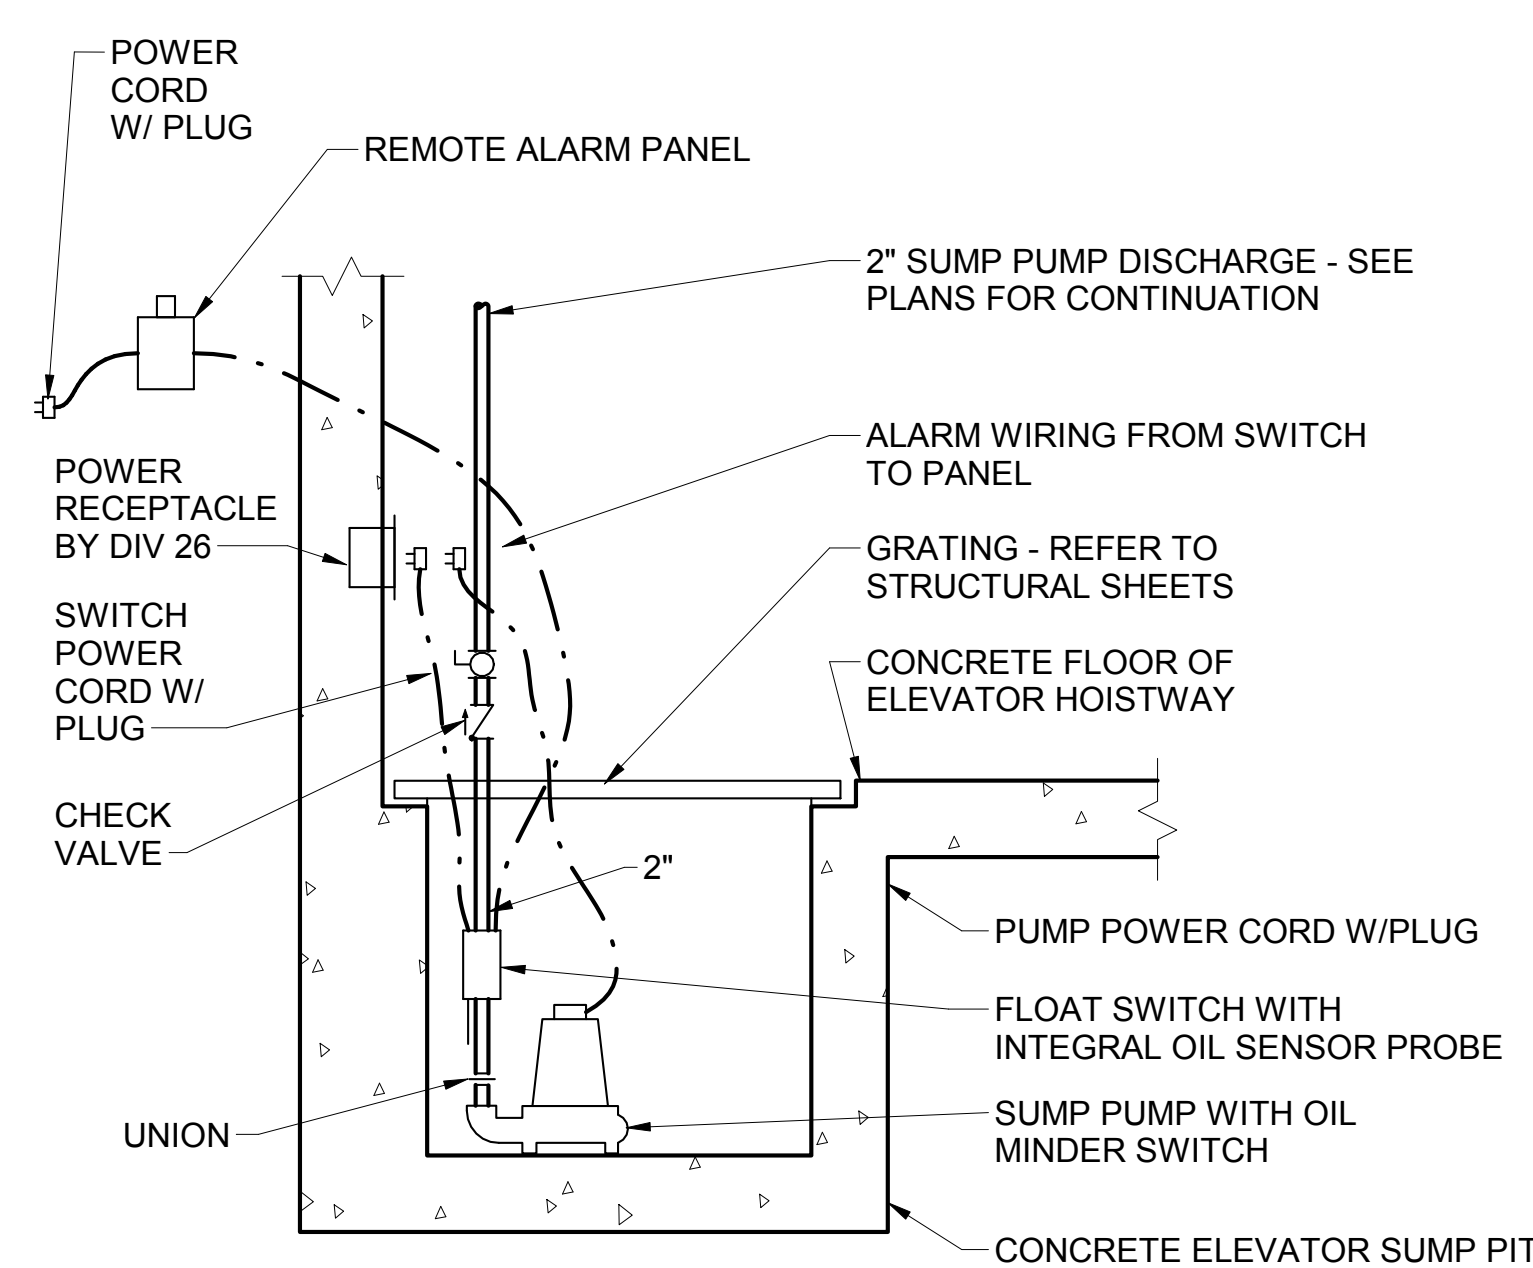


5 SUMP PUMP DETAIL
P-501 SCALE: N.T.S.

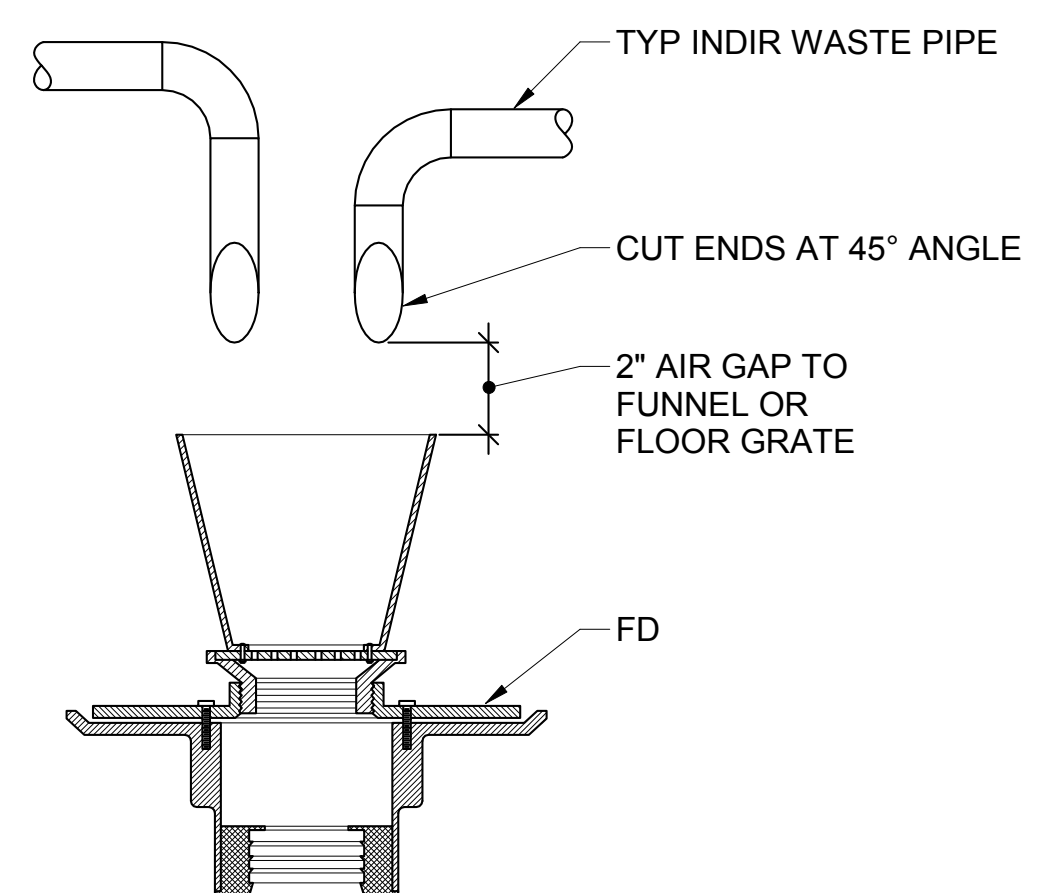


6 INDIRECT WASTE PIPING
P-501 SCALE: N.T.S.

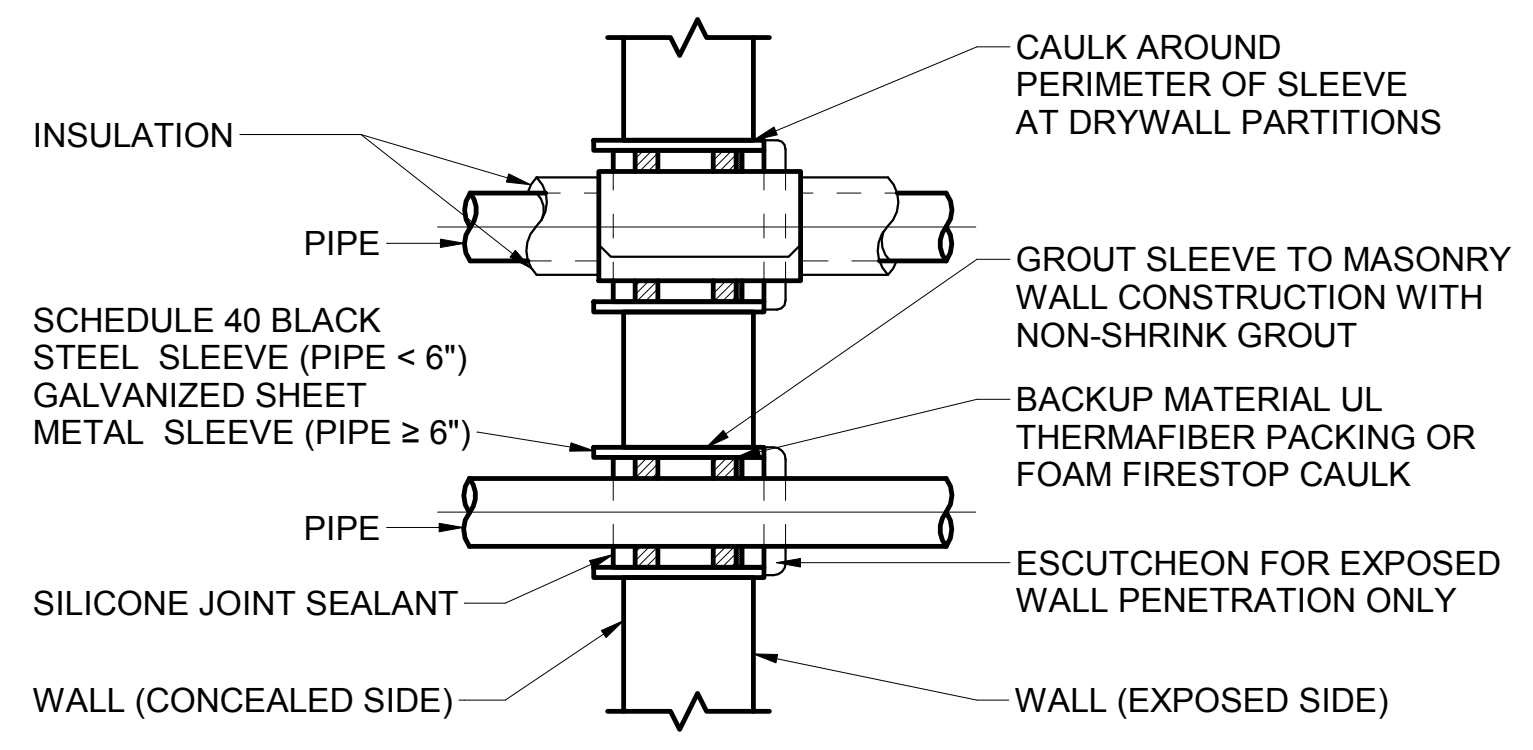


7 PIPE SLEEVE THROUGH WALL
P-501 SCALE: N.T.S.

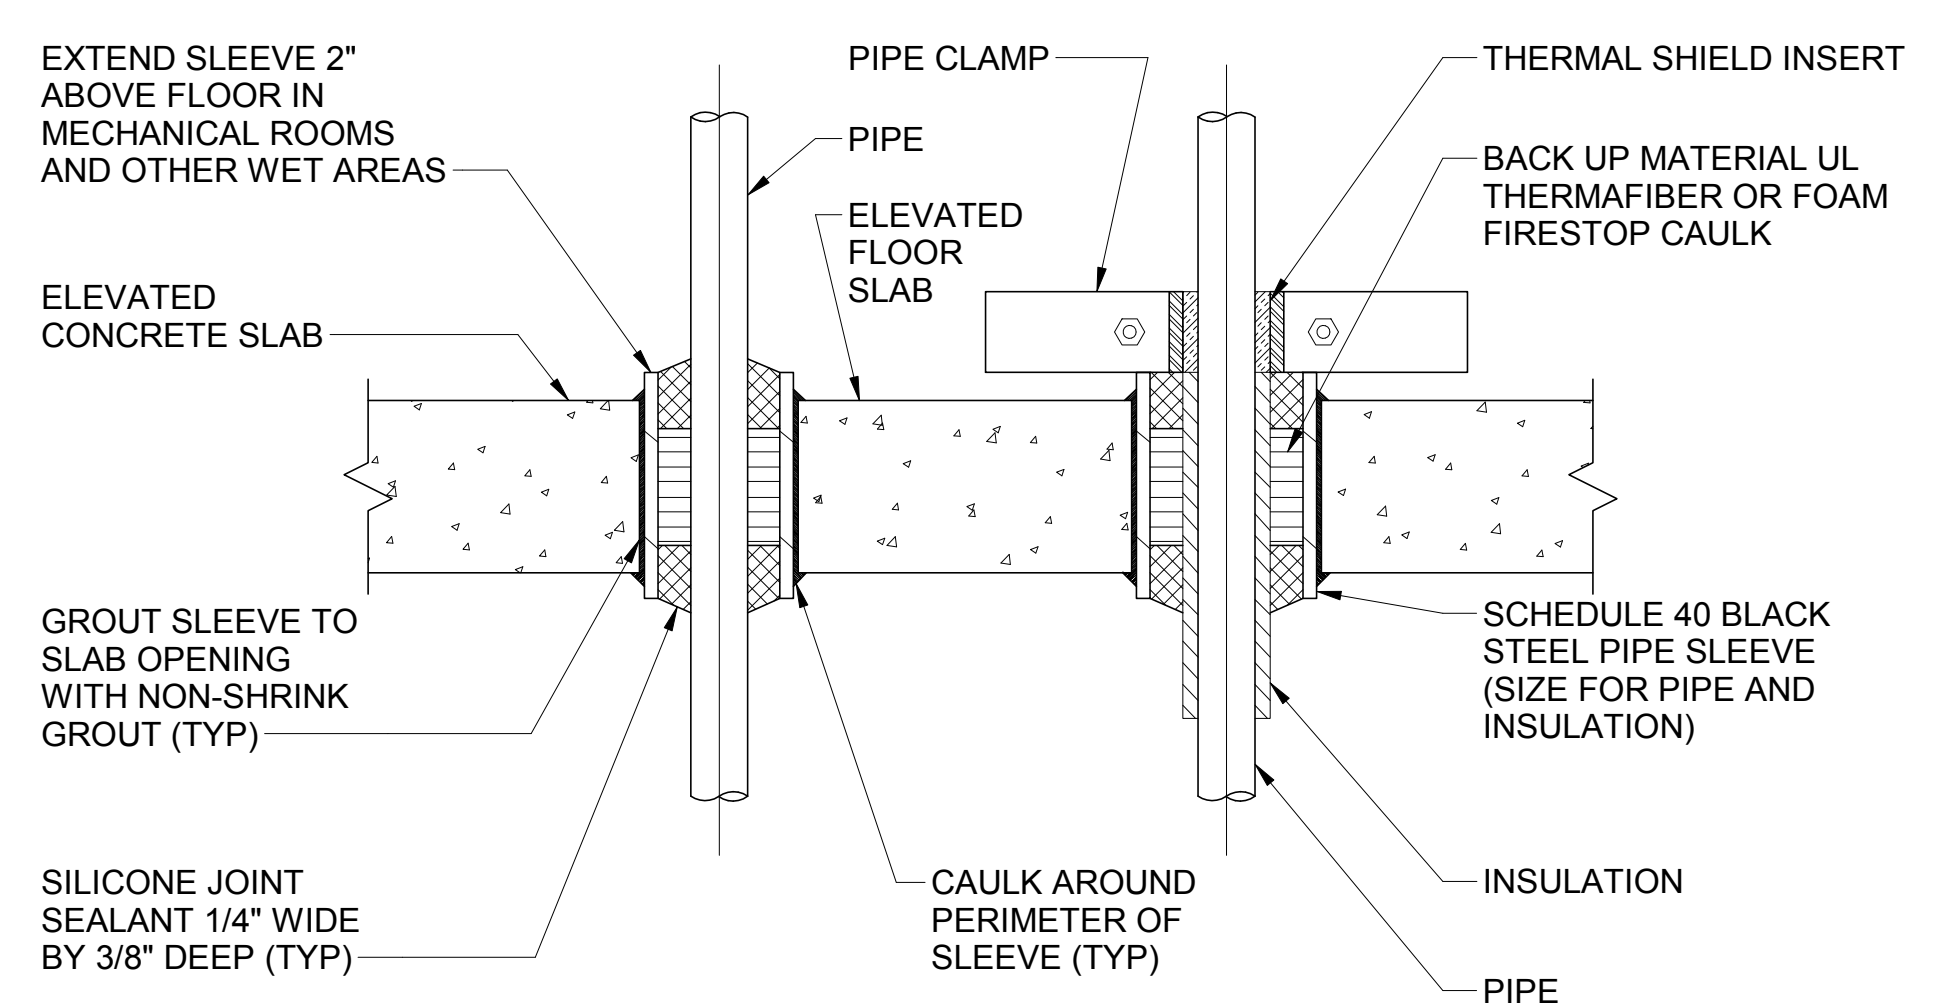


8 PIPE SLEEVE THROUGH ELEVATED FLOOR
P-501 SCALE: N.T.S.

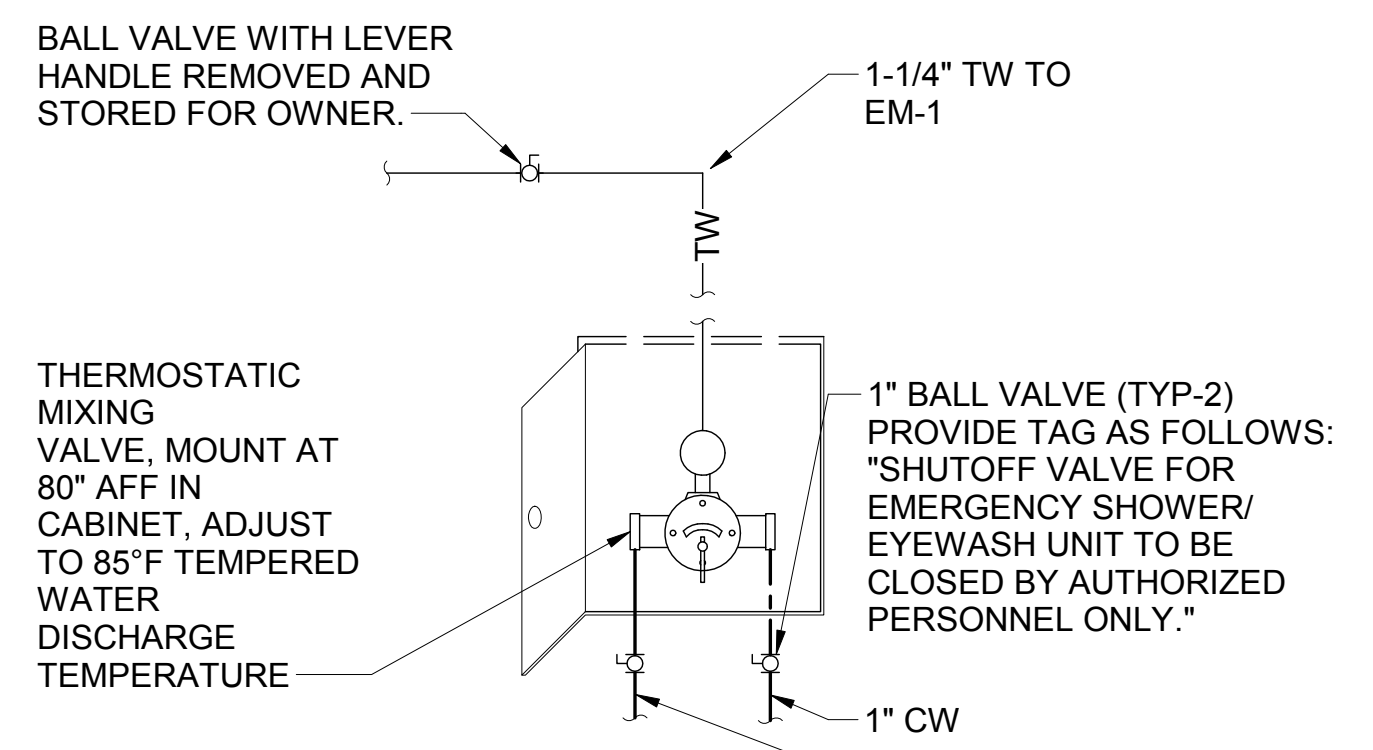


9 TEMPERED WATER MIXING VALVE EMV-1
P-501 SCALE: N.T.S.

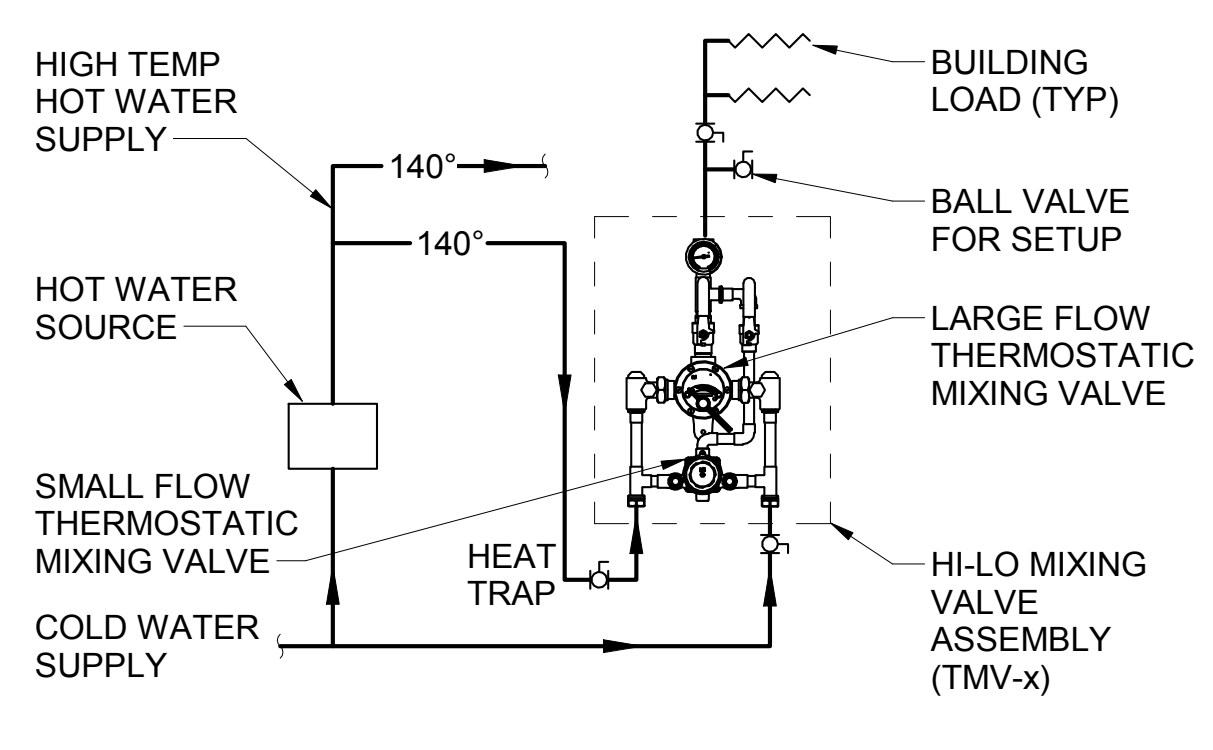


10 HI-LOW MIXING VALVE PIPING SCHEMATIC
P-501 SCALE: N.T.S.

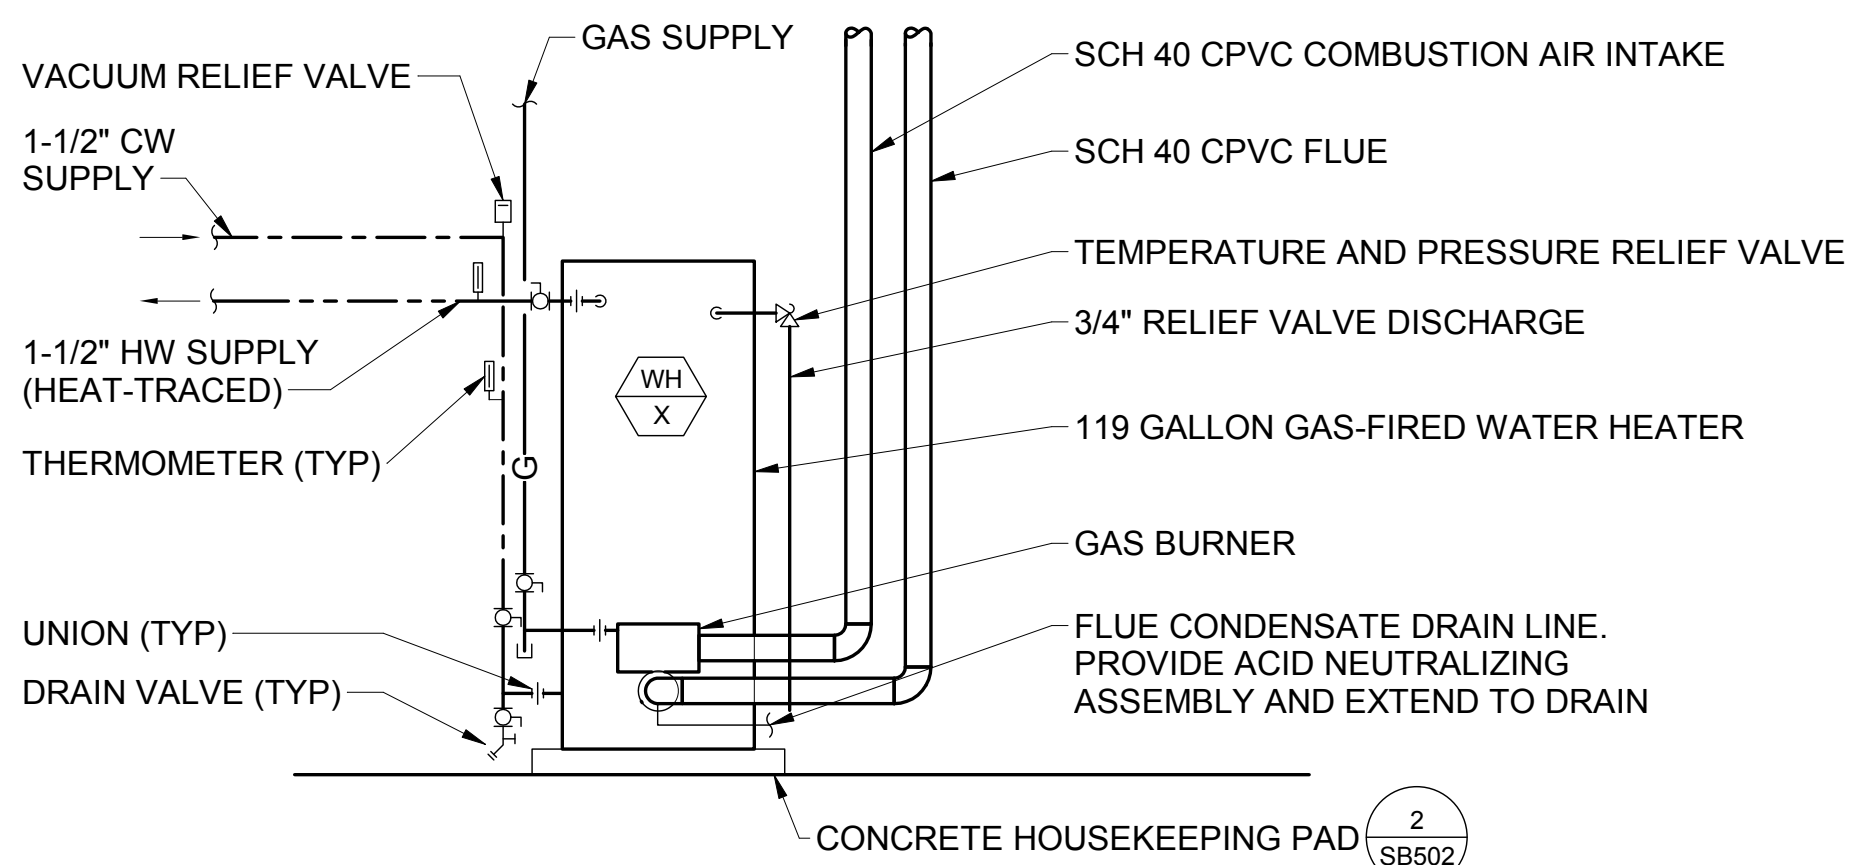


11 GAS-FIRED WATER HEATER DETAIL
P-501 SCALE: N.T.S.

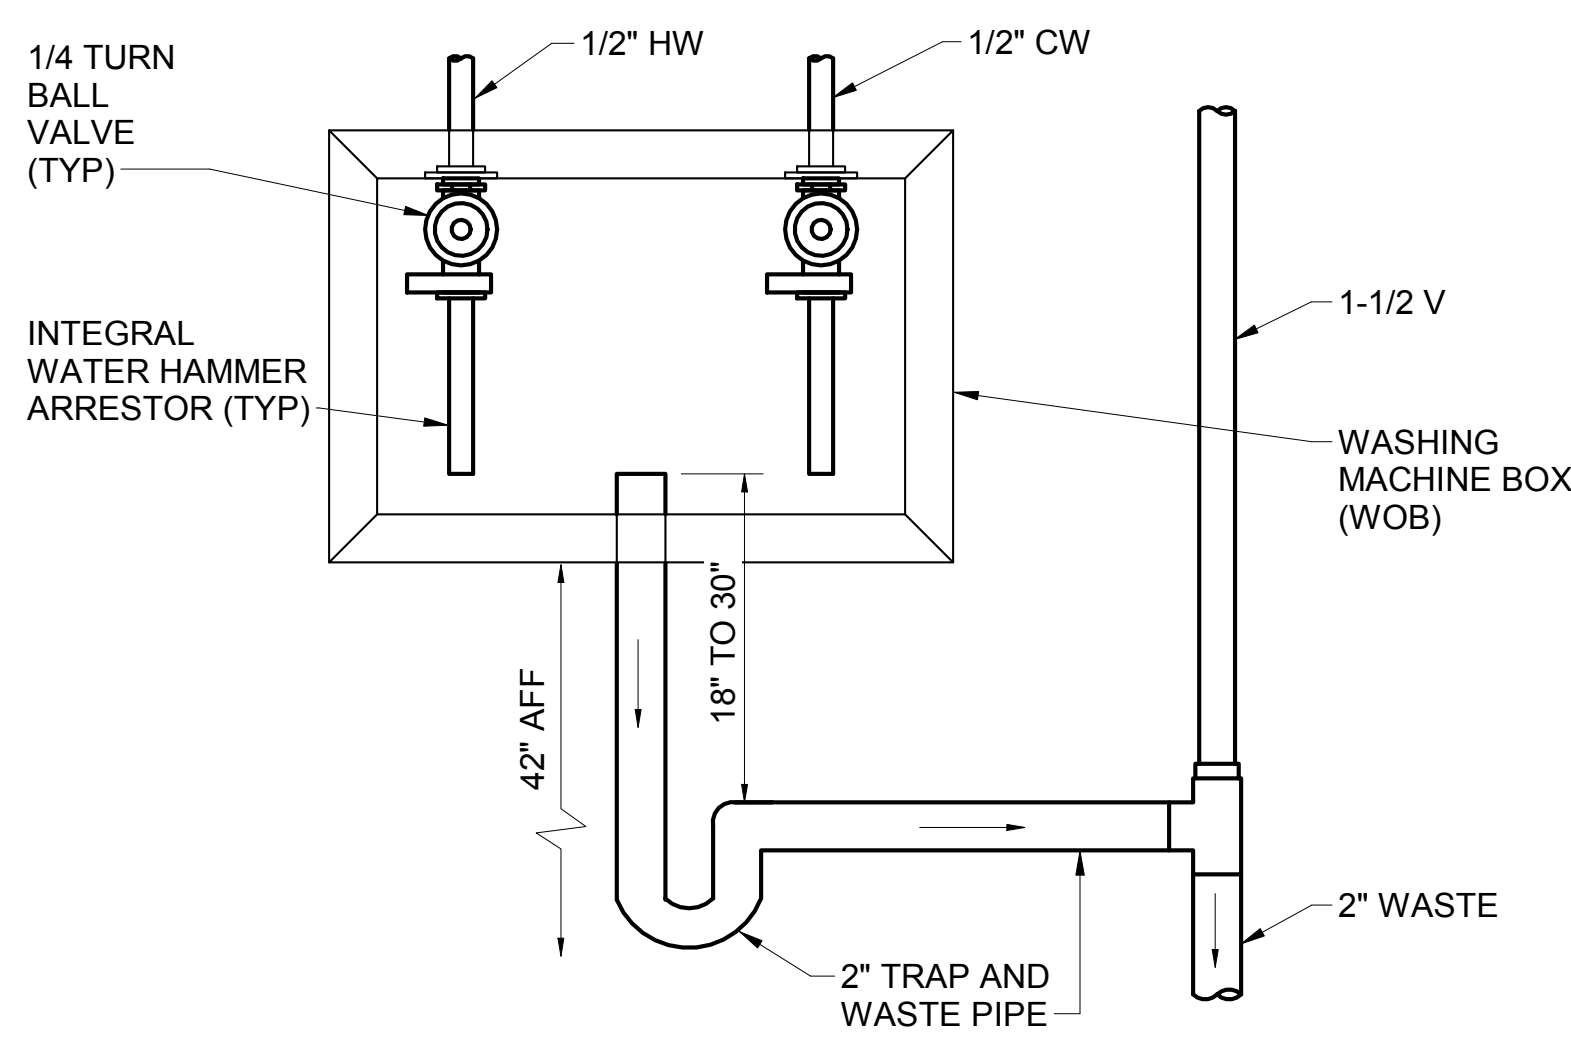


12 WASHING MACHINE BOX DETAIL
P-501 SCALE: N.T.S.

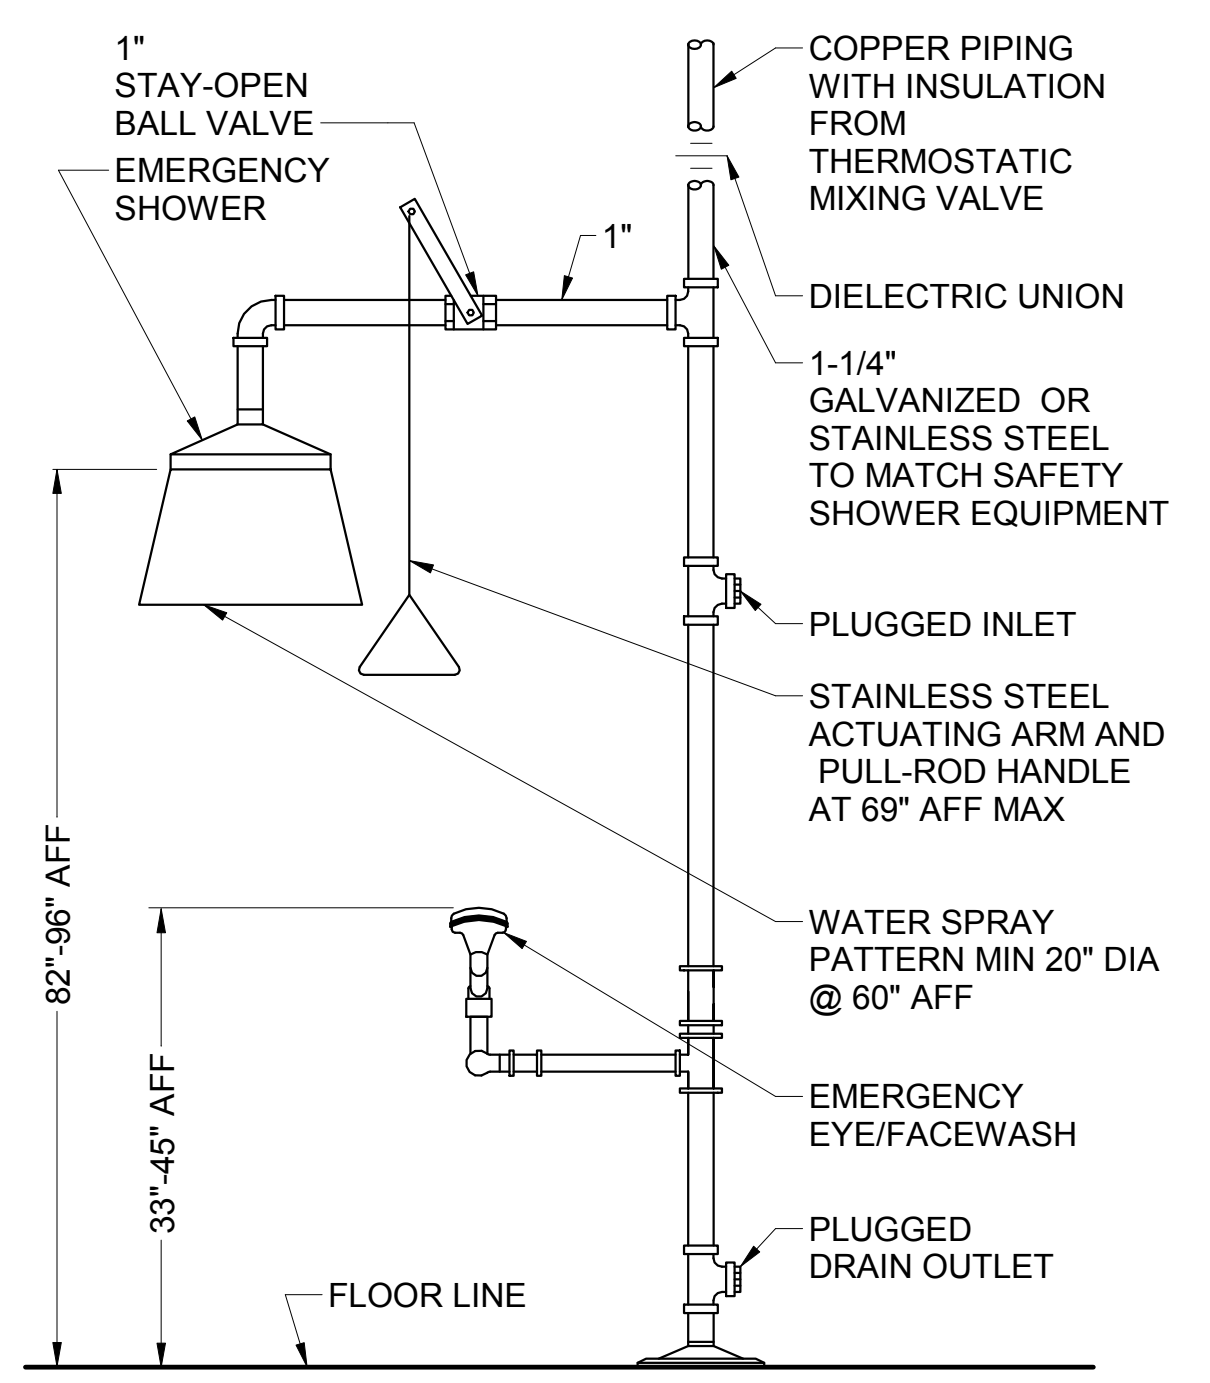


13 SAFETY SHOWER AND EYEWASH DETAIL
P-501 SCALE: N.T.S.

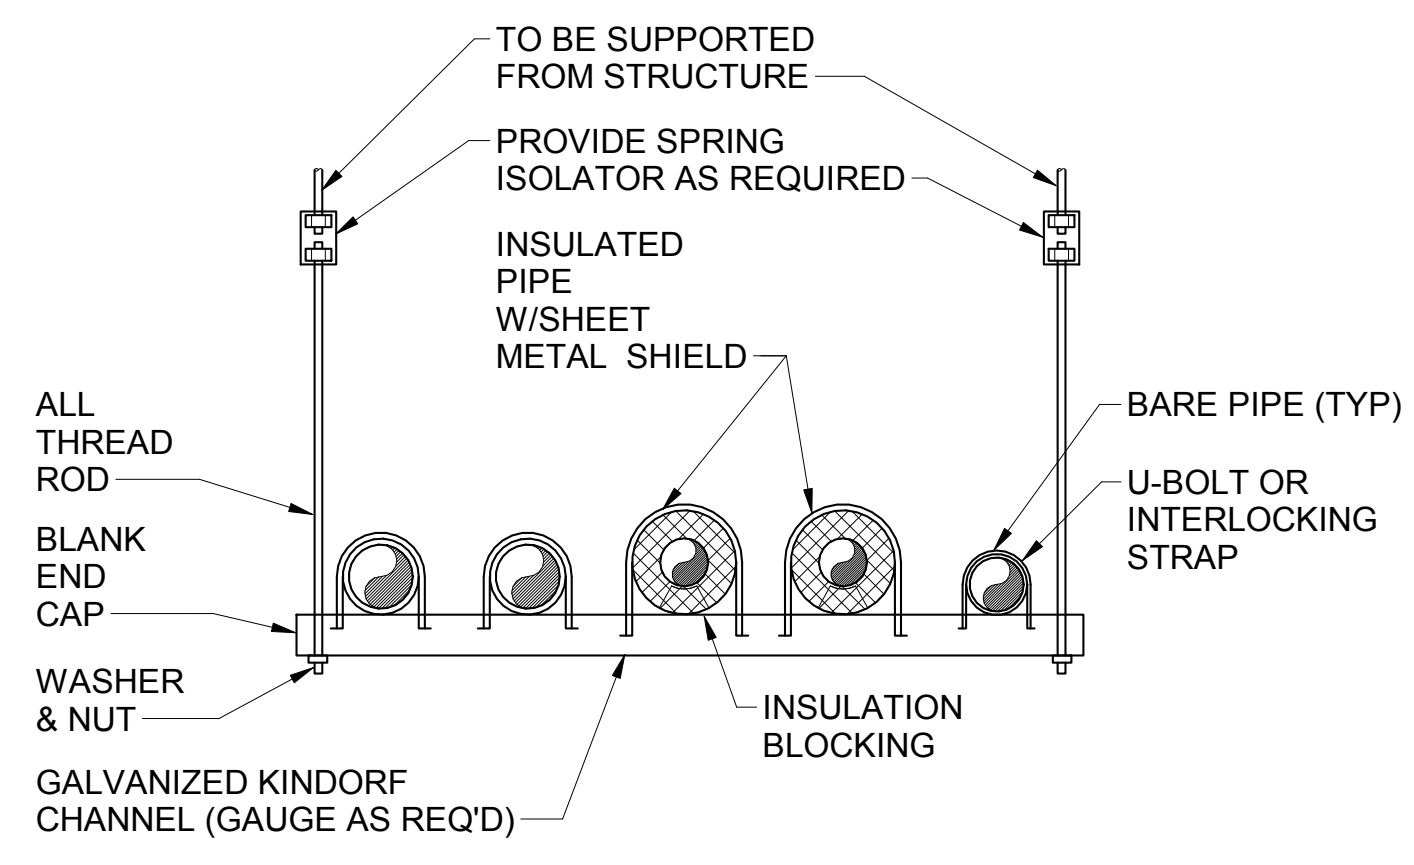


14 TRAPEZE PIPE SUPPORT DETAIL
P-501 SCALE: N.T.S.

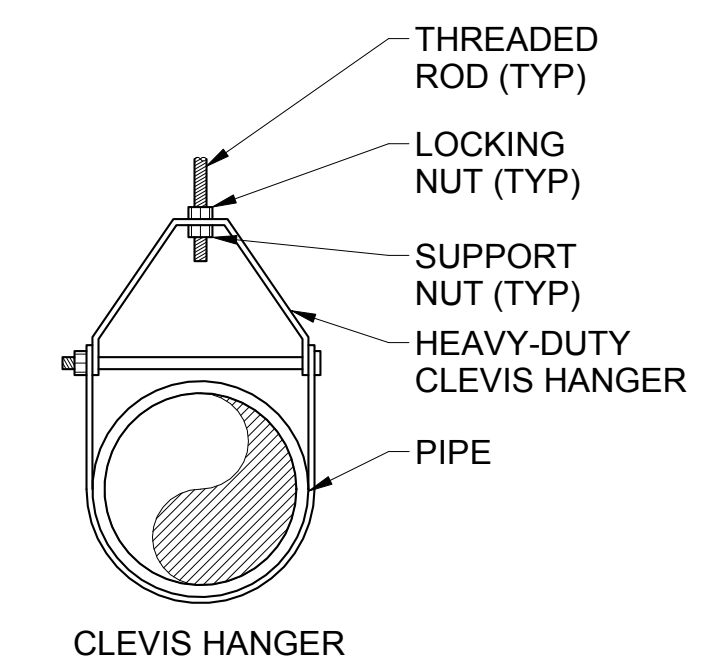

15 PIPE HANGER ATTACHMENT DETAIL
P-501 SCALE: N.T.S.

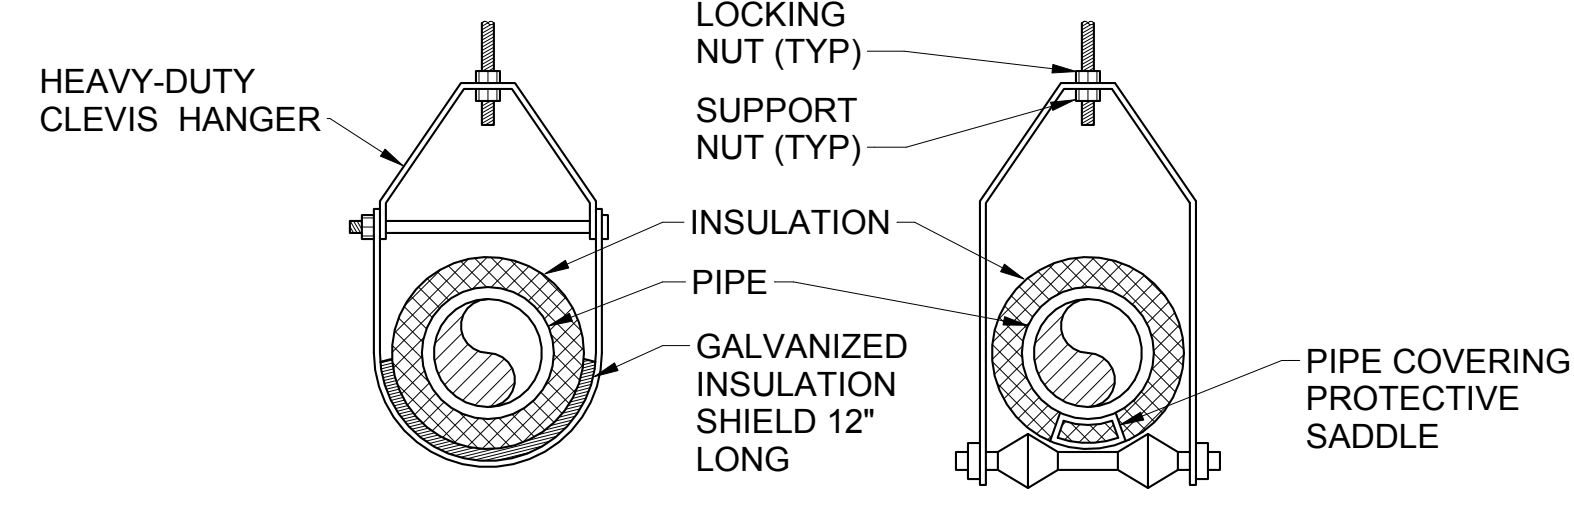

16 PIPE HANGER ATTACHMENT DETAILS
P-501 SCALE: N.T.S.

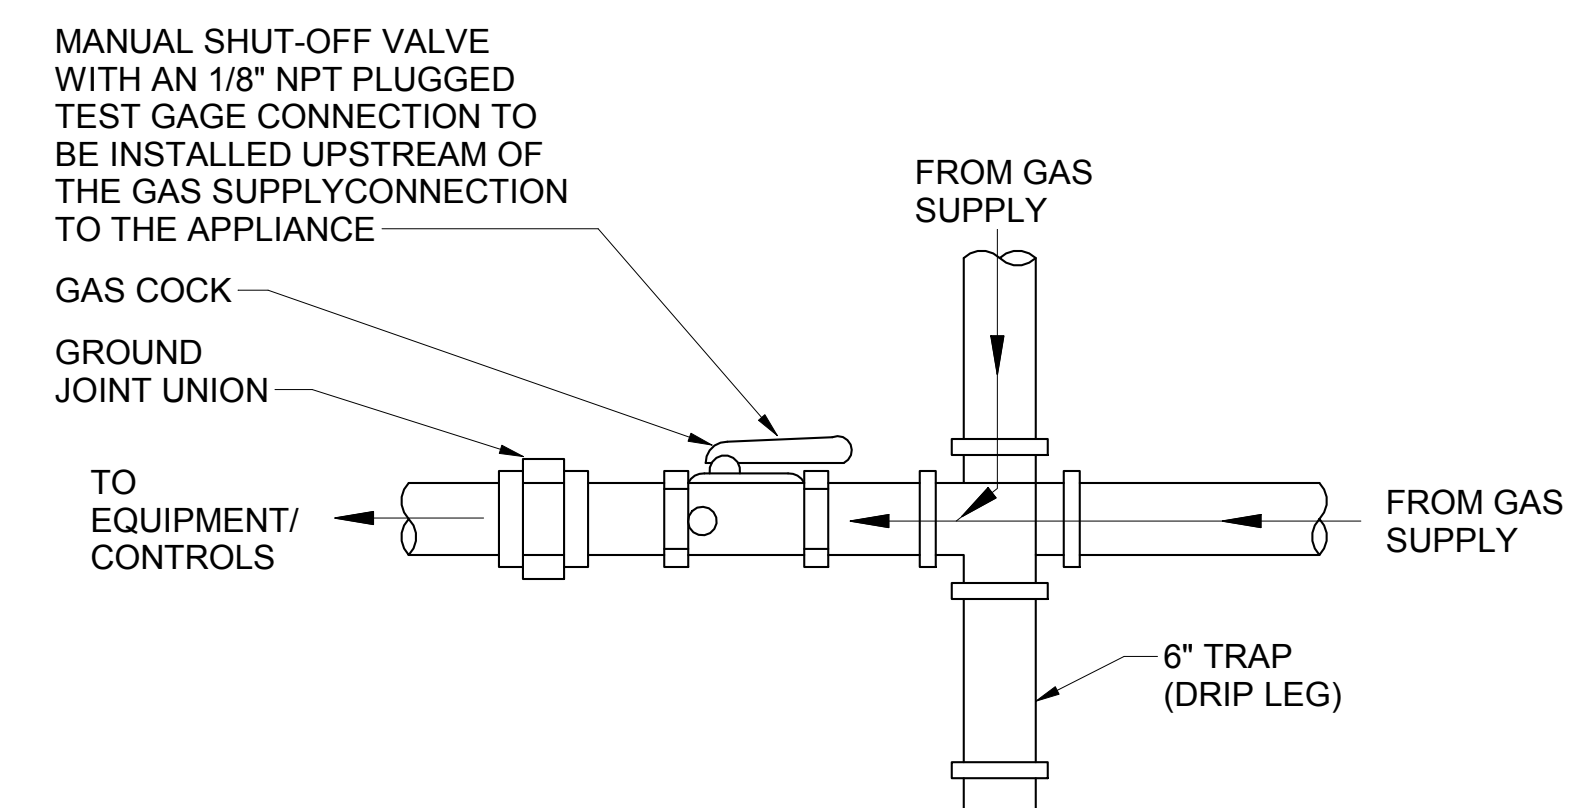

17 GAS CONNECTION TO EQUIPMENT DETAIL
P-501 SCALE: N.T.S.

- NOTES:**
1. PIPING SUPPORT SYSTEM COMPONENTS SHALL HAVE A NON-CORROSIVE METAL FINISH.
 2. COPPER PIPING SHALL BE PROTECTED FROM CONTACT W/DISSIMILAR METALS.

			STATE OF MAINE PUBLIC SCHOOL PROJECT TITLE: PORTLAND PUBLIC SCHOOLS NEW FRED P. HALL ELEMENTARY SCHOOL LOCATION: 23 ORONO ROAD, PORTLAND, ME TITLE THIS DWG: PLUMBING DETAILS 1
DRAWN BY: RDA CHECK BY: MSA	DATE: 03/17/17	OAK POINT ASSOCIATES P-501 SHEET NO.	271 OF 312