


DRAWING KEYNOTES

- △ DRAIN TRAP PRIMER CONNECTION. REFER TO PLANS FOR WATER LINE ROUTING.
- △ OFFSET WASTE AND VENT PIPING TO RISE IN KNEE WALL BELOW COUNTERTOP TO CLEAR BEAM AT WALL AND THEN OFFSET BACK INTO WALL TO RISE TO CEILING.
- △ OFFSET VENT ABOVE CEILING TO CLEAR BEAM AT WALL.

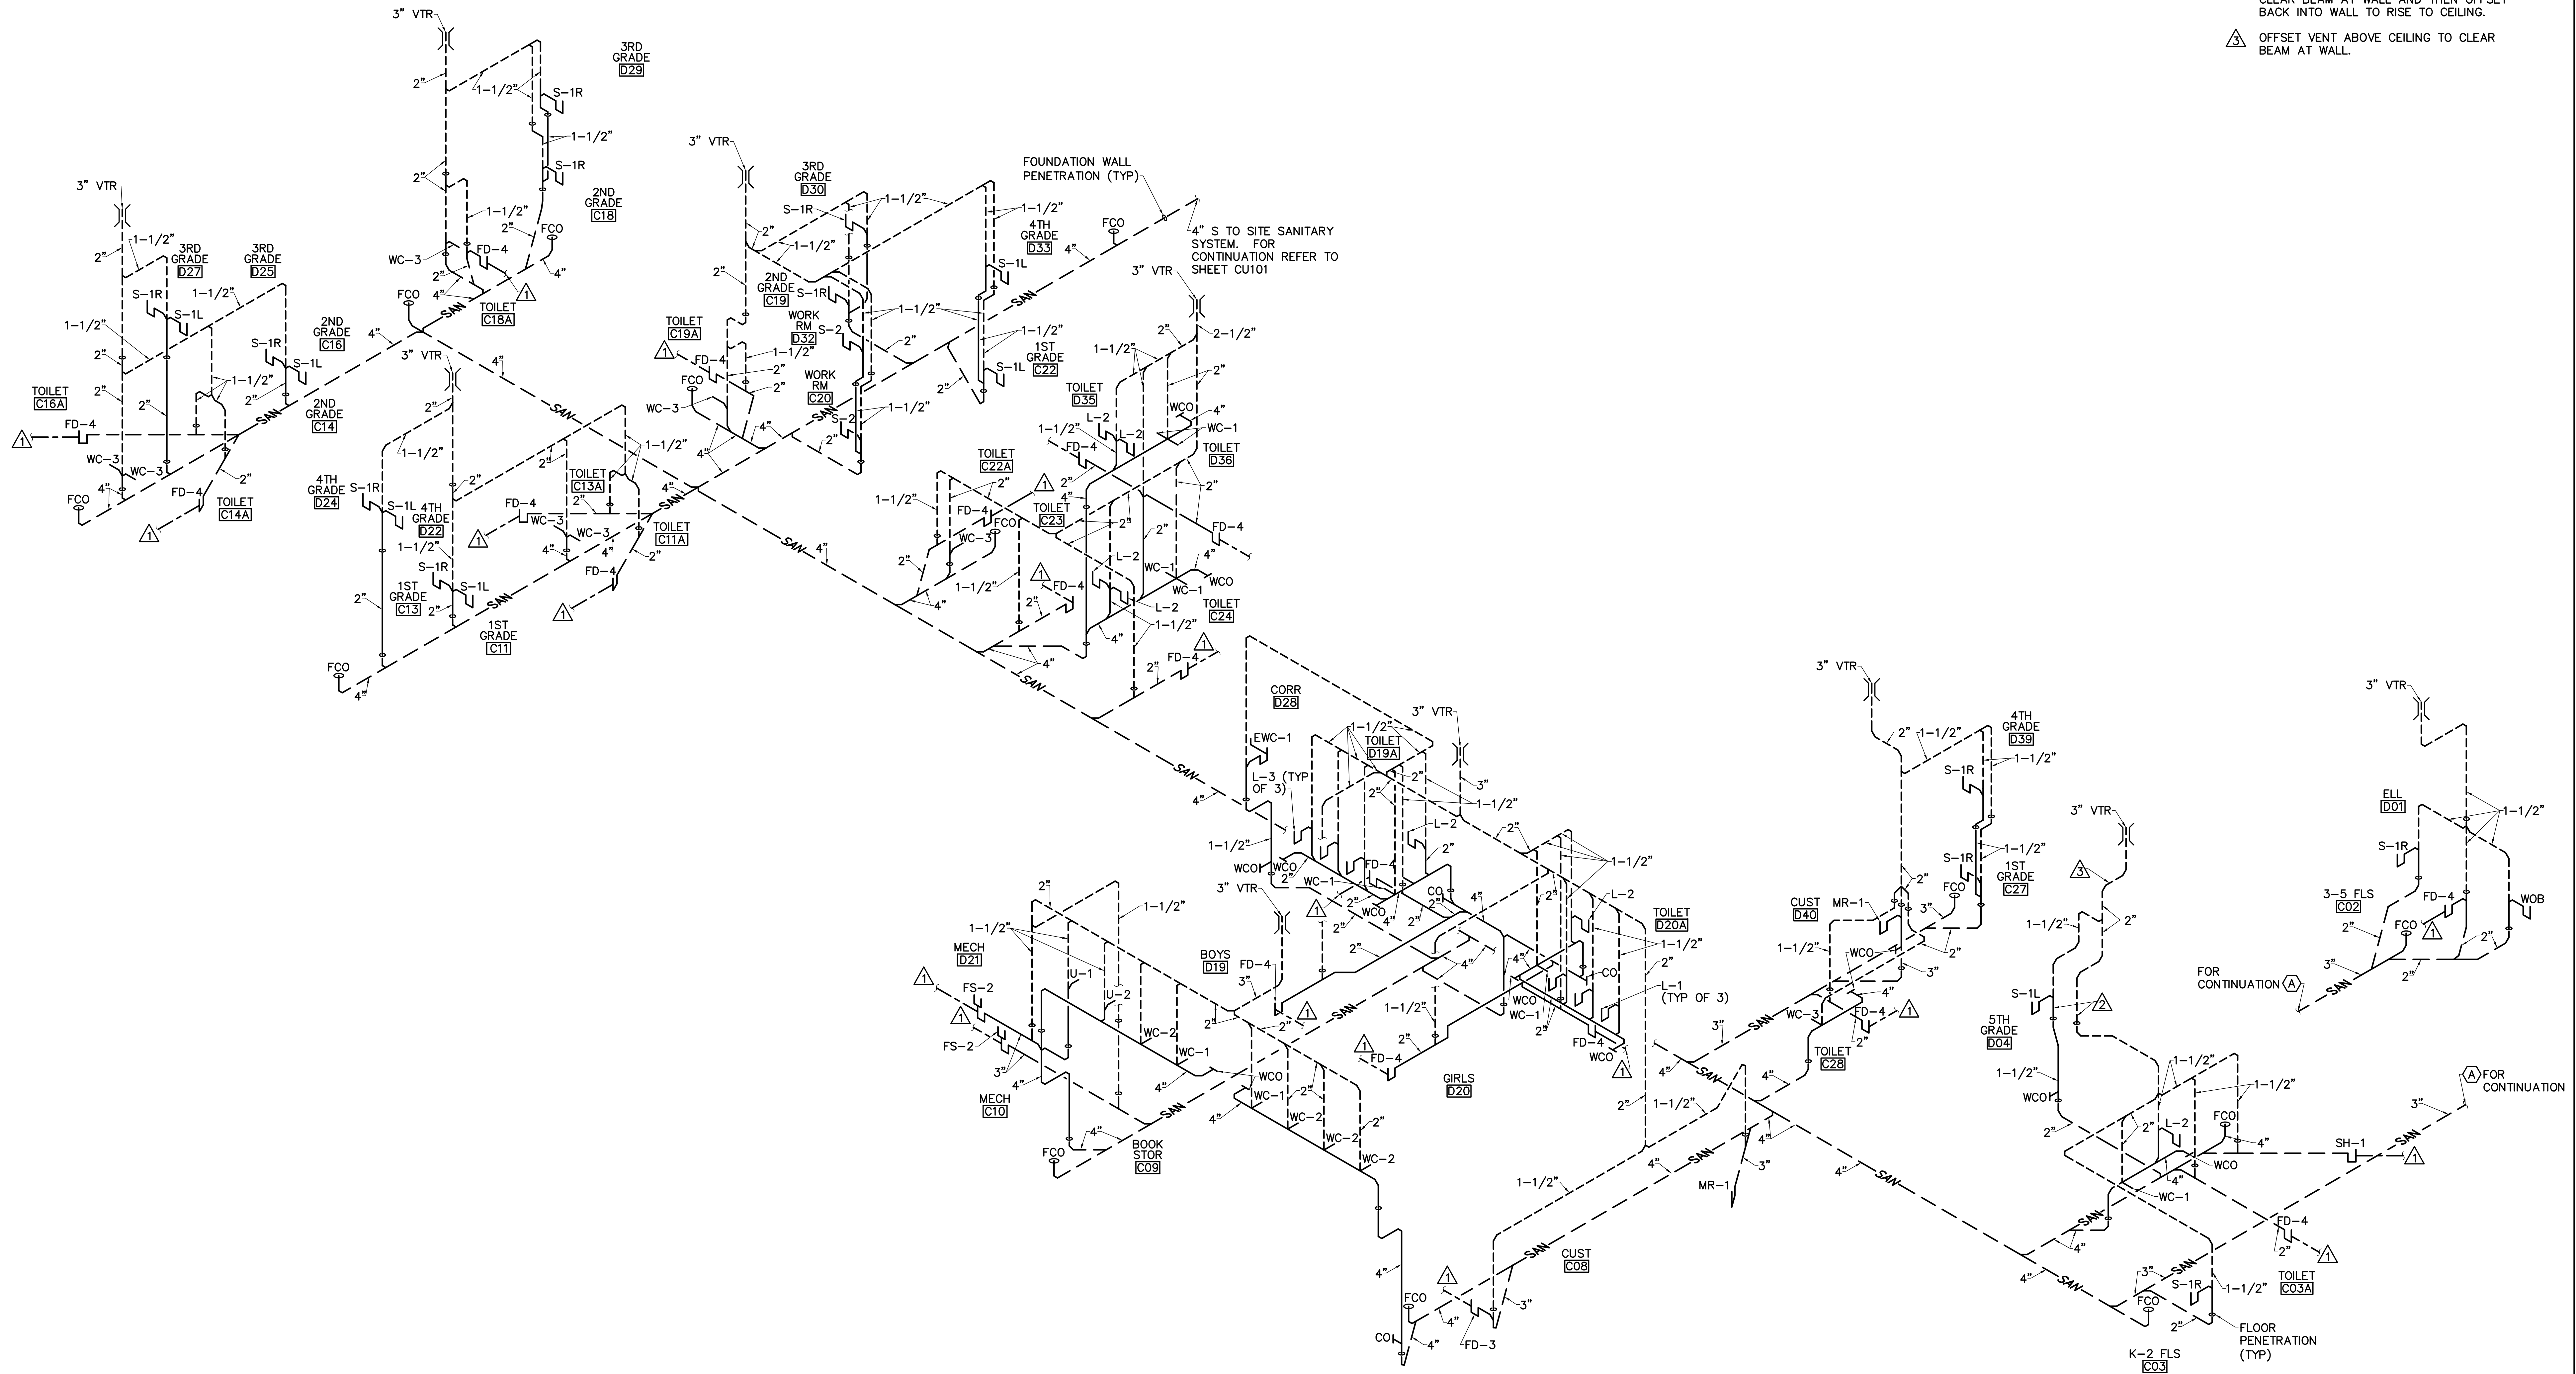

**1. SANITARY WASTE AND VENT
RISER DIAGRAM - PART C**
P-703 NOT TO SCALE

		STATE OF MAINE PUBLIC SCHOOL PROJECT	
		TITLE: PORTLAND PUBLIC SCHOOLS NEW FRED P. HALL ELEMENTARY SCHOOL LOCATION: 523 GRAND ROAD, PORTLAND, ME TITLE THIS DWG: PLUMBING RISER DIAGRAMS 3	
DRAWN BY: RDA CHECKED BY: MSA		DRAWING NO. P-703 SHEET NO.	
NO.	DATE	DESCRIPTION	BY
		REVISIONS	
DATE: 04/04/17		231 Main Street, Biddeford, Maine 04005 207.283.2193	