



1 Foodservice Equipment Plan
Q-101 SCALE: 1/4" = 1'-0"

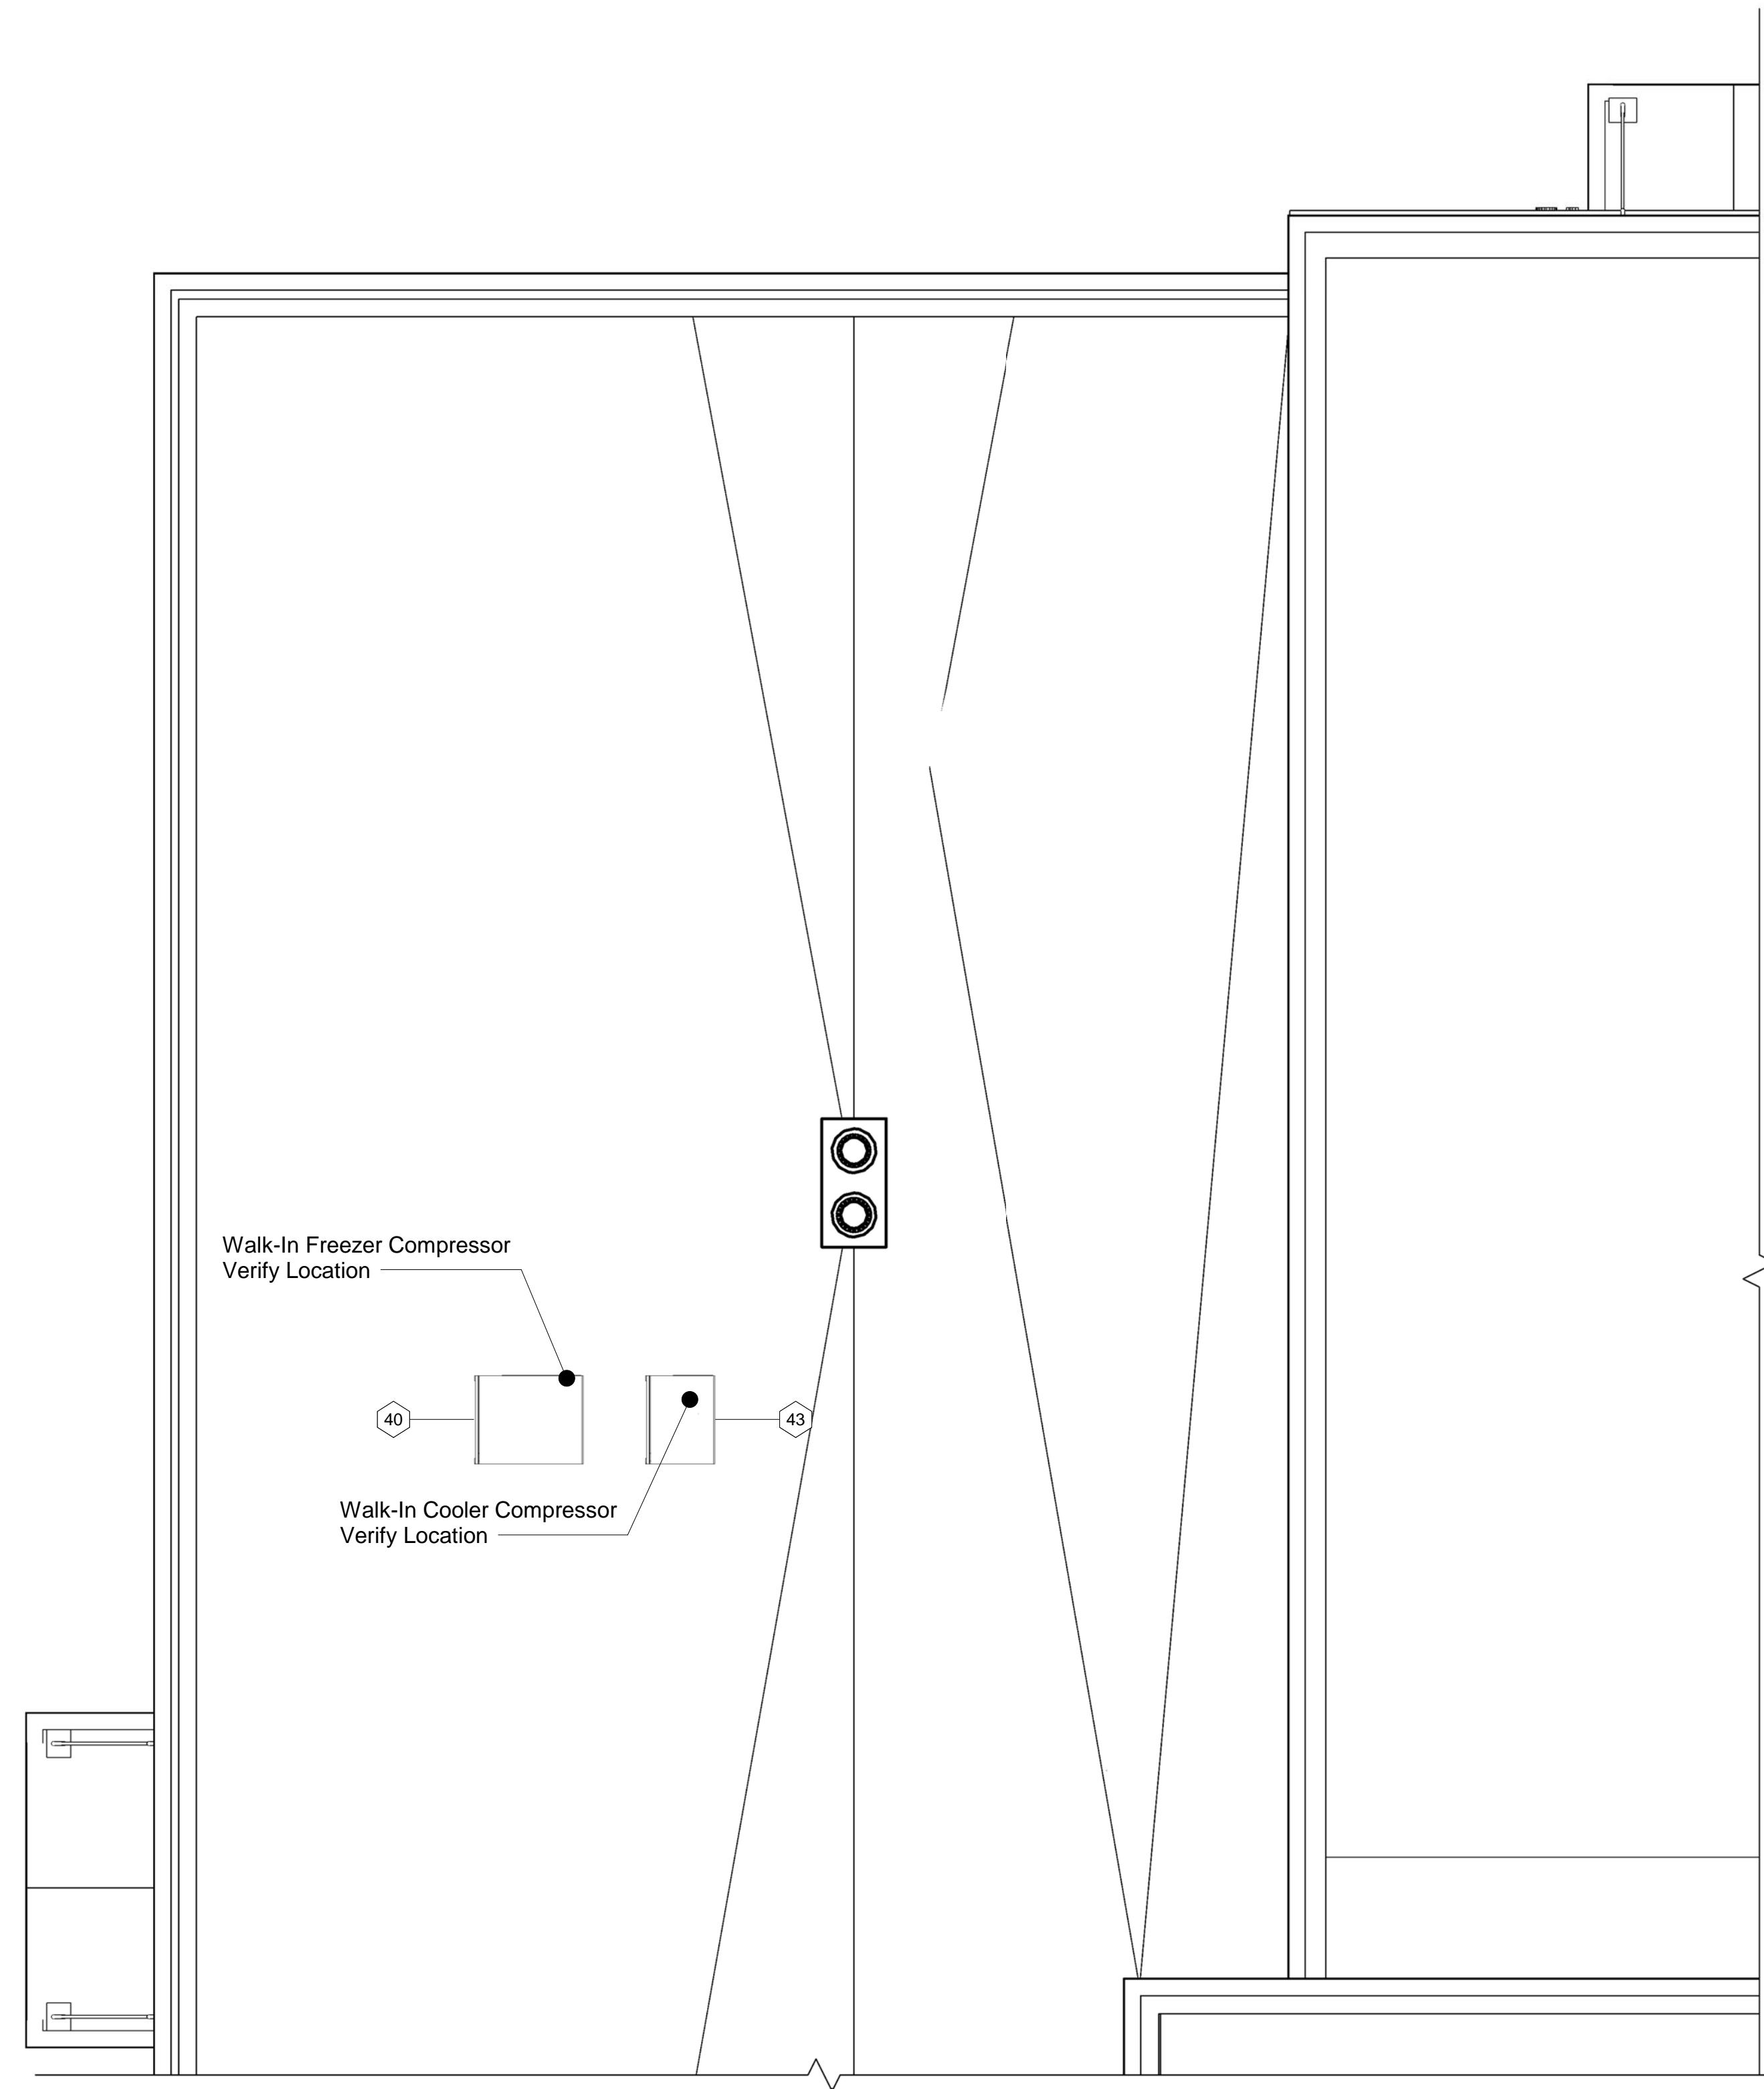

2 Foodservice Equipment Roof Plan
Q-101 SCALE: 1/4" = 1'-0"

Foodservice Equipment Schedule		
Item #	Qty.	Description
1	1	Mop Sink
1.1	1	Service Faucet
2	1	Shelving Unit
3	1	Dishable, Clean
4	1	Condensate Hood
5	1	Dishwasher, Door-Type
6	1	Dishable, Soiled
6.1	1	Pre-Rinse Faucet
7	1	Disposer
7.1	1	Disposer Control Panel
8	1	Sink, 3-Compartment
8.1	2	Double Pantry Faucet
9	1	Pot Rack, Wall Mounted
10	3	Hand Sink
12	2	Shelving Unit
13	2	Convection Oven, Double
14	1	Range, 6-Burner
15	1	Steamer, Double
16	2	Exhaust Hood
19	2	Bun Pan Rack
20	1	Refrigerator, Roll-In
21	2	Work Table
22	2	Rethermalization Cabinet
24	1	Work Table with Sink
24.1	1	Faucet, Splash Mounted
25	2	Wall Shelf
30	2	Milk Cooler
31	2	Serving Counter, Flat Top
32	2	Serving Counter, Hot Food
33	2	Tray Stand
34	1	Serving Counter, Salad Bar
35	1	Serving Counter, Cashier Station
36	7	Shelving Unit
37	1	Trash/Recycling/Compost Station
38	1	Walk-In Freezer
39	1	Evaporator Coil, Freezer
40	1	Compressor, Freezer
41	1	Walk-In Cooler
42	1	Evaporator Coil, Cooler
43	1	Compressor, Freezer
44	10	Shelving Unit

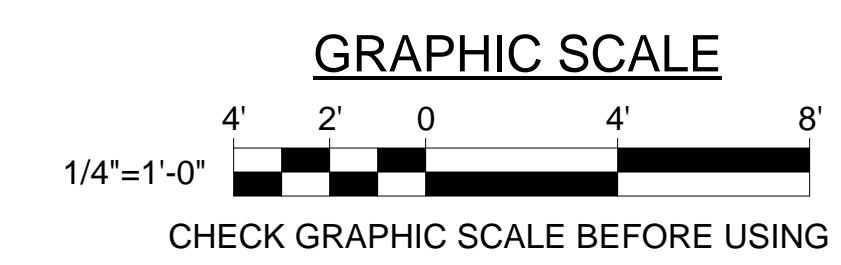

STATE OF MAINE PUBLIC SCHOOL PROJECT	
TITLE PORTLAND PUBLIC SCHOOLS NEW FRED P. HALL ELEMENTARY SCHOOL	
LOCATION 23 ORONO ROAD, PORTLAND, ME	
TITLE THIS DWG. FOODSERVICE EQUIPMENT FLOOR PLAN & SCHEDULE	
DRAWN BY: TJM	DRAWING NO.
CHECK BY: TJM	Q-101
NO. DATE	DESCRIPTION
BY	NO.
REVISIONS	DATE 03/17/17