



2 MEZZANINE PLAN
1/8"=1'-0"

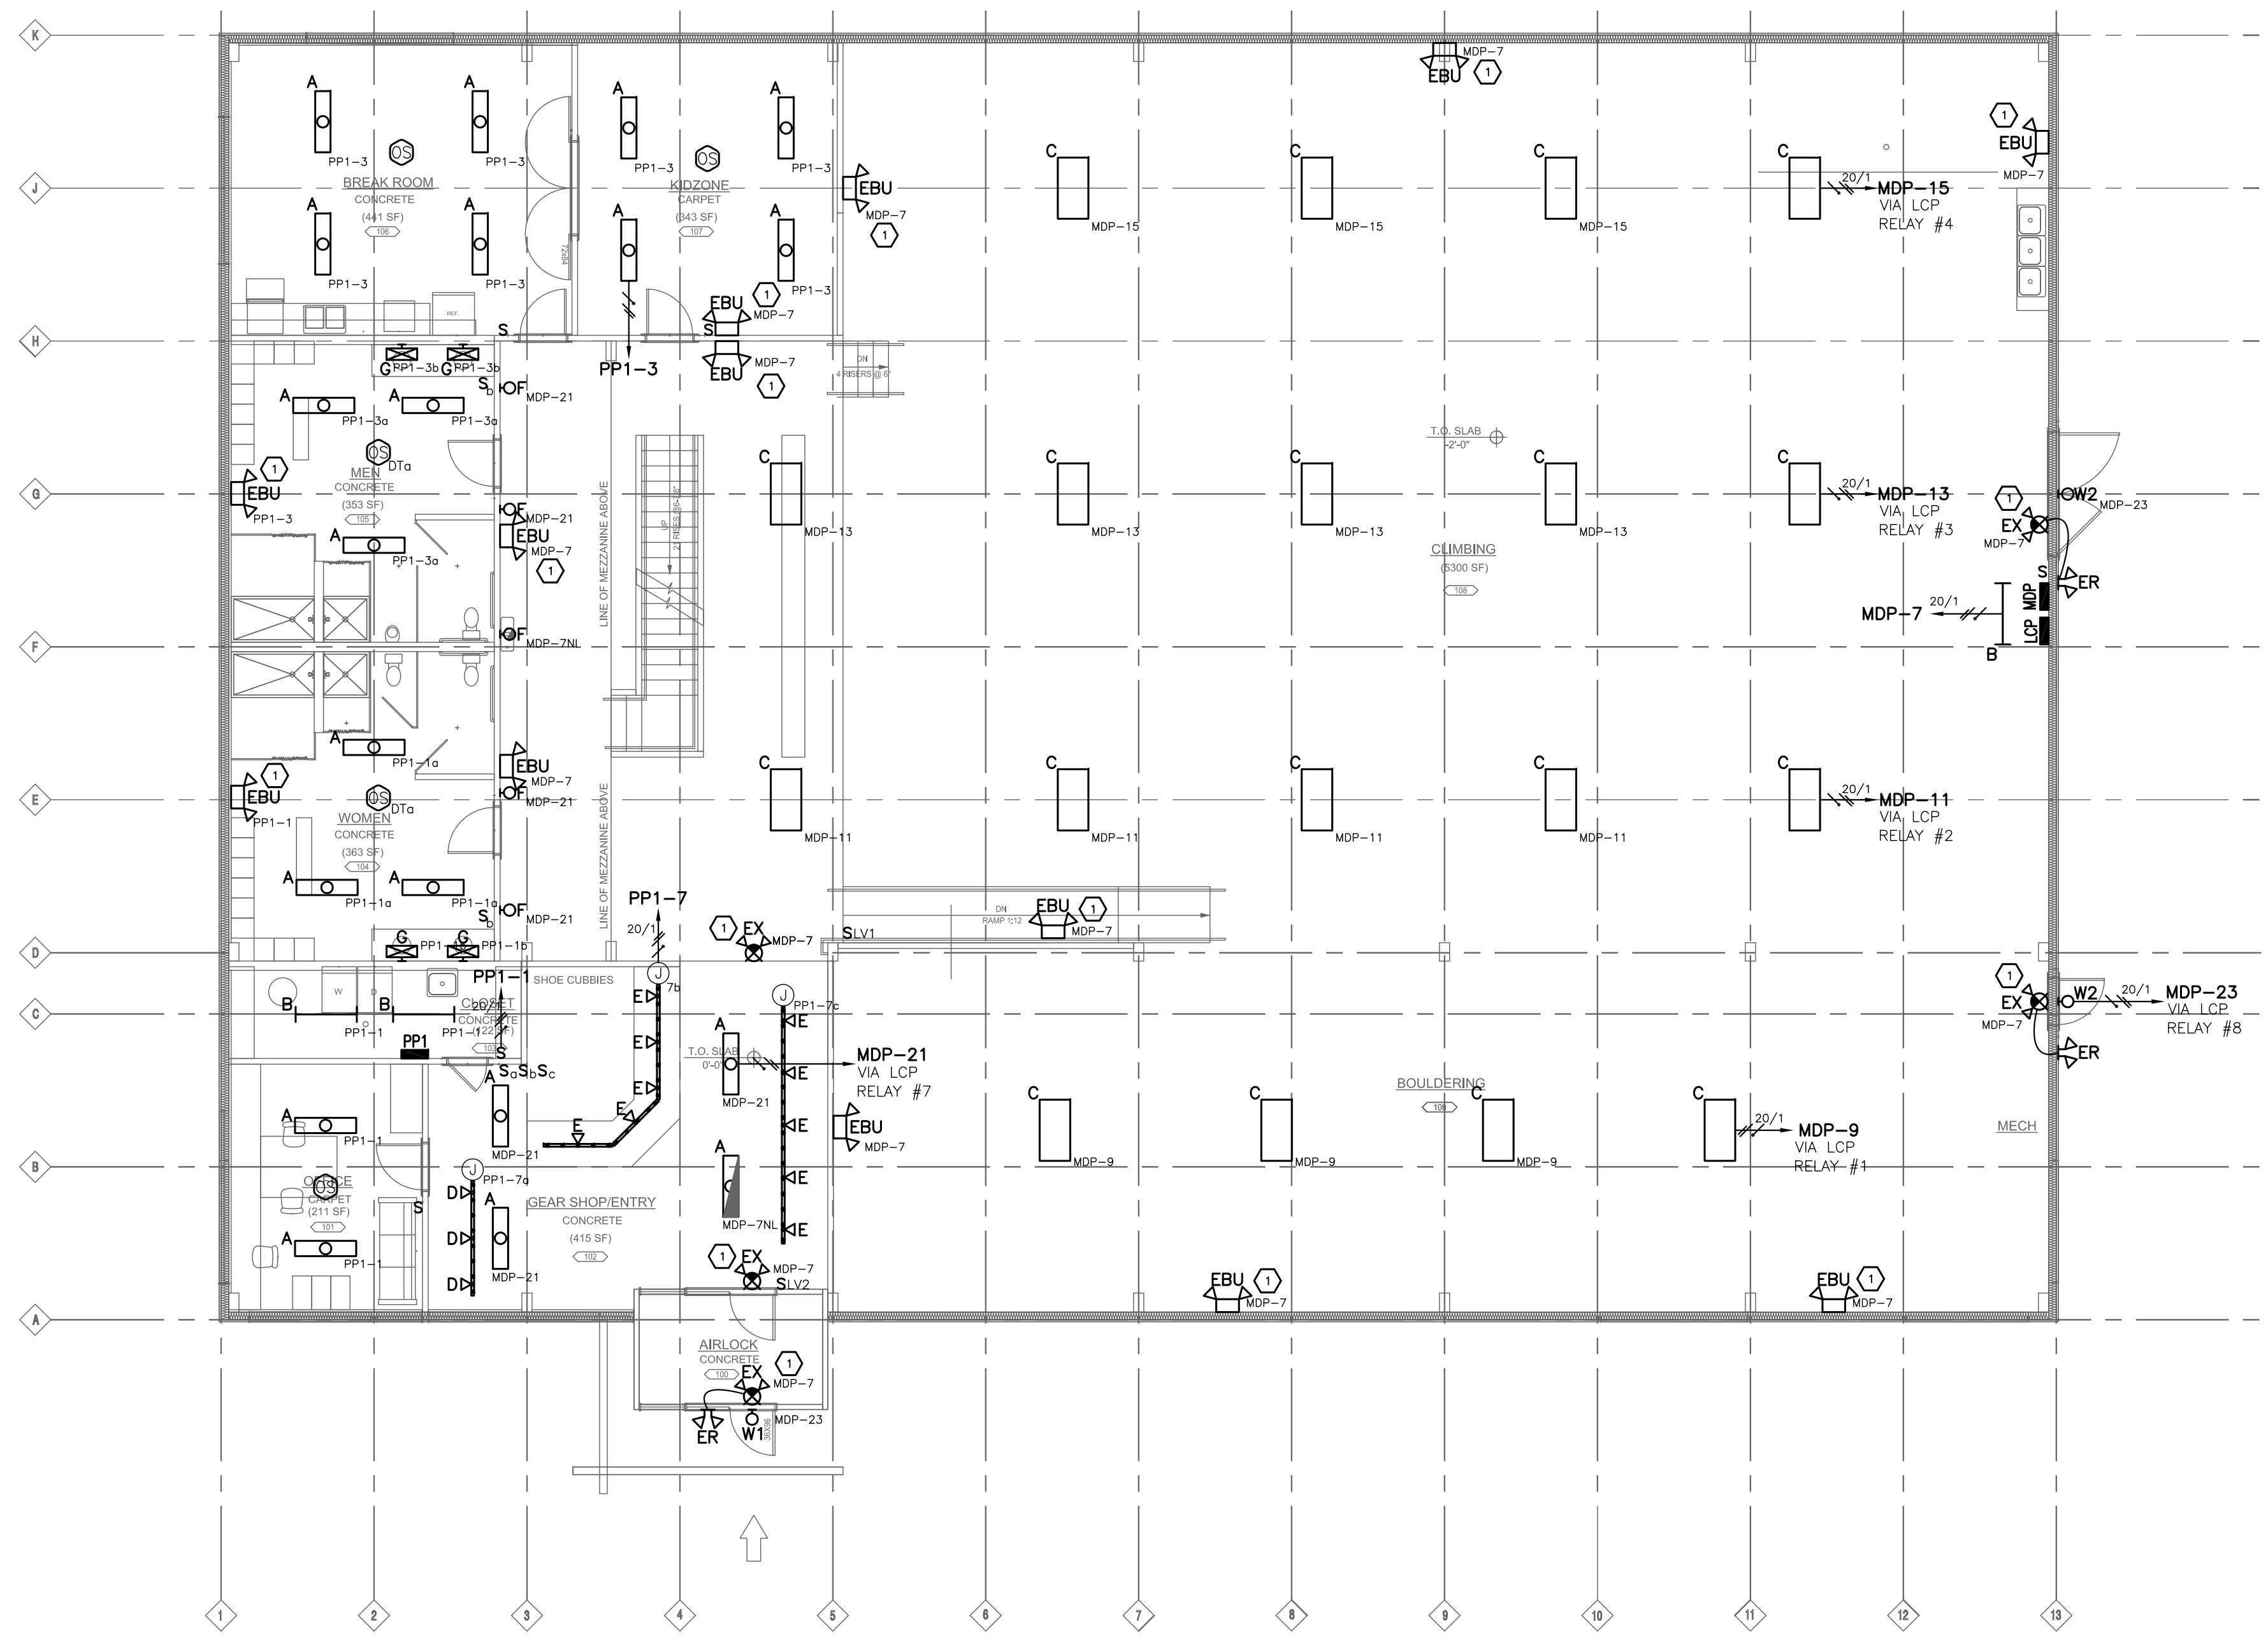

1 FIRST FLOOR PLAN
1/8"=1'-0"

ELECTRICAL KEY NOTES:

- 1 SELF CONTAINED UNIT EXIT SIGNS, EMERGENCY BATTERY UNITS AND EMERGENCY BALLAST TO BE CONNECTED TO LOCAL AREA LIGHTING CIRCUITS AHEAD OF ALL SWITCHING CONTROLS, IN ACCORDANCE WITH 2011 NEC SECTION 700.12-(e).
- 2 E.C. TO PROVIDE POWER CONNECTION TO MECHANICAL EQUIPMENT AS SHOWN. ALL LOW VOLTAGE AND CONTROL WIRING TO BE FURNISHED AND INSTALLED BY THE M.C. VERIFY LOCATION OF MECHANICAL EQUIPMENT IN FIELD WITH THE MECHANICAL CONTRACTOR.
- 3 E.C. TO VERIFY FINAL LOCATION OF OUTLET, DEVICE, AND/OR EQUIPMENT IN FIELD WITH THE GENERAL CONTRACTOR PRIOR TO ROUGH IN.
- 4 E.C. TO COORDINATE EXACT LOCATION AND ELECTRICAL REQUIREMENTS OF OWNER FURNISHED EQUIPMENT IN THE FIELD WITH THE OWNERS REPRESENTATIVE.
- 5 REMOTE TEST STATION TO BE LOCATED IN ACCESSIBLE AREA WITH IN 25 FEET OF ROOF TOP UNIT. LABEL EACH STATION IDENTIFYING THE ROOF TOP UNIT IT SERVES. REFER TO MANUFACTURERS RISER DIAGRAM FOR WIRING REQUIREMENTS.
- 6 E.C. TO COORDINATE EXACT LOCATION OF LIGHTING FIXTURES IN MECHANICAL SPACE TO AVOID CONFLICT WITH MECHANICAL EQUIPMENT AND DUCT WORK.

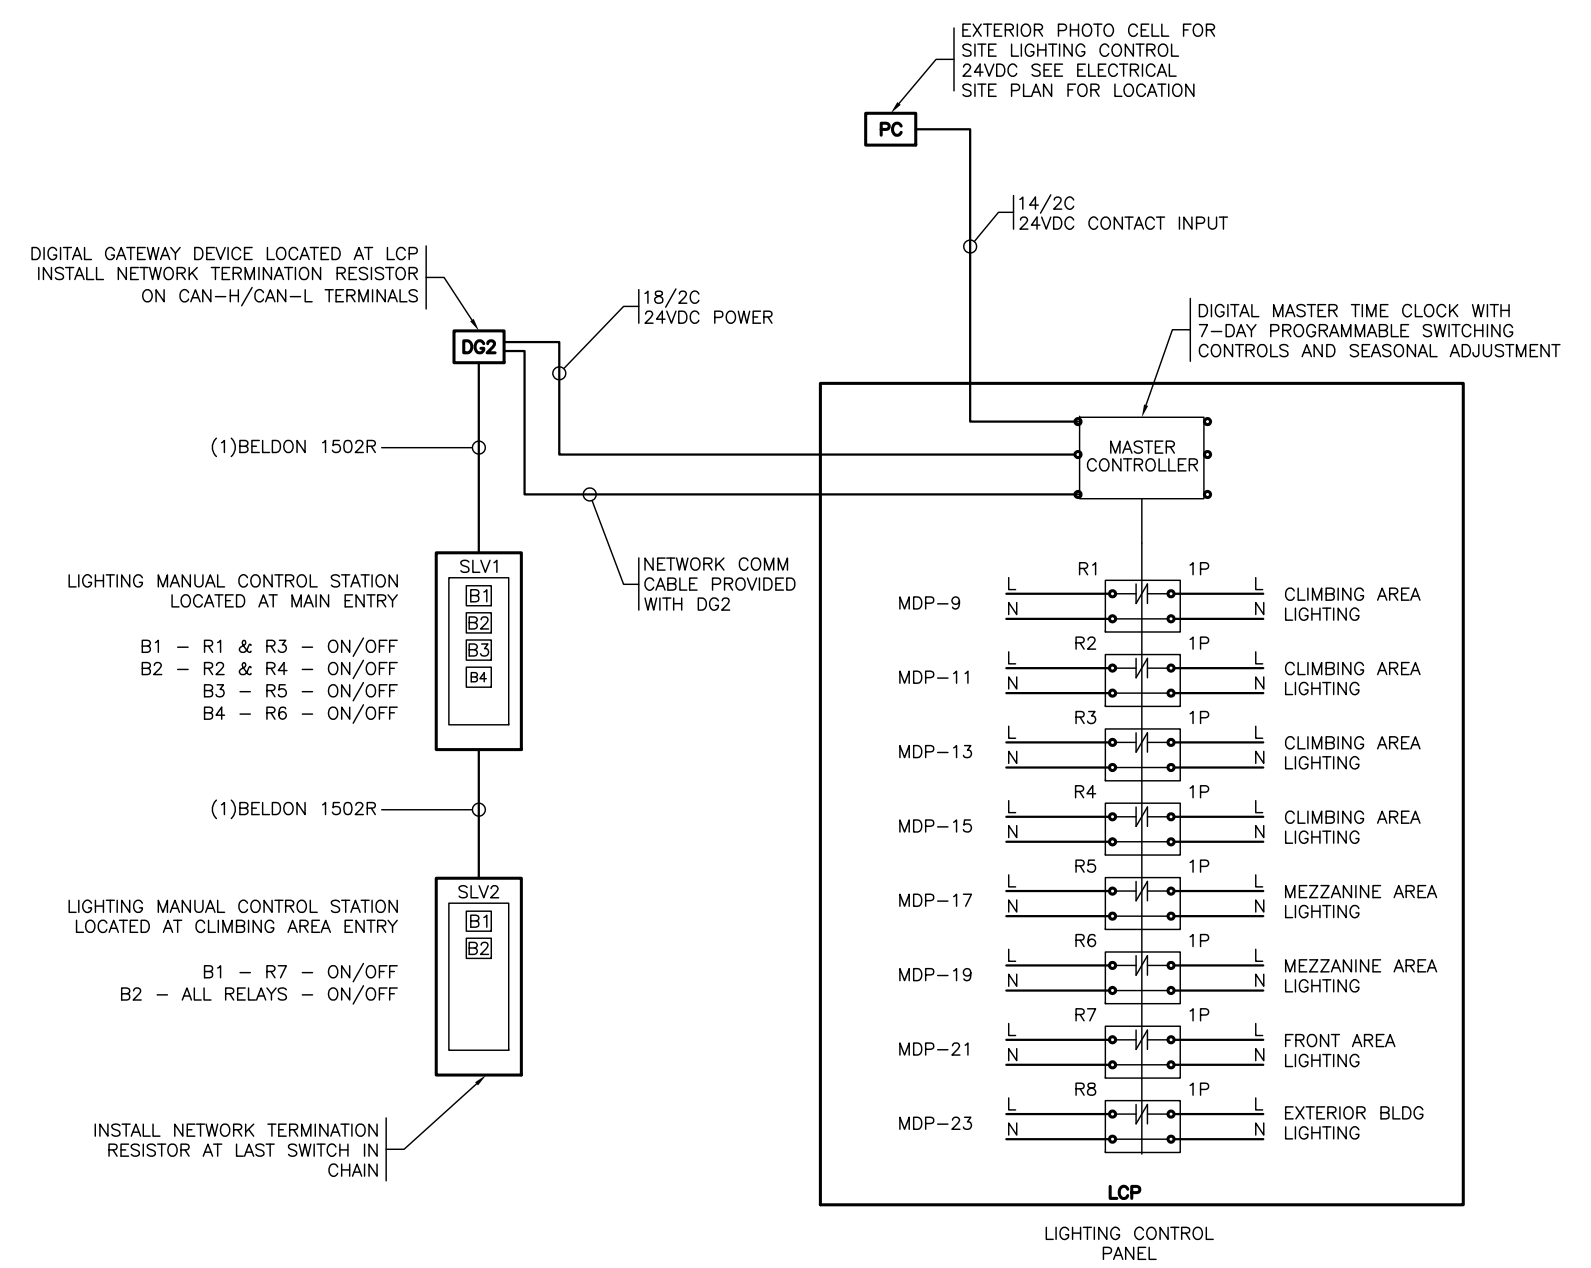

2 LIGHTING CONTROL DETAIL
NOT TO SCALE

NO.	ISSUE/REVISION	DATE	BY
1	ISSUED FOR PROGRESS	1/13/14	J. LLESSARD



Interstate Electrical Services
THE DIFFERENCE IS ATTITUDE
15 COTE LANE BEDFORD, N.H. 03110
P: (603) 627-5230 F: (603) 627-3480
www.iasec.com

PROJECT:
EVO ROCK & FITNESS
65 WARREN AVE
PORTLAND, MAINE

DATE: 12-6-13
DRAWN BY: B. HARLOW
DESIGNED BY: M. WHITE
CHECKED BY: M. WHITE
SCALE: AS SHOWN
PROJECT NUMBER: ---

DRAWING TITLE:
LIGHTING PLANS

DRAWING NUMBER
E4
SHEET 4 OF 4

PROGRESS
JANUARY 13, 2014
DRAWING
NOT FOR CONSTRUCTION