





LIGHTING LEGEND

- E.TRO EXISTING TROFFER 2X4 FIXTURE
- E.D./I EXISTING DIRECT/INDIRECT 2X4 FIXTURE
- R/E.TRO REUSE EXISTING TROFFER 2X4 FIXTURE IN NEW LOCATION
- R/E.P REUSE EXISTING PARABOLIC FIXTURE
- P NEW PARABOLIC FIXTURE
- C NEW LED DOWNLIGHT


1 REFLECTED CEILING PLAN - NEW
SCALE: 1/4" = 1'-0"

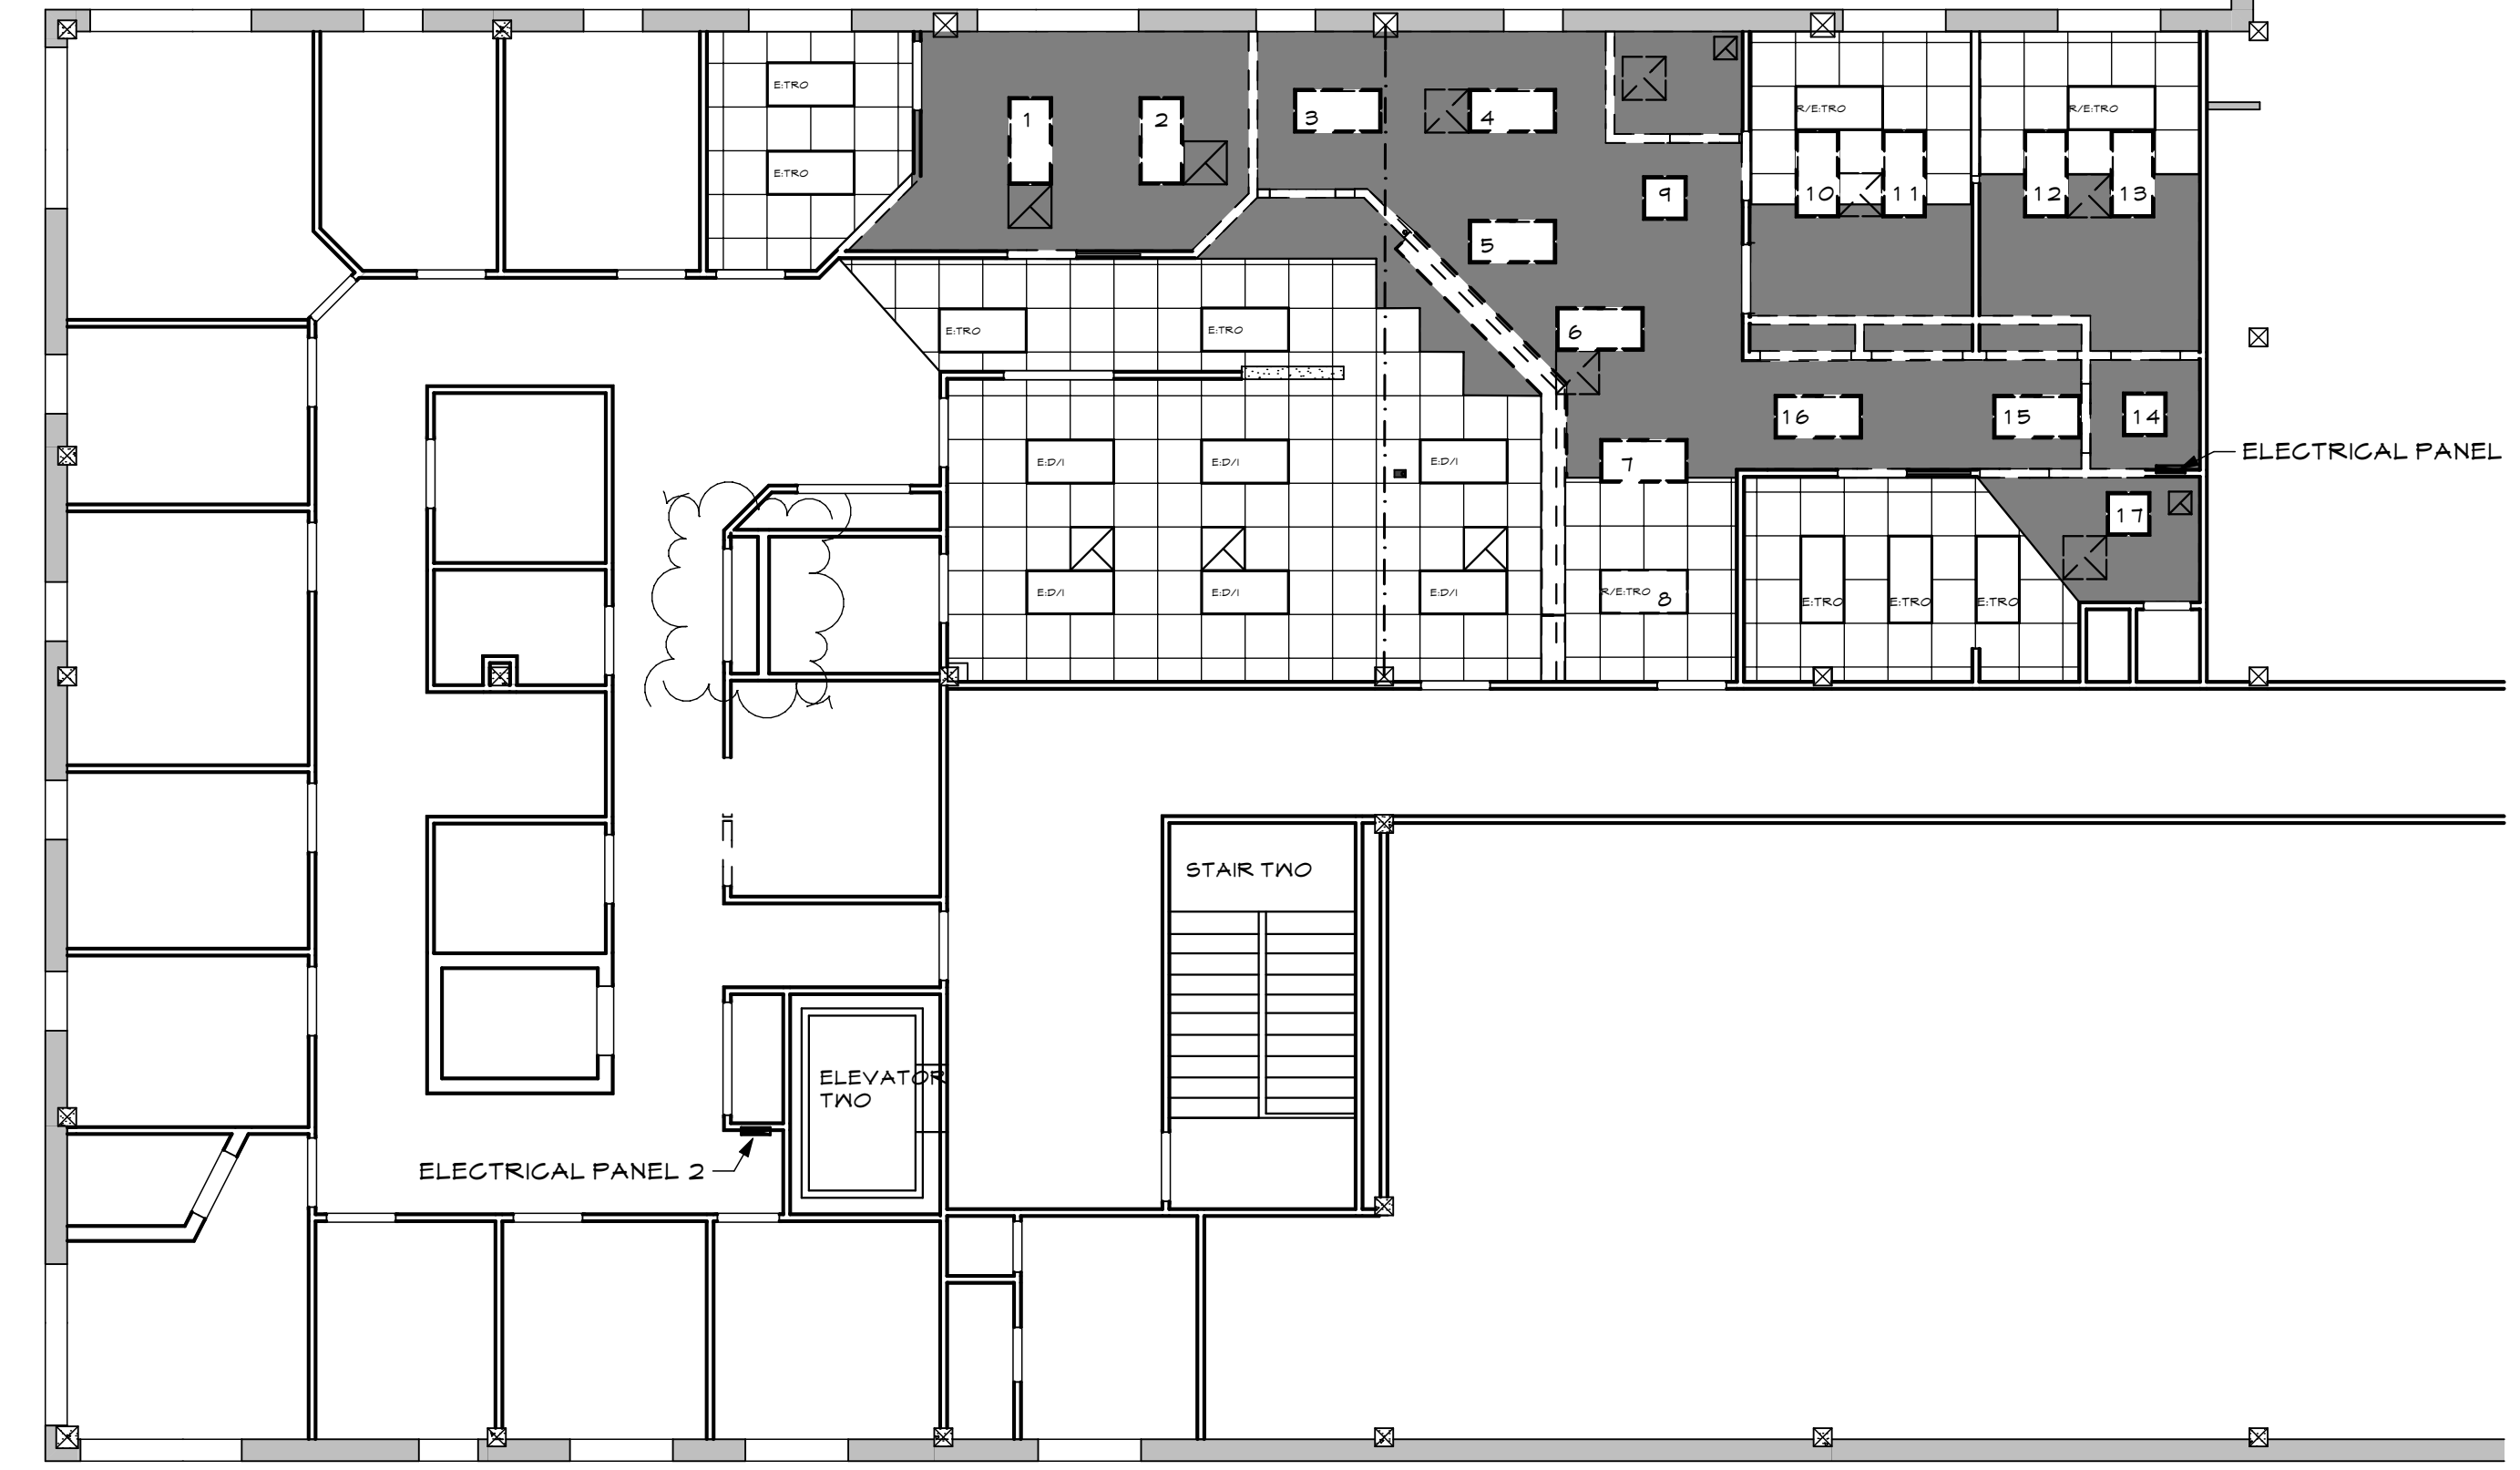

2 REFLECTED CEILING PLAN - DEMO
SCALE: 1/8" = 1'-0"

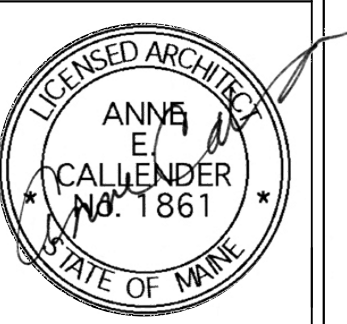

WHIPPLE — CALLENDER ARCHITECTS

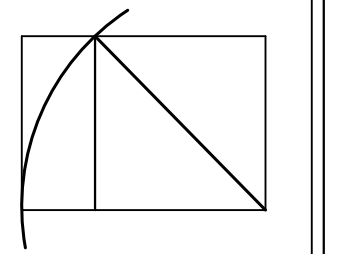

136 PLEASANT AVE.
 PORTLAND, ME 04103
 P 207.115.2616
 F 207.115.5631
 www.whipplecallender.com

DATE	DESCRIPTION
1-21-13	PERMIT SET
1-30-13	REVISIONS TO PLAN
1-27-14	REVISIONS TO PLAN UPDATE FOR PERMIT

DATE:	21 JAN 2013
CHECKED BY:	AEC
DRAWN BY:	AEC
JOB:	12-TFA
SHEET TITLE:	REFLECTED CEILING PLANS - NEW AND DEMO