



1 FIRST FLOOR PLAN
 A.5 SCALE: 1/4" = 1'-0"

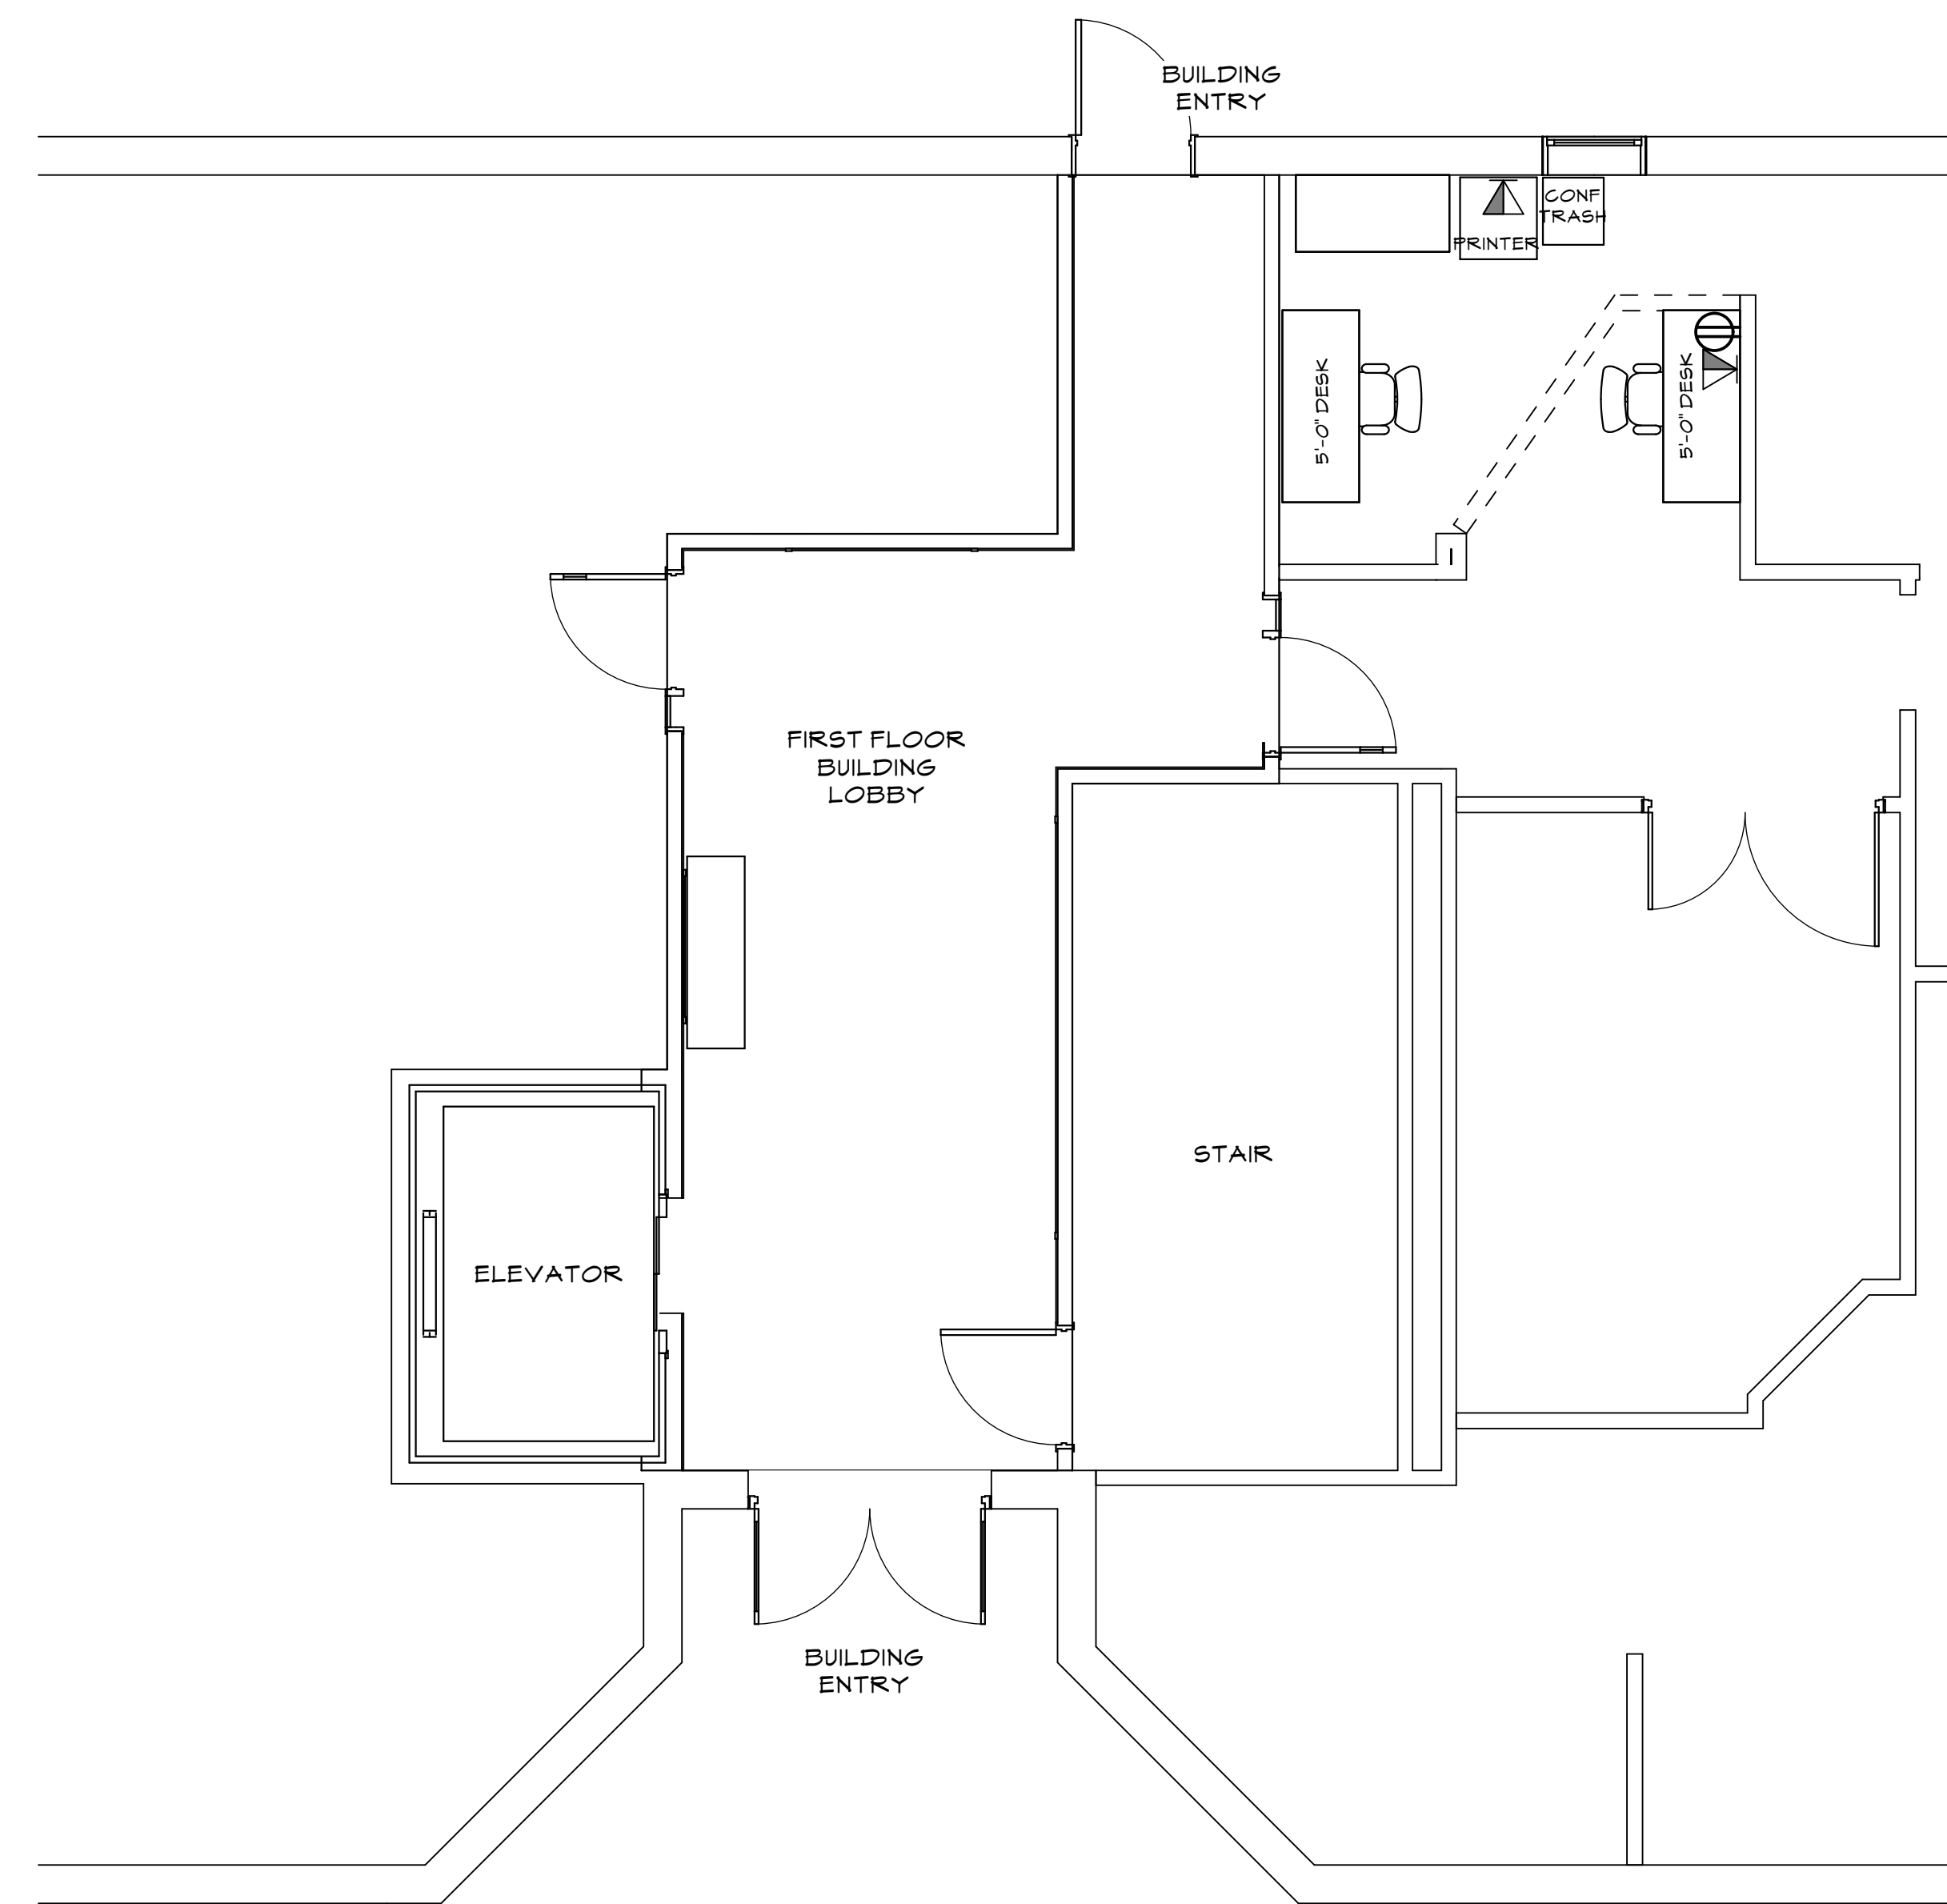


2 FIRST FLOOR ELECTRICAL PLAN
 A.5 SCALE: 1/4" = 1'-0"

MMP OTOLARYNGOLOGY
 1250 FOREST AVENUE
 PORTLAND, MAINE

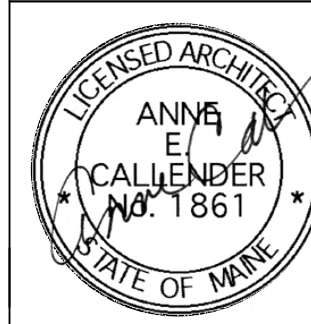

WHIPPLE - CALLENDER ARCHITECTS

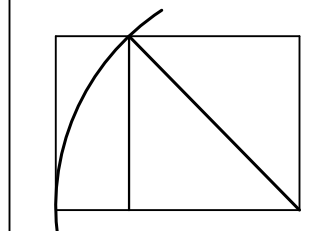

136 PLEASANT AVE.
 PORTLAND, ME 04103
 P 207.115.2616
 F 207.115.5631
 www.whipplecallender.com

DATE	DESCRIPTION
1-21-14	REVISIONS TO PLAN UPDATE FOR PERMIT

DATE: 21 JAN 2013
 CHECKED BY: AEC
 DRAWN BY: AEC
 JOB: 12-TFA
 SHEET TITLE: FIRST FLOOR OFFICE PLAN

A.5