

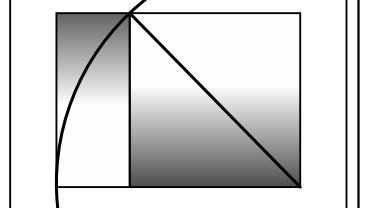


LIGHT FIXTURE SCHEDULE								
FIXTURE	SYMBOL	COUNT	TYPE	MODEL	LAMP	TRIM	FINISH/COLOR	NOTES
A		51	SURFACE MOUNTED					
B		60	2'X2' HUNG CEILING FIXTURE					
C		5	WALL MOUNTED ABOVE MIRROR					
D		4	SHOWER FIXTURE					

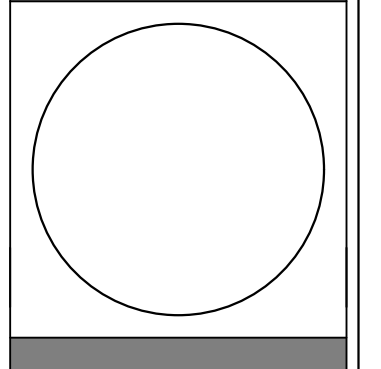

**1**  
**A1.5** **FIRST FLOOR REFLECTED CEILING PLAN**  
SCALE: 1/4" = 1'-0"

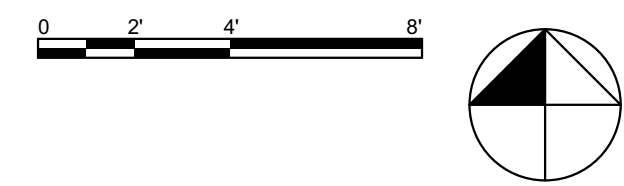

DATE	DESCRIPTION

DATE: 12/14/17  
CHECKED BY: JAD  
DRAWN BY: CJC  
JOB: 2017-BISHOP  
SHEET TITLE:

FIRST FLOOR REFLECTED CEILING PLAN

A1.5 FIRST FLOOR REFLECTED CEILING PLAN - Plotted on 12/19/17 at 10:38 AM by Joe Delaney. File Path: \Volumes\WCA Expansion Drive\ WCA Projects\2017 Projects\BIS Bishop st. - Pinetree Recovery\BIS ArchCAD Models\BIS Model v20 12\_04\_17.plt

THIS DRAWING IS AN INSTRUMENT OF SERVICE AND SHALL REMAIN THE PROPERTY OF WHIPPLE CALLENDER ARCHITECTS. IT SHALL NOT BE USED FOR ANY OTHER PURPOSE THAT FOR WHICH IT IS SPECIFICALLY FURNISHED.