




DATE	12/22/17
DESIGNED BY	JAD
DRAWN BY	CJC
PROJECT	2017 - BISHOP STREET
SHEET TITLE	EXISTING SITE PLAN

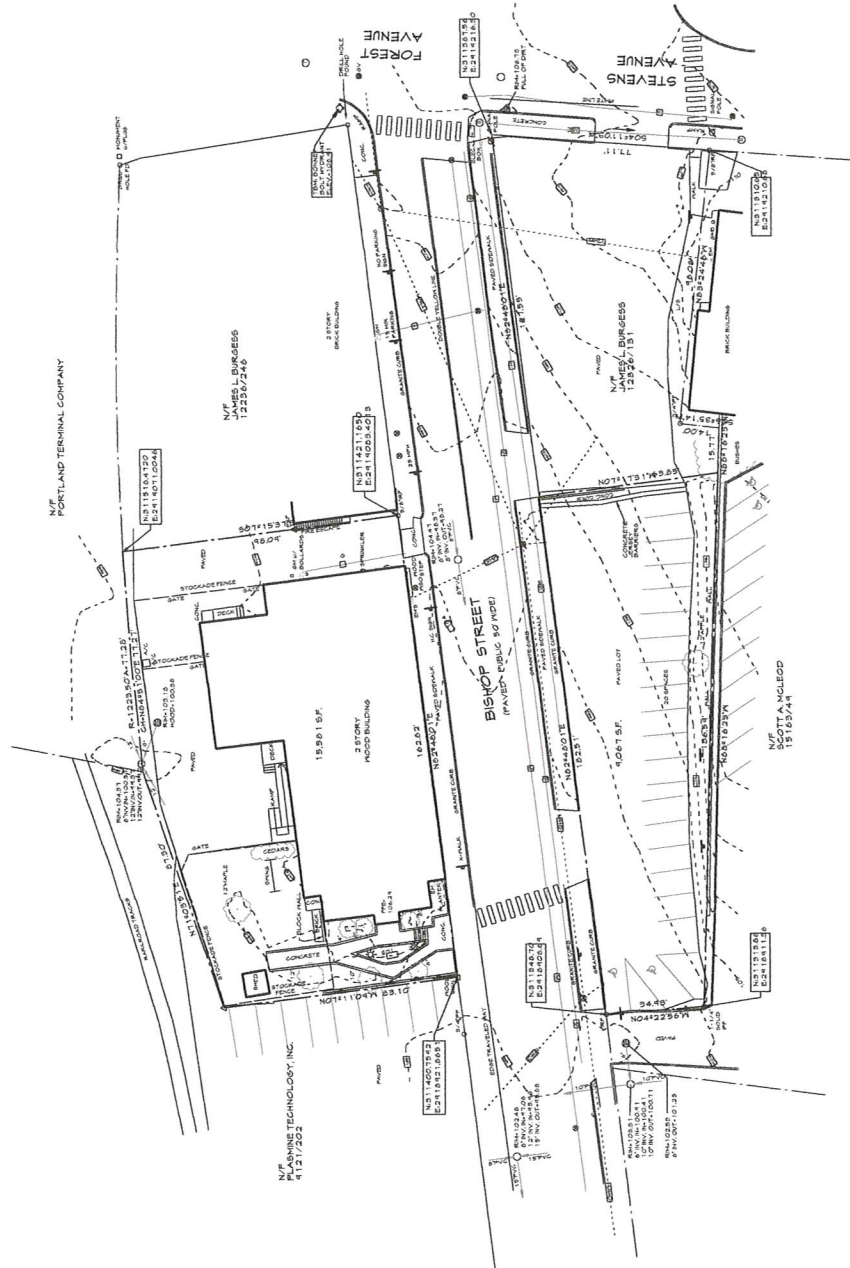

**LEGEND**

- RGN PIPE OR ROD FOUND
- ⊗ UTILITY POLE
- ⊕ ELECTRIC METER
- ⊙ SON
- ⊗ CATCH BASIN
- ⊕ WATER VALVE OR SHUTOFF
- ⊙ GAS VALVE
- ⊗ DEBRIS TREE
- ⊕ TREE
- ⊙ OVERHEAD PIPES
- ⊕ UNDERGROUND PIPES
- ⊗ PROPERTY LINE
- ⊕ 1"=100'-0" 1' CONTOUR

**GRAPHIC SCALE**  
0 10 20 40 80'



THIS DRAWING IS AN INSTRUMENT OF SERVICE AND SHALL REMAIN THE PROPERTY OF WHIPPLE CALENDER ARCHITECTS. IT SHALL NOT BE LOANED, REPRODUCED, COPIED, OR IN ANY MANNER USED FOR ANY OTHER PROJECT WITHOUT THE WRITTEN CONSENT OF WHIPPLE CALENDER ARCHITECTS.

# 17 BISHOP STREET

## Legend

-  17 Bishop St
-  McDonald's

